


KEYNOTES




KEYNOTE	DESCRIPTION	DET/SHT	COLOR / FINISH
01	CONCRETE PAVING	01/ L4.01	NATURAL GREY / MEDIUM BROOM
02	CONCRETE PAVING	01/ L4.01	NATURAL GREY / MEDIUM SANDBLAST FINISH
03	COLOR CONCRETE PAVING	01/ L4.01	INTEGRAL COLOR- SOLOMON 'CANVAS' MEDIUM BROOM FINISH
04	COLOR CONCRETE PAVING	01/ L4.01	INTEGRAL COLOR- SOLOMON 'CANVAS' MEDIUM SANDBLAST FINISH
05	CONCRETE SEATWALL AT FOUNTAIN	13/ L4.01	NATURAL GREY W/ ARDEX FINISH LIGHT SANDBLAST
06	AQUATICS UTILITY WALL	22/ L4.01	NATURAL GREY W/ ARDEX FINISH LIGHT SANDBLAST
07	CONCRETE SEATWALL TYPE 3	16/ L4.01	NATURAL GREY W/ ARDEX FINISH LIGHT SANDBLAST
08	RECYCLED PLASTIC HEADERBOARD	17/ L4.02	BROWN
09	VEHICULAR BOLLARD AND CHAIN	19/ L4.02	-/-
10	FREESTANDING WALL	14/ L4.01	COLOR TO MATCH BLDG 10N ARCH/ SMOOTH PLASTER FINISH
11	CONCRETE RETAINING WALL TYPE 4	14/ L4.01	COLOR TO MATCH BLDG 10N ARCH/ SMOOTH PLASTER FINISH
12	GUARDRAIL/ HANDRAIL @ RETAINING WALL	14/ L4.03	GALVANIZED
13	CONCRETE RETAINING WALL W/ T.S. FENCE	09/ L4.03	NATURAL GREY W/ ARDEX FINISH LIGHT SANDBLAST
14	CONCRETE SEATWALL TYPE 4	09/ L4.01	NATURAL GREY W/ ARDEX FINISH LIGHT SANDBLAST
15	CONCRETE SEATWALL TYPE 2	14/ L4.01	NATURAL GREY W/ ARDEX FINISH LIGHT SANDBLAST
16	CONCRETE TRIANGULAR SEAT	11/ L4.01	NATURAL GREY W/ ARDEX FINISH LIGHT SANDBLAST
17	CONCRETE STAIRS	01/ L4.02	NATURAL GREY MEDIUM BROOM
18	HANDRAIL AT STAIRS	01/ L4.03	GALVANIZED
19	CHEEK WALL AT STAIRS	03/ L4.02	NATURAL GREY W/ ARDEX FINISH LIGHT SANDBLAST
20	CONCRETE MOW BAND	06/ L4.01	NATURAL GREY / MEDIUM BROOM
21	CONCRETE RETAINING WALL TYPE 8	20/ L4.01	NATURAL GREY W/ ARDEX FINISH LIGHT SANDBLAST
22	SPECTATOR SEATING	20/ L4.03	NATURAL GREY W/ ARDEX FINISH LIGHT SANDBLAST
23	4" CHAINLINK FENCE	15/ L4.04	VINYL COATED BLACK
24	DECOMPOSED GRANITE PAVING	06/ L4.01	WITH STABILIZER
25	GRASSMOW PAVERS	10/ L4.03	-/-
26	GRAVEL MULCH	17/ L4.02	1 1/2" TO 2 1/2" GRAY COLOR.
27	FLAGPOLE	01/ L4.02	ALUMINUM FINISH, GOLD BALL INTERNAL HALLYARD
28	TEACHING STATION BOARD	24/ L4.01	PER DETAIL
29	PILASTER WITH CAP AND FINIAL	09/ L4.02	COLOR TO MATCH BLDG 10N ARCH/ SMOOTH PLASTER FINISH
30	TUBE STEEL FENCE	01/ L4.04	BLACK POWDER COAT PER MANUFACTURER
31	CONCRETE BAND	08/ L4.01	NATURAL GREY / MEDIUM BROOM
32	DOUBLE T.S. PED. GATE W/ PANIC HARDWARE	04/ L4.04	BLACK POWDER COAT PER MANUFACTURER
33	PILASTER WITH CAP	13/ L4.02	COLOR TO MATCH BLDG 10N ARCH/ SMOOTH PLASTER FINISH
34	PAVERS	23/ L4.01	CORUSITER SERIES 1104 PER MANUFACTURER
35	GUARDRAIL & HANDRAIL @ BLDG 1 STAIRS	18/ L4.03	GALVANIZED
36	FIRE DEPT. KNOX BOX	-/-	MODEL 3200, HINGED DOOR
37	'BULLDOG ATHLETICS' SIGNAGE	23/ L4.03	COLOR TO MATCH BLDG 10N ARCH/ SMOOTH PLASTER FINISH
38	CHEEK WALL AT SLOPED WALK	13/ L4.03	NATURAL GREY W/ ARDEX FINISH LIGHT SANDBLAST
39	PEDESTRIAN DIRECTIONAL TRAILBLAZER SIGN	04/ G1.01	-/-
40	PRIMARY VEHICULAR DIRECTIONAL SIGN	05/ G1.01	-/-
41	CAMPUS MAP DIRECTORY TYPE 1	02/ G1.01	-/-
42	ACCESSIBLE ROUTE DIRECTIONAL SIGN	16/ L4.04	-/-
43	PARKING LOT IDENTIFICATION SIGN	03/ G1.01	-/-
44	DRINKING FOUNTAIN	18/ L4.04	ALUMINUM PER MANUFACTURER
45	BIKE RACK	23/ L4.04	GALVANIZED
46	AQUATICS ENTRY GATE	09/ L4.04	BLACK POWDER COAT PER MANUFACTURER
47	HANDRAIL AT SPECTATOR SEATING	18/ L4.03	GALVANIZED

REFERENCE KEYNOTES

KEYNOTE	DESCRIPTION	COMMENTS
A	A.C. PAVING	PER CIVIL PLANS
B	CONCRETE CURB	PER CIVIL PLANS
C	PARKING LOT STRIPING	PER CIVIL PLANS
D	PAVEMENT MARKINGS	PER CIVIL PLANS
E	CONCRETE WHEEL STOP - 4' W	PER CIVIL PLANS
F	CONCRETE CURB RAMP	PER CIVIL PLANS
G	BOLLARD	PER CIVIL PLANS
H	ACCESSIBLE PARKING PAVEMENT MARKING	PER CIVIL PLANS
J	ACCESSIBLE PARKING STALL SIGNAGE	PER CIVIL PLANS
K	ACCESSIBLE DROP OFF ZONE	PER CIVIL PLANS
L	TRUNCATED DOMES	PER CIVIL PLANS
M	ACCESSIBILITY TOW AWAY SIGN	PER CIVIL PLANS
N	POOL LIFT	PER CIVIL PLANS
P	FOUNTAIN 1	PER FOUNTAIN PLANS
Q	FOUNTAIN 2	PER FOUNTAIN PLANS
R	FOUNTAIN 3	PER FOUNTAIN PLANS
S	EXISTING PLAQUE	PROTECT IN PLACE
T	SURGE CHAMBER	PER AQUATICS PLANS
U	6" RAISED CONCRETE PLATFORM	PER CIVIL PLANS
V	PLANTER POT	BY OWNER
W	SLOT DRAIN	PER CIVIL PLANS
X	FIRE HYDRANT	PER CIVIL PLANS
Y	EXISTING MEDIAN	PROTECT IN PLACE
Z	EXISTING A.C. PAVING	PROTECT IN PLACE
AA	EXISTING COLONADE	PROTECT IN PLACE
BB	EXISTING STAIRS	PROTECT IN PLACE
CC	EXISTING CONCRETE PAVING	PROTECT IN PLACE
DD	BUS SHELTER	BY OWNER
EE	RELOCATED STOP SIGN	PER CIVIL PLANS
FF	RELOCATED PARKING PERMIT MACHINE	PER CIVIL PLANS
GG	TRAFFIC SIGN	SEE CIVIL PLANS
HH	RETAINING WALL AT LOADING DOCK	SEE BLDG 10N DWGS
JJ	WALKOFF MATS	SEE BLDG 10N DWGS
KK	LIGHTING FIXTURE	PER ELECTRICAL PLANS
LL	CONCRETE SURROUND AT AQUATICS UTILITIES	PER AQUATICS PLANS

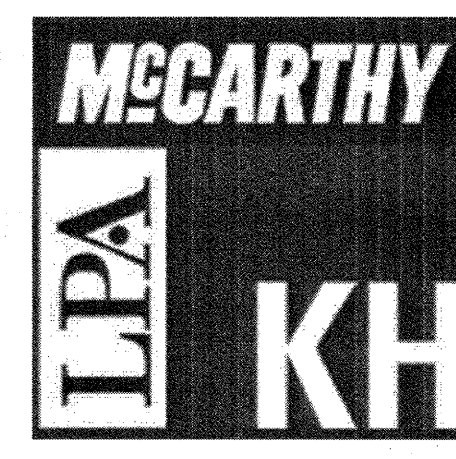

McCarthy Building Companies, Inc.
343 Sansome Street, 14th Floor
San Francisco, California 94104
P 415 364-1339
F 415 397-5999

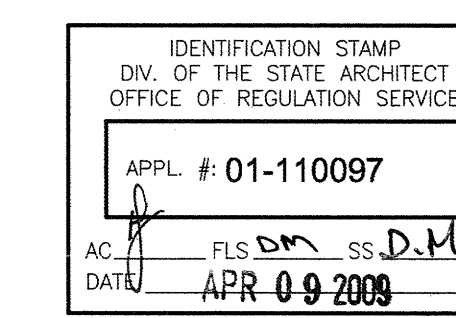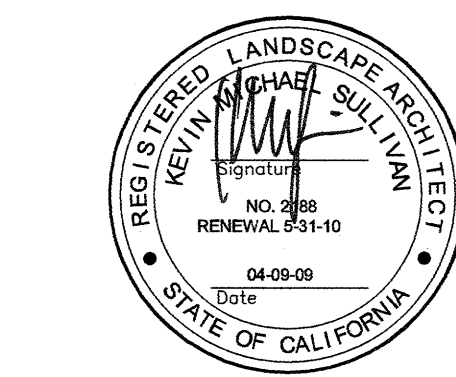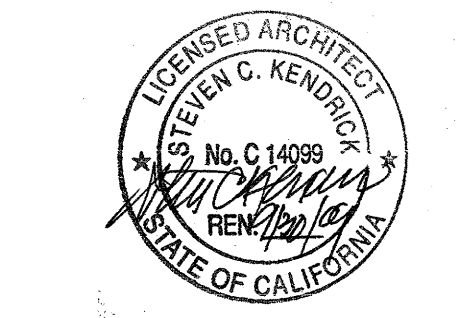

IDENTIFICATION STAMP
DIV. OF THE STATE ARCHITECT
OFFICE OF REGULATION SERVICE
APPL. # 01-110097
AC. # 111111
FLS. # 111111
SS. # 111111
DATE APR 09 2009
FILE NUMBER:
This and all other project documents are the property of McCarthy Building Companies, Inc. and shall remain the property of McCarthy Building Companies, Inc. until the project is completed. No part of this project may be reproduced or transmitted in any form or by any means, electronic, mechanical, photocopying, recording, or by any information storage and retrieval system, without the prior written permission of McCarthy Building Companies, Inc. The user of this project documents shall be deemed to have accepted the terms and conditions of this license. McCarthy Building Companies, Inc. and its affiliates shall not be liable for any damages or losses, including consequential damages, arising from the use of this project documents. McCarthy Building Companies, Inc. and its affiliates shall not be responsible for any discrepancies between project documents and the existing conditions.

© Copyright 2008

College of San Mateo
Site Package
San Mateo, CA
Developed for
San Mateo County Community College District




Date	Revision Description
19 SEPT 2008	DSA SUBMITTAL
09 APRIL 2009	DSA FINAL

Date	Revision Description
19 SEPT 2008	DSA SUBMITTAL
09 APRIL 2009	DSA FINAL

Job No.	Date
2708230	09 APRIL 2009

Drawn by AG, RF
Checked by SM
Scale AS SHOWN

LAYOUT AND MATERIALS ENLARGEMENTS
L2.01

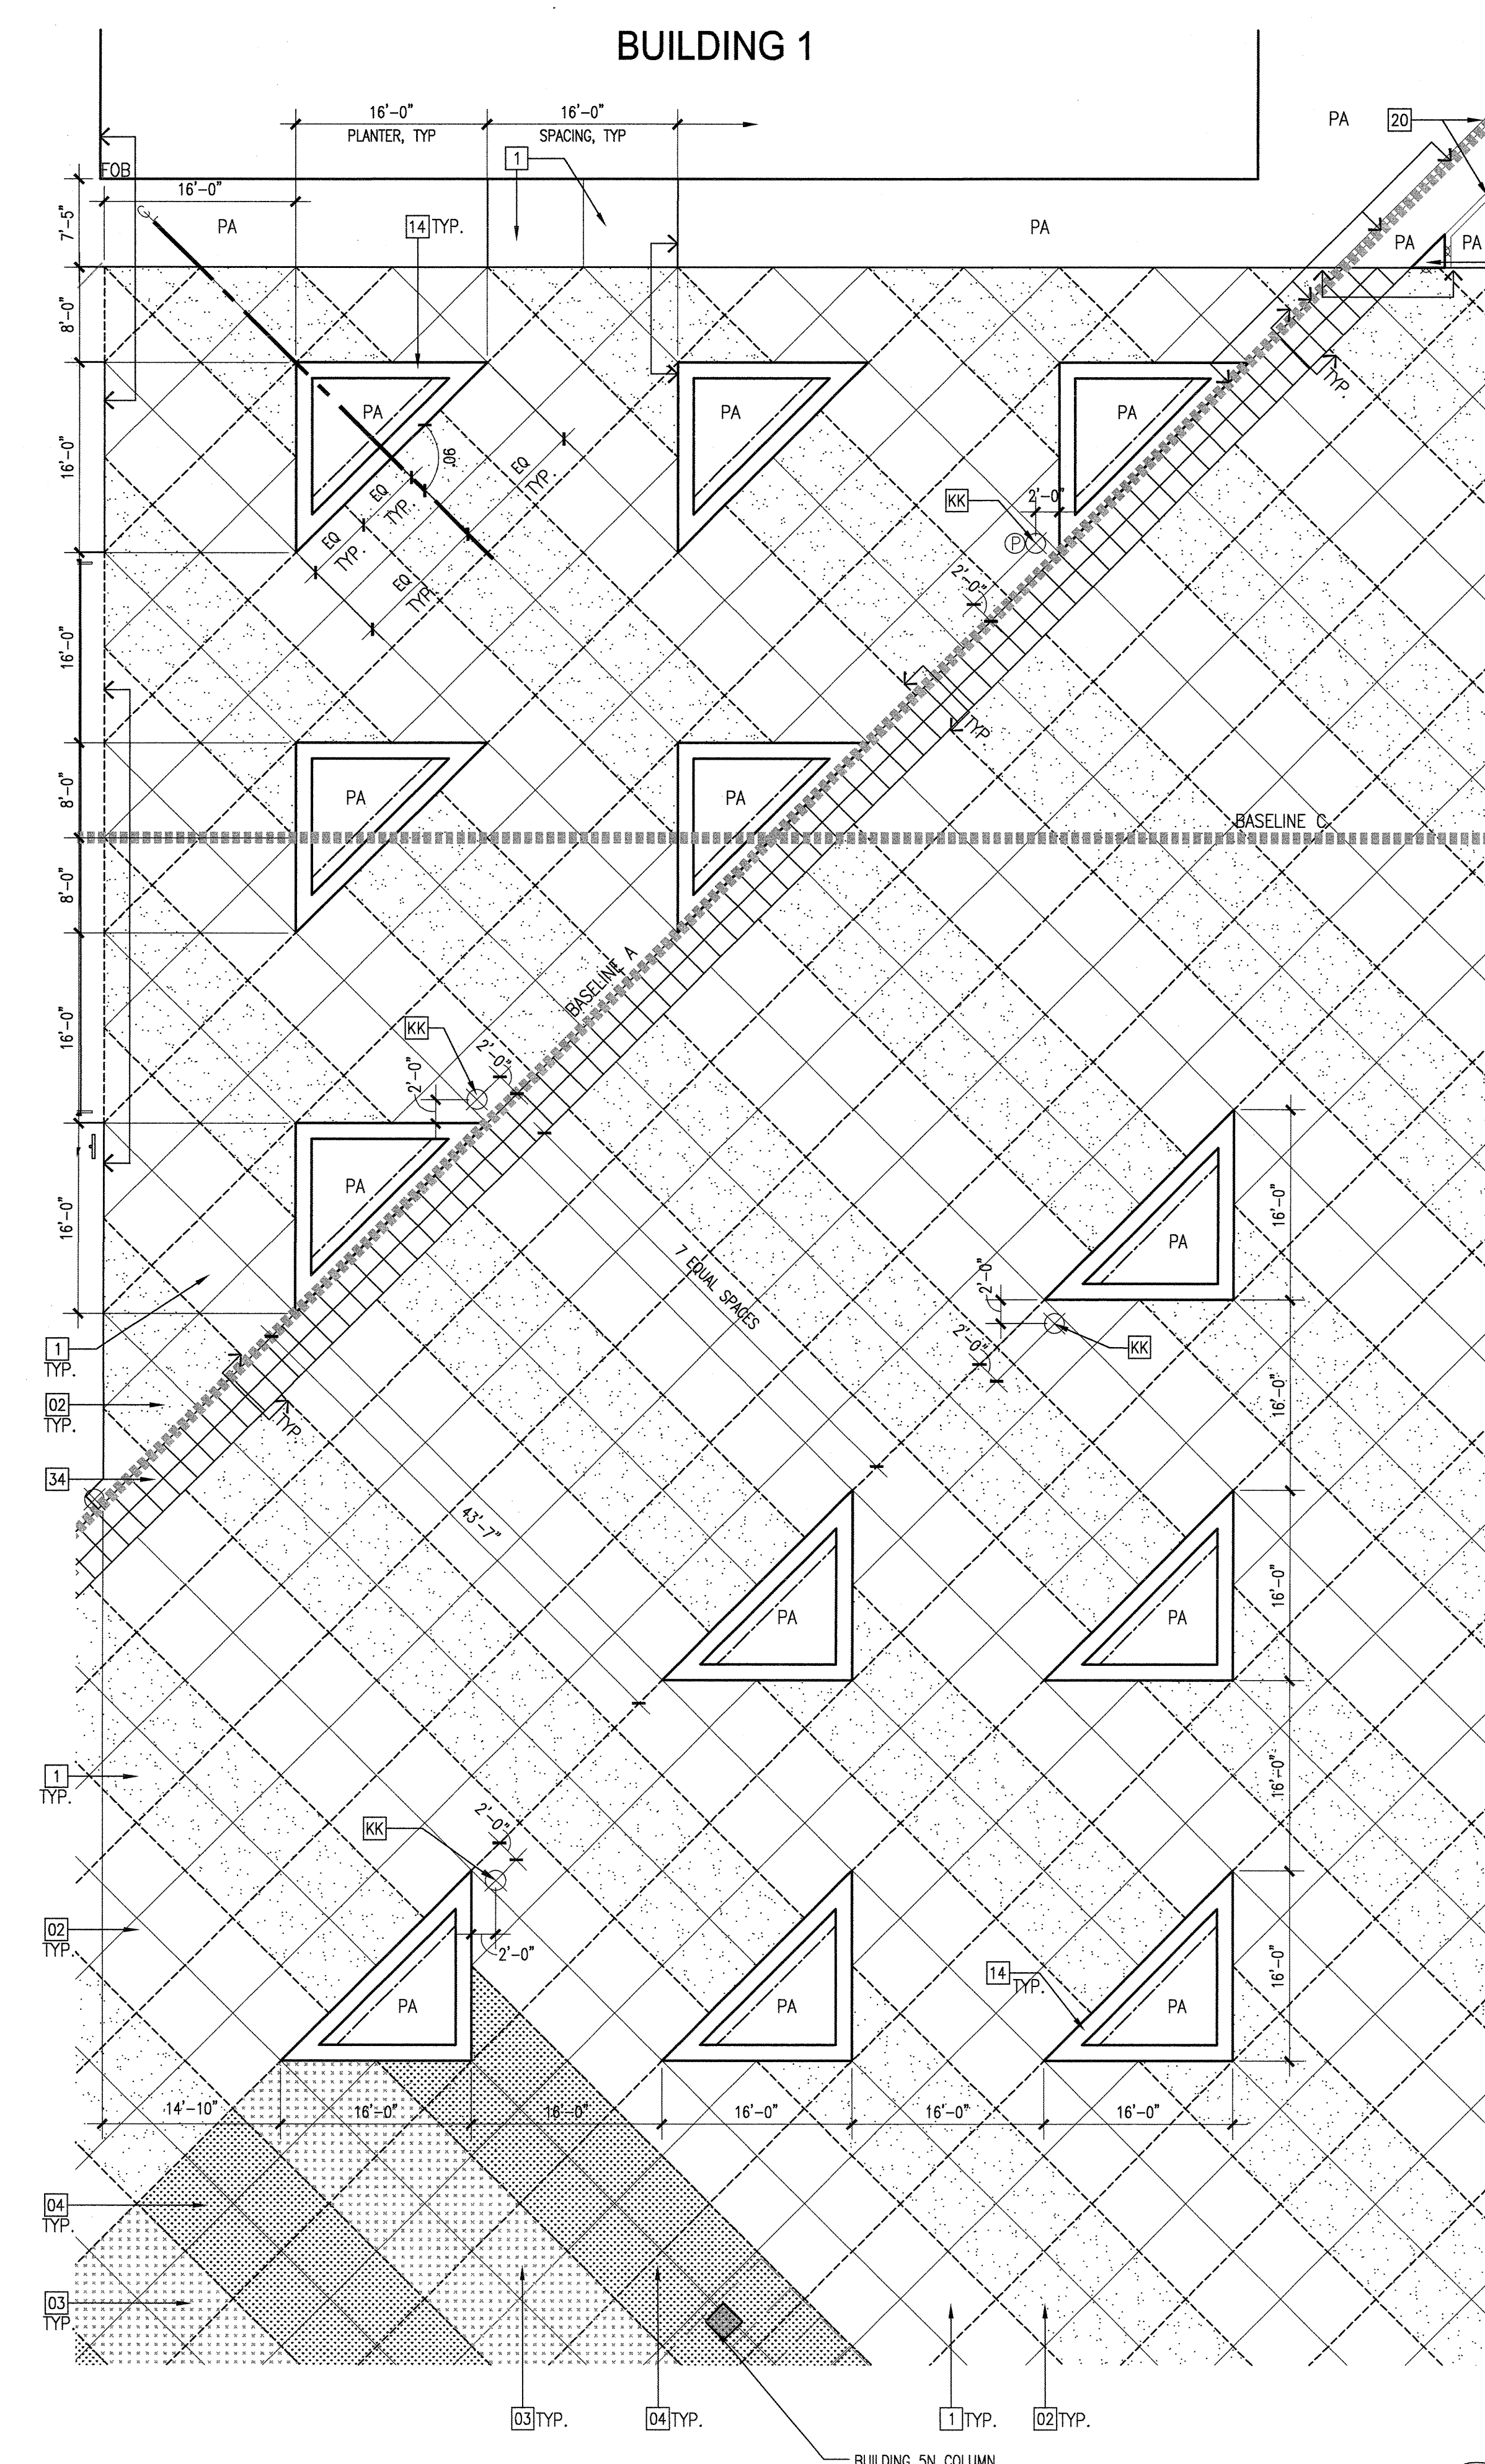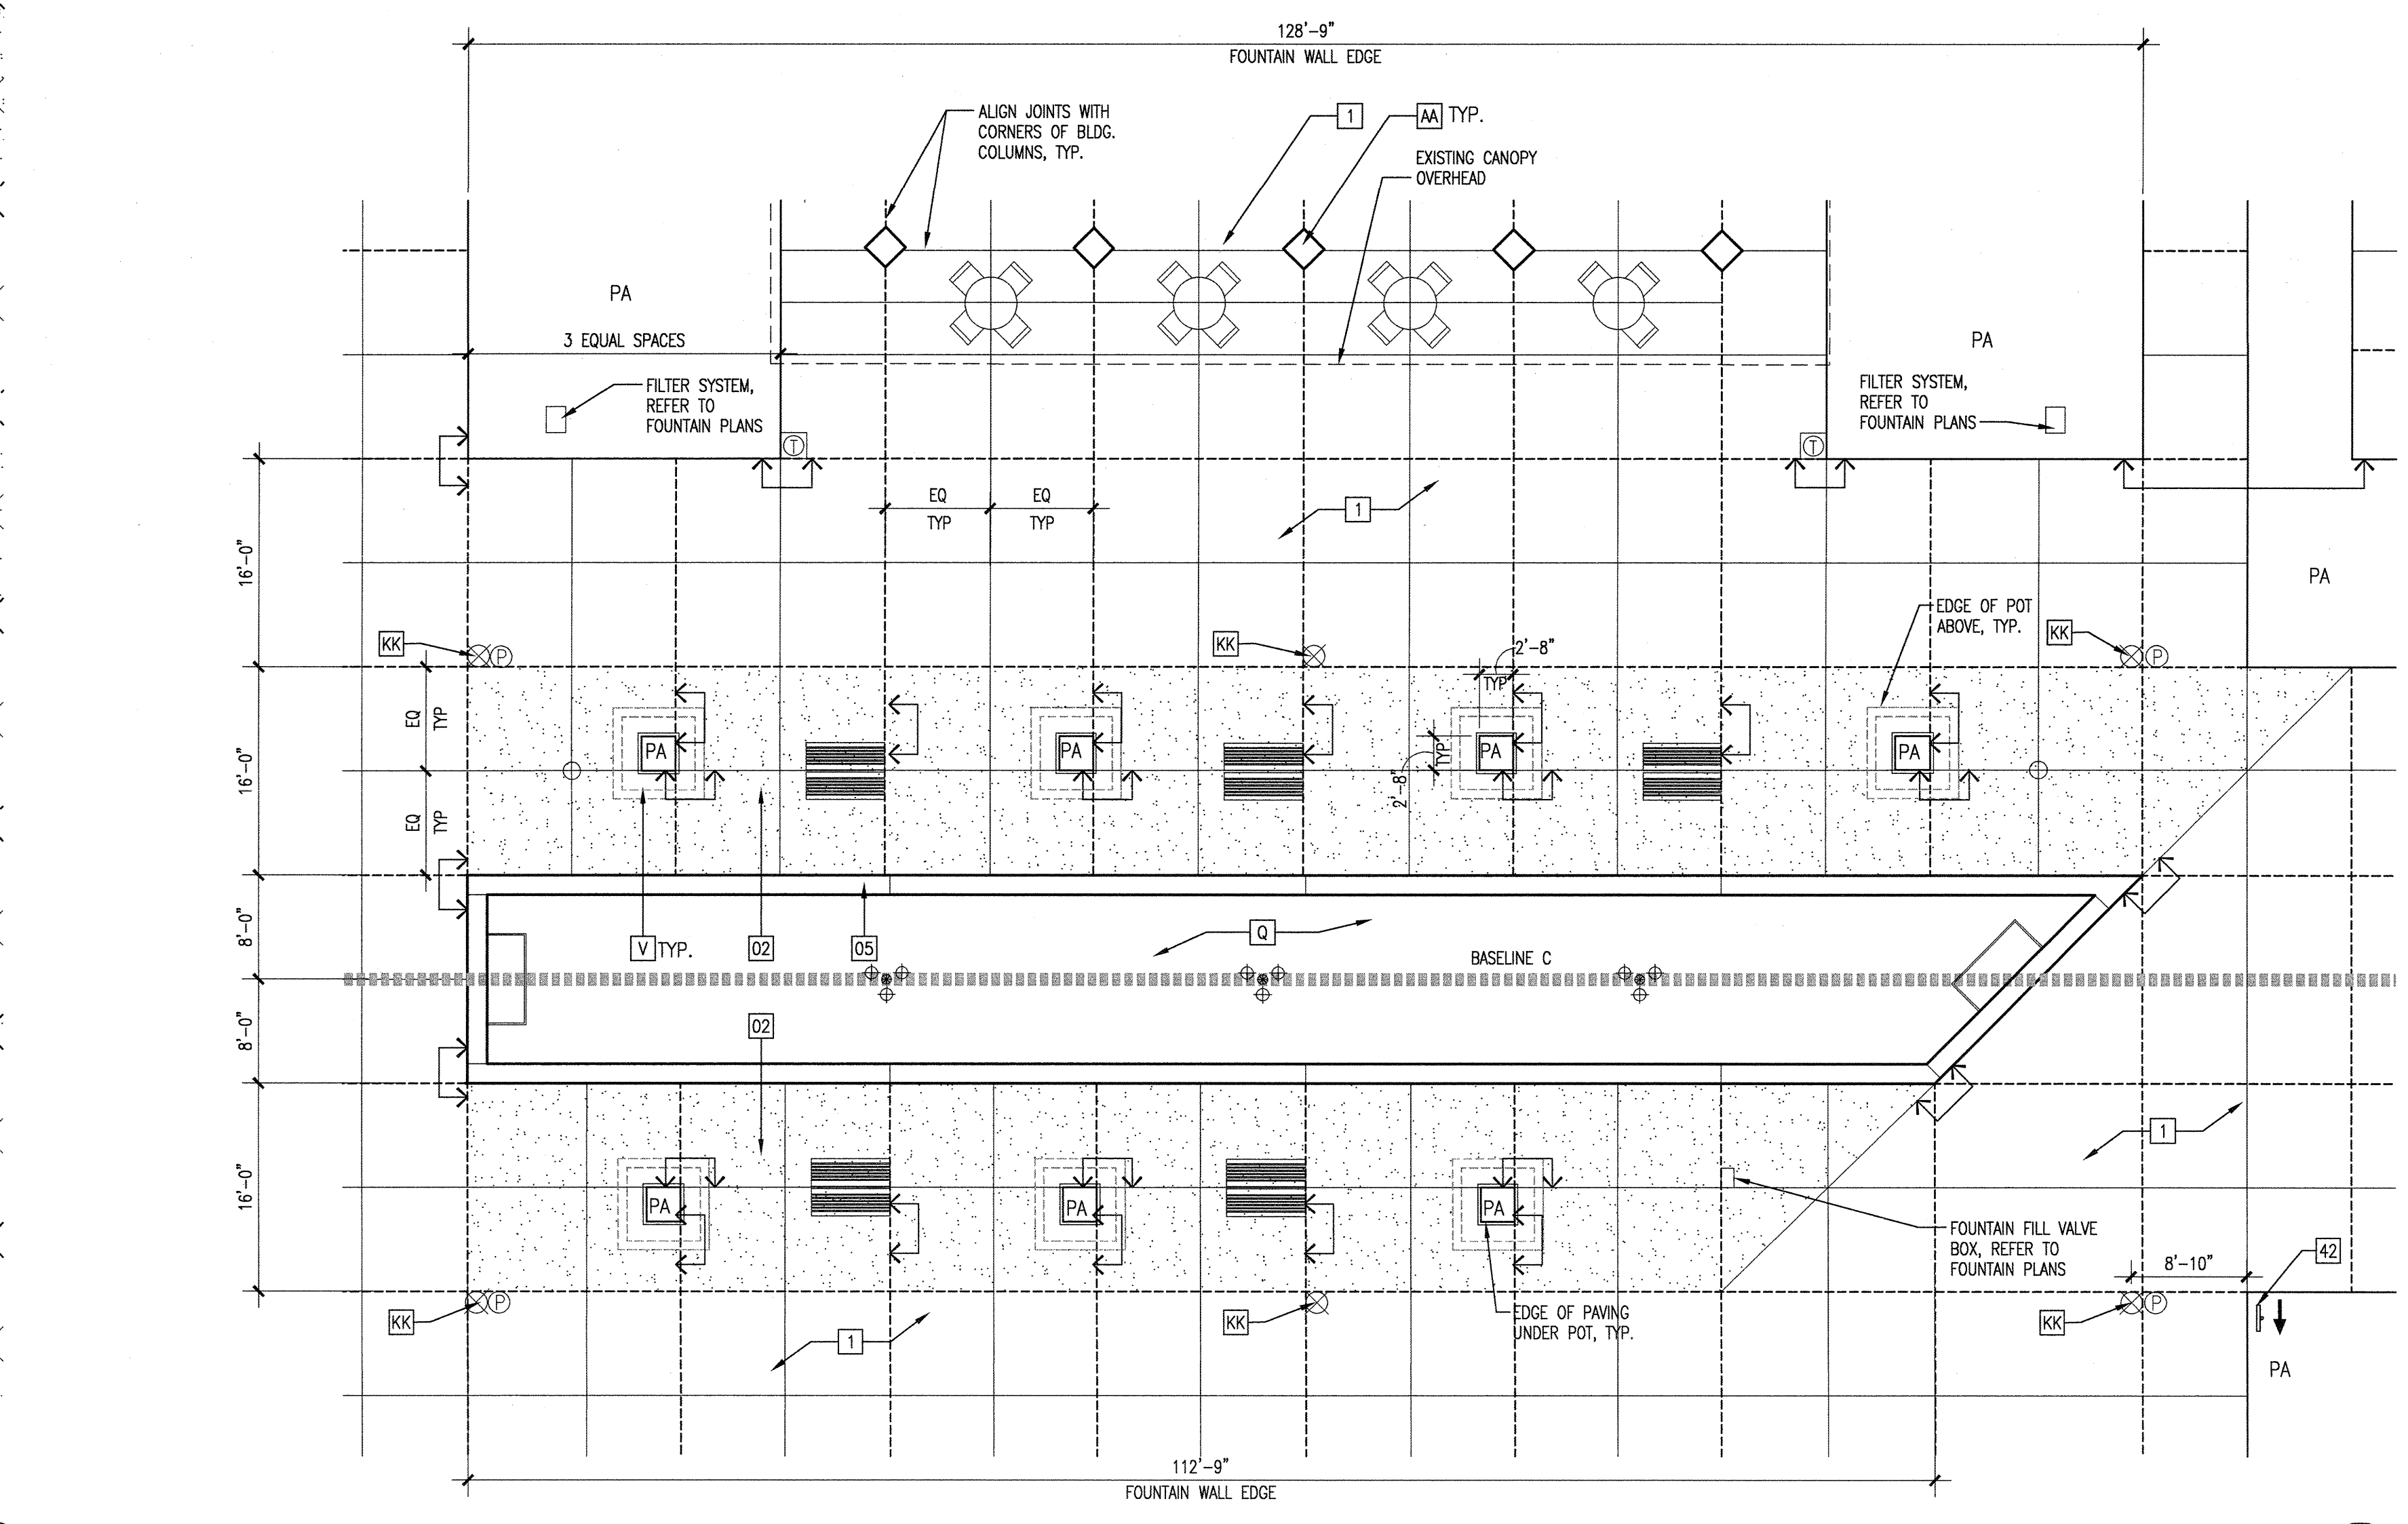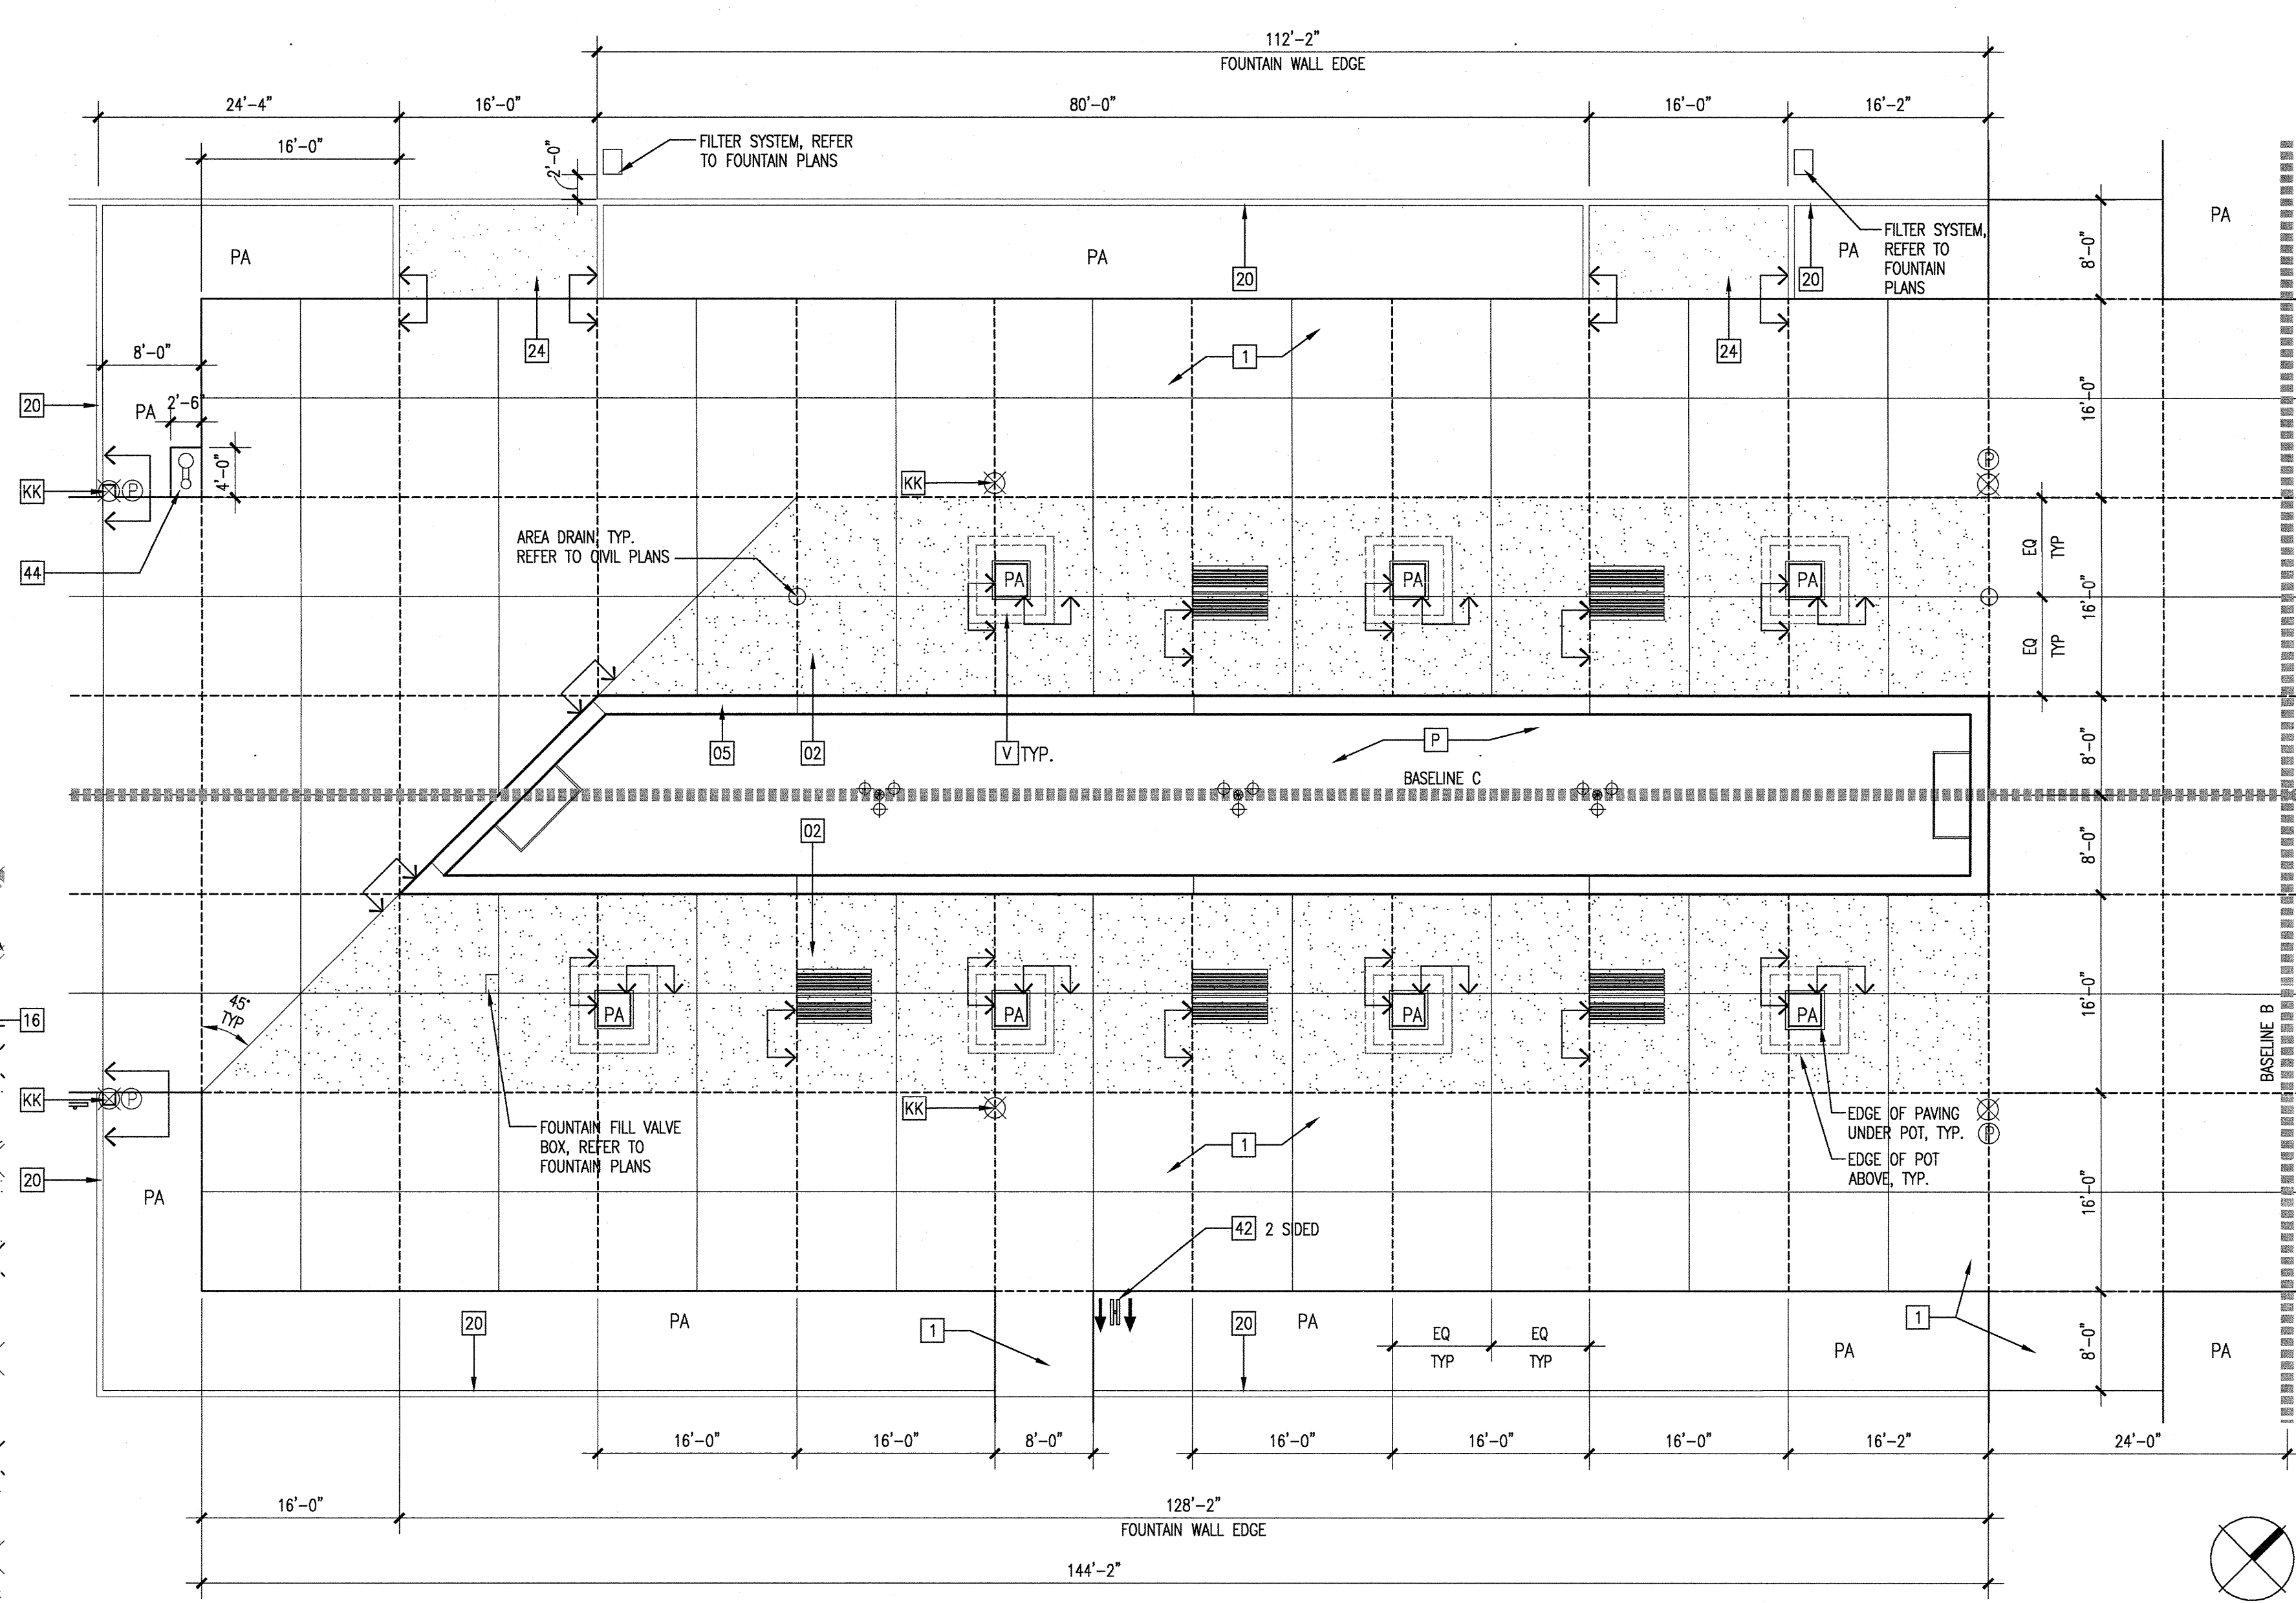

DONOR PLAZA ENLARGEMENT PLAN 1' = 10'-0" 03

FOUNTAIN 2 ENLARGEMENT PLAN 1' = 10'-0" 02

DONOR PLAZA ENLARGEMENT PLAN 1' = 10'-0" 03