



IDENTIFICATION STAMP
DIVISION OF THE STATE ARCHITECT
APPLICATION NUMBER OF XXXXX
SCALE AS NOTED


DSA SUBMITTAL

COLLEGE OF SAN MATEO
BUILDING 15
MODERNIZATION
SMCCCD
3401 CSN Drive
San Mateo, CA 94402
College of San Mateo
1700 W. Hillside Blvd.
San Mateo, CA 94402

SHEET TITLE
BUILDING 15 PLUMBING FLOOR PLAN


NO.	DATE	DESCRIPTION

DATE	MARCH 9, 2009
DRAWN	RS
CHECKED	DG
SCALE	AS NOTED
NAT. JOB NO.	2901
SHEET NUMBER	P2.11

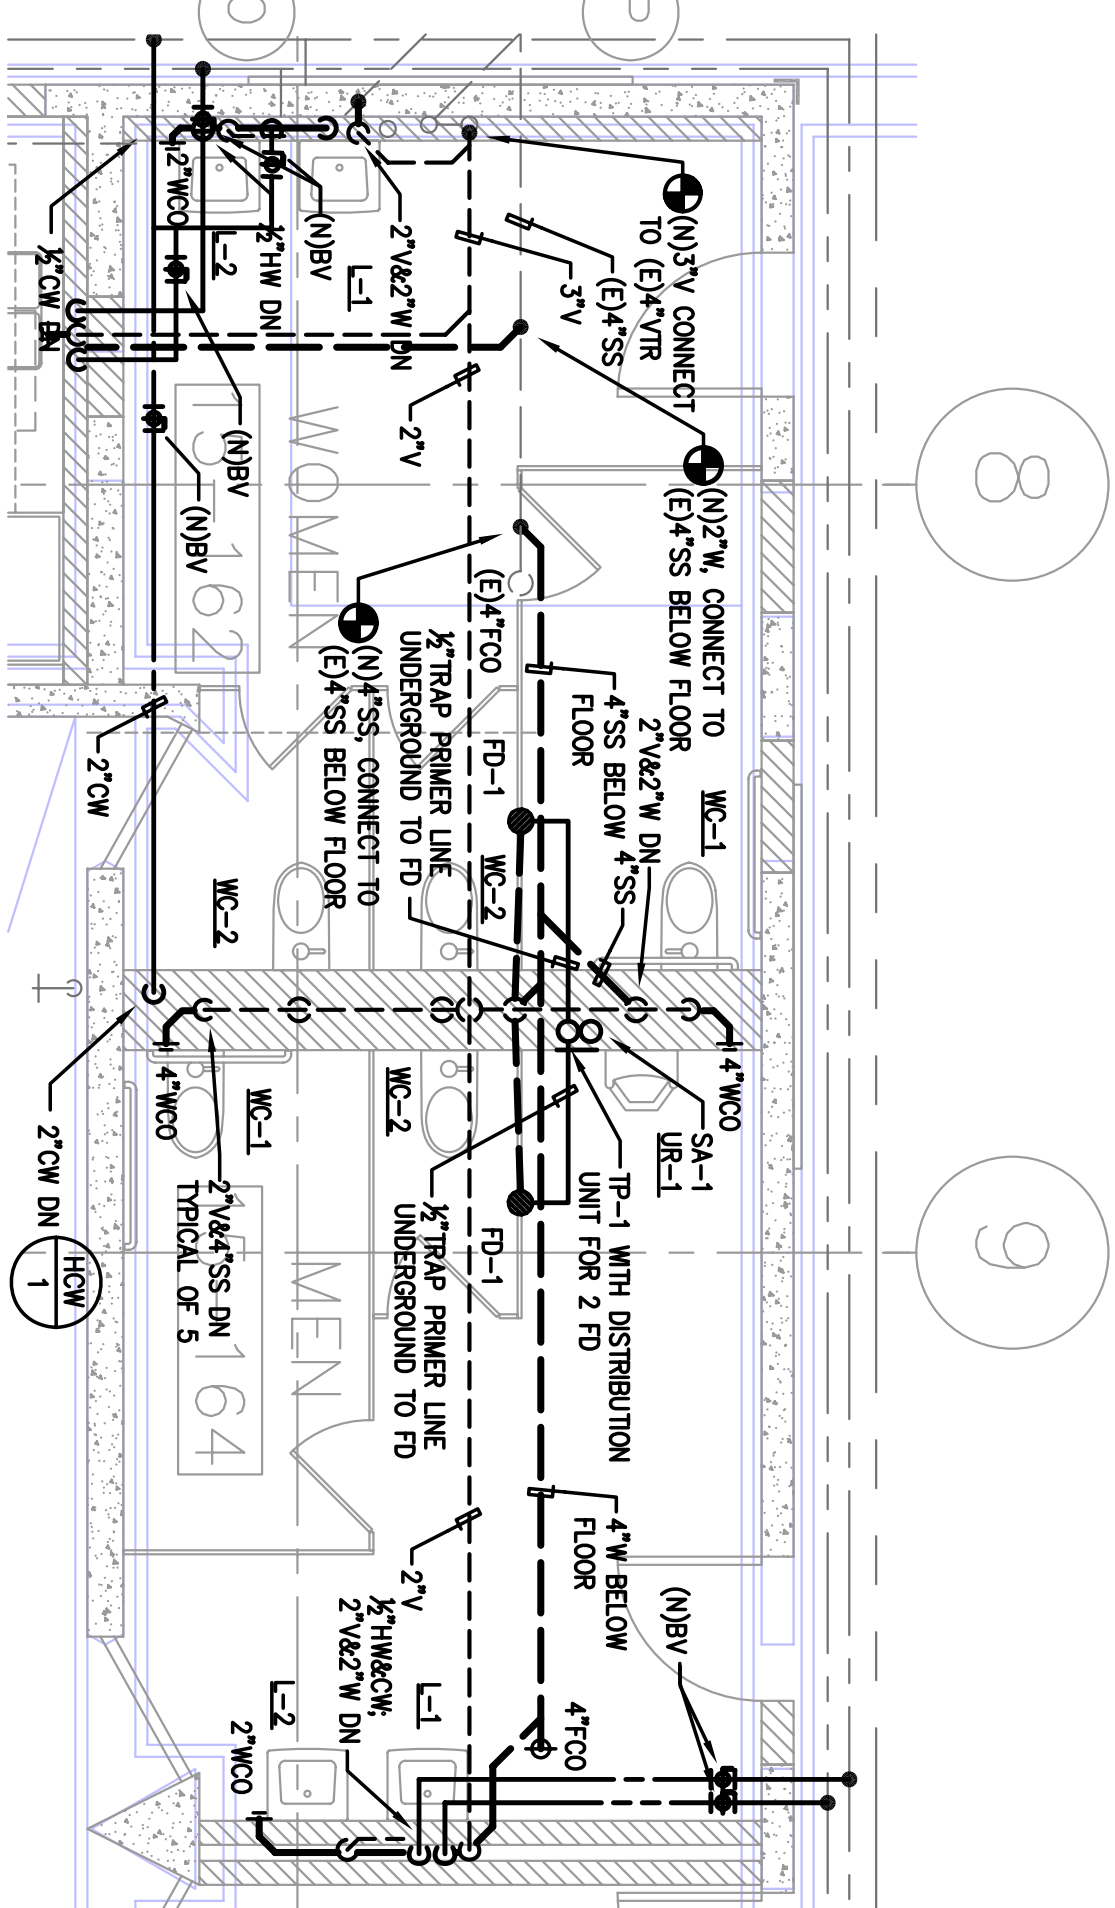


2 RESTROOM PLUMBING PLAN

1/4"=1'-0"

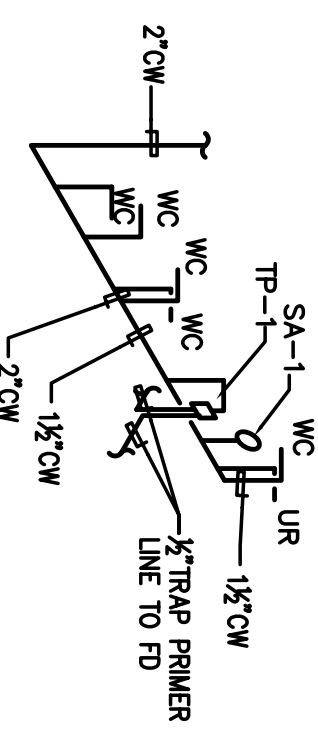

CW COLD WATER SCHEMATIC
1 NOT TO SCALE

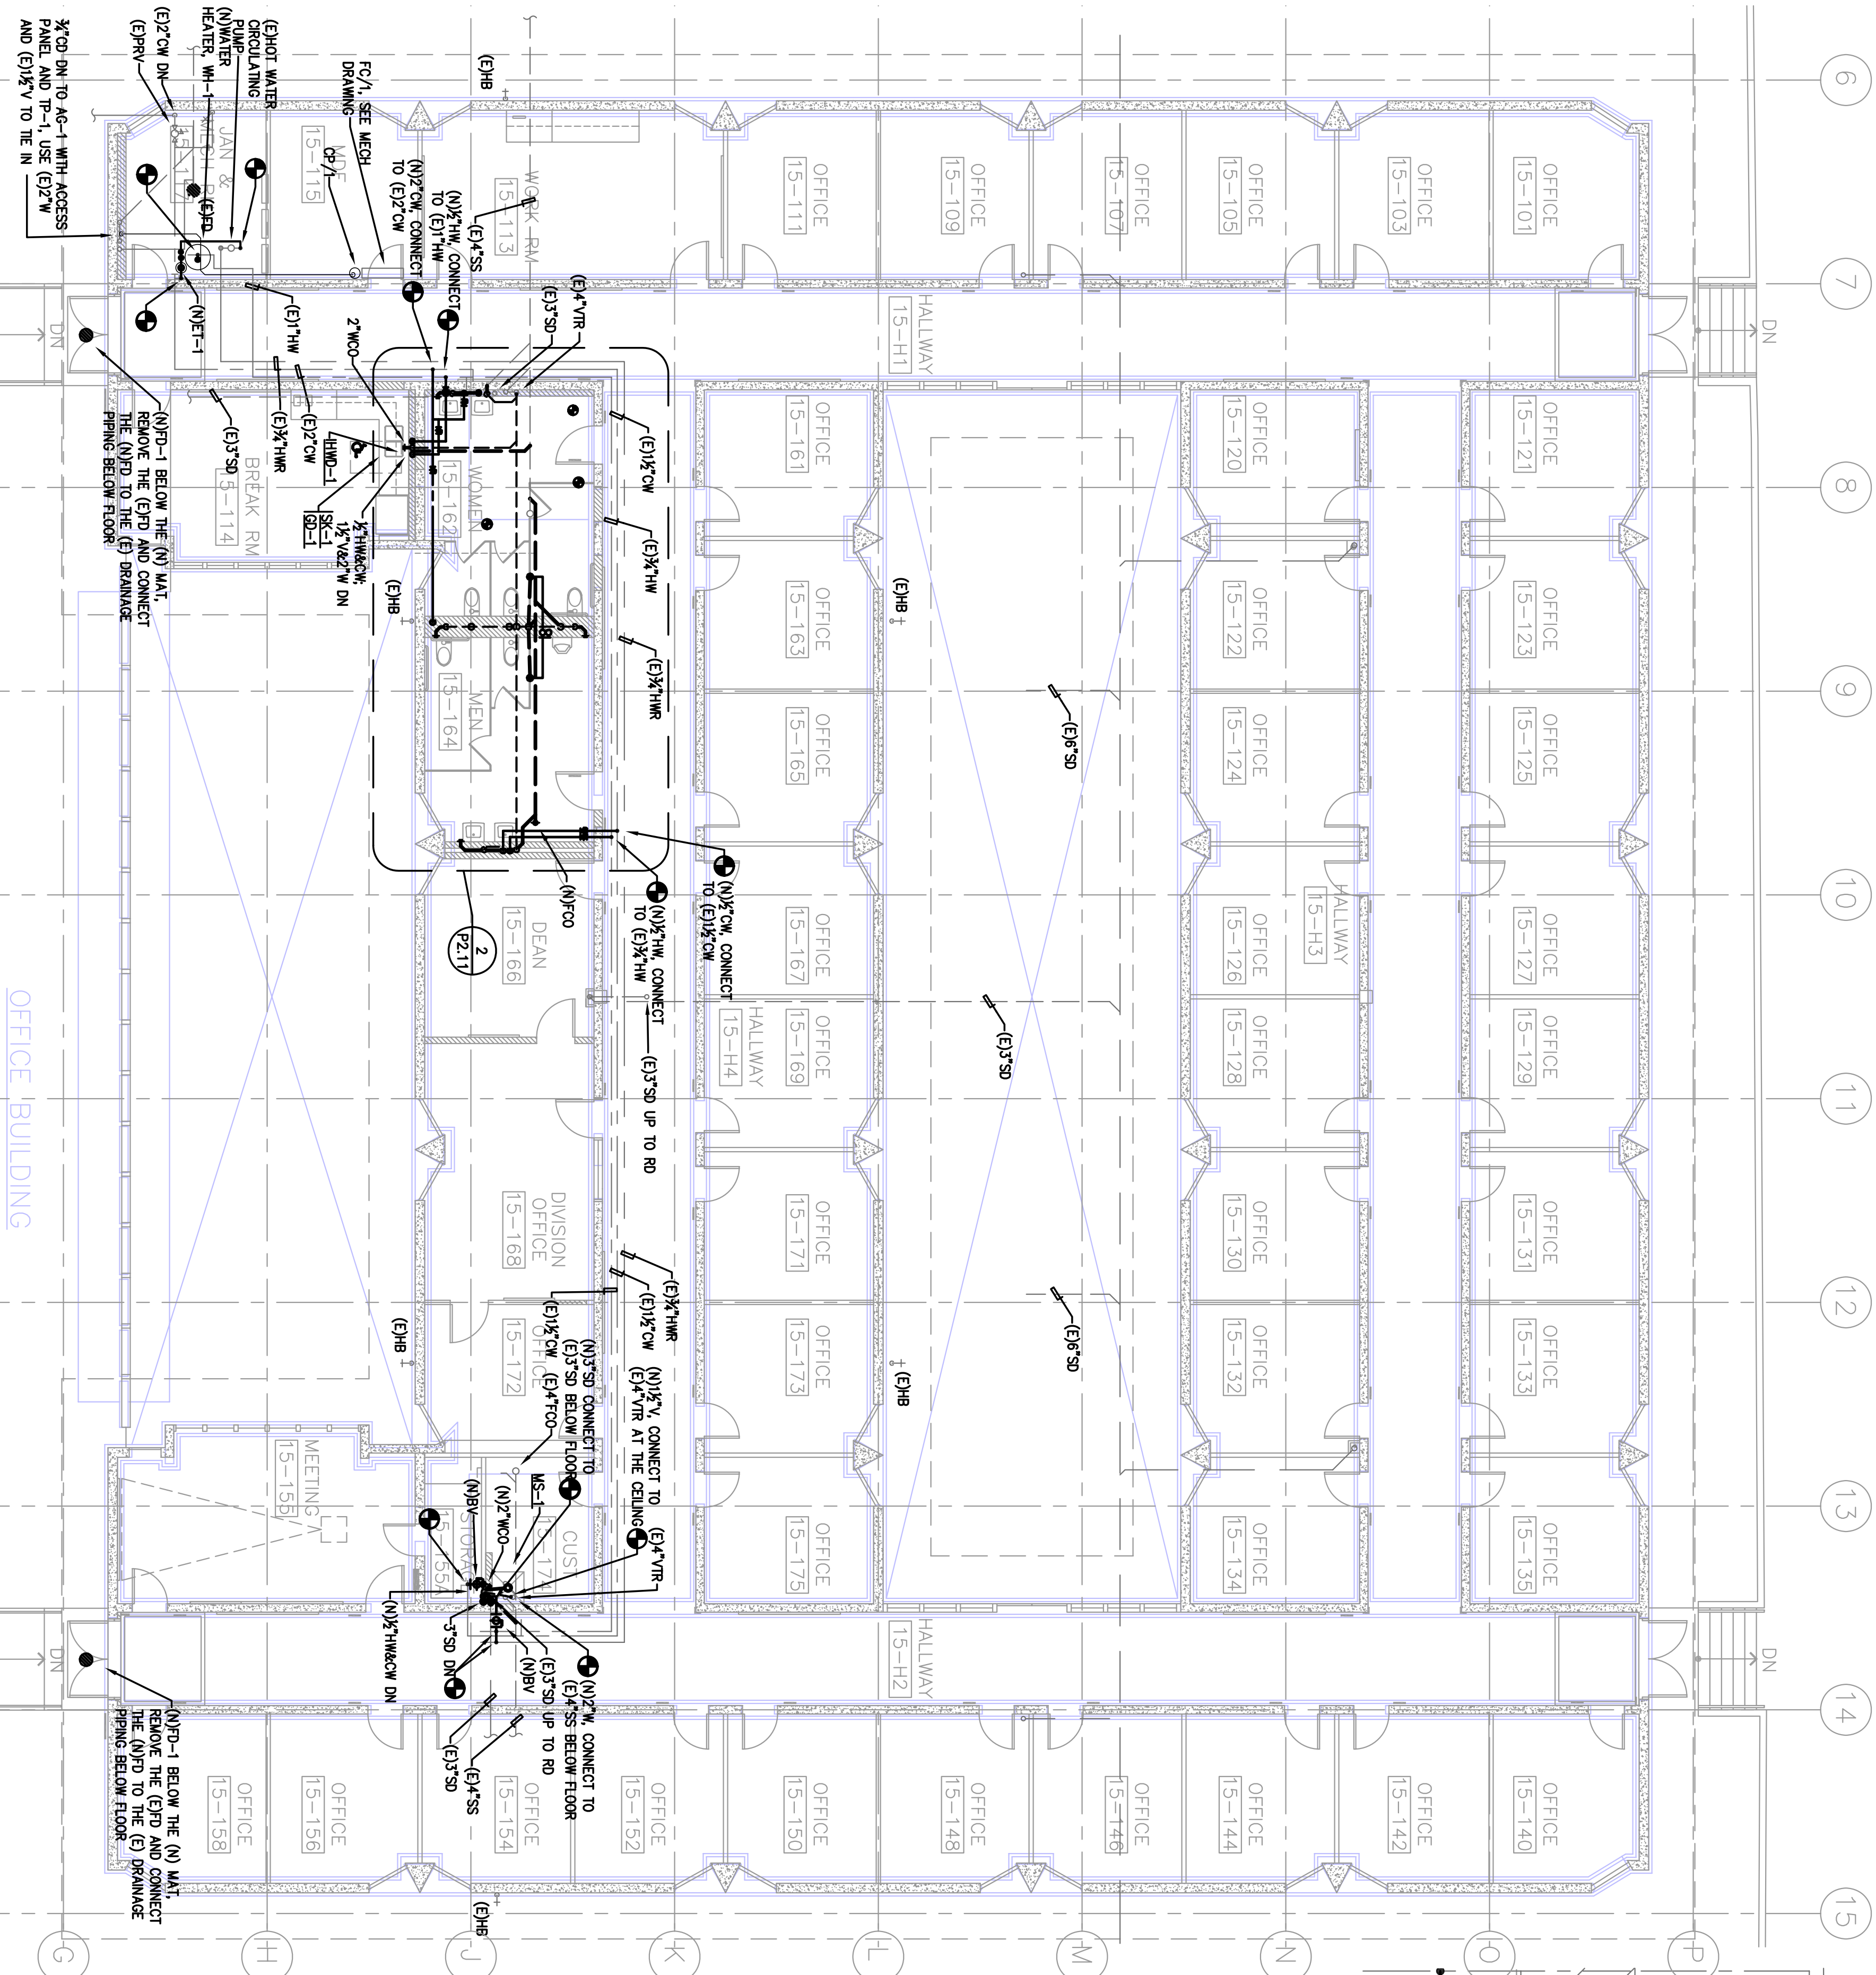

1 PLUMBING FLOOR PLAN - BUILDING 15

1/8"=1'-0"

P2.11