


Revision	Description	Date
1	PROVIDE CWA ARE SIGN	07/27/09
2	REVISION TO PANEL SCHEDULES	07/27/09
3	DATA CDD BY Confirmed Bk	08/04/09
4	3RD FLOOR FINANCIAL AID CHANGES	08/04/09
5	4TH FLOOR FINANCIAL AID CHANGES	08/04/09
6	4TH FLOOR FINANCIAL AID CHANGES	08/04/09
7	ELECTRICAL DRAWING OF RECORD	01/21/11


Revision	Description	Date
1	100% Design Development	07/27/09
2	50% Construction Documents	07/27/09
3	DATA SUBMITTAL	09/11/09
4	50% Construction Documents	12/04/09
5	DATA FINAL	03/11/10
6	ELECTRICAL CHANGES PER ARCHIT	07/28/09
7	ELECTRICAL CHANGES PER ARCHIT	07/28/09
8	ELECTRICAL CHANGES PER ARCHIT	08/04/09
9	ELECTRICAL CHANGES PER ARCHIT	08/04/09
10	ELECTRICAL CHANGES PER ARCHIT	08/04/09
11	ELECTRICAL CHANGES PER ARCHIT	08/04/09
12	ELECTRICAL CHANGES PER ARCHIT	08/04/09
13	ELECTRICAL CHANGES PER ARCHIT	08/04/09
14	ELECTRICAL CHANGES PER ARCHIT	08/04/09
15	ELECTRICAL CHANGES PER ARCHIT	08/04/09
16	ELECTRICAL CHANGES PER ARCHIT	08/04/09
17	ELECTRICAL CHANGES PER ARCHIT	08/04/09
18	ELECTRICAL CHANGES PER ARCHIT	08/04/09
19	ELECTRICAL CHANGES PER ARCHIT	08/04/09
20	ELECTRICAL CHANGES PER ARCHIT	08/04/09
21	ELECTRICAL CHANGES PER ARCHIT	08/04/09
22	ELECTRICAL CHANGES PER ARCHIT	08/04/09
23	ELECTRICAL CHANGES PER ARCHIT	08/04/09
24	ELECTRICAL CHANGES PER ARCHIT	08/04/09
25	ELECTRICAL CHANGES PER ARCHIT	08/04/09
26	ELECTRICAL CHANGES PER ARCHIT	08/04/09
27	ELECTRICAL CHANGES PER ARCHIT	08/04/09
28	ELECTRICAL CHANGES PER ARCHIT	08/04/09
29	ELECTRICAL CHANGES PER ARCHIT	08/04/09
30	ELECTRICAL CHANGES PER ARCHIT	08/04/09
31	ELECTRICAL CHANGES PER ARCHIT	08/04/09
32	ELECTRICAL CHANGES PER ARCHIT	08/04/09
33	ELECTRICAL CHANGES PER ARCHIT	08/04/09
34	ELECTRICAL CHANGES PER ARCHIT	08/04/09
35	ELECTRICAL CHANGES PER ARCHIT	08/04/09
36	ELECTRICAL CHANGES PER ARCHIT	08/04/09
37	ELECTRICAL CHANGES PER ARCHIT	08/04/09
38	ELECTRICAL CHANGES PER ARCHIT	08/04/09
39	ELECTRICAL CHANGES PER ARCHIT	08/04/09
40	ELECTRICAL CHANGES PER ARCHIT	08/04/09
41	ELECTRICAL CHANGES PER ARCHIT	08/04/09
42	ELECTRICAL CHANGES PER ARCHIT	08/04/09
43	ELECTRICAL CHANGES PER ARCHIT	08/04/09
44	ELECTRICAL CHANGES PER ARCHIT	08/04/09
45	ELECTRICAL CHANGES PER ARCHIT	08/04/09
46	ELECTRICAL CHANGES PER ARCHIT	08/04/09
47	ELECTRICAL CHANGES PER ARCHIT	08/04/09
48	ELECTRICAL CHANGES PER ARCHIT	08/04/09
49	ELECTRICAL CHANGES PER ARCHIT	08/04/09
50	ELECTRICAL CHANGES PER ARCHIT	08/04/09

Job No.	March 2009
Date	March 2009
Drawn by	
Checked by	
Scale	
Lighting Plan	LEVEL 3 - SOUTH
<b>E2.06</b>	

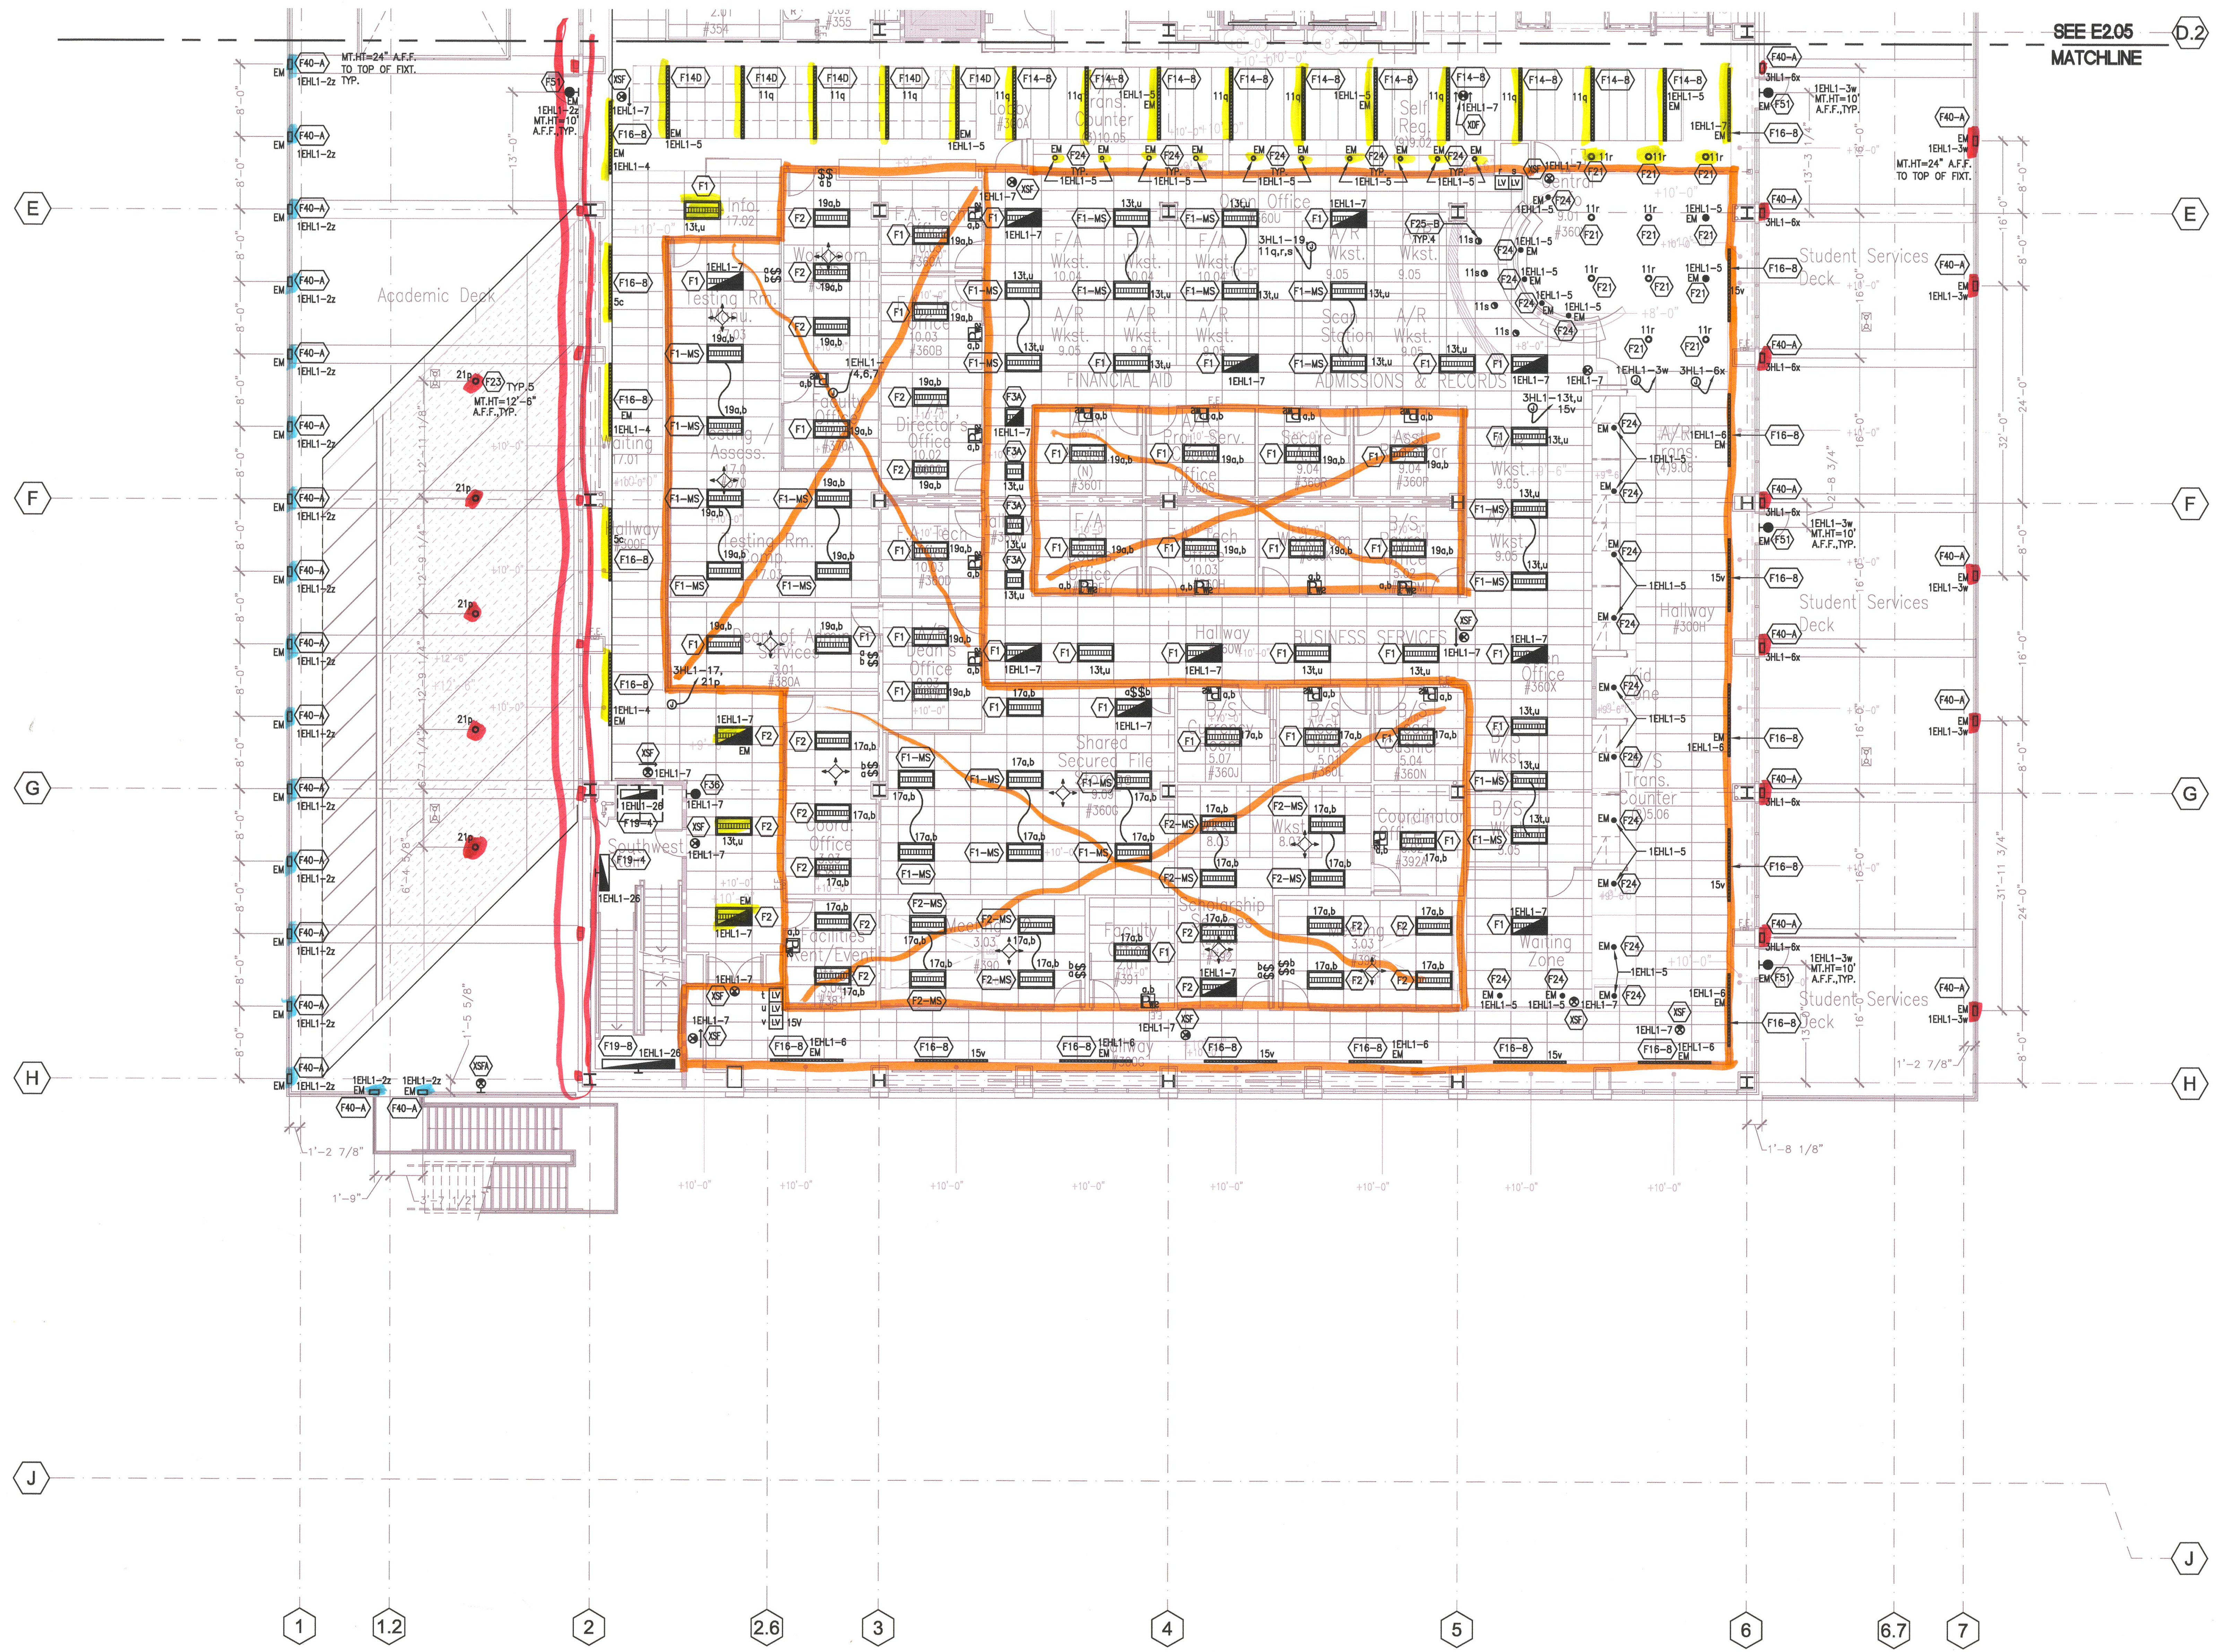

1 Lighting Plan - Level 3 - South  
E2.06 SCALE: 1/8" = 1'-0"

- GENERAL NOTES**
- ALL 277V, NORMAL LIGHTING DEVICES SHALL BE CIRCUITED TO PANEL "3HL1", U.O.N.
  - ALL 277V, EMERGENCY LIGHTING DEVICES SHALL BE CIRCUITED THRU EMERGENCY LIGHTING INVERTER TO PANEL "3EHL1", U.O.N.
  - ALL 120V, NORMAL LIGHTING DEVICES SHALL BE CIRCUITED TO PANEL "3UN21/3UN22", U.O.N.
  - ROUTE EXTERIOR LIGHTING VIA LCP AND PHOTOSENSOR MOUNTED ON ROOF FACING NORTH. CONTROLS SHALL BE INTERFACED WITH BMS.

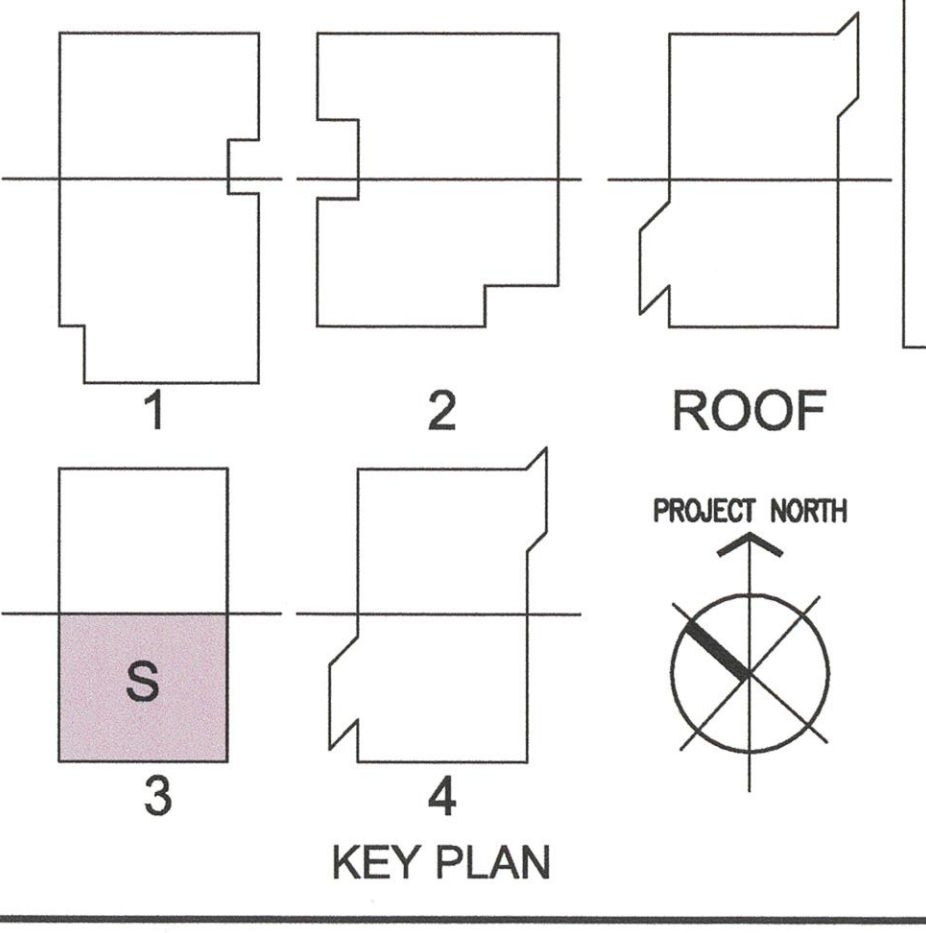

**LEGEND: OCCUPANCY SENSORS**

DT-300

PW-200

**DRAWING OF RECORD**  
ROSENBLIN ELECTRIC, INC.  
DATE: 01-21-2011