 


SECOND FLOOR FINISH AND SIGNAGE PLAN



SHEET NOTES

- 1 NO CHAIR RAIL OR WAINSCOT ON THIS WALL
- 2 PL-1 CASEWORK FINISH ON BODY
- 3 PL-2 CASEWORK FINISH AT COUNTERTOP
- 4 EP CASEWORK FINISH AT COUNTERTOP
- 5 PROVIDE ACCENT PAINT P-3 AT COLUMNS AND PROTRUDING WALLS, TYP. THIS ROOM, U.O.N.
- 6 PROVIDE ACCENT PAINT P-4 AT COLUMNS, TYP. THIS ROOM, U.O.N.
- 7 PROVIDE ACCENT PAINT P-7 AT COLUMNS, TYP. THIS ROOM, U.O.N.
- 8 PROVIDE ACCENT PAINT P-8 AT COLUMNS, TYP. THIS ROOM, U.O.N.

GENERAL NOTES


- A. SEE ELECTRICAL PLANS FOR LOCATION OF ILLUMINATED EXIT SIGNS.
- B. SEE SIGNAGE SCHEDULE FOR ROOM ID SIGNS
- C. SEE FINISH GROUPS SCHEDULE AND FINISH LEGEND ON SHEET A9.1 FOR DESCRIPTION OF FINISHES AND FINISH GROUPS.
- D. EVACUATION SIGNS (SIGN TYPE 25) TO BE POSTED AT EVERY ELEVATOR LOBBY, AT EACH FIRE ALARM FULL STATION AND AT EACH EXIT. VERIFY WITH SCHOOL DISTRICT LOCATION PRIOR TO FABRICATION. EVACUATION MAPS TO BE PROVIDED BY DISTRICT USING THE ARCHITECT'S EXISTING PLAN. SEE DETAIL 17/A9.3

LEGEND

SIGNAGE. SEE SHEET A9.40



Bunton Clifford Associates, Inc.  
210 Hammond Ave.  
Fremont, California 94539  
[T] 510.445.1000  
[F] 510.445.1005  
www.BCAincOnline.com

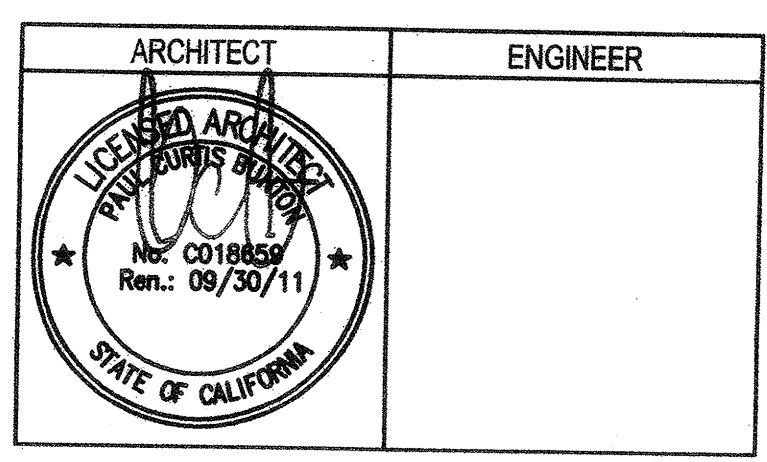

1. This sheet is part of a set and is not to be used alone.  
2. This sheet is not to be used for construction unless the architect's stamp and signature appear on the drawings and the status box indicates drawings have been released for construction.  
3. These plans and prints thereof, as instruments of service, are owned by the architect and are for use on this project only. Reproduction and/or distribution without the prior written consent of the architect is forbidden.  
4. Copyright Bunton Clifford Associates, 2006

REMARKS	DATE
ADDENDUM NO. 1	08/18/09
ADDENDUM NO. 2	11/09/09

DRAWING STATUS	DATE
ASB PLAN CHECK	08/28/08
ASB BACK CHECK	01/22/09
BIDDING	08/18/09
CONSTRUCTION	

FILE NO. 41-C1  
IDENTIFICATION STAMP OF THE STATE ARCHITECT  
01-110074  
AC: \_\_\_\_\_ FLR: \_\_\_\_\_ SS: \_\_\_\_\_  
DATE: \_\_\_\_\_

**BUILDINGS 5 & 6 RENOVATIONS**  
San Mateo County Community College District

APPROVED BY THE STATE ARCHITECT  
AC: *SM* FILE: *56* SS: *SS*  
APPL NO: *110074* DATE: *1/22/09*

**CAÑADA COLLEGE**  
4200 Farm Hill Boulevard  
Redwood City, CA 94061

SECOND FLOOR  
FINISH AND SIGNAGE PLAN

Date: 08/29/08  
Drawing Number: **A9.42**  
Scale: AS NOTED  
Project Number: 07013