

SHEET NOTES

- 1 NO CHAIR RAIL OR WAINSCOT ON THIS WALL
- 2 PL-1 CASEWORK FINISH ON BODY
- 3 PL-2 CASEWORK FINISH AT COUNTERTOP
- 4 EP CASEWORK FINISH AT COUNTERTOP
- 5 PAINT P-1 AT NEW WALLS, TYP. THIS ROOM
- 6 ACCENT WALL WITH P-4 PAINT
- 7 ACCENT WALL WITH P-8 PAINT
- 8 PROVIDE CARPET-1 AT PORTION OF THE ROOM INDICATED
- 9 ACCENT WALL WITH P-3 PAINT
- 10 PROVIDE CARPET-2 FLOORING, TYP. THIS ROOM
- 11 NO ACCENT WALL THIS ROOM
- 12 FIELD PAINT P-2 AT WALLS, TYP. THIS ROOM
- 13 PROVIDE RESILIENT FLOORING-2, TYP. THIS ROOM
- 14 FLOORING TRANSITION LINE

GENERAL NOTES


- A. SEE ELECTRICAL PLANS FOR LOCATION OF ILLUMINATED EXIT SIGNS.
- B. SEE SIGNAGE SCHEDULE FOR ROOM ID SIGNS
- C. SEE FINISH GROUPS SCHEDULE AND FINISH LEGEND ON SHEET A9.1 FOR DESCRIPTION OF FINISHES AND FINISH GROUPS.
- D. EVACUATION SIGNS (SIGN TYPE 25) TO BE POSTED AT EVERY ELEVATOR LOBBY, AT EACH FIRE ALARM PULL STATION AND AT EACH EXIT. VERIFY WITH SCHOOL DISTRICT LOCATION PRIOR TO FABRICATION. EVACUATION MAPS TO BE PROVIDED BY DISTRICT USING THE ARCHITECT'S EXTING PLAN. SEE DETAIL 17/A9.3

RFI-172

RFI-29
 ASX-36E

RFI-312
 Lav. Mirrors


RFI-24
 Finishes

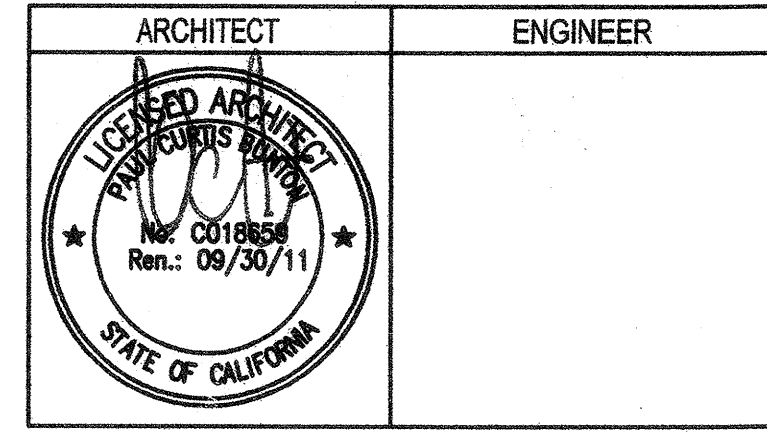

1. This sheet is part of a set and is not to be used alone.
 2. This sheet is not to be used for construction unless the architect's stamp and signature appear on the drawings and the status box indicates drawings have been released for construction.
 3. These plans and prints thereof, as instruments of service, are owned by the architect and are for use on this project only. Reproduction and/or distribution without the prior written consent of the architect is forbidden.
 4. Copyright Bunton Clifford Associates, 2009

REVISIONS	DATE
ADDENDUM NO. 1	08/18/08
ADDENDUM NO. 2	11/08/09

DRAWING STATUS	DATE
DSR PLAN CHECK	08/28/08
DSR BACK CHECK	01/22/09
BIDDING	08/18/09
CONSTRUCTION	

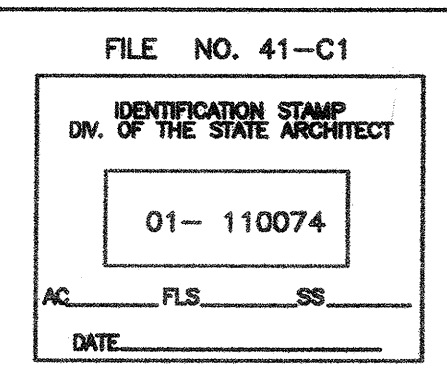



**BUILDINGS 5 & 6
 RENOVATIONS**
 San Mateo County Community
 College District

APPROVED
 DIV. OF THE STATE ARCHITECT
 AC 177, PLS. 088, SS 16
 APPL. NO. 116074, DATE 8/27/10

CAÑADA COLLEGE
 4200 Farm Hill Boulevard
 Redwood City, CA 94061

THIRD FLOOR
 FINISH AND SIGNAGE PLAN

Date 08/29/08 Drawing Number
 Scale AS NOTED **A9.43**
 Project Number 07013

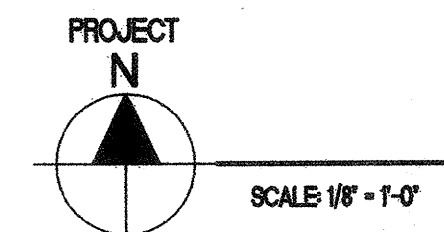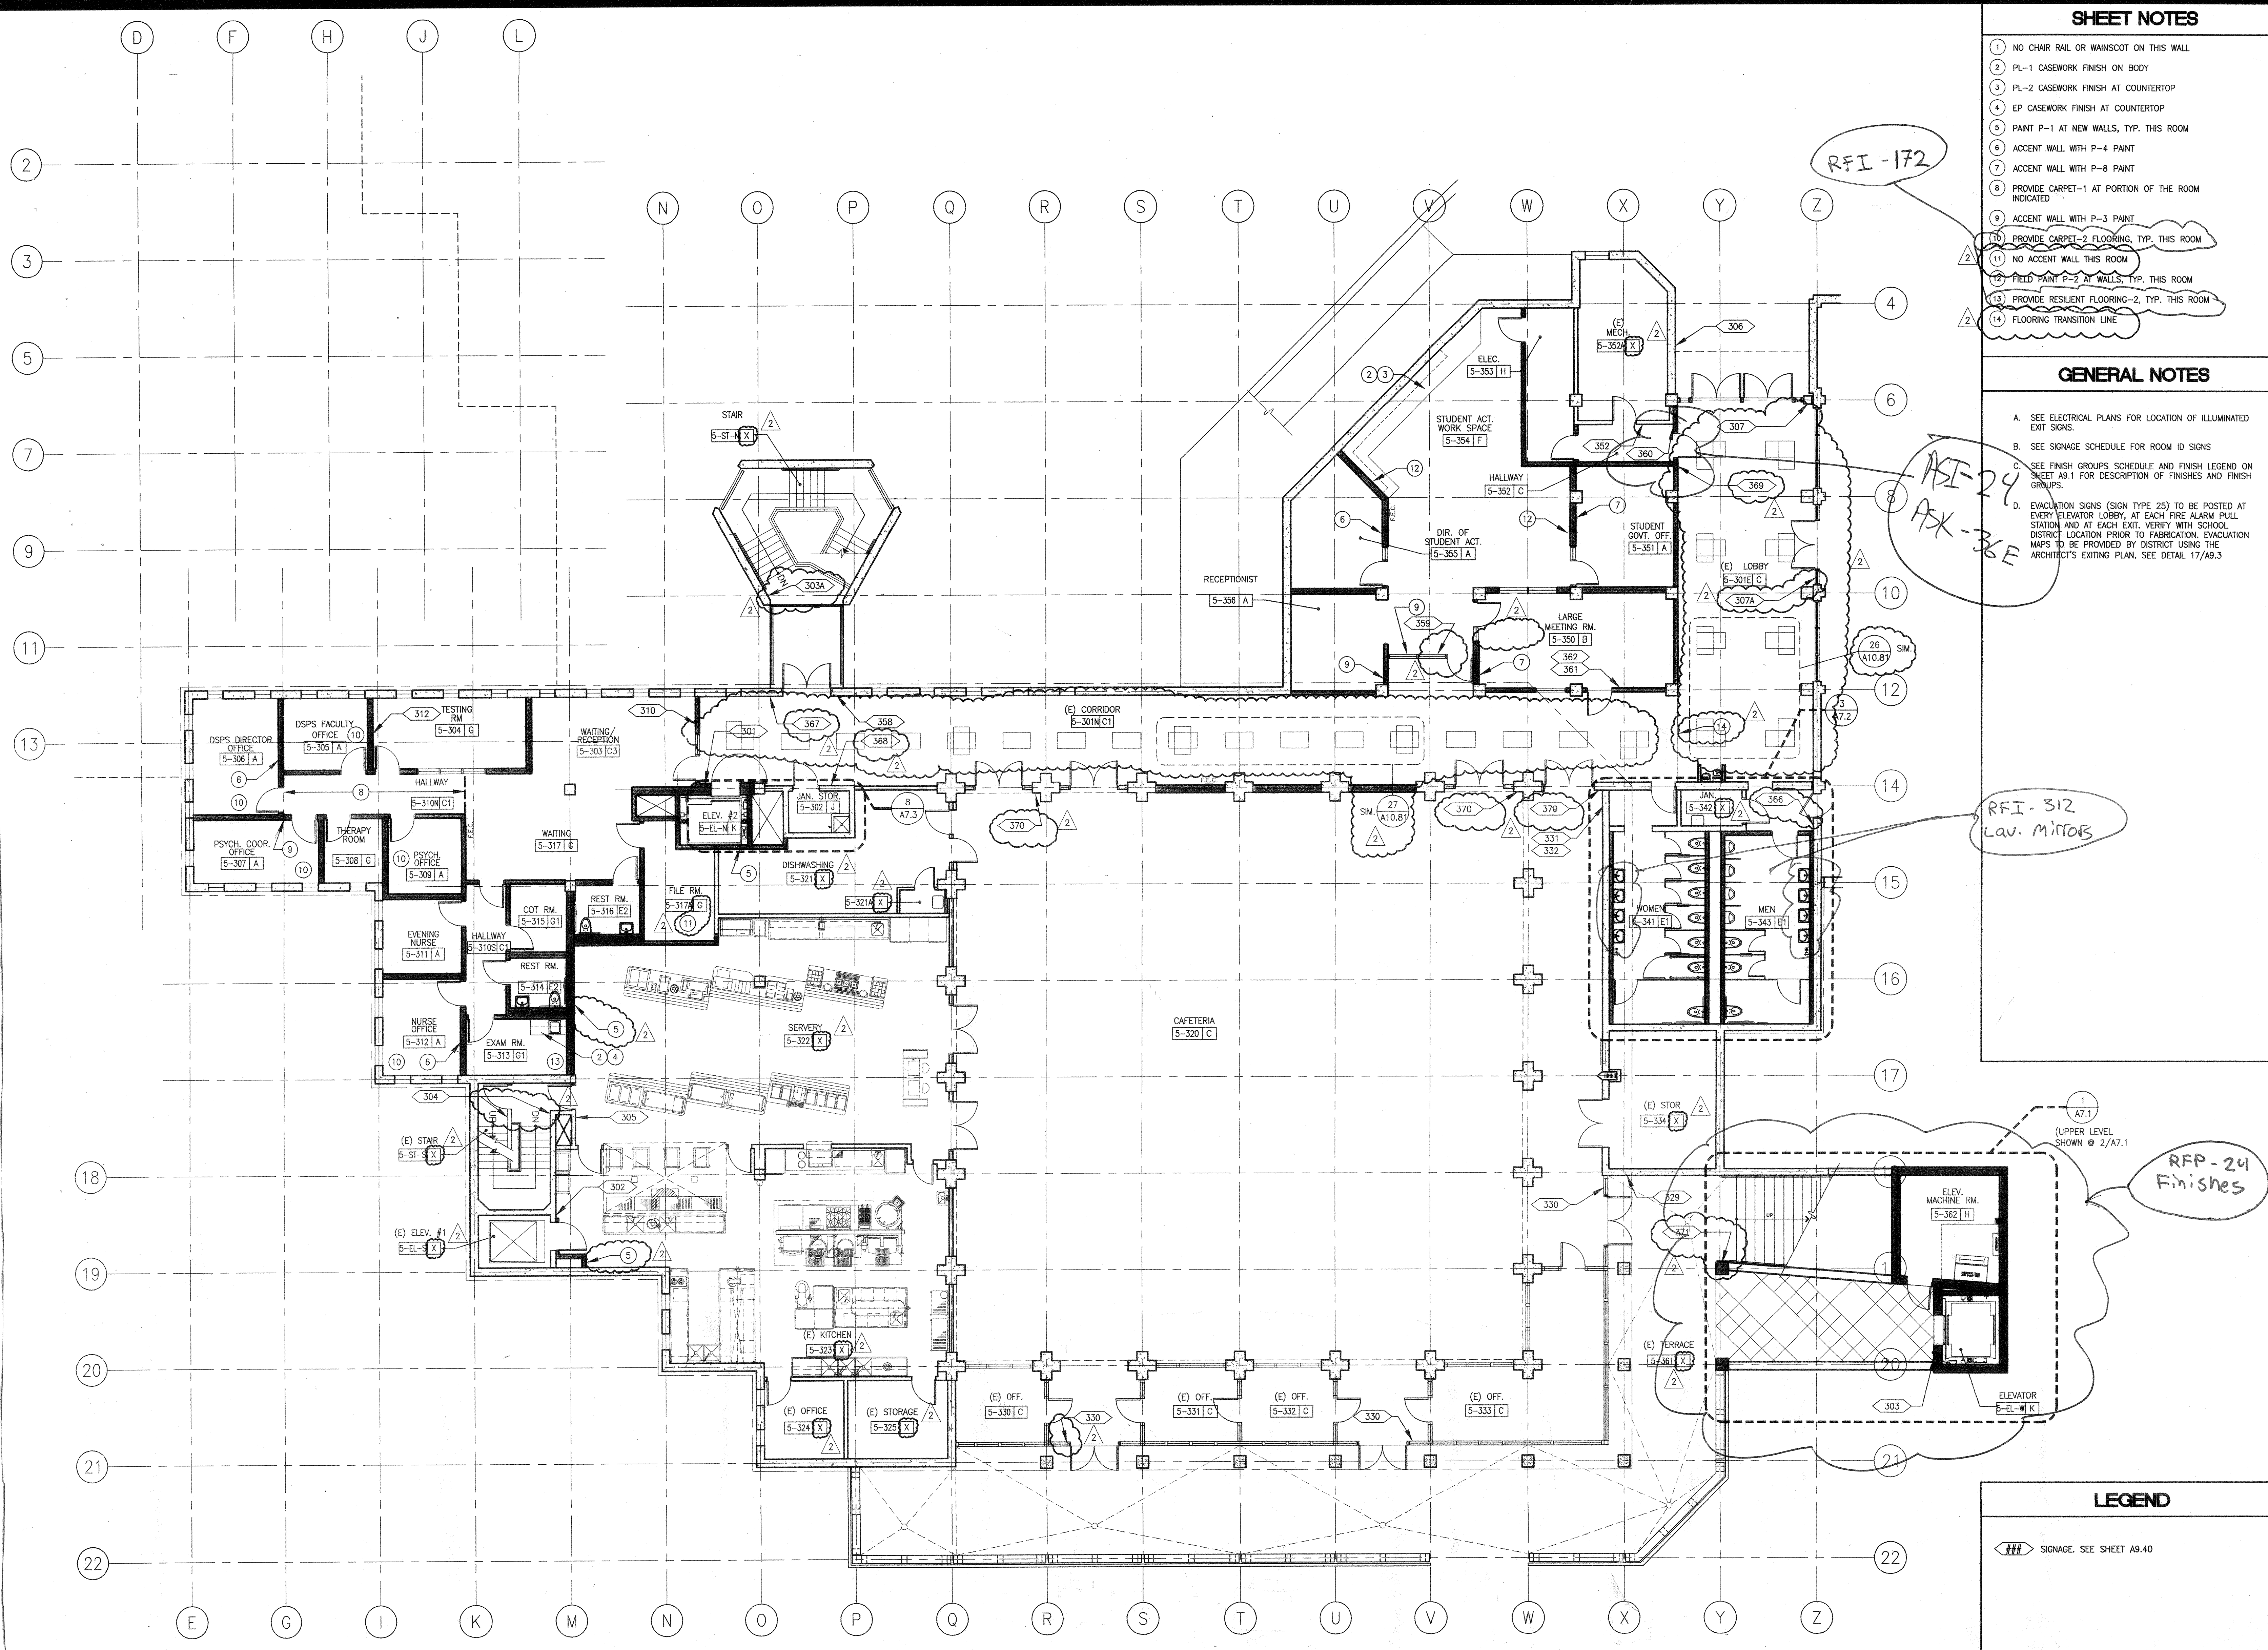

THIRD FLOOR FINISH AND SIGNAGE PLAN

1

LEGEND

SIGNAGE. SEE SHEET A9.40