


All drawings and written material appearing herein constitute original and unpublished work of ALLIED HEATING AND AIR CONDITIONING CO., INC. and may not be duplicated, used or disclosed without written consent of ALLIED HEATING AND AIR CONDITIONING CO., INC.

Child Development Center  
 Cañada College

4200 Farm Hill Blvd  
 Redwood City, CA 94061

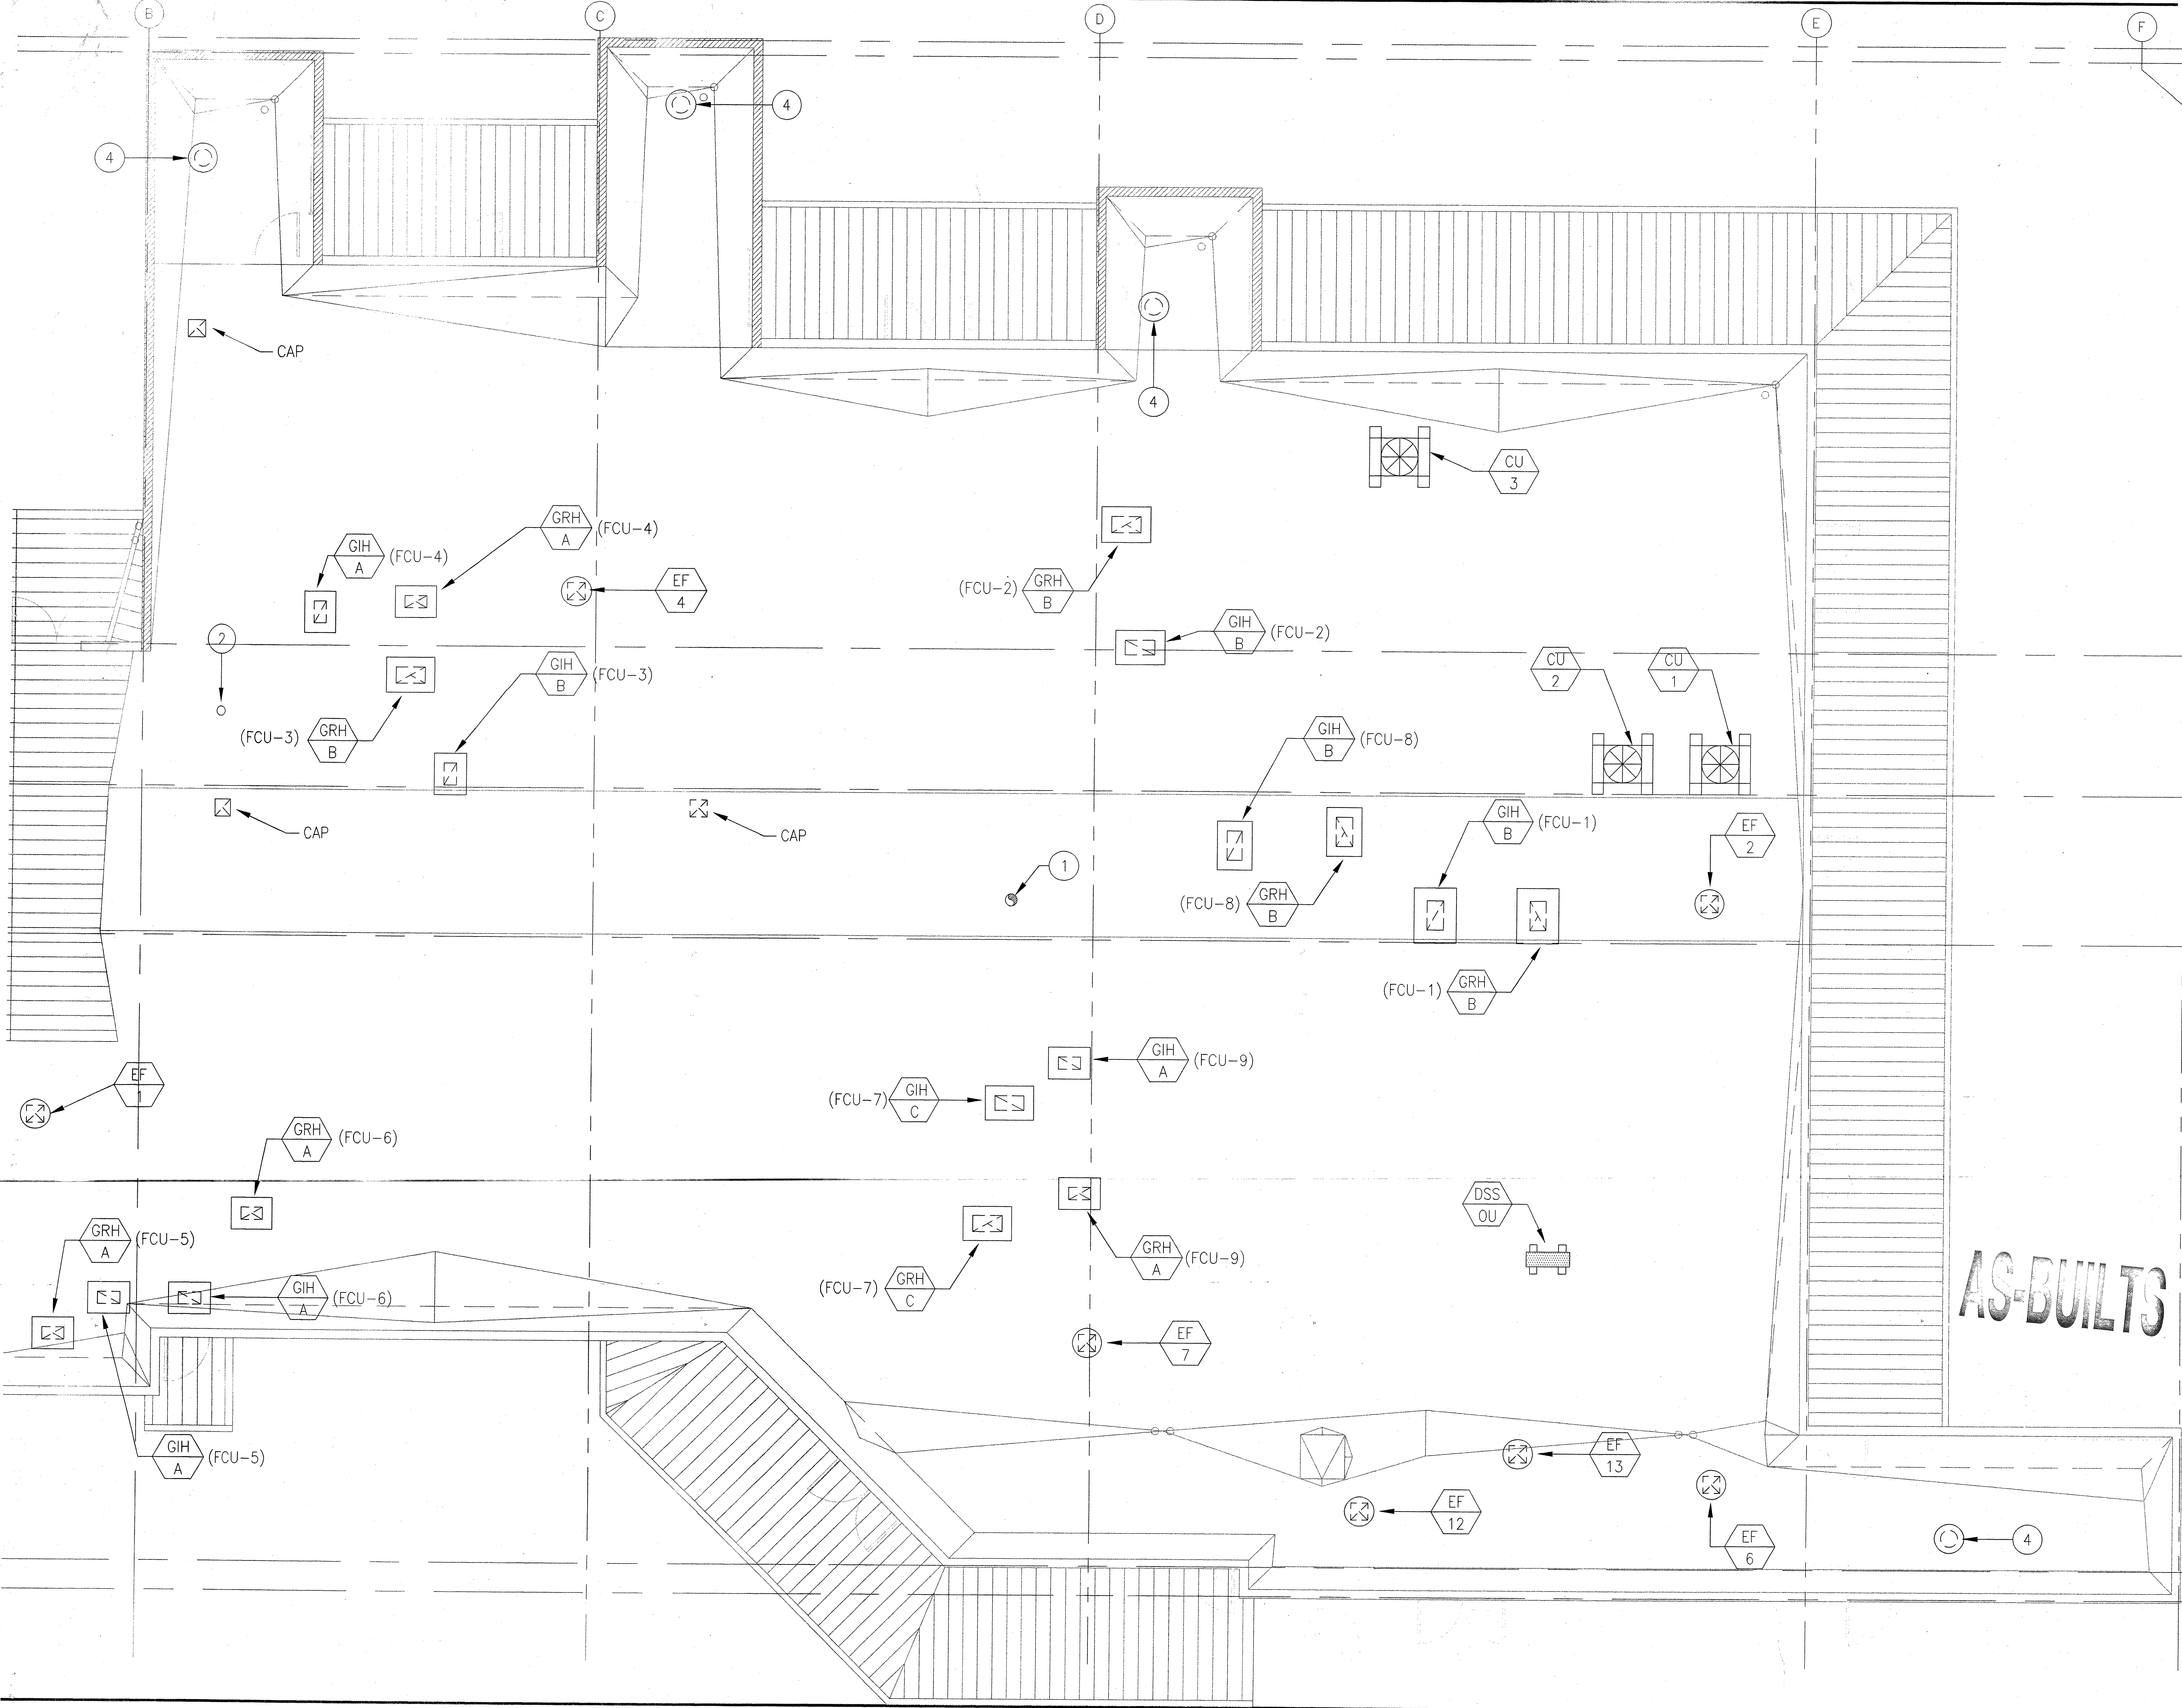

**AS-BUILTS**

ISSUES AND REVISIONS

Record Drawing	09.03.03
----------------	----------

Date: 08.05.03  
 Scale: 1/4"=1'-0"  
 Modified By: David V

Cañada College

Roof Plan - HVAC

Sheet Number: M1.3r  
 Job Number: 02026