


**LIGHTING
1ST LEVEL FLOOR PLAN**
SCALE 1/8"=1'-0"

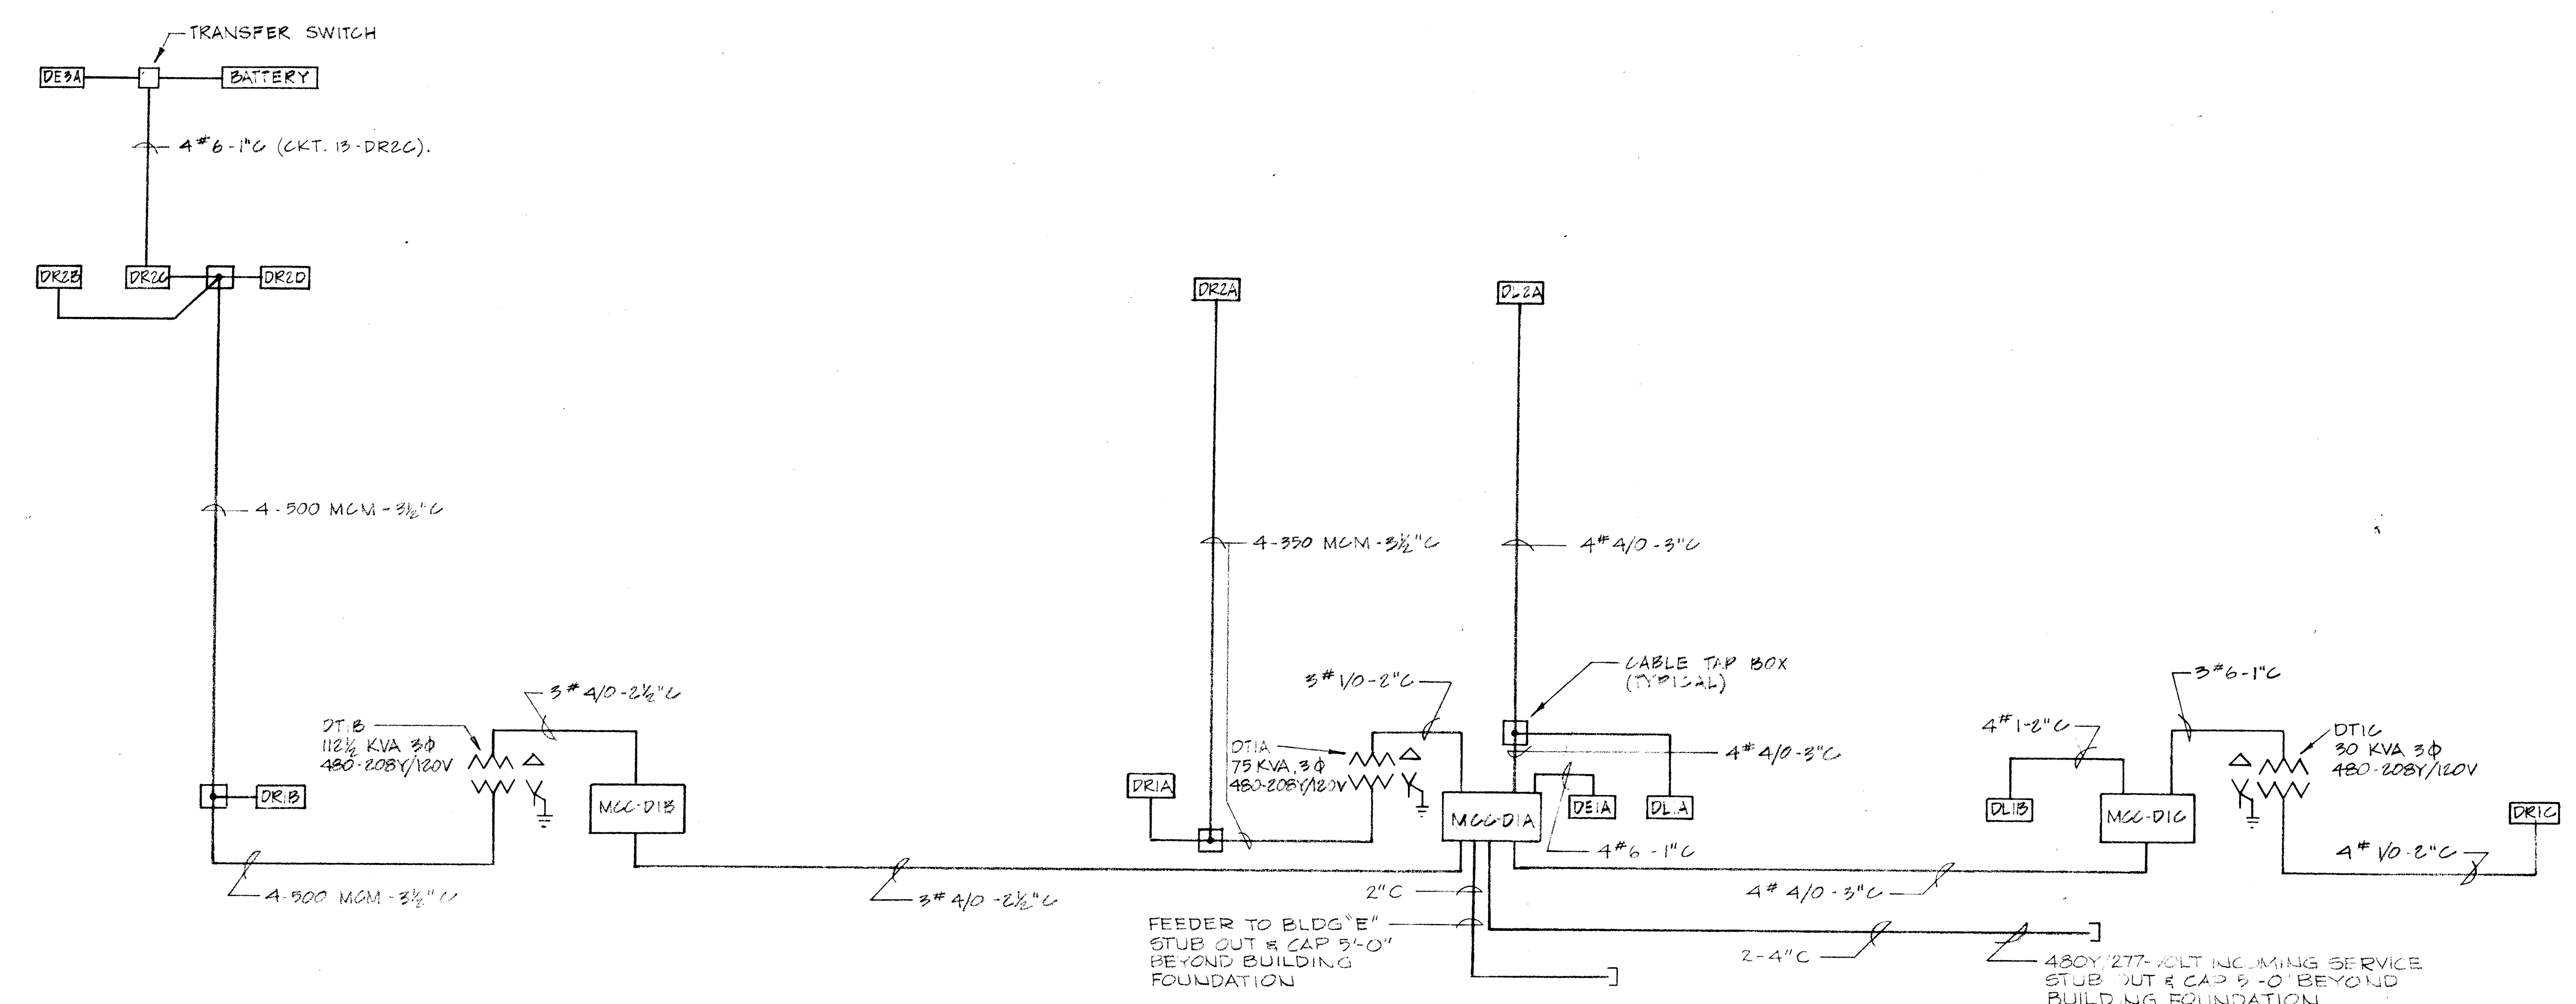


BUILDING "D" RISER DIAGRAM

NOTES:

- SEE SHEETS EG-1 THROUGH EG-4
EG-1 SYMBOLS, NOTES & FIXTURES
EG-2 DIAGRAMS
EG-3 & 4 PANEL SCHEDULES
- ALL ELECTRICAL WORK IN MECHANICAL ROOMS SHALL BE RUN EXPOSED, AND COORDINATED WITH MECHANICAL EQUIPMENT. FIXTURES SHALL BE LOCATED AFTER EQUIPMENT IS INSTALLED.
- REFER TO ARCHITECTURAL REFLECTED CEILING PLANS AND INTERIOR ELEVATIONS FOR EXACT LOCATIONS OF FIXTURES AND ELECTRICAL EQUIPMENT, INCLUDING STUB-UPS FOR FUTURE LABORATORY EQUIPMENT.

SCHEDULE OF LIGHTING FIXTURES

LOCATION	TYPE
MEN, WOMEN, TOILETS, LOCKERS	2/40-J2
DIVISION OFFICE, FAC OFFICES, TOWEL RM	4/40-J2
STAIRS, CORRIDOR, HALLS, VEST, LOBBY, GARDENING, TEAM RM, EQUIPMENT RMs.	2/40-A1
LOCKERS	1/40-A2
SHOWERS	2/40-E
EXITS	2/25-GQ
ALL OTHERS EXCEPT NOTED ON PLANS	4/40-A

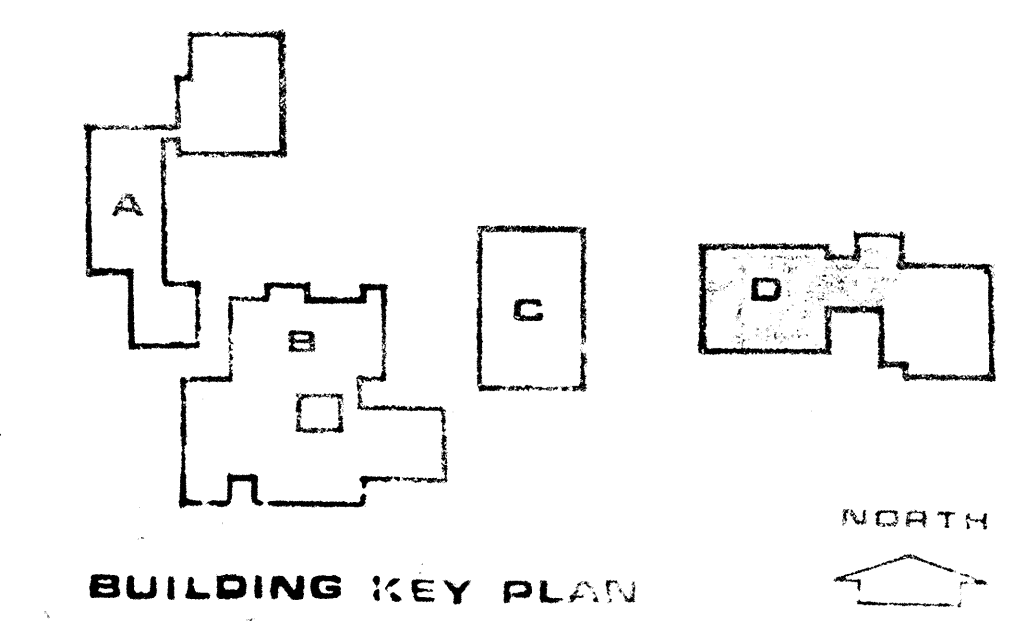

BUILDING KEY PLAN

JOHN CARL WARNECKE FALL
JOHN CARL WARNECKE AND ASSOCIATES
ARCHITECTS AND PLANNING CONSULTANTS
61 NEW MONTGOMERY STREET SAN FRANCISCO

COLLEGE OF SAN MATEO
SAN BRUNO CALIFORNIA
ELECTRICAL - 1ST LEVEL PLAN - LIGHTING
PHYSICAL EDUCATION BUILDING 'D'

SCALE	DATE	REVISION DESCRIPTION	DATE	APPROVED
AS SHOWN	10-18-67			
JOB NO. 64-18	AW:ZA			
D.B.	AW:ZA			
CHECK BY P.E.G.				
DATE FEB 10 1967				
SHEET NUMBER		NO.		
E-D1				
OF 5 SHEETS		REVISION NO.		