



NOTES:
 1. SEE NOTES 1 TO 4 ON SHEET E-A1.

SCHEDULE OF LIGHTING FIXTURES	
LOCATION	TYPE
MEN, WOMEN	2/40-12
CORRIDORS	FIXTURE C
STAIRS	2/40-A1
EXITS	2/25-02
ALL OTHERS EXCEPT NOTED ON PLANS	4/40-A

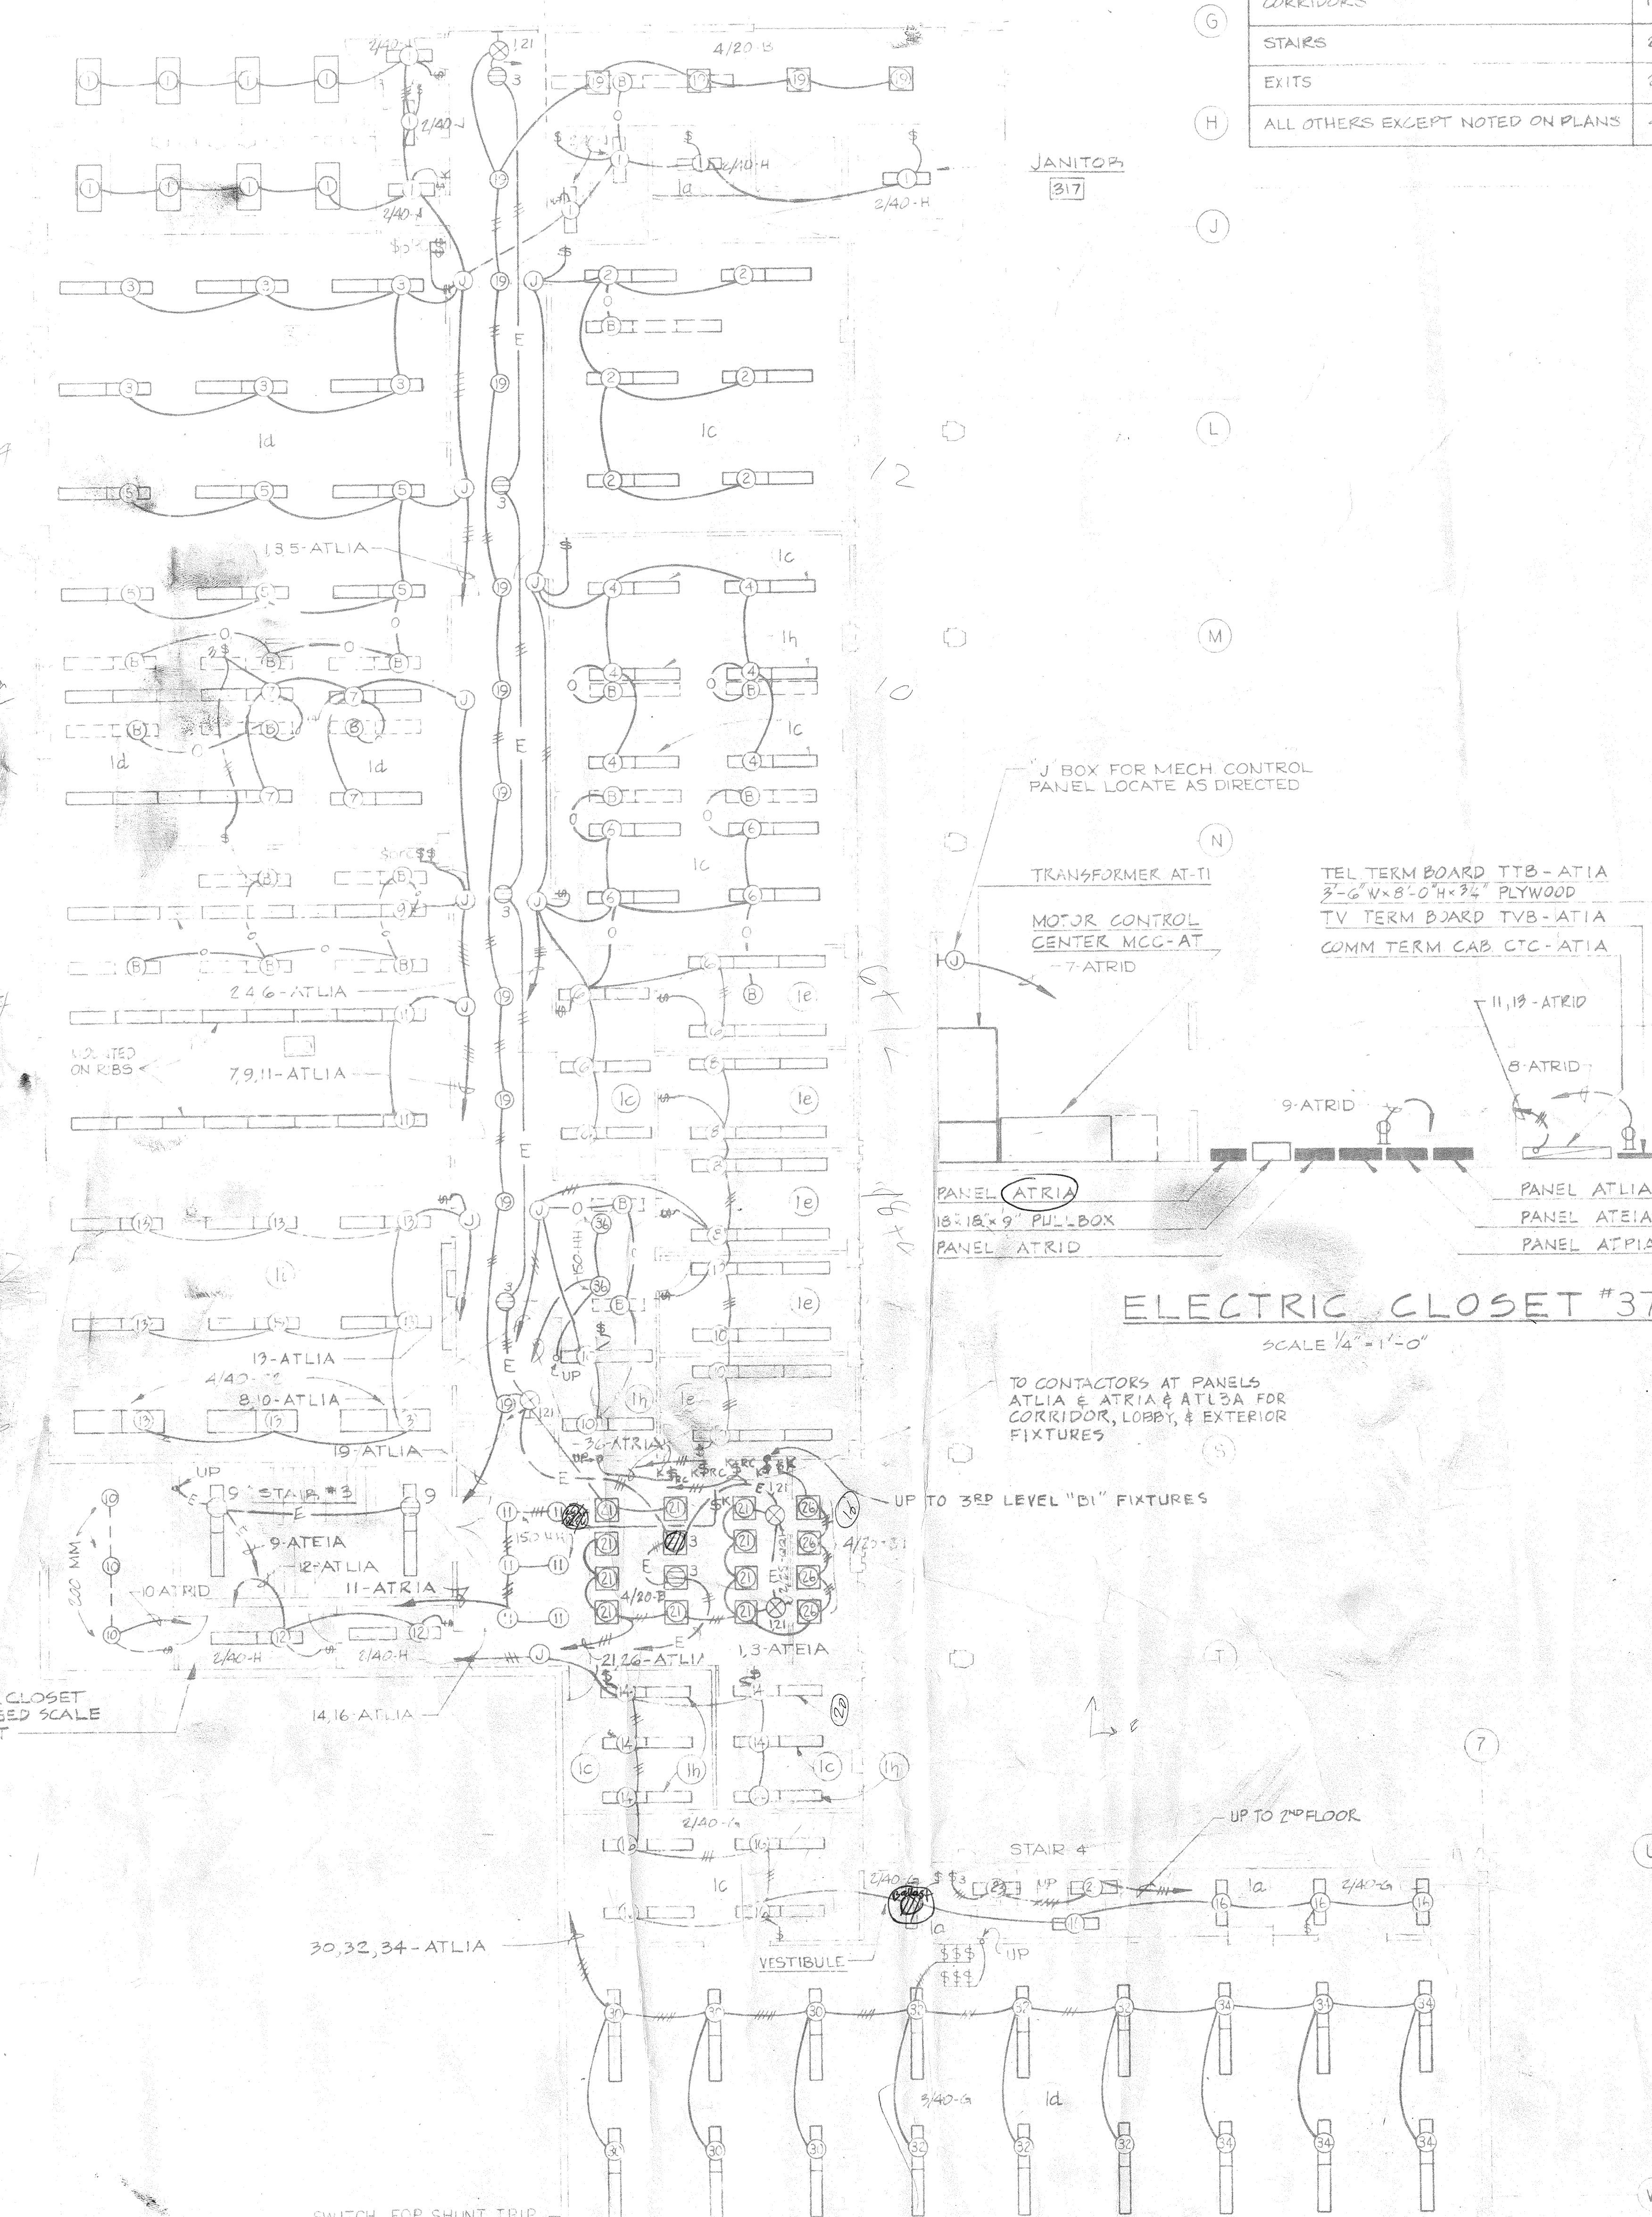


LIGHTING
 1ST LEVEL FLOOR PLAN
 SCALE 1/8"=1'-0"

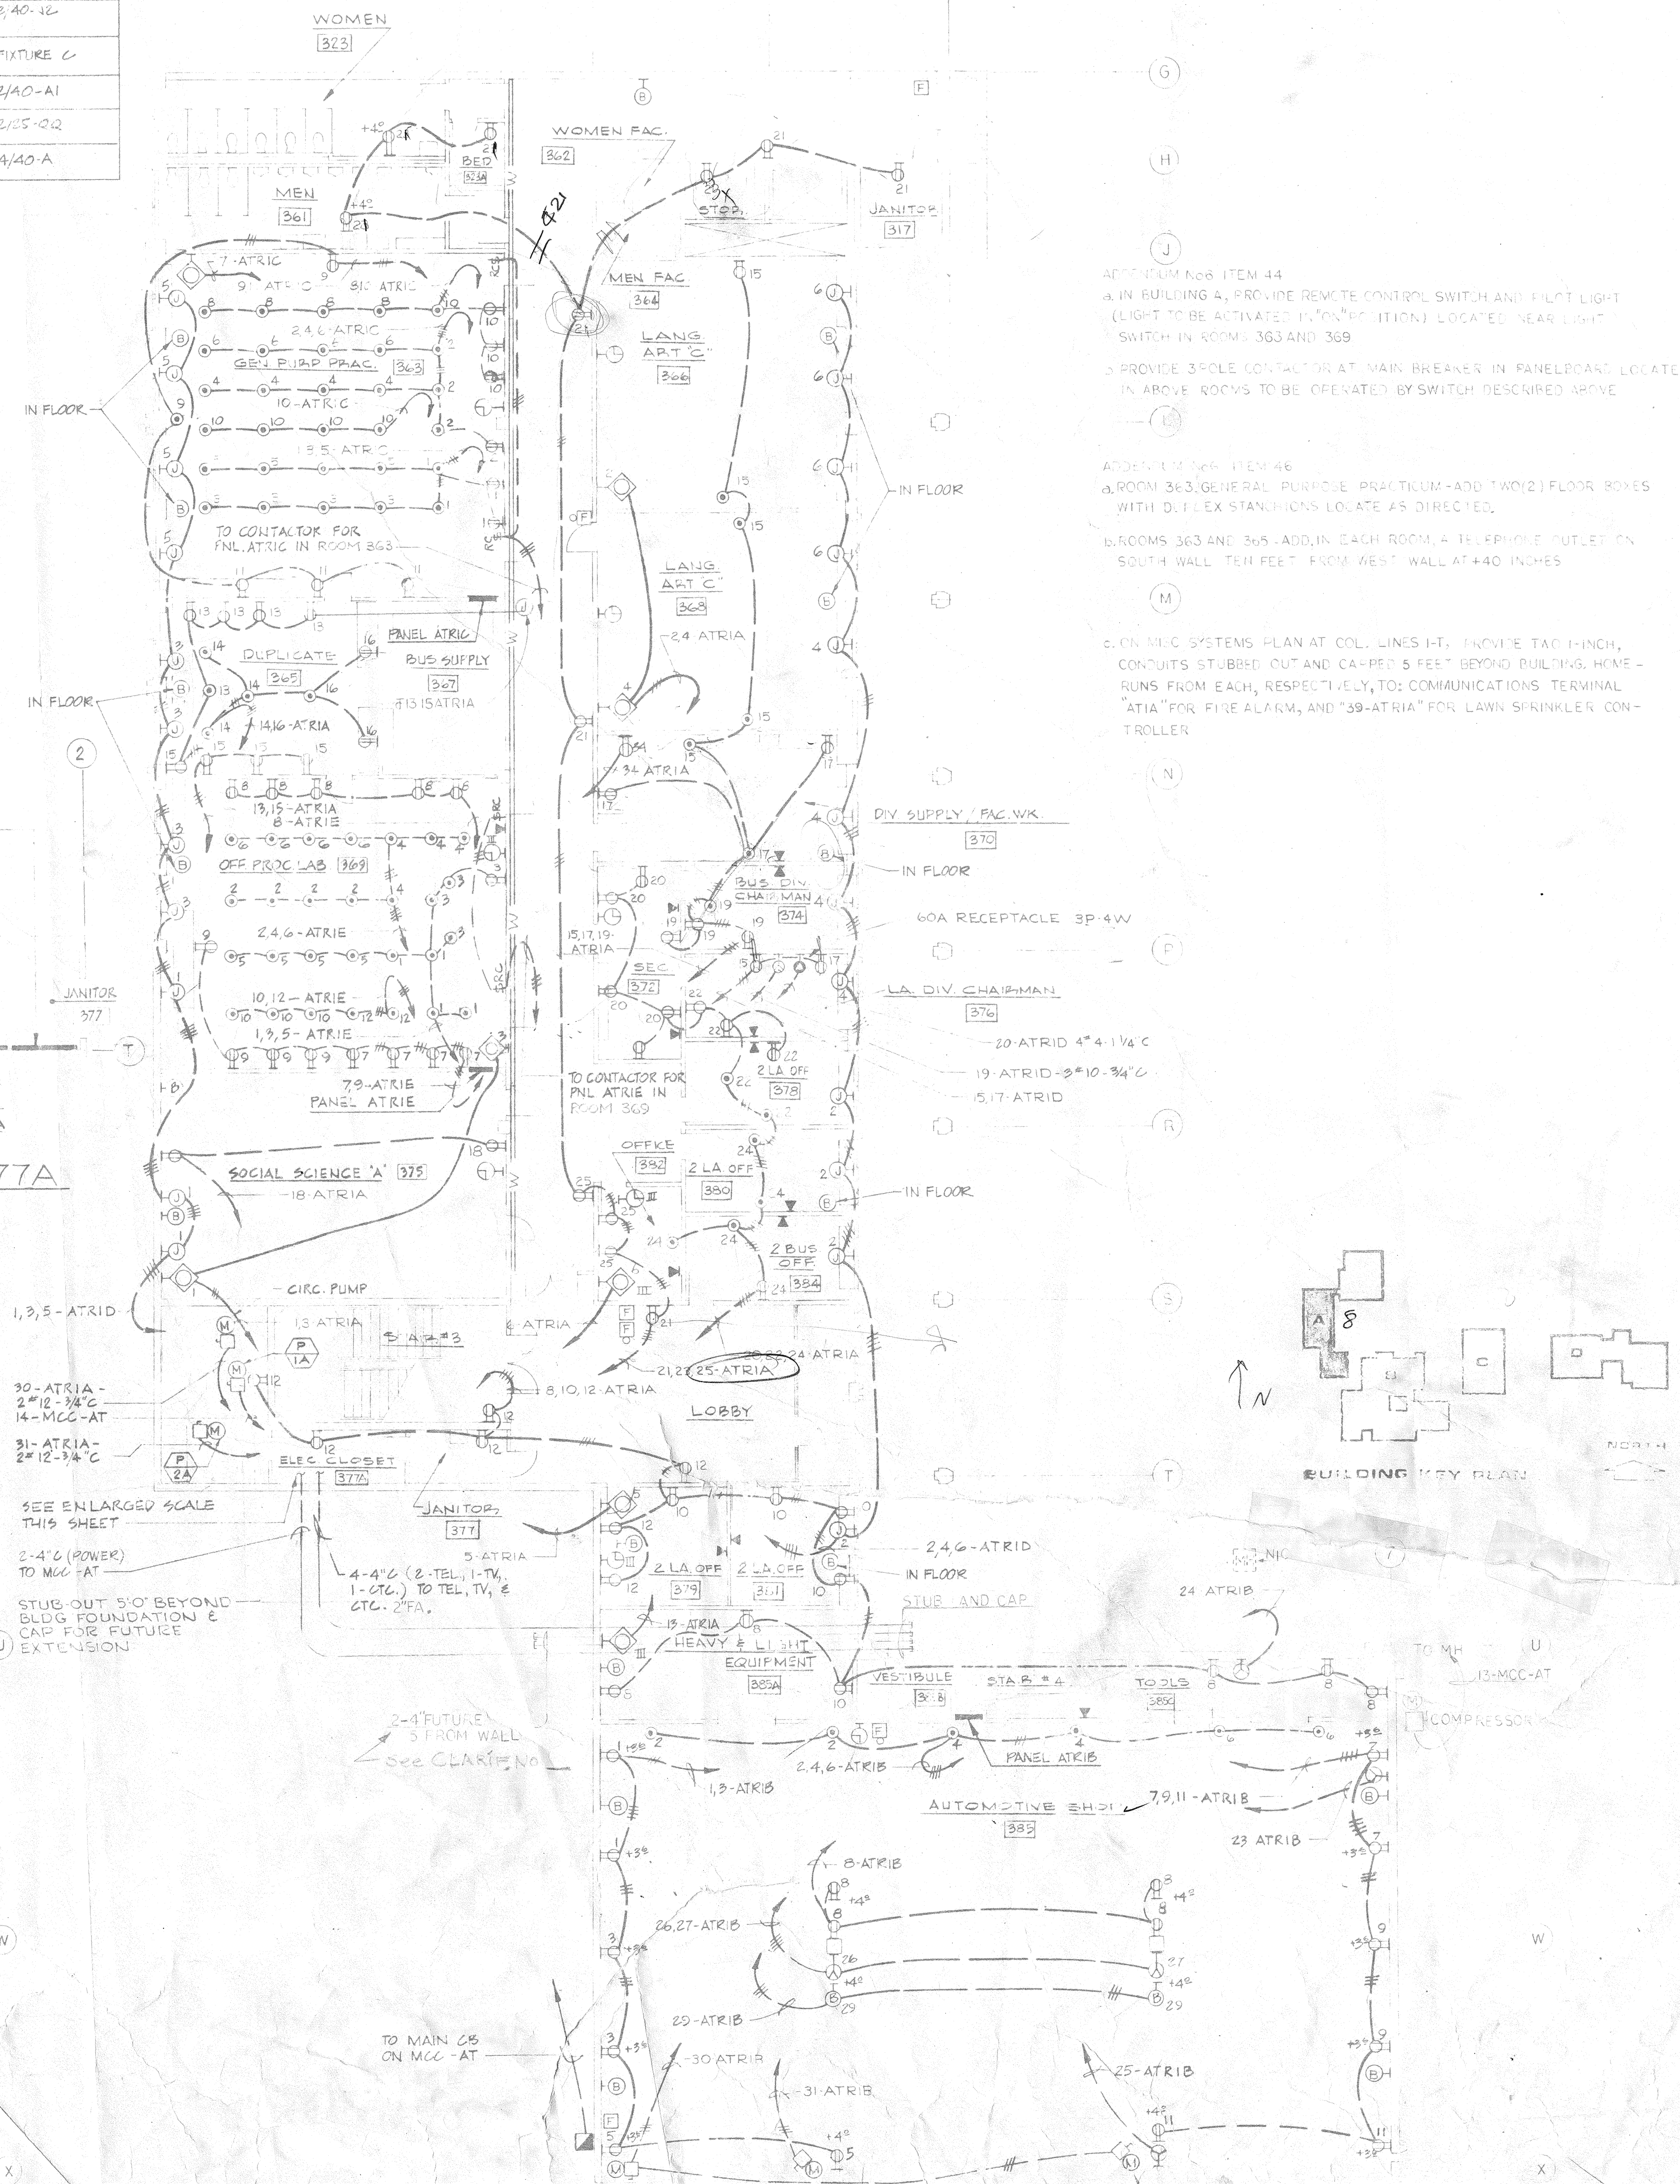

MISCELLANEOUS SYSTEMS
 1ST LEVEL FLOOR PLAN
 SCALE 1/8"=1'-0"

ELECTRIC CLOSET #377A
 SCALE 1/4"=1'-0"

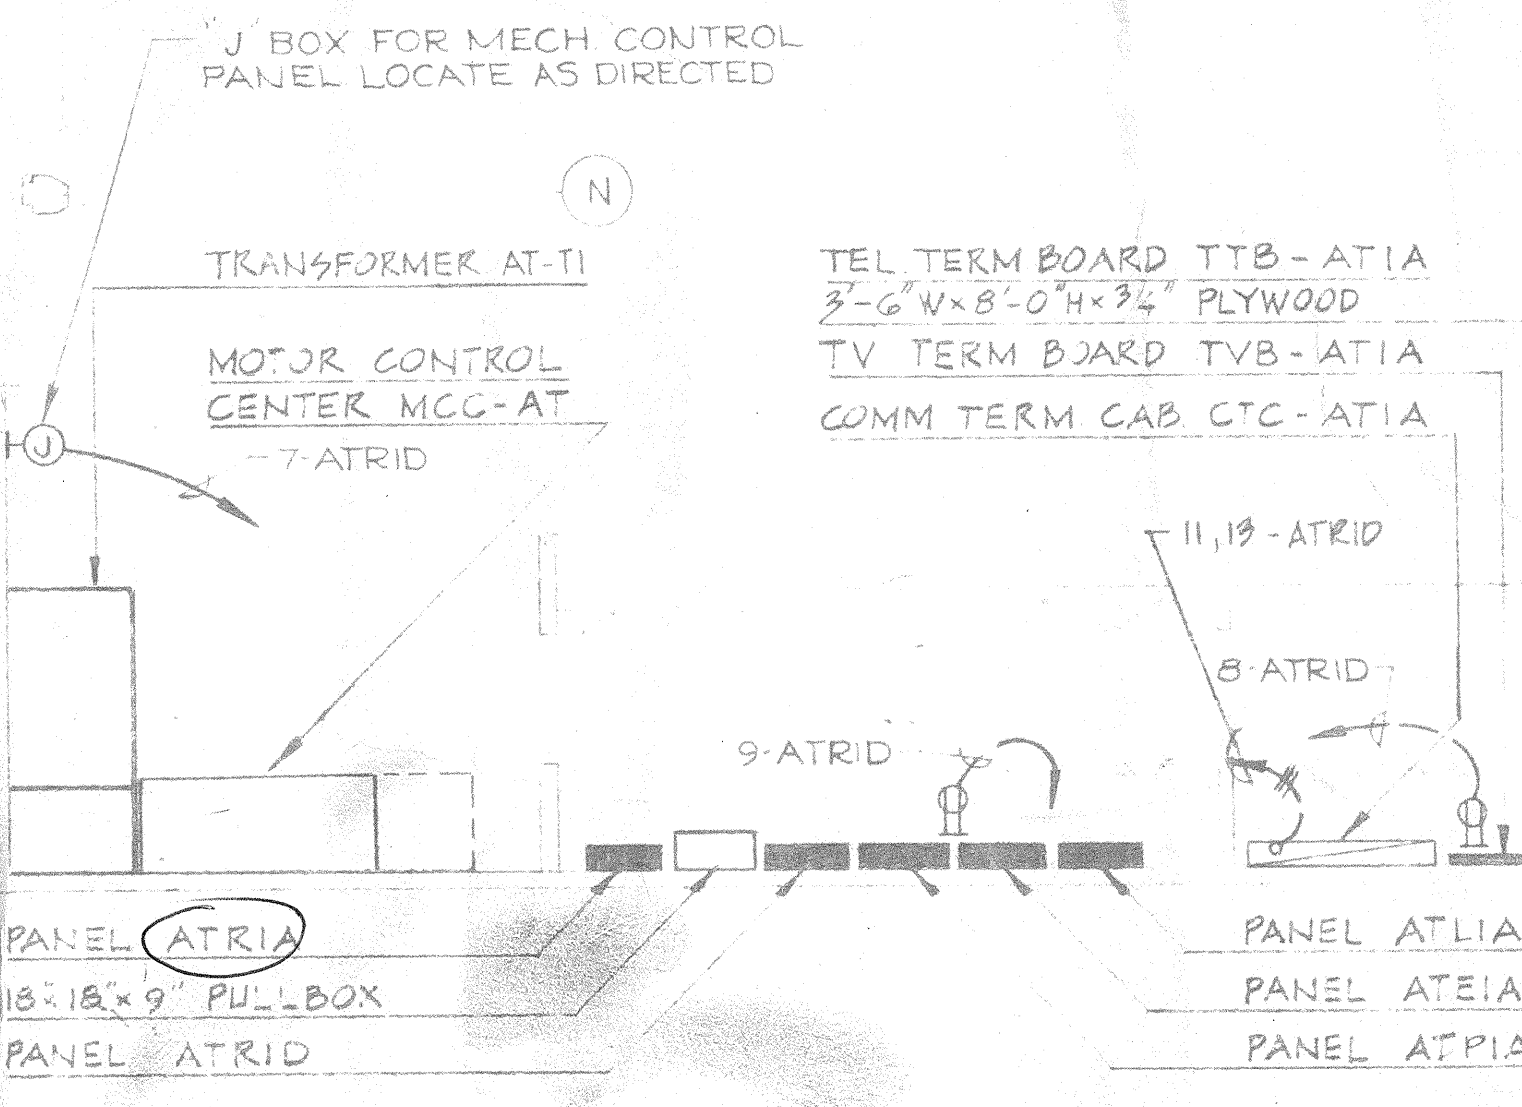

JOHN CARL WARNECKE P.E. A.I.A.
JOHN CARL WARNECKE AND ASSOCIATES
 ARCHITECTS AND PLANNING CONSULTANTS
 61 NEW MONTGOMERY STREET SAN FRANCISCO

ISADORE THOMPSON
 STRUCTURAL ENGINEER
 MICHAEL & EUGENE ENGINEERS
 CIVIL ENGINEERS

MATTHEW T. SCOTLAND
 ARCHITECTURAL ELECTRICAL ENGINEER
 WASHINGTON STATE LICENSE NO. 11417
 CALIFORNIA LICENSE NO. 2177

MATTHEW T. SCOTLAND
 ARCHITECTURAL ELECTRICAL ENGINEER
 WASHINGTON STATE LICENSE NO. 11417
 CALIFORNIA LICENSE NO. 2177

BUILDING A SCIENCE, TECH/VOC.
 ELECTRICAL 1ST LEVEL PLANS
COLLEGE OF SAN MATEO
 SAN BRUNO CALIFORNIA

SCALE AS SHOWN	DATE	REVISION DESCRIPTION	DATE	APPROVED
JOB NO. 64-15				
D.B. B.A.P.P.				
CHECKED BY P.E.G.				
DATE SAN 10 1967				
SHEET NUMBER				
OF 6 SHEETS				
REVISION NO.				