

JOHN CARL WARNECKE & ASSOCIATES
ARCHITECTS AND PLANNING CONSULTANTS
67 NEW MONTGOMERY STREET
SAN FRANCISCO

JOHN CARL WARNECKE AND ASSOCIATES
ARCHITECTS AND PLANNING CONSULTANTS
67 NEW MONTGOMERY STREET
SAN FRANCISCO


BRADY THOMPSON
STRUCTURAL ENGINEER
MECH. & ELEC. ENGINEERS
CARL E. KIRKER
CIVIL ENGINEER

MATTHEW J. ASSIGNED
SAN MATEO JUNIOR COLLEGE DISTRICT
OFFICE OF ARCHITECTURE
2774 G. AVENUE
SAN MATEO, CALIFORNIA 94401
APPROVED 11/18/1987


BUILDING A SCIENCE, TECH / VOC
WALL SECTIONS
COLLEGE OF SAN MATEO
SAN BRUNO CALIFORNIA

SCALE AS NOTED
JOB NO. 1504
D.B.
CHECK BY
DATE JAN 12 1987

SHEET NUMBER
NO. REVISION DESCRIPTION DATE APPROVED
SAII
OF 26 SHEETS
REVISION NO.

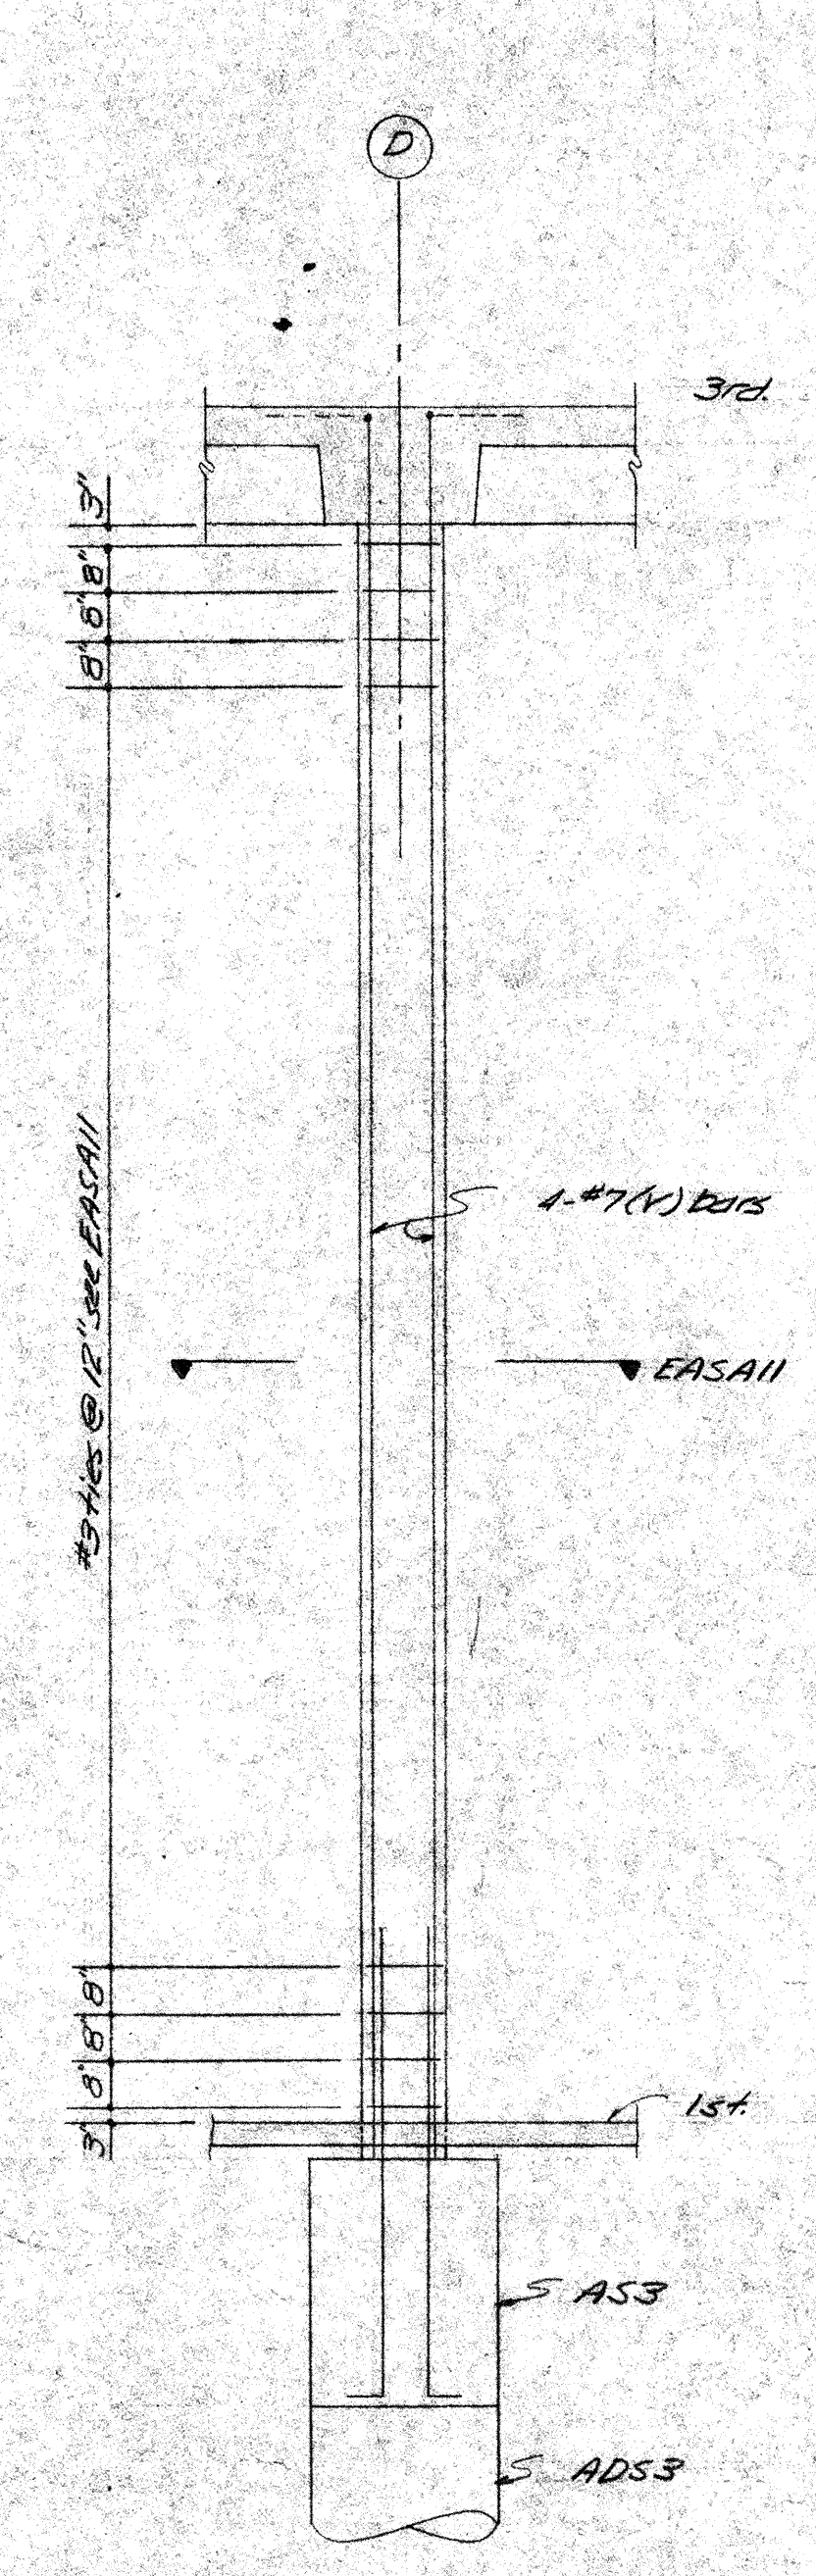


PLAN
EASII 3/4"=1'-0"

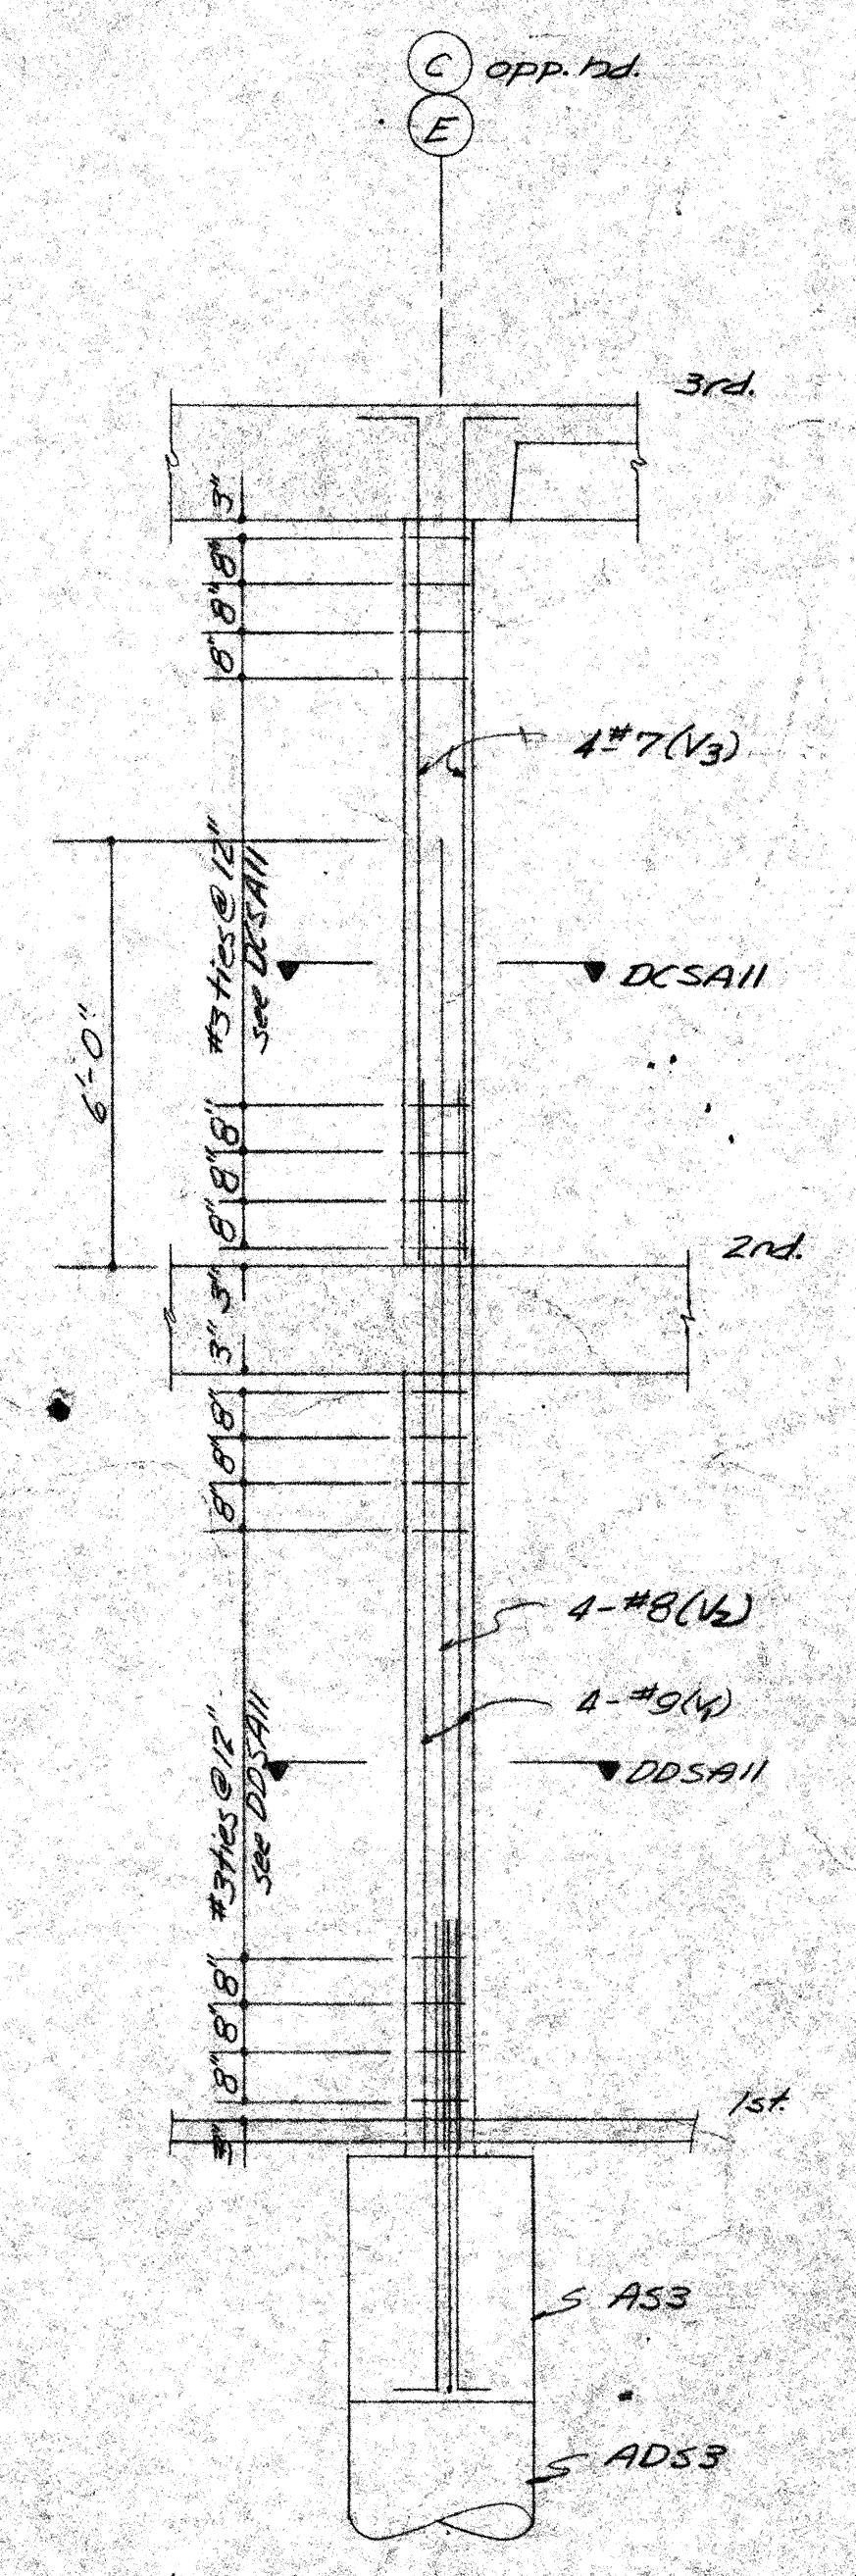


PLAN
DCSAII 3/4"=1'-0"


PLAN
DDSAII 3/4"=1'-0"

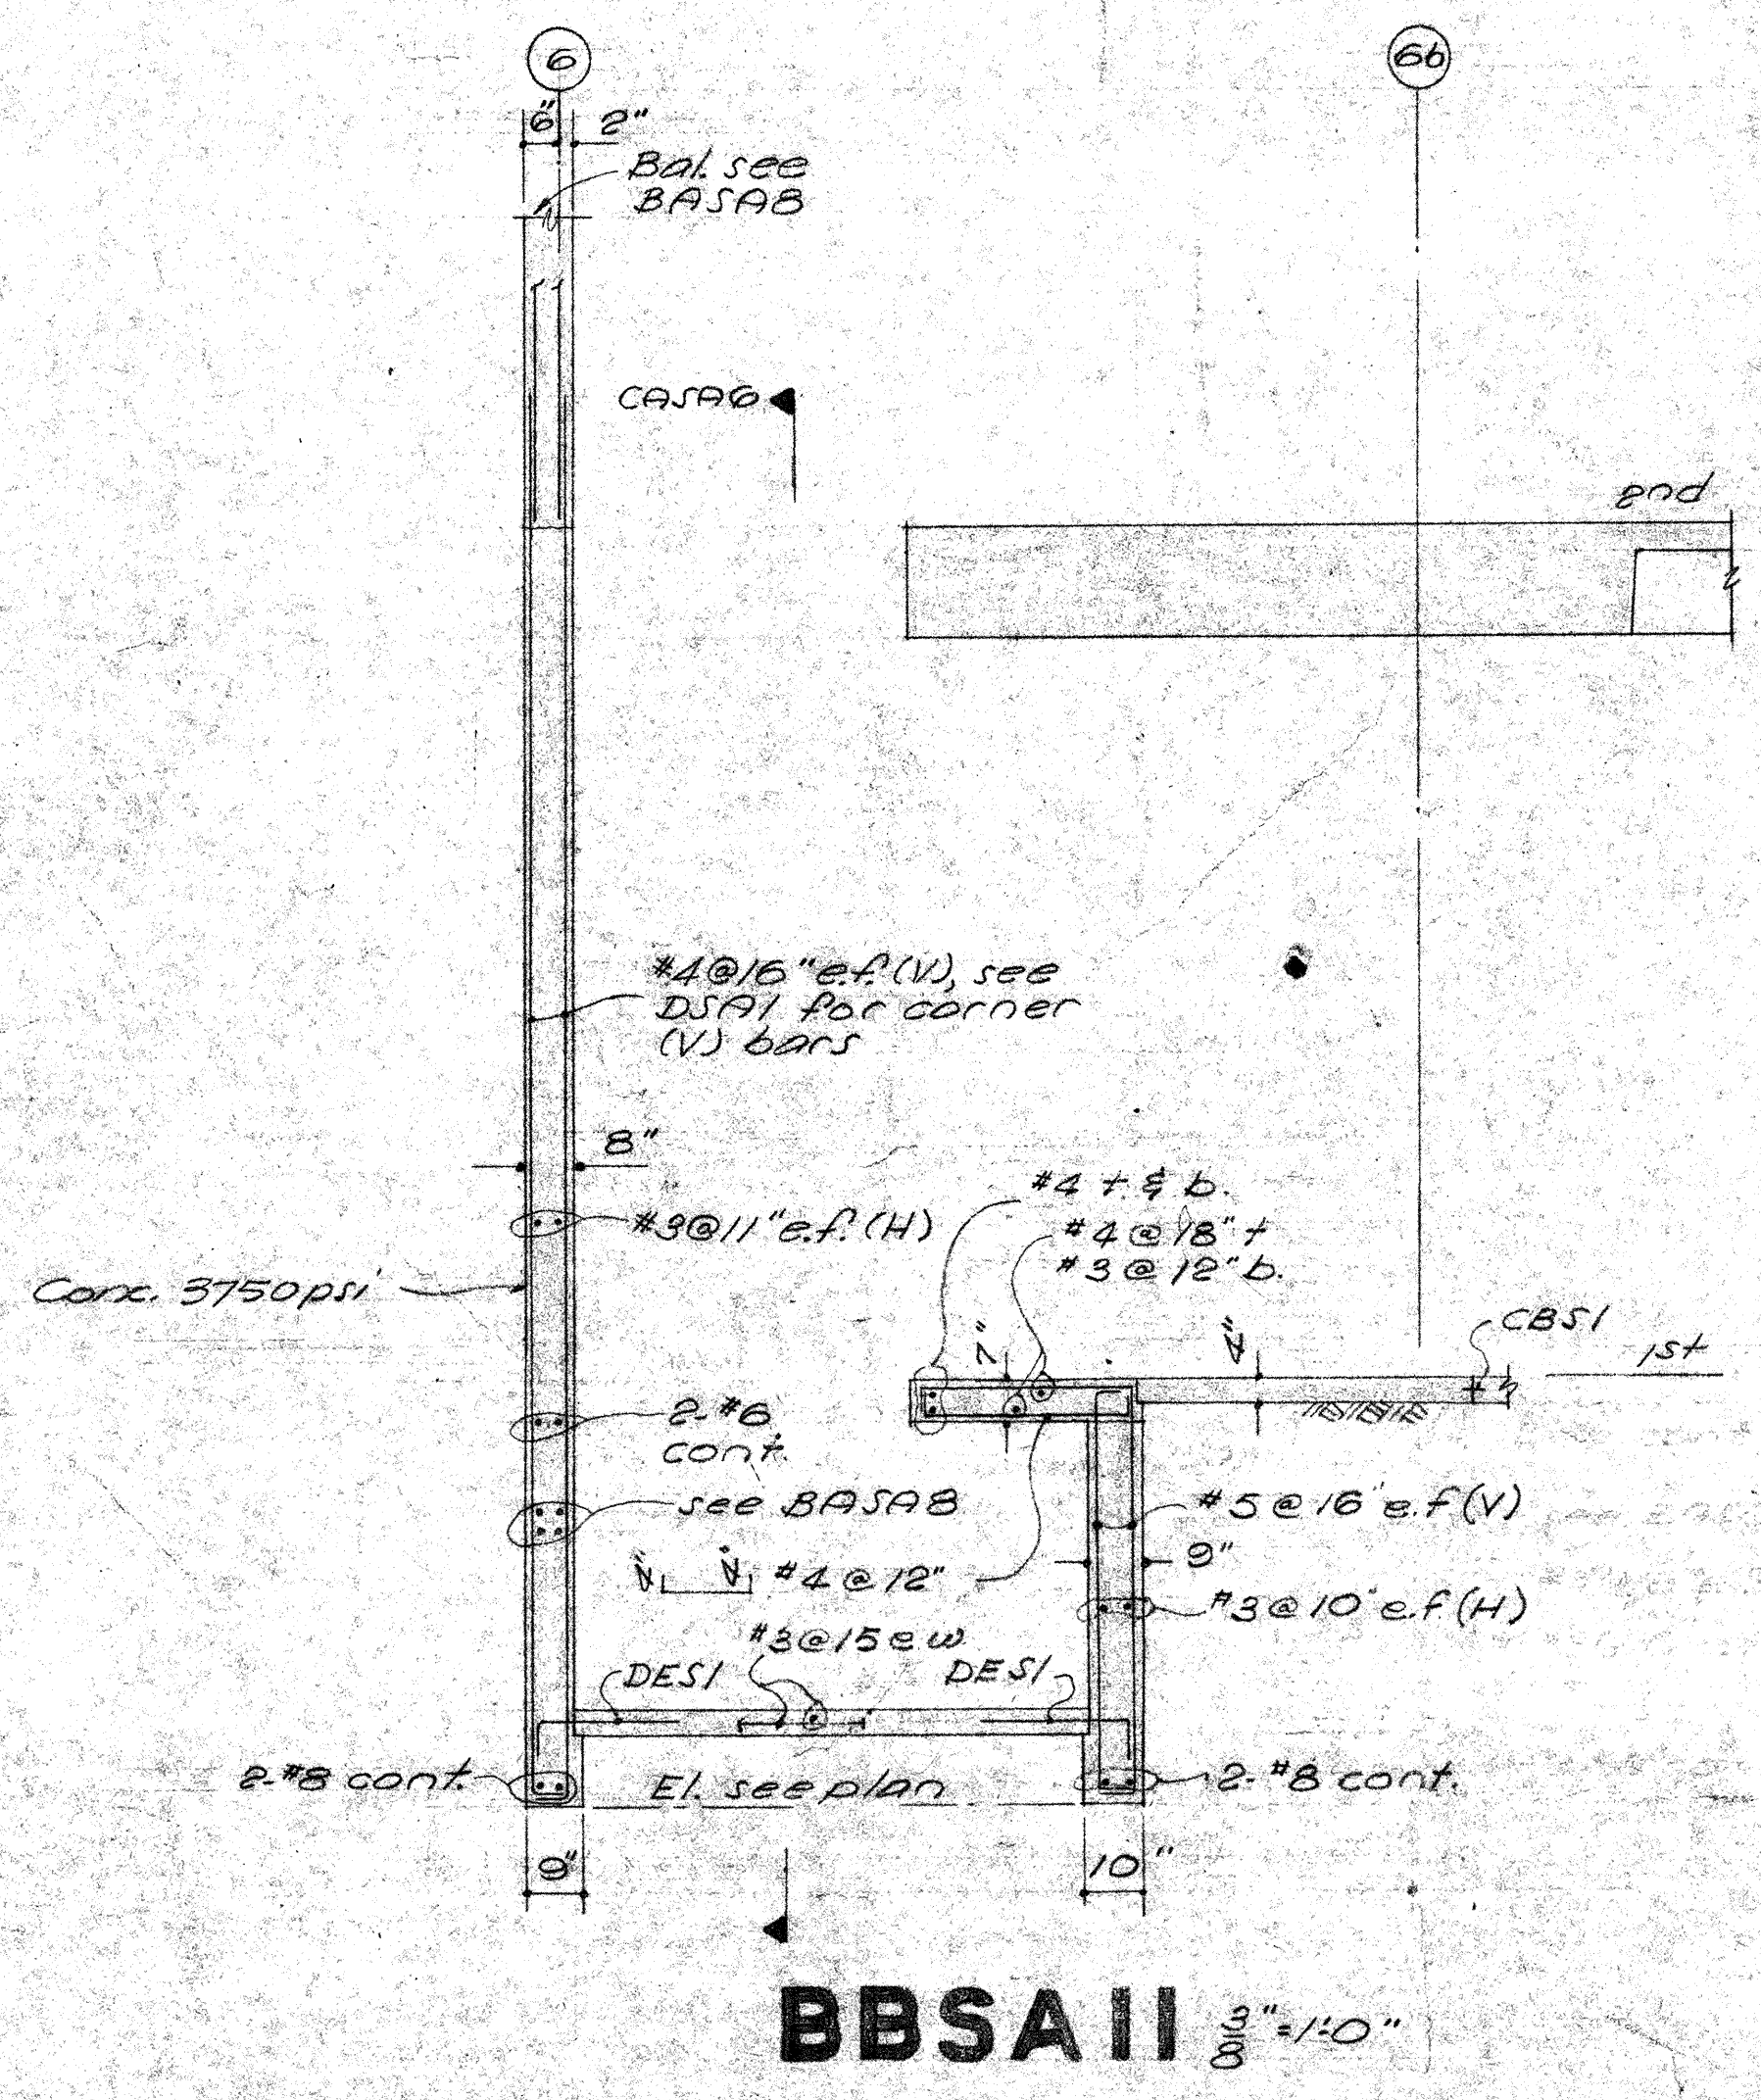


BBSAII 3/8"=1'-0"

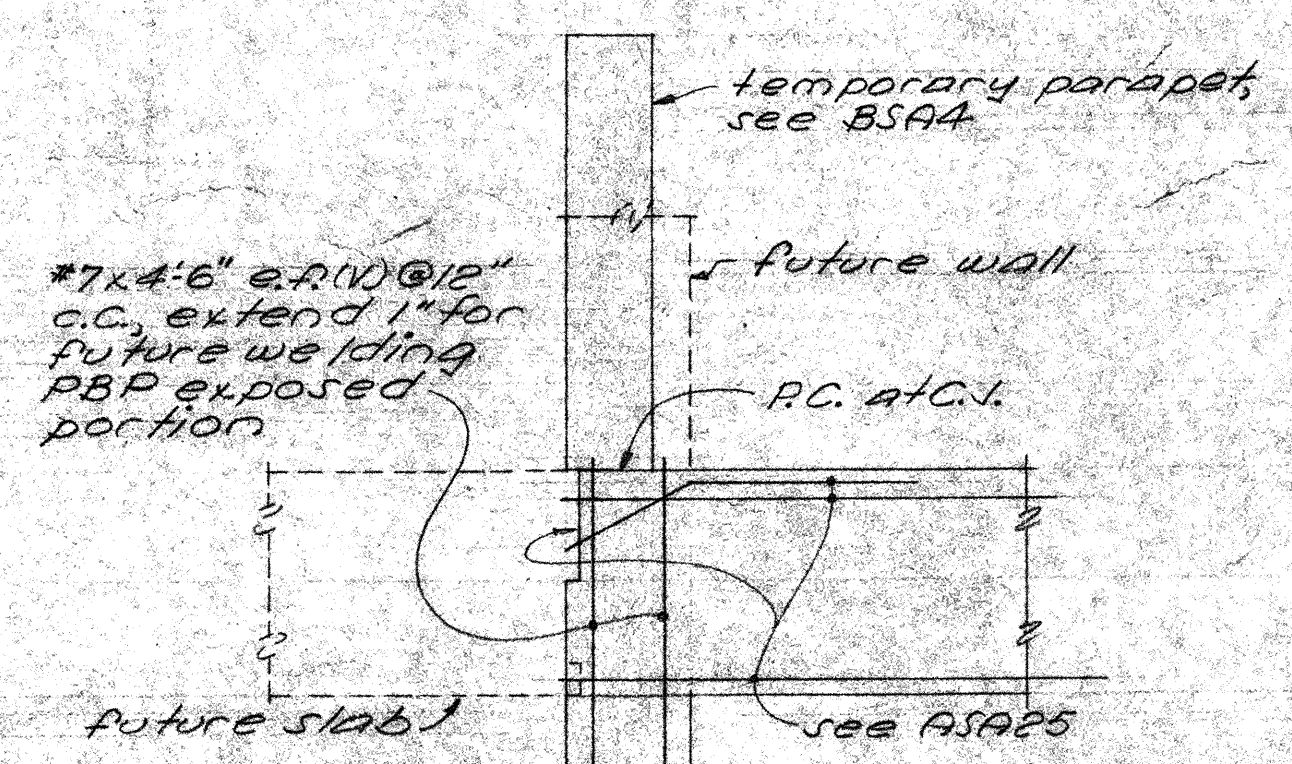


AASII 3/8"=1'-0"

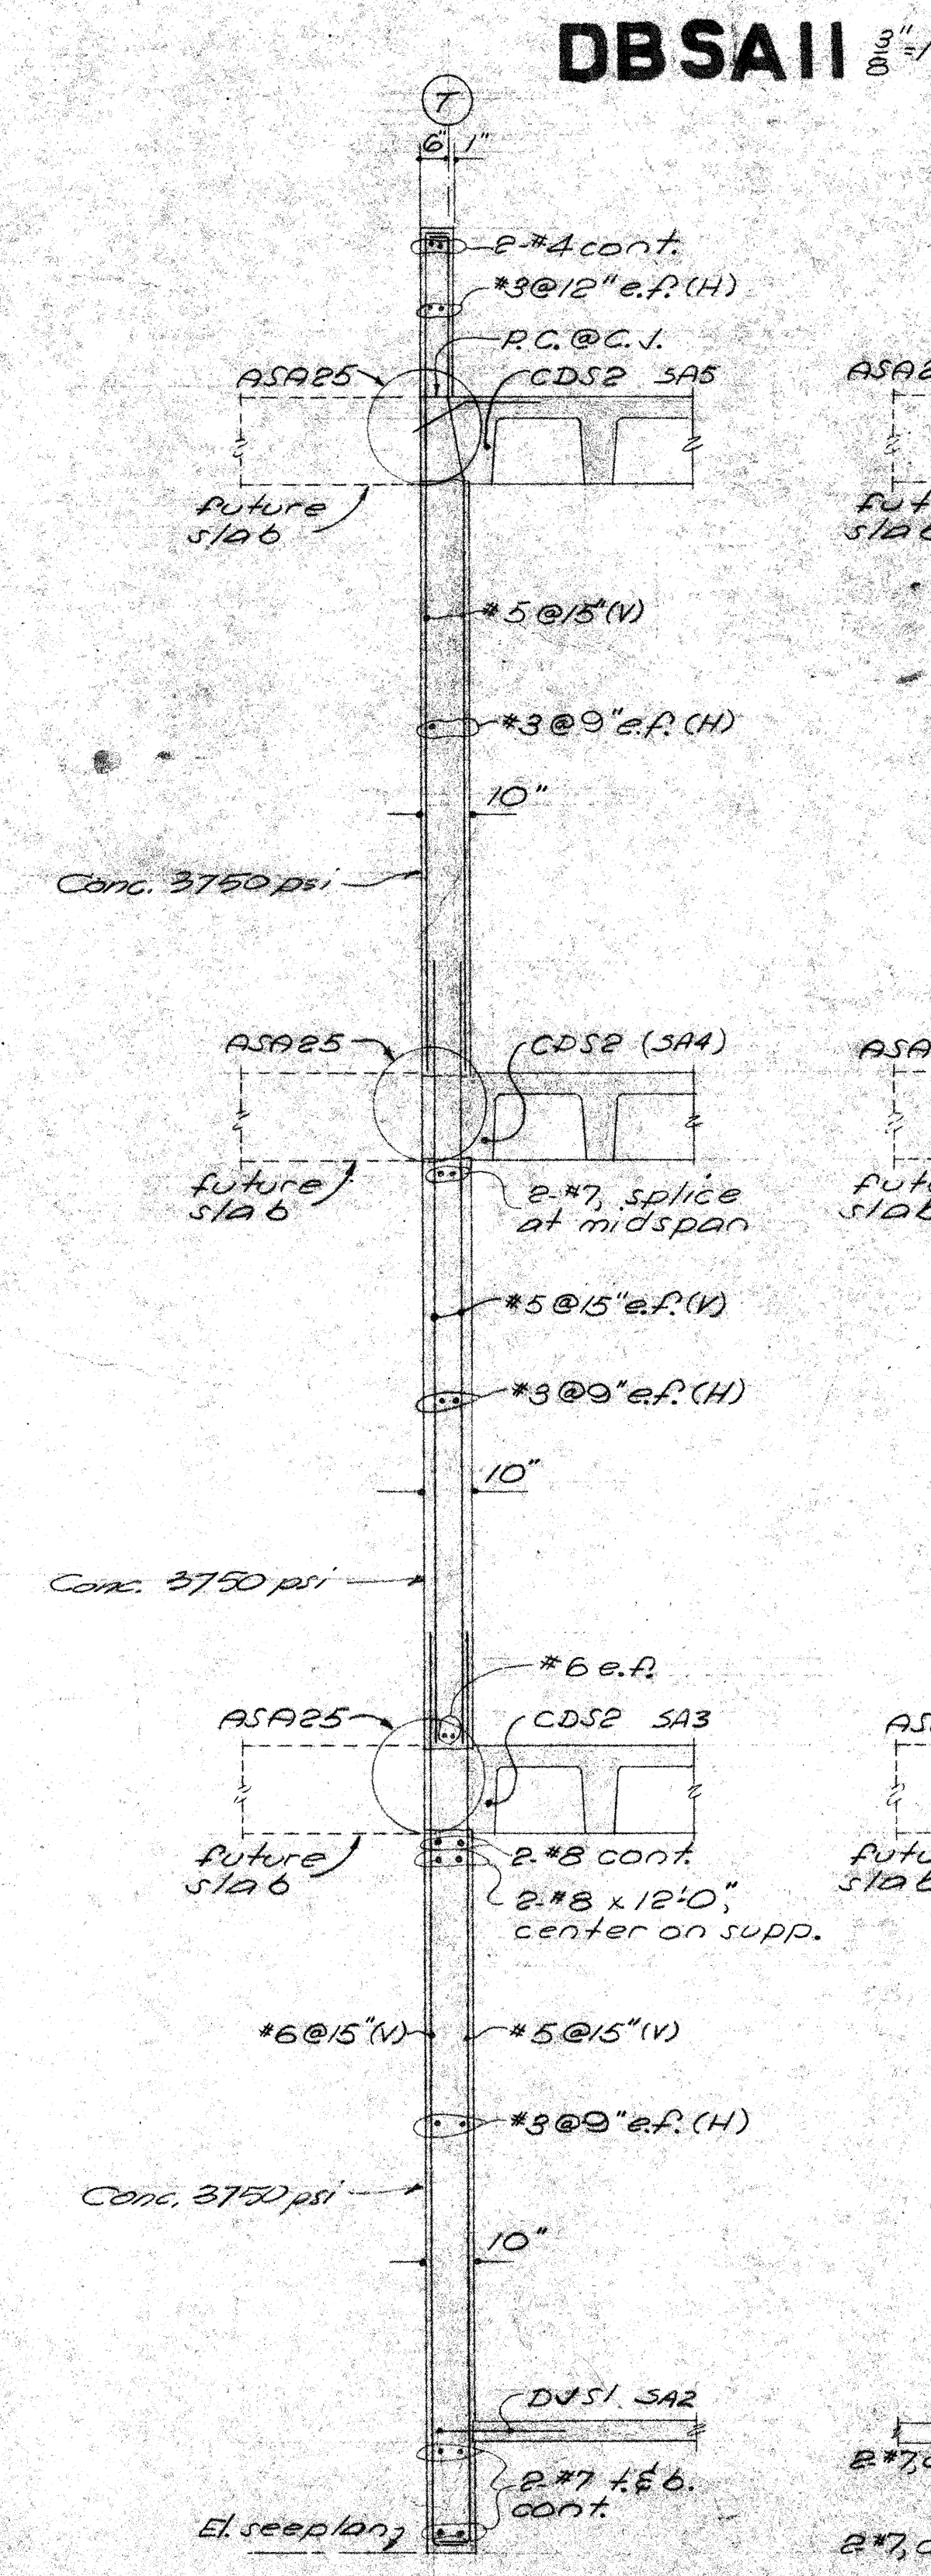


DASAII 3/8"=1'-0"

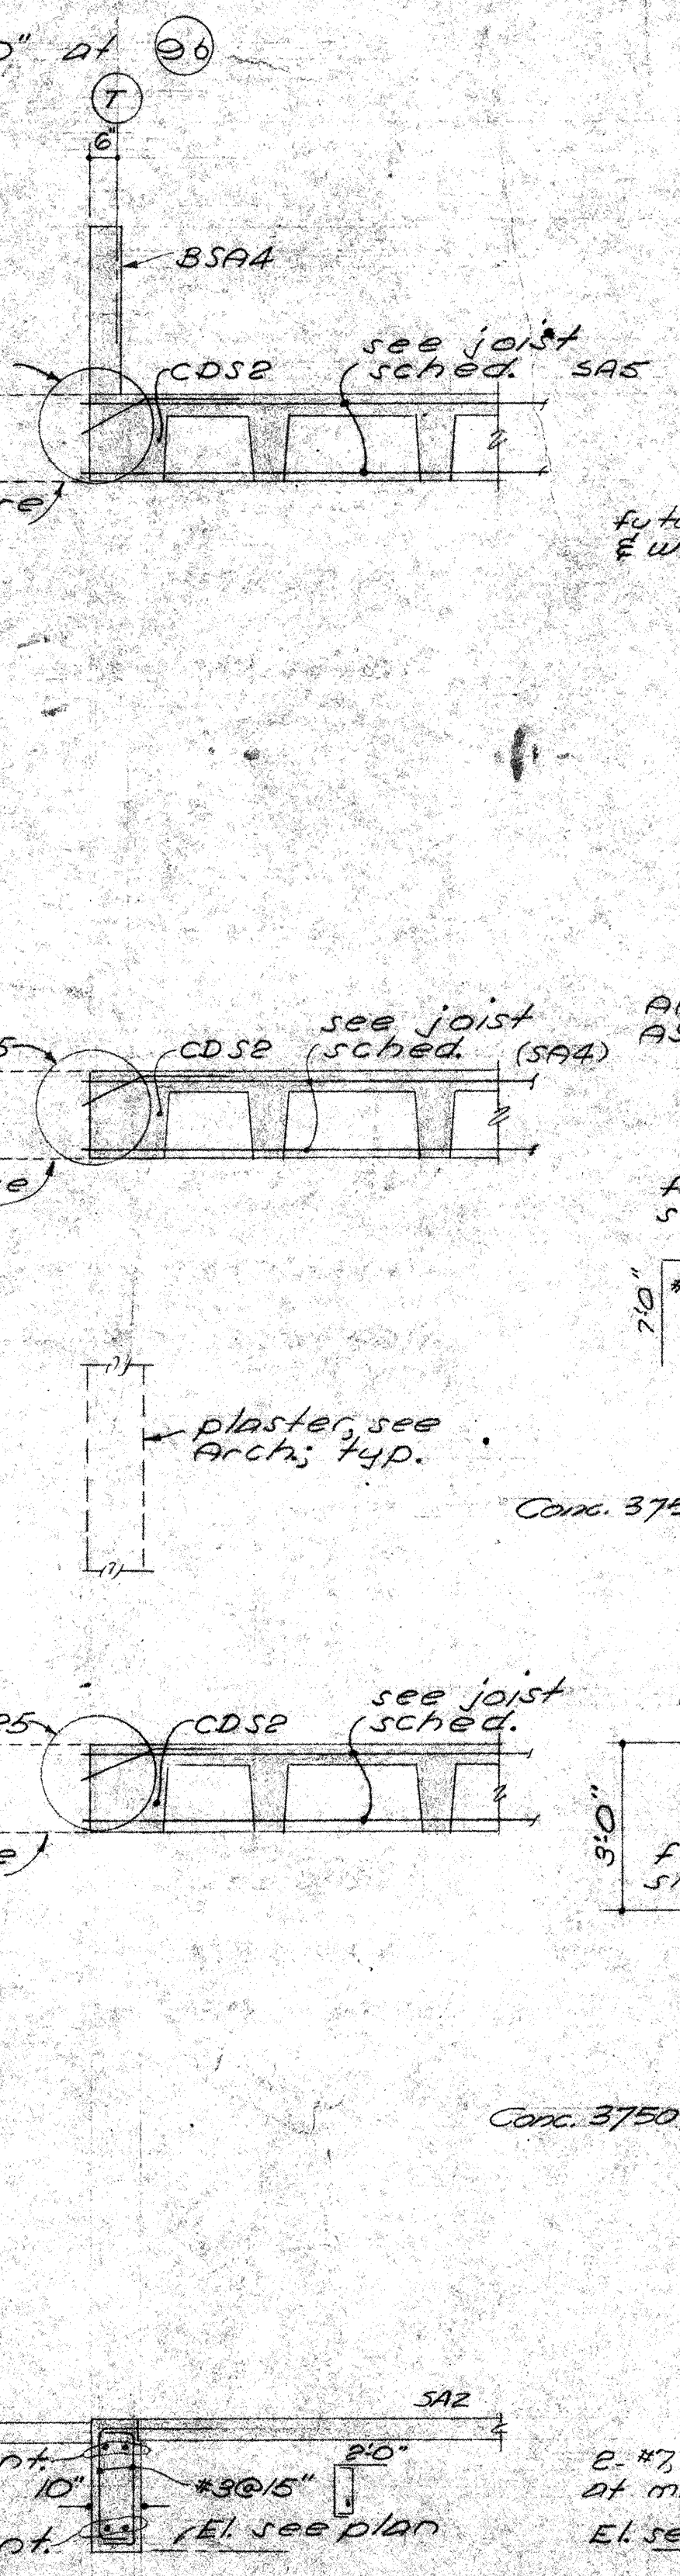


DSAII 3/8"=1'-0"

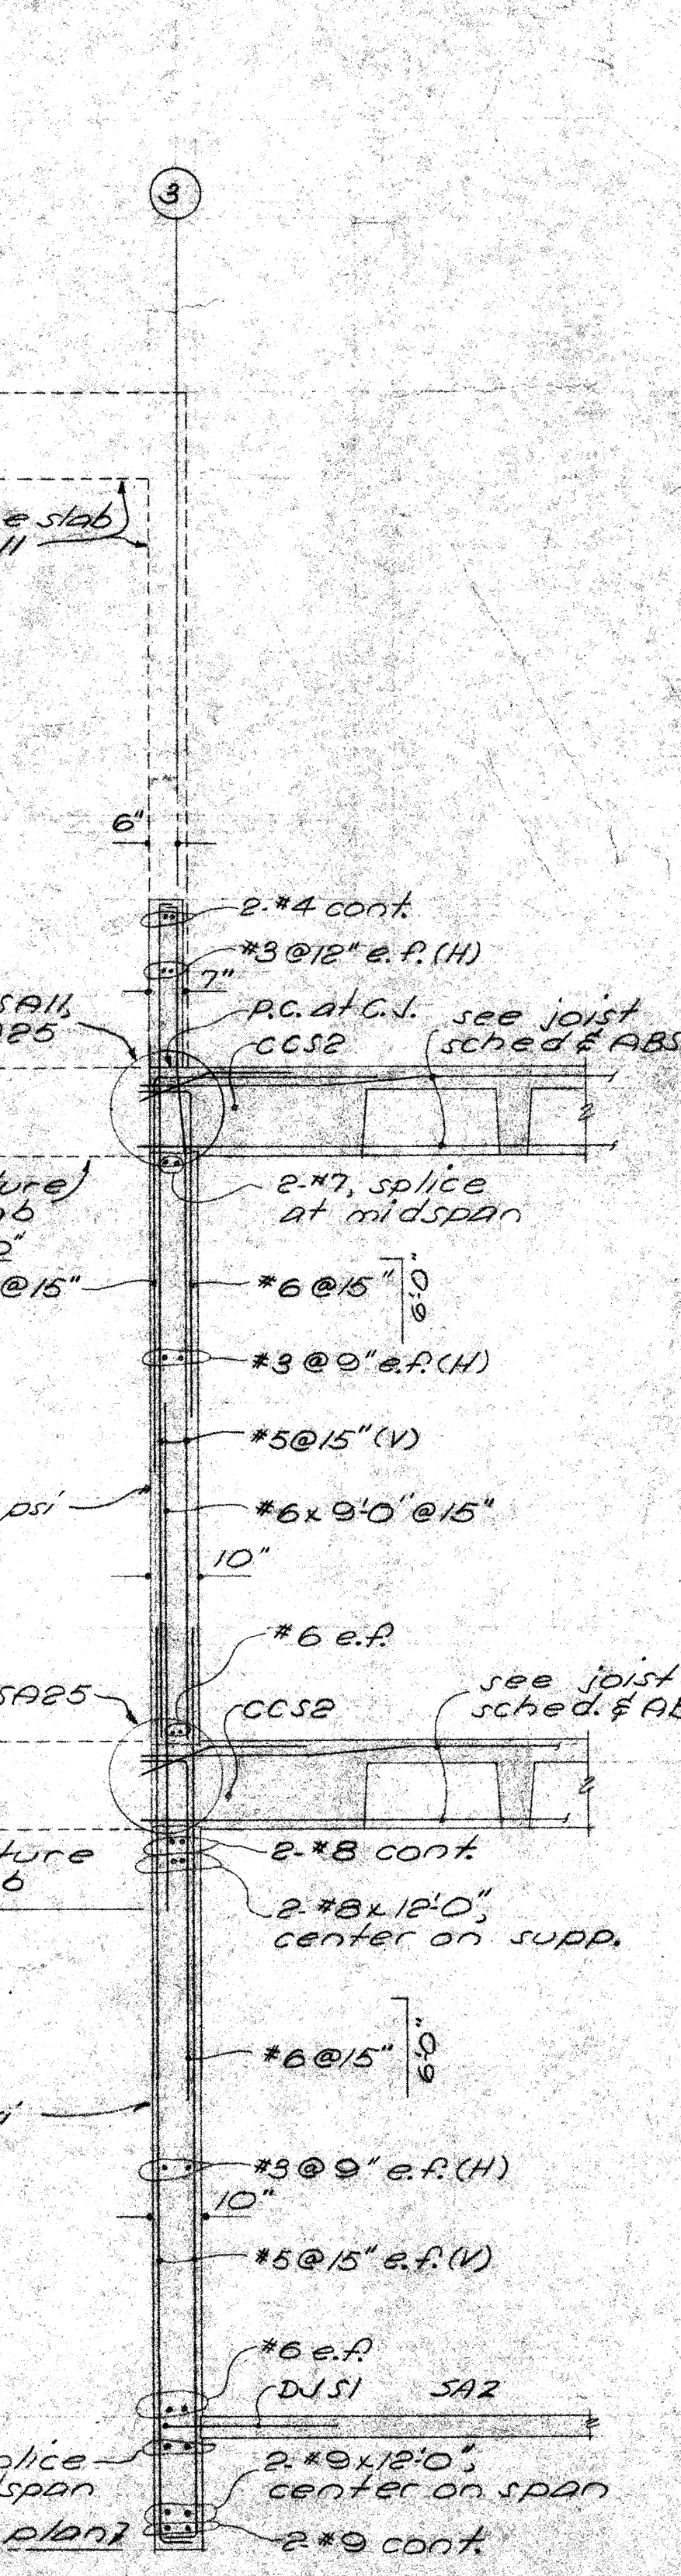


CSAII 3/8"=1'-0"

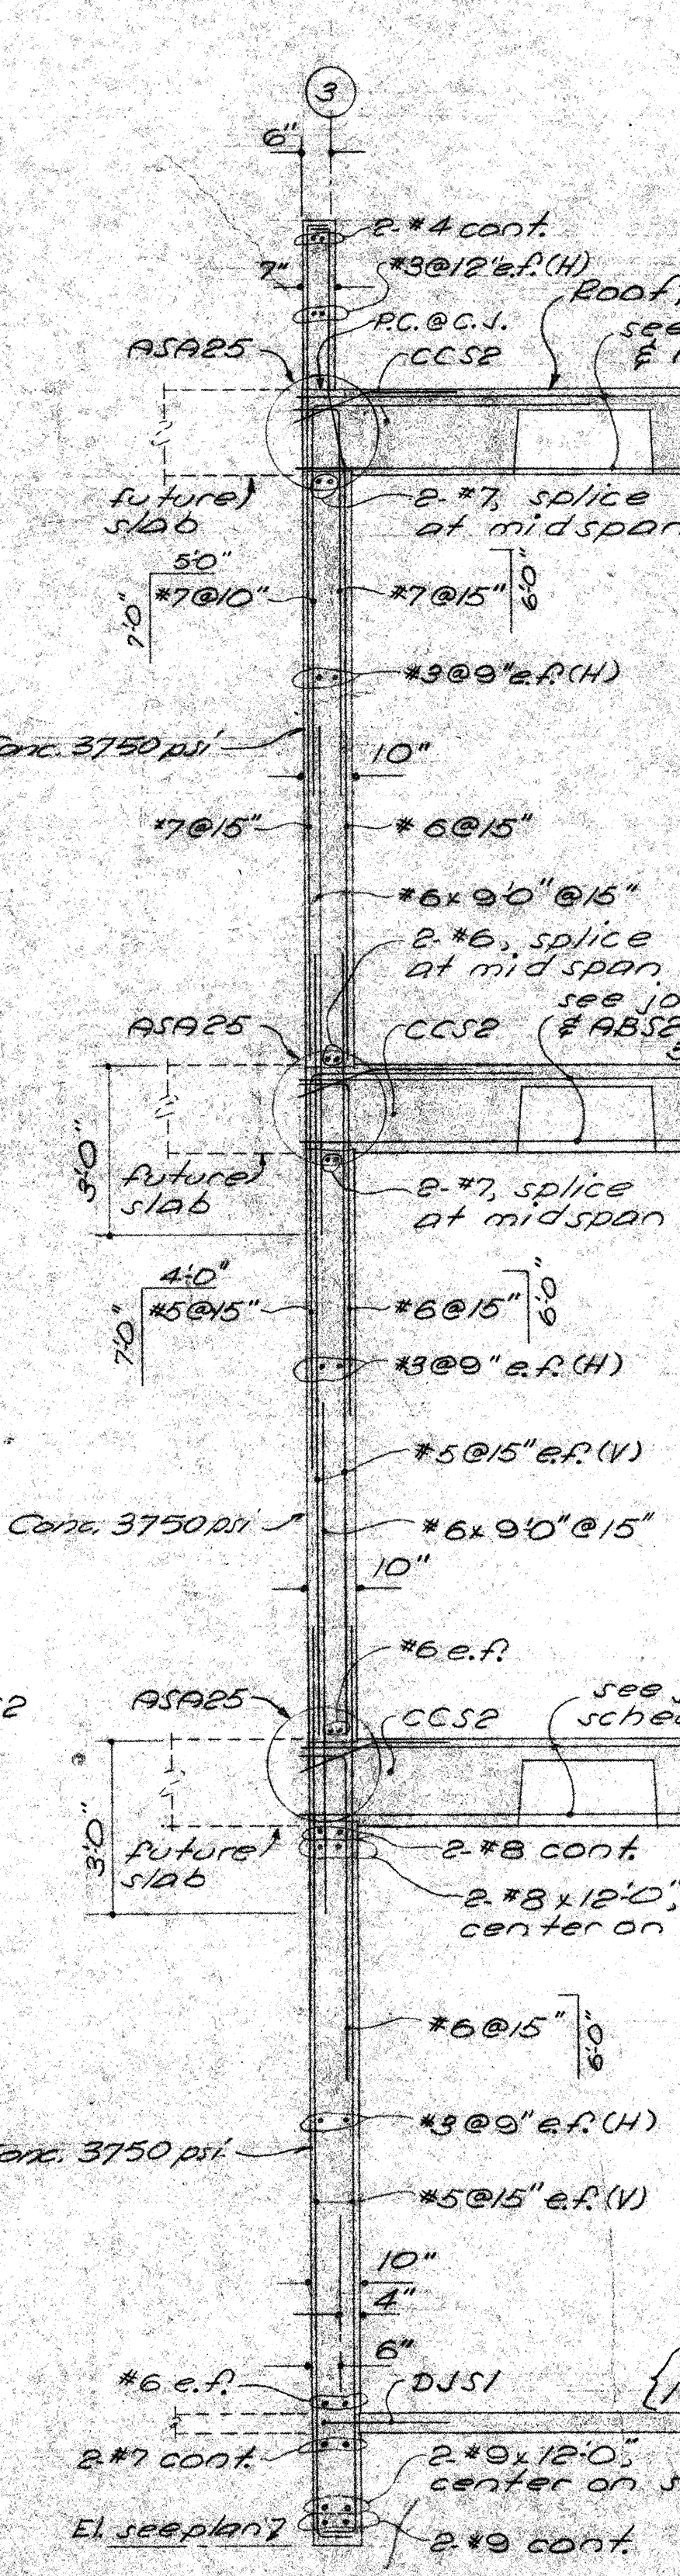


BASAII 3/8"=1'-0"

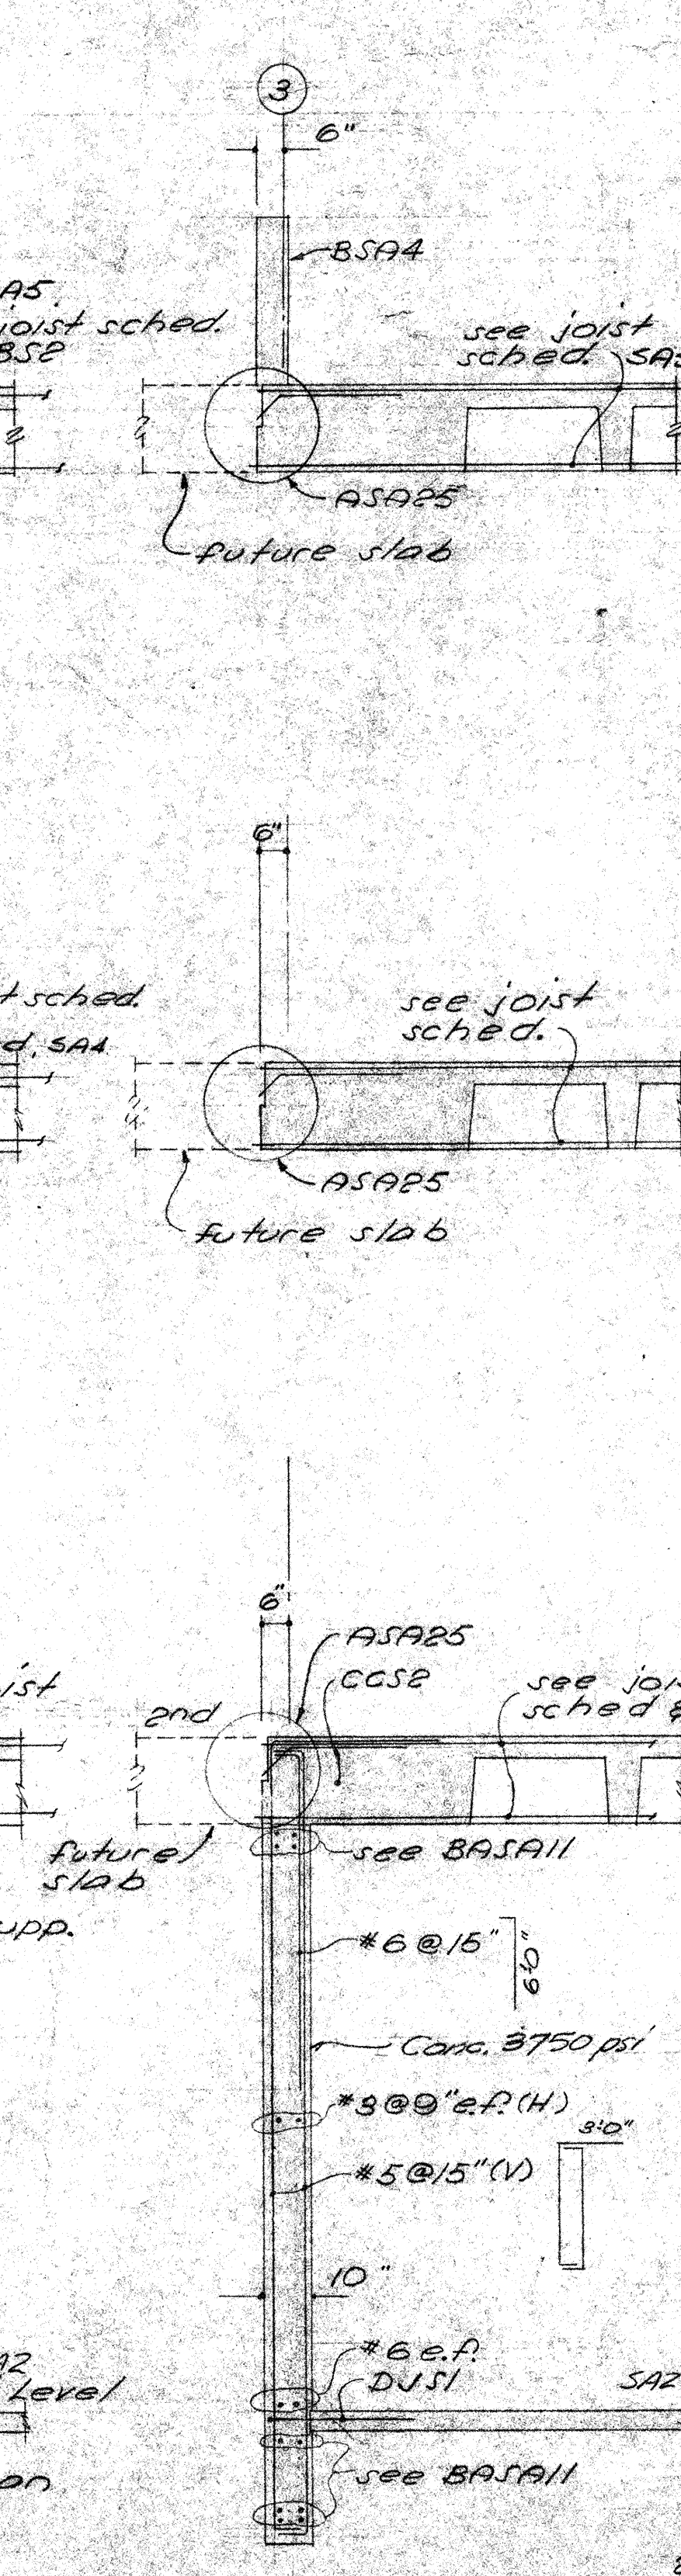

BSAAII 3/8"=1'-0"

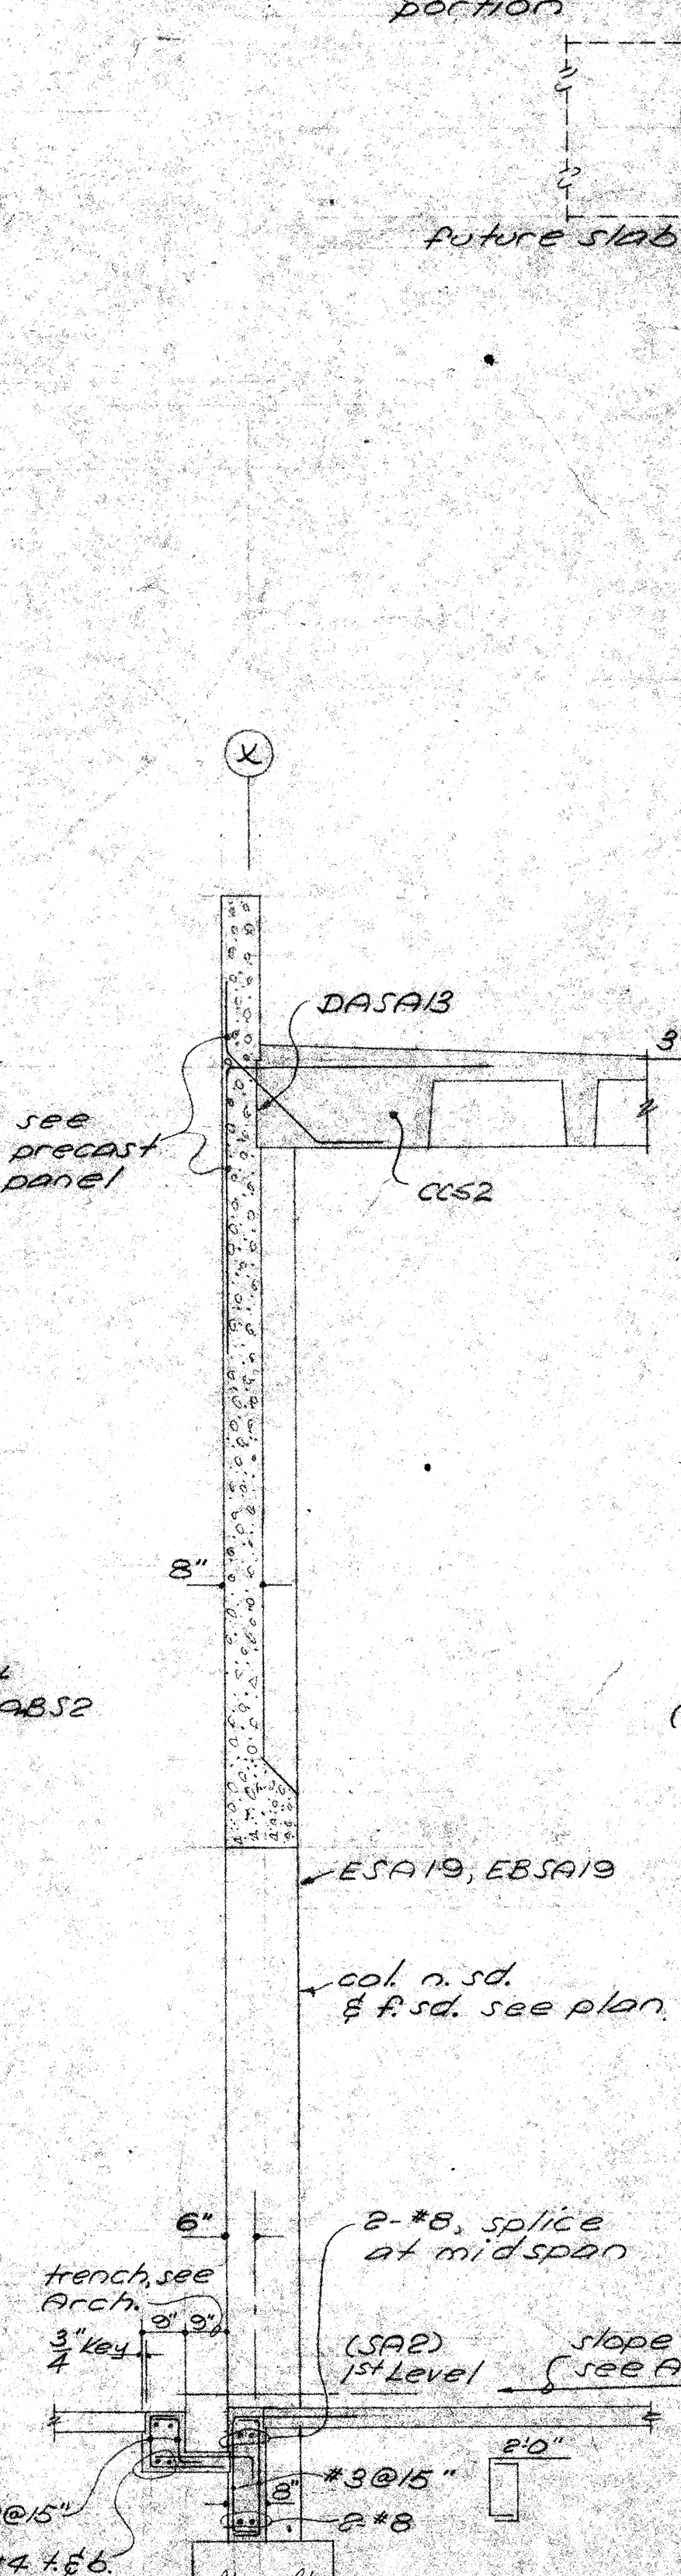

ABSAII 3/8"=1'-0"

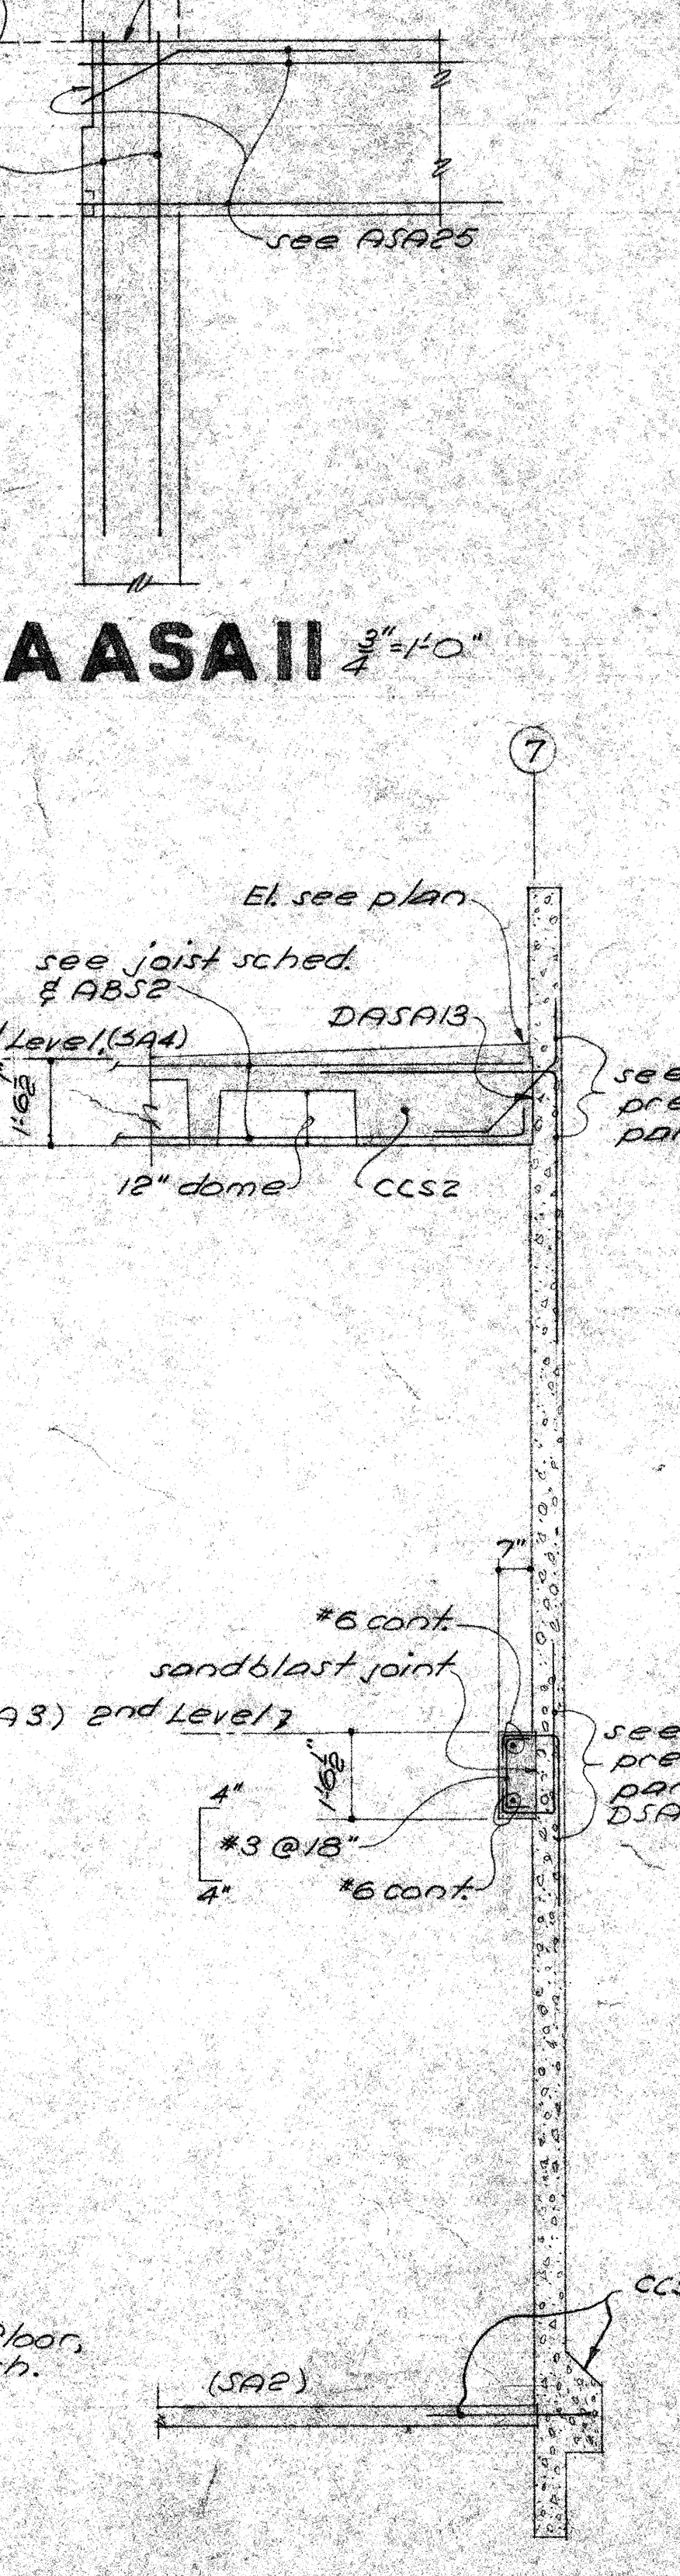

ASAAII 3/8"=1'-0"