

WALL FIRE DAMPER NTS 5


SECTION 3

SCALE 1/4"=1'-0"

3


SECTION 1

NOT TO SCALE 1

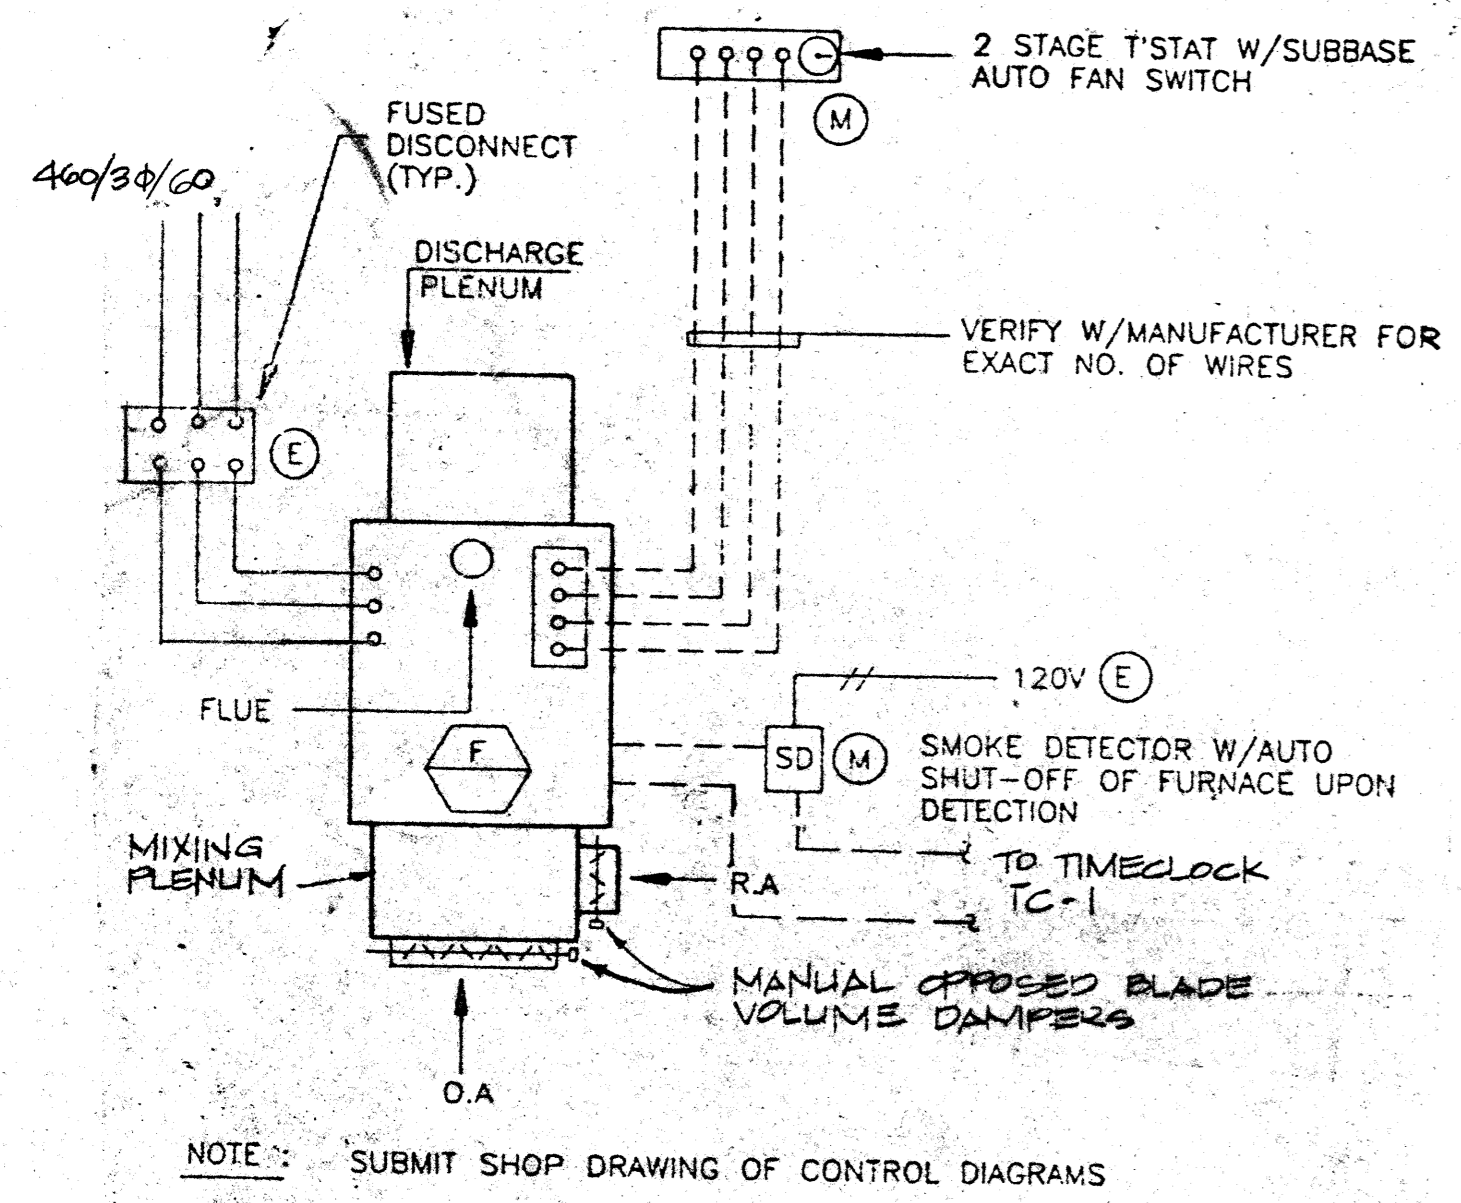

FURNACE

NOTE: REFER TO CONTROL NOTES FOR MORE INFORMATION.

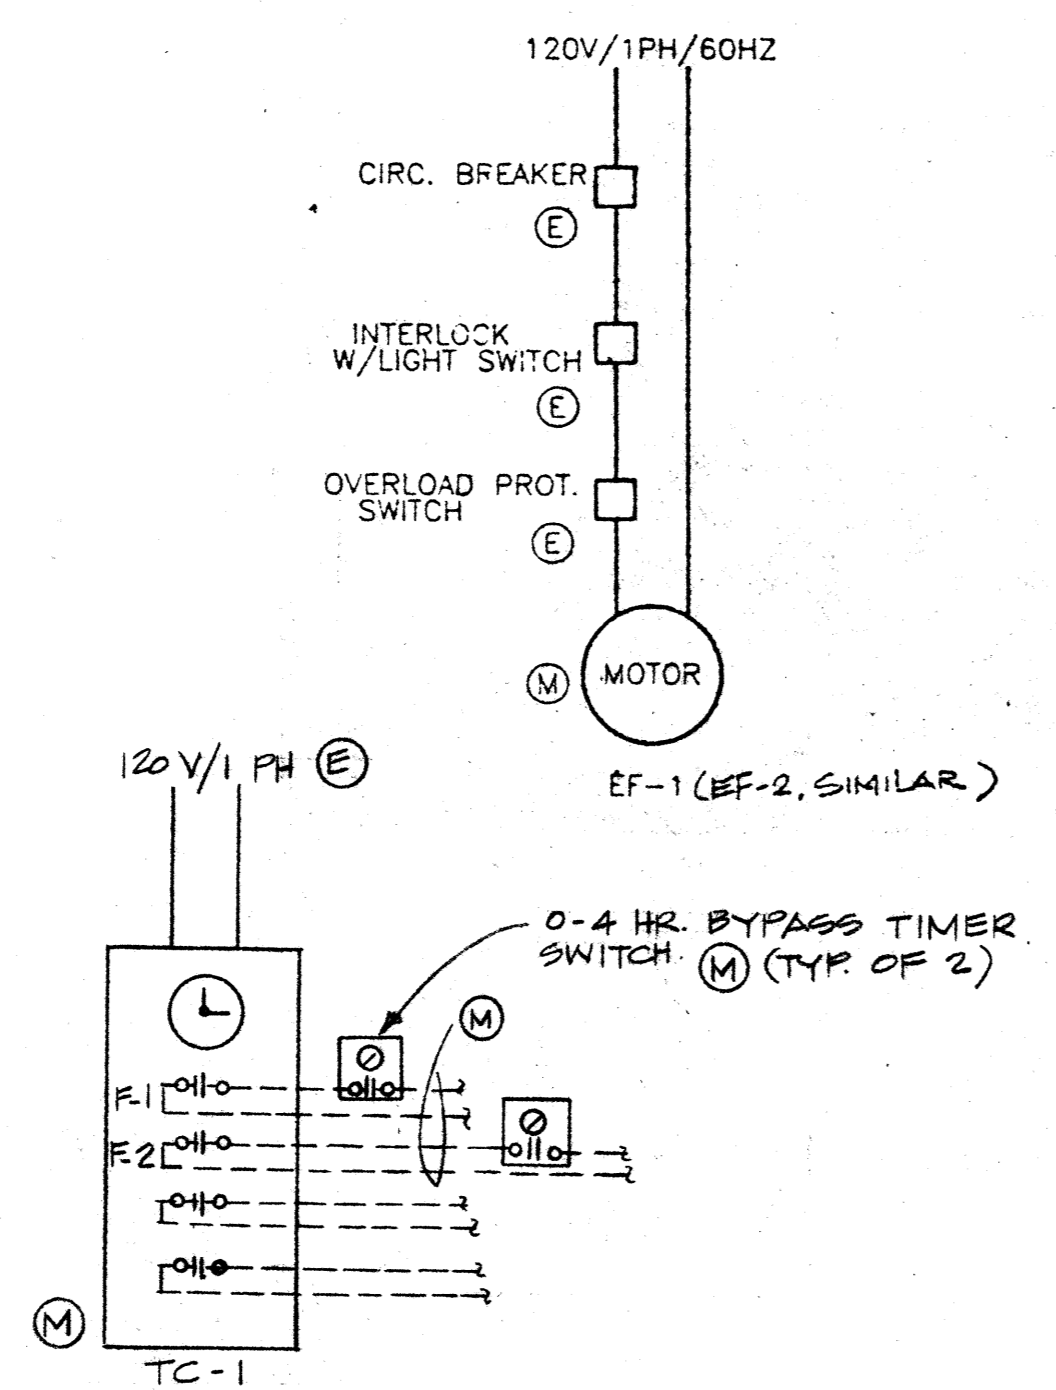


TIMECLOCK


DAYTON E2210 PROGRAMMABLE ELECTRONIC TIMECLOCK, A-CIRCUIT, BATTERY CARRY-OVER. PROVIDE SURGE SUPPRESSORS TO BE INSTALLED ACROSS EA. TIME SWITCH CONTACT.

CONTROLS

NOT TO SCALE 4

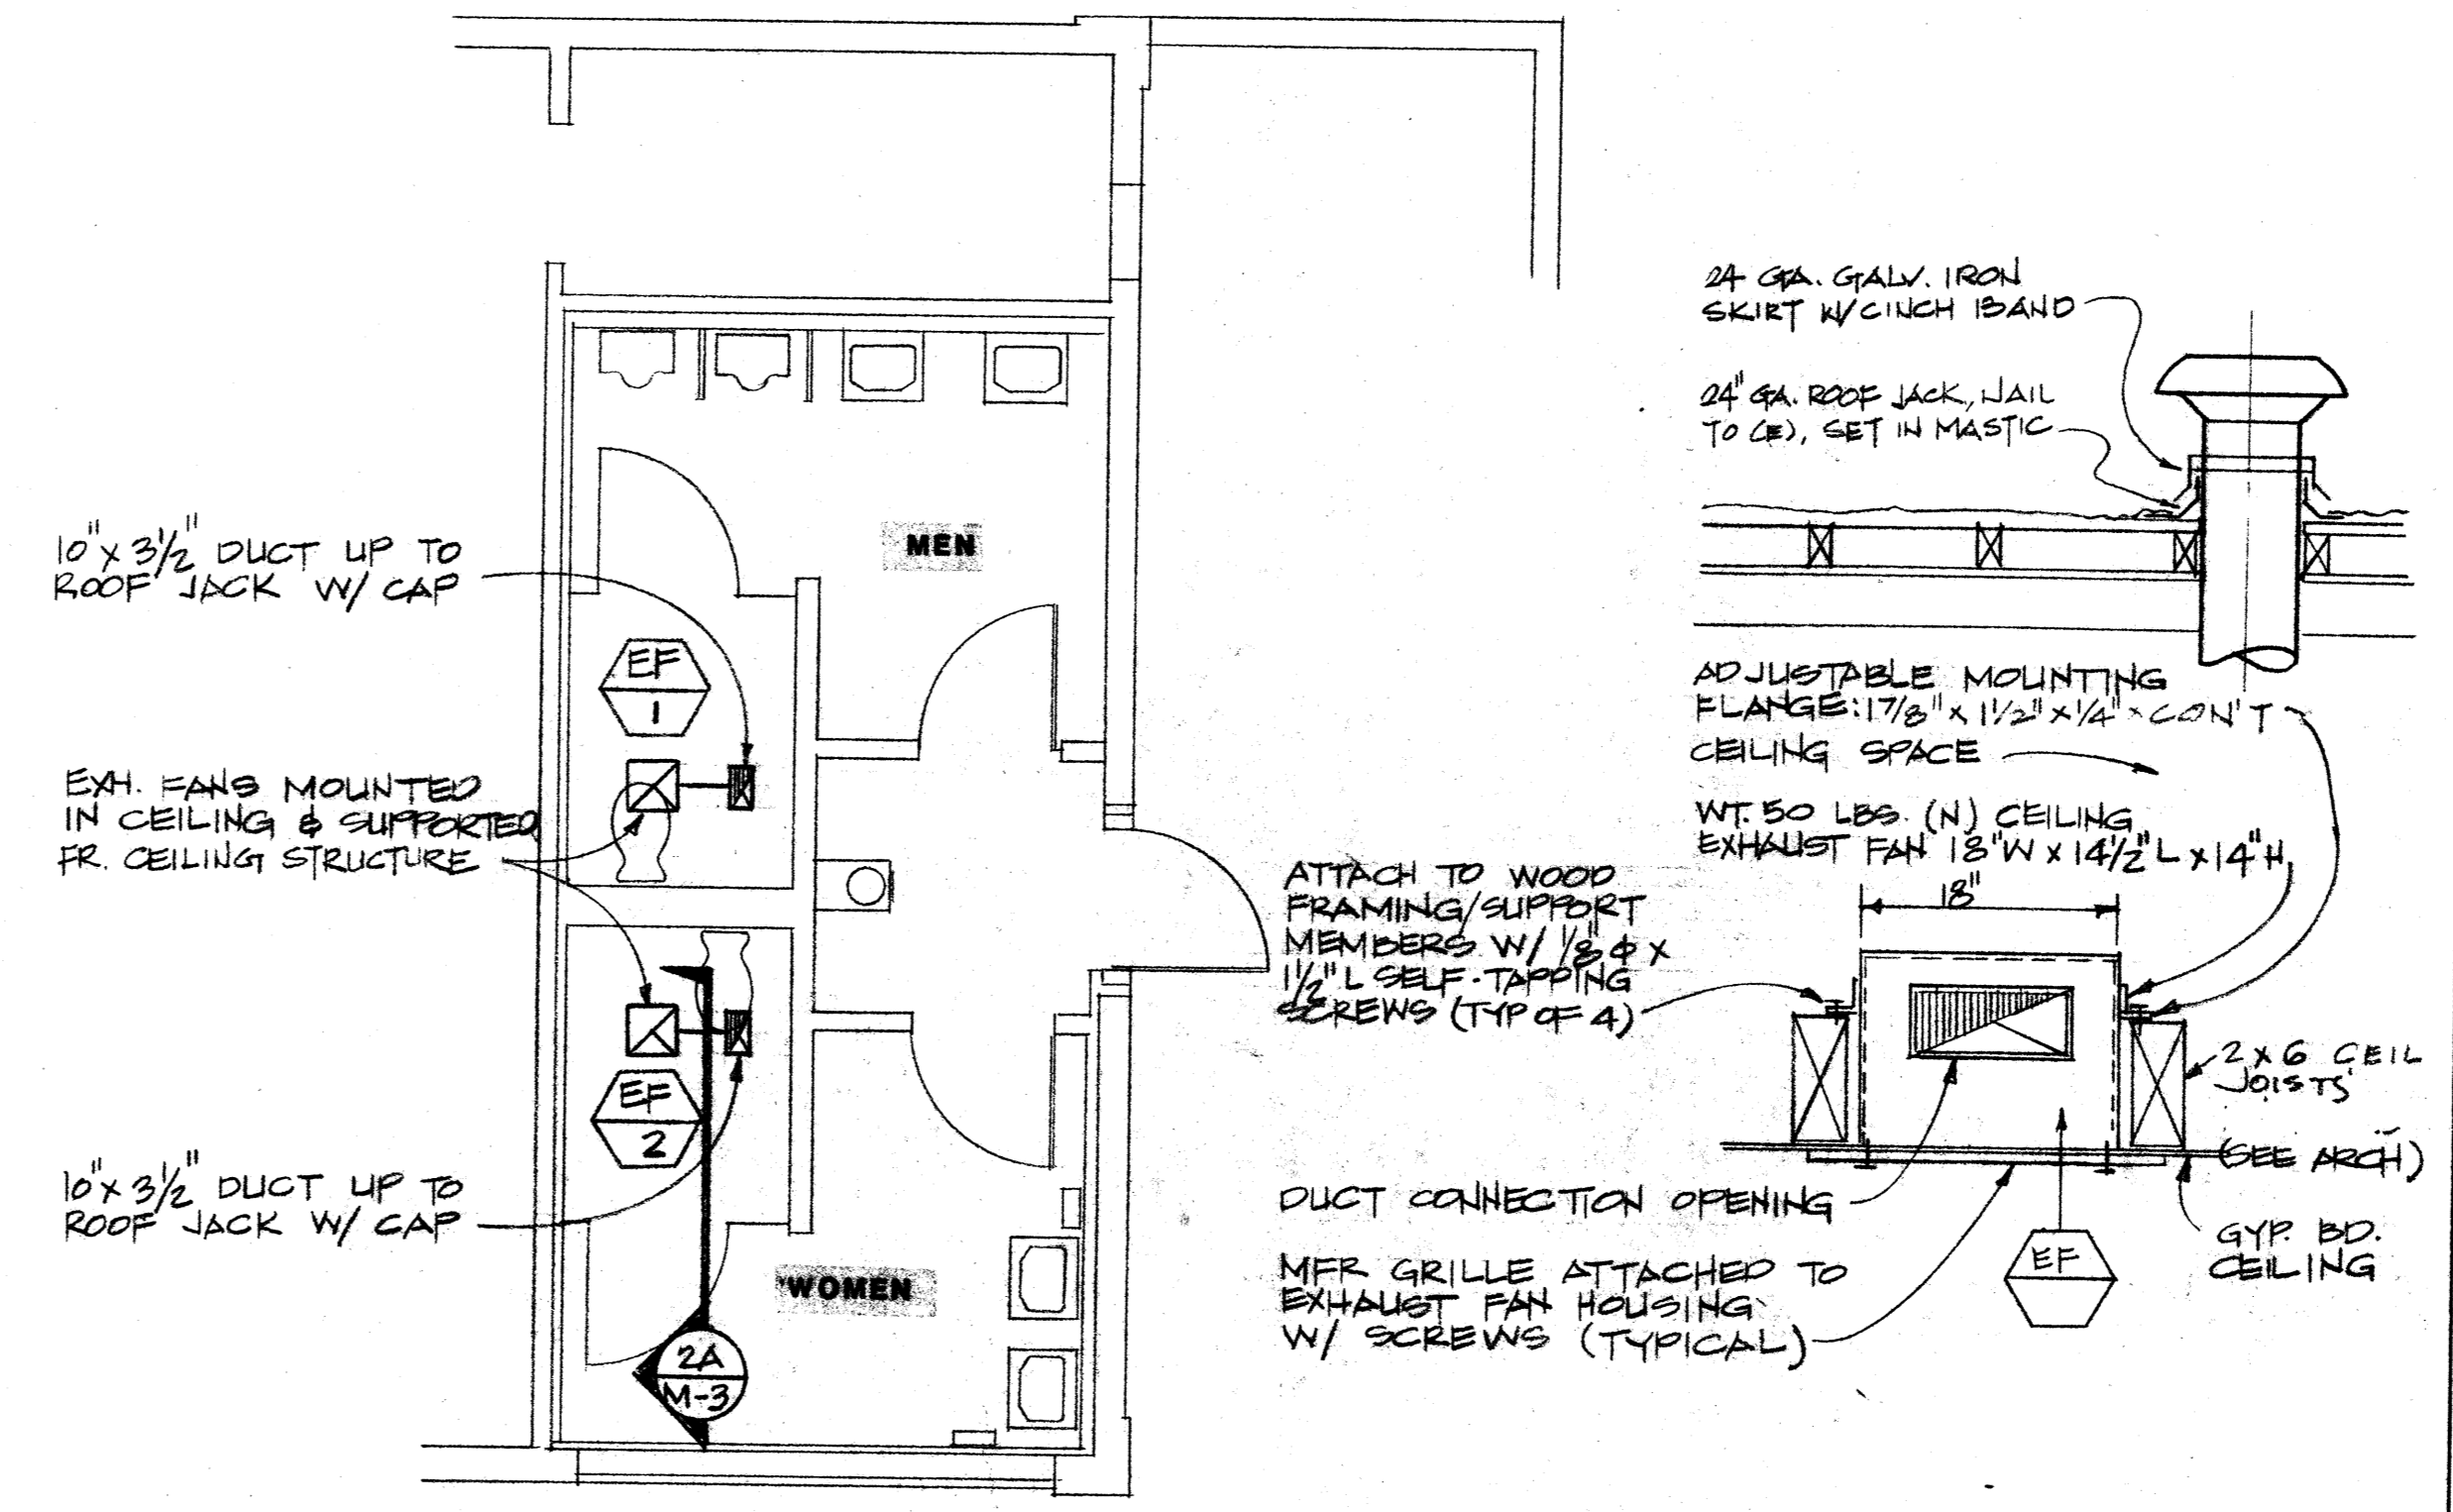

NOTE: SEE ARCH. DRAWINGS OR SHEET P-2 FOR LOCATION OF THESE ROOMS.

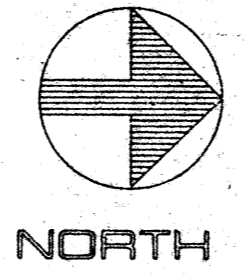

PARTIAL FLOOR PLAN - TOILETS AT (E) AUTO SHOP

SCALE 1/4"=1'-0"

2

USA STRUCTURAL SAFETY SECT
 IDENTIFICATION STAMP
 Department of General Services
 Office of the State Architect
 DEC 1 1980
 53721
 USA STATE FIRE MARSHAL

NOTES

- CONTROL NOTES :
- ALL WIRING TO CONFORM TO LOCAL CODES.
 - POWER WIRING BY ELECTRICAL CONTRACTOR.
 - LOW VOLTAGE BY MECHANICAL CONTRACTOR. THE FINAL CONNECTION AND SUPERVISION OF ALL CONTROL WIRING SHALL AND INTERLOCK WIRING SHALL BE RESPONSIBILITY OF TEMPERATURE CONTROL CONTRACTOR.
 - (M) FURNISHED AND INSTALLED BY MECHANICAL CONTRACTOR.
 - (E) FURNISHED AND INSTALLED BY ELECTRICAL CONTRACTOR.
 - COORDINATE WITH ELECTRICAL CONTRACTOR PRIOR TO FINALIZING THE BID.
 - THIS DRAWING IS FOR COORDINATION ONLY. THE TEMPERATURE CONTROL CONTRACTOR IS FULLY RESPONSIBLE FOR THE COMPLETE TEMPERATURE CONTROL SYSTEM AND SHOULD INCLUDE IN HIS BID ALL NECESSARY ITEMS WHETHER SHOWN HERE OR NOT.
 - ALL THERMOSTATS SHALL BE CAPABLE OF BEING SET TO MAINTAIN SPACE TEMPERATURE SET POINT FROM LOW OF 55°F AND SHALL BE CAPABLE OF TERMINATING ALL HEATING ABOVE 70°F
 - REFER TO MANUFACTURER'S LITERATURE REGARDING ACTUAL WIRING REQ'D
 - PROVIDE LOCKING COVER FOR THERMOSTATS FOR ALL SYSTEMS SERVING ALL AREAS.
 - ALL SMOKE DETECTORS TO BE FURNISHED AND INSTALLED BY MECHANICAL CONTRACTOR. ELECTRICAL CONTRACTOR TO WIRE THEM.
 - MECHANICAL CONTRACTOR TO VERIFY TEMPERATURE CONTROLS WITH ACTUAL MANUFACTURER'S CONTROL DIAGRAMS.
 - MECHANICAL CONTRACTOR TO PROVIDE DETAILED WIRING DIAGRAM FOR REVIEW AND COORDINATION WITH ELECTRICAL CONTRACTOR. 7 COPIES REQUIRED.
 - FINAL THERMOSTAT LOCATIONS TO BE COORDINATED WITH FURNITURE LAYOUT, SHOWN ON SHOP DRAWINGS AND SIGNED OFF BY THE OWNER.

CALIFORNIA STATE FIRE MARSHAL
 APPROVED
 12-11-80
 REGISTERED PROFESSIONAL ENGINEER
 P. TRIFUNOVIC
 No. 110862
 MECHANICAL
 STATE OF CALIFORNIA

ENCON
 ENERGY CONSERVATION COMPANY
 4940 EL CAMINO REAL, SUITE 203
 LOS ANGELES, CALIFORNIA 90024 U.S.A.
 TEL: (415) 961-8885

KELLER AND DASEKING - ARCHITECTS
 WALTER L. KELLER A.I.A.
 WILLIAM H. DASEKING A.I.A.
 822 OAK GROVE AVENUE
 MENLO PARK, CA 94025 415/322-5866
 C-1334

AUTOMOTIVE CLASSROOM BUILDING
 TOILET ROOM RENOVATIONS
 SKYLINE COLLEGE
 SAN MATEO COUNTY COMMUNITY COLLEGE DISTRICT

8906
 12-12-90
 M-3
 23 of 41