



KEYED NOTES

1 CONNECT THE NEW COLD WATER LINES TO THE EXISTING AND COLD WATER LINES.

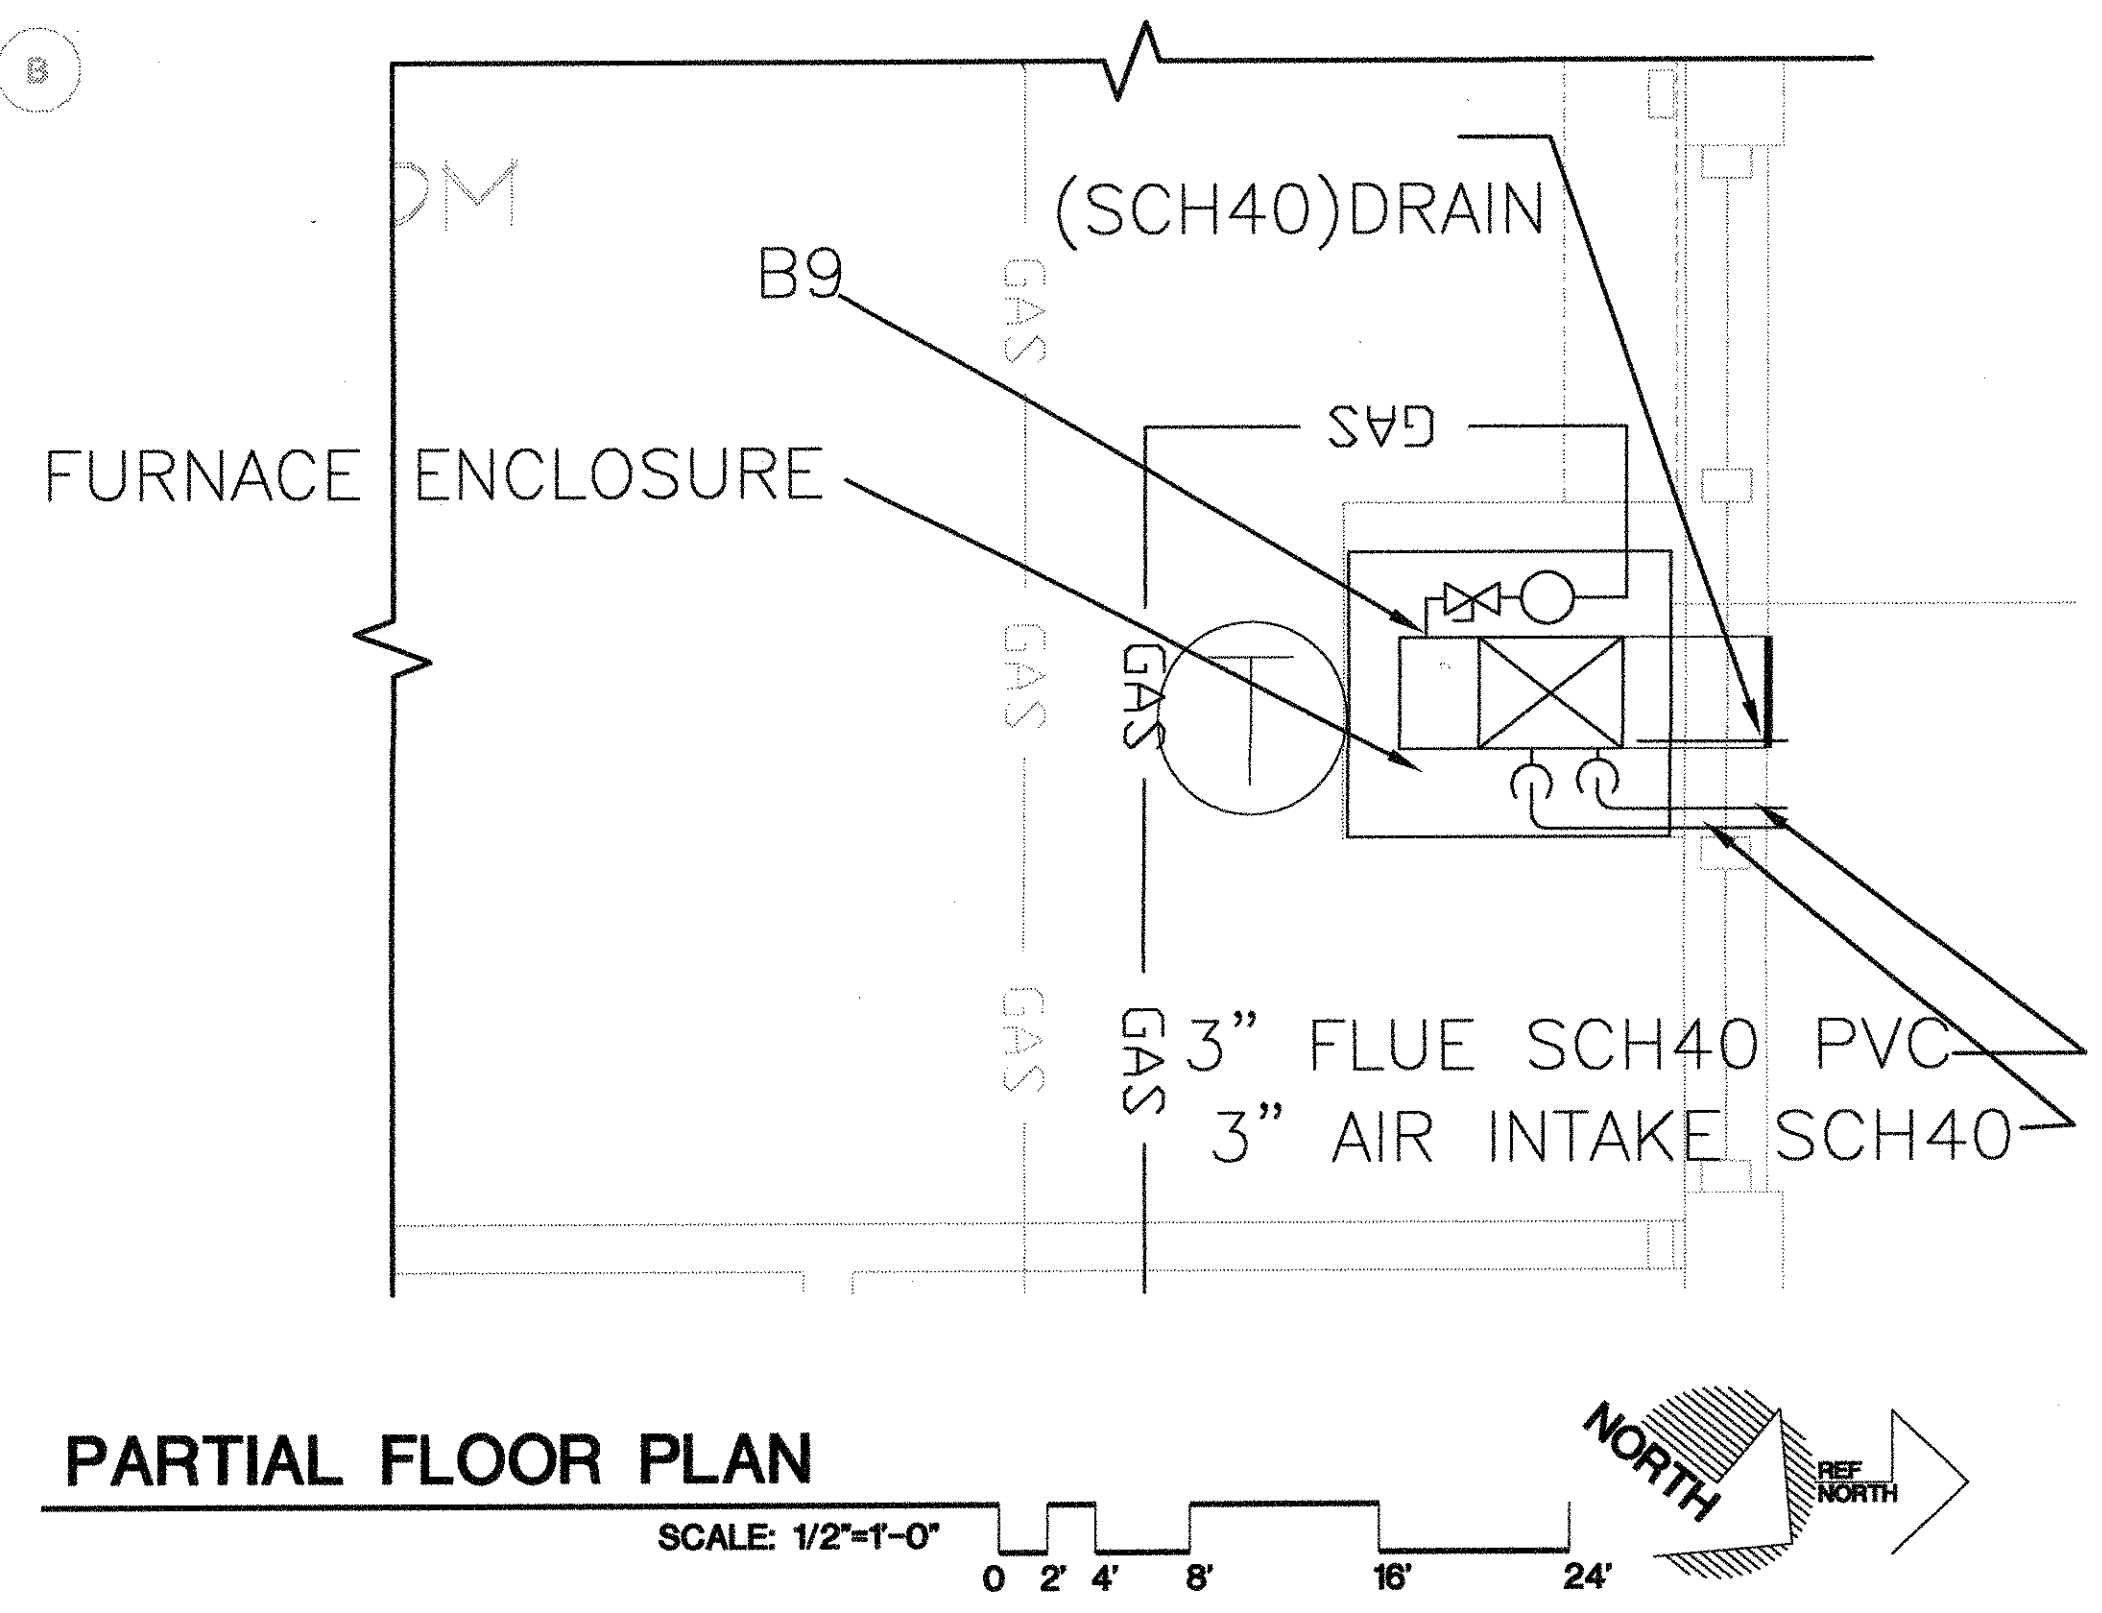


PARTIAL FLOOR PLAN

SCALE: 1/2"=1'-0" 0 2' 4' 8' 16' 24'

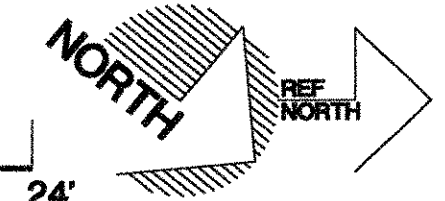

Rough plumbing for rest of building tested & OK to proceed

Sugimura & Associates Architects
 Architecture • Interiors
 Landscape Architecture
 2155 South Bascom Avenue, Suite 200
 San Jose, CA 95008
 408-879-0600 Fax 408-377-6066
 COPYRIGHT © 2003 Sugimura & Associates Architects

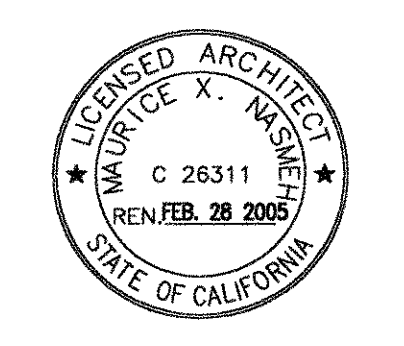

REGISTRATION STAMP
 DIV. OF THE STATE ARCHITECT
 OFFICE OF REGULATION SERVICES
 APP. NO. _____
 AC. _____
 DATE _____
 FILE NO. _____
 Division of the State Architect
 1995 Clay St., Suite 1001
 Oakland, CA 94612

GAS, COLD AND HOT WATER PIPING PLAN
BUILDING 13
SKYLINE COLLEGE SWING SPACE
PERMIT PACKAGE #3
SKYLINE COLLEGE
3300 COLLEGE DRIVE
SAN BRUNO, CA 94066

REVISIONS

NO.	ITEM	DATE
AB	BOUR	3/4/05

CLIENT APPROVAL:

DRAWN BY: KH
 CHECKED BY: MDN
 JOB NO: 2145.002 DATE: 13 FEB 2004

KEY PLAN

