
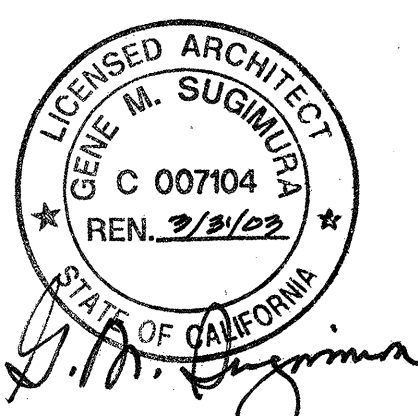


**LEGEND**

- IP IRON PIPE
- C.B. CATCH BASIN
- E.B. ELECTRIC BOX
- E.V. ELECTRIC VAULT
- F.H. FIRE HYDRANT
- PM POWER METER
- TEL.V. TELEPHONE VAULT
- WM WATER METER
- GV GATE VALVE
- ▲ THRUST BLOCK

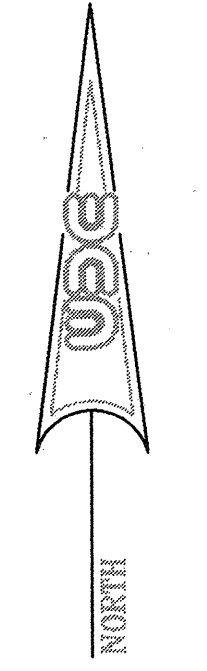

<p><b>DAVID EVANS AND ASSOCIATES INC.</b>          5000 Executive Parkway, Suite 125          San Ramon, California 94583          Phone: 925.867.3380          Fax: 925.867.3388</p>	<p><b>GENE M. SUGIMURA</b>          LICENSED ARCHITECT          No. C 007104          REN. 3/31/02          STATE OF CALIFORNIA</p>
<p><b>EDWARD WOODS</b>          REGISTERED PROFESSIONAL ENGINEER          No. C 29881          EXPIRES 03-31-03          CIVIL          STATE OF CALIFORNIA</p>	<p>PREPARED UNDER THE SUPERVISION OF            MARK E. WOODS, P.E.          EXPIRES 3-31-2003</p>
<p>SCALE: 1"=20'          DATE: 9/28/01          DRAWN BY: W-W          ENGINEER: MEW          CHECKED BY:          FB-1082 PG. 7</p>	<p>FACILITIES MAINTENANCE CENTER  <b>UTILITY PLAN</b>          SAN BRUNO          SKYLINE COLLEGE          CALIFORNIA</p>
<p>IDENTIFICATION STAMP          DIVISION OF THE STATE ARCHITECT          APPL01 104070          AC FL S          DATE</p>	<p>SHEET NO.  <b>C3</b> OF SHEETS          JOB No.          SMCC0000-0009</p>