


NO.	DESCRIPTION	DATE
04/2008	ISSUE FOR PERMITS	04/2008
06/13/08	100% SCHEDULED DESIGN	06/13/08
07/28/08	50% DESIGN DEVELOPMENT	07/28/08
08/13/08	80% DESIGN DEVELOPMENT	08/13/08
10/10/08	90% DESIGN DEVELOPMENT	10/10/08
11/11/08	CONSTRUCTION DOCUMENTS	11/11/08
11/11/08	INTERNAL 90% REVIEW INCREMENT 3	11/11/08
12/22/08	INTERNAL 90% REVIEW INCREMENT 3	12/22/08
02/02/09	DATA INCREMENT #2	02/02/09
05/12/09	DATA INCREMENT #3	05/12/09
06/10/09	ISSUED TO FIELD	06/10/09
12/27/10	RECORD DRAWINGS	12/27/10

14% DIVISION OF THE STATE ARCHITECT
APR # 01-110117
FILE # 41-C1
AC _____ **RS** _____
SSS _____ **DATE** _____
IDENTIFICATION STAMP
Increment 3

SKYLINE COLLEGE
 SAN MATEO COUNTY
 DISTRICT COLLEGE
CIP2 DESIGN-BUILD PROJECT BUILDING 4 INCREMENT 3

PROJECT NO.	SP1057010	DRAWN BY	IB
DATE	04/28/08	CHECKED BY	ALS
SCALE	3/32"=1'-0"		
SHEET TITLE	LEVEL 2 LIGHTING PLAN		

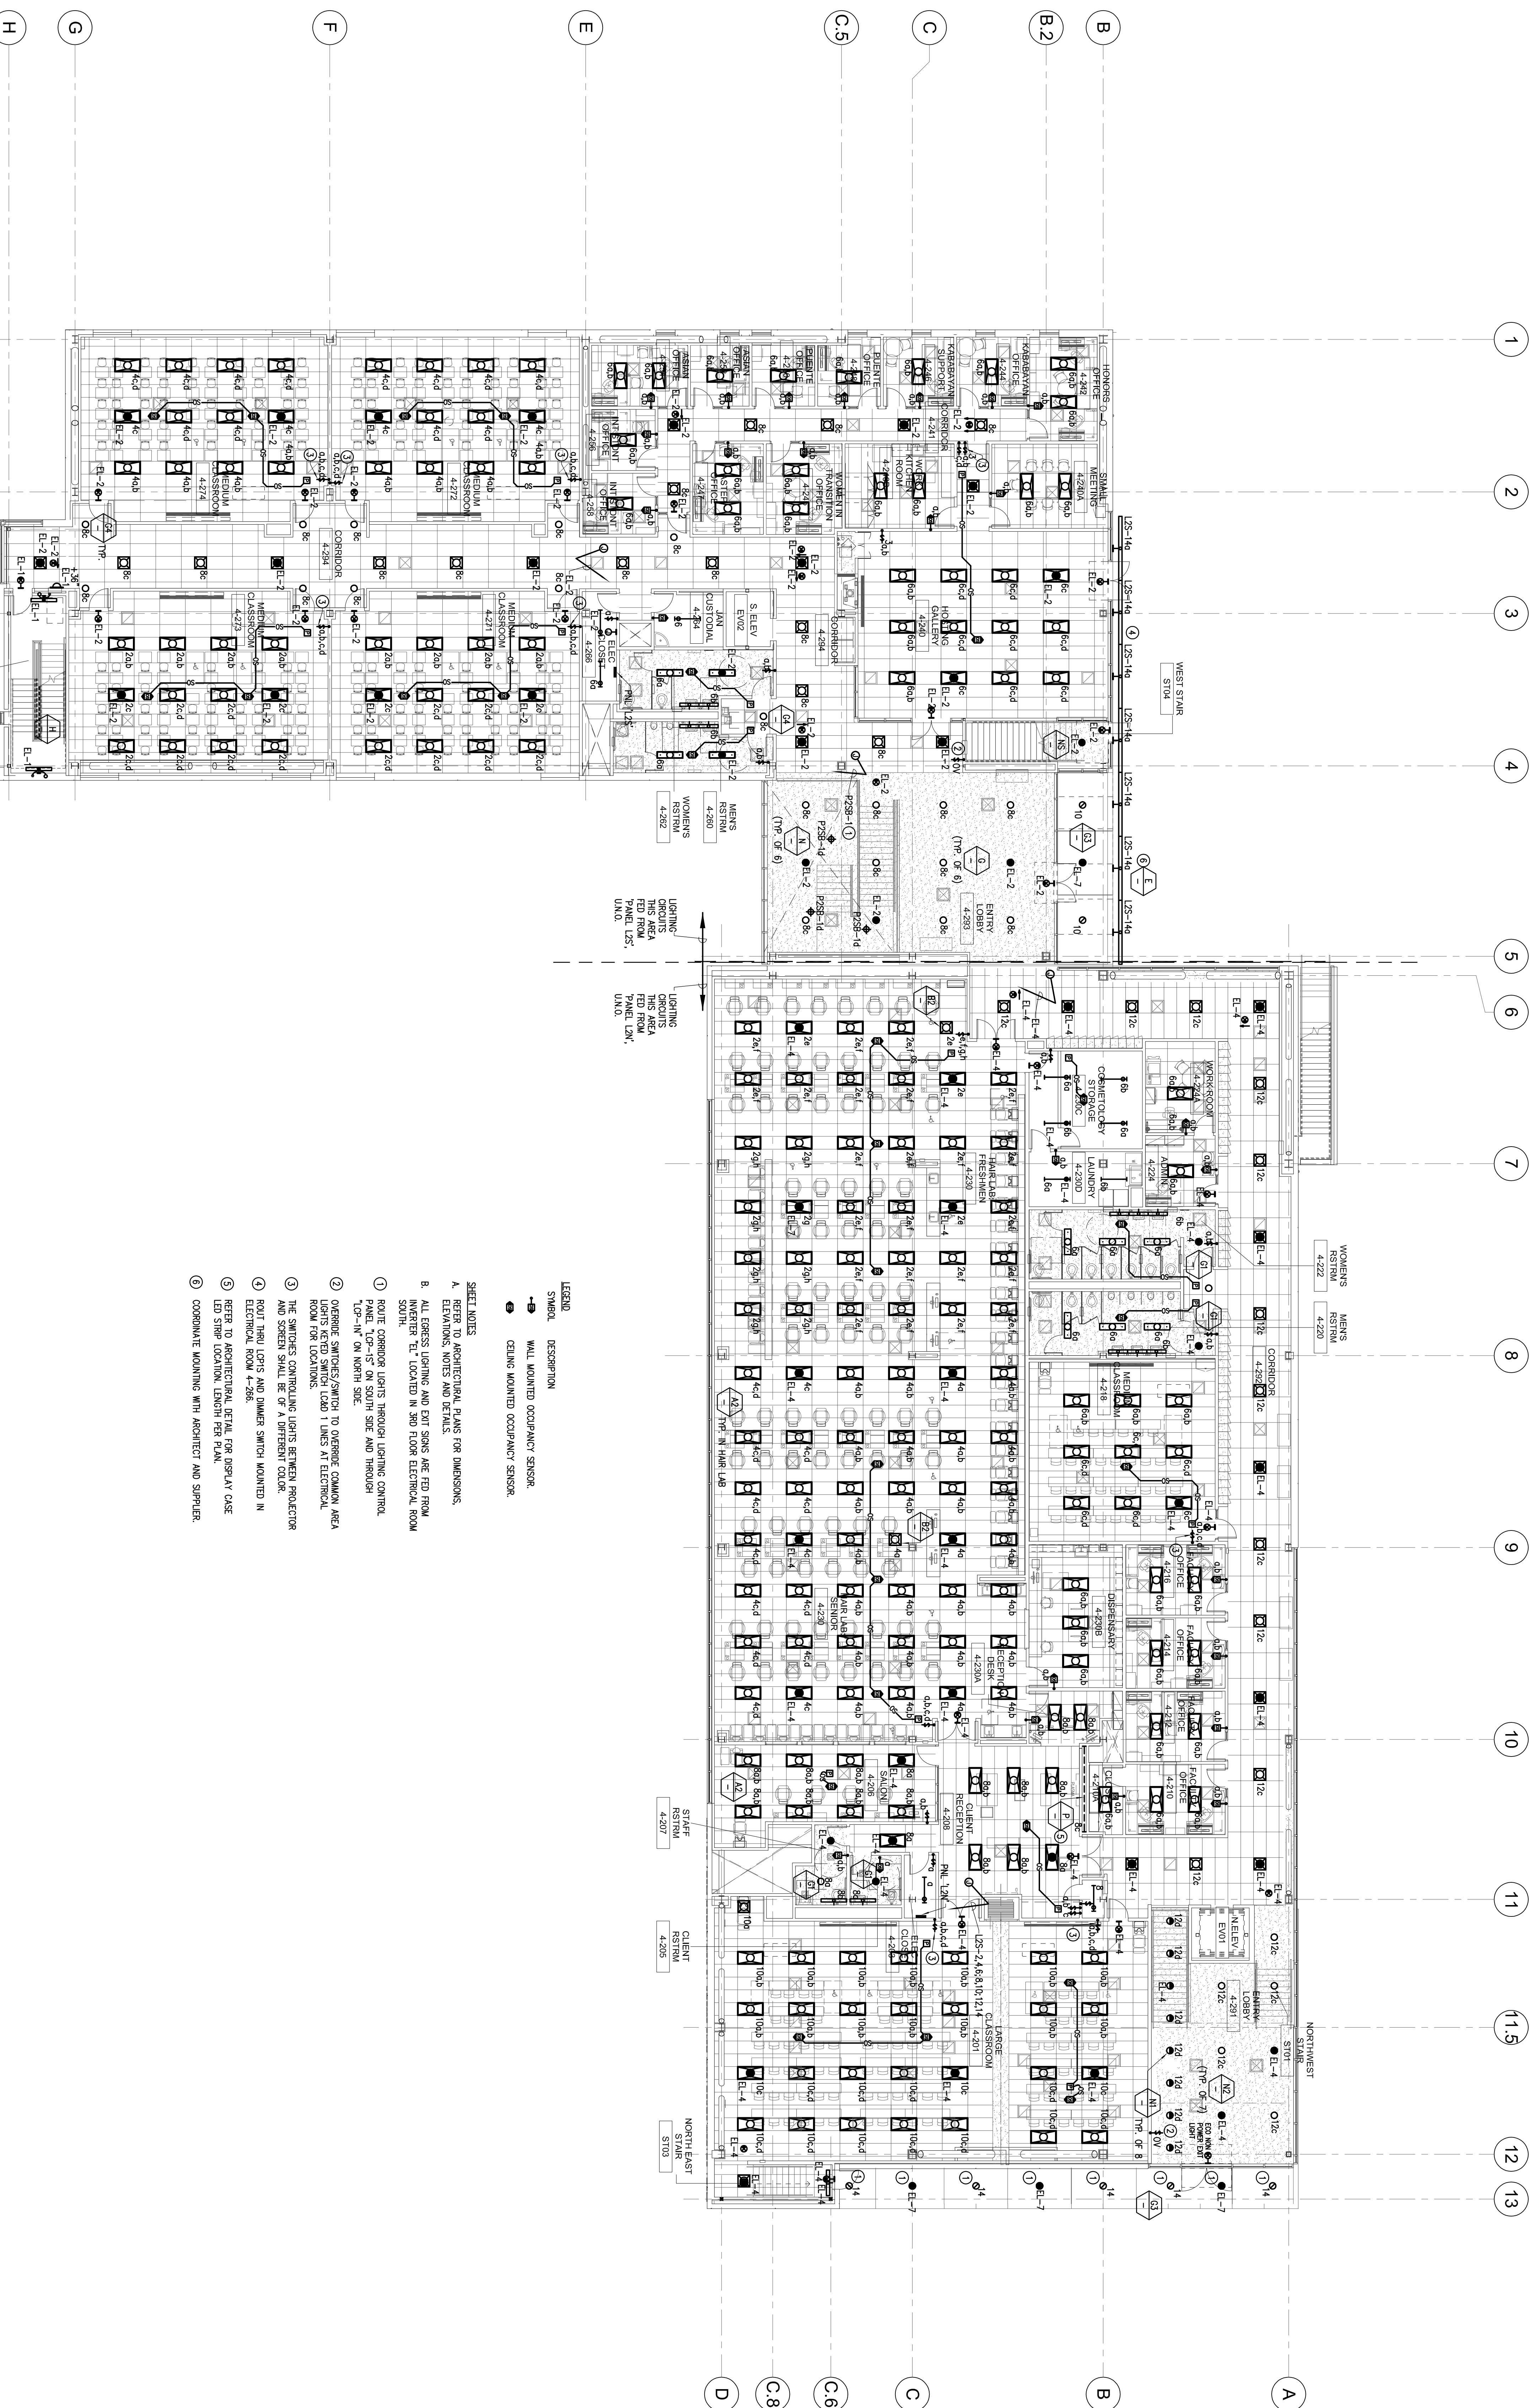

All drawings and written material, including but not limited to, drawings, specifications, and schedules, are the property of Steinberg Architects and shall remain the property of Steinberg Architects. No part of this drawing may be reproduced or transmitted in any form or by any means, electronic or mechanical, including photocopying, recording, or by any information storage and retrieval system, without the prior written permission of Steinberg Architects.

This drawing is not to scale. The drawing has been revised from the original size.