


1 DAVINCI LOT N.T.S.

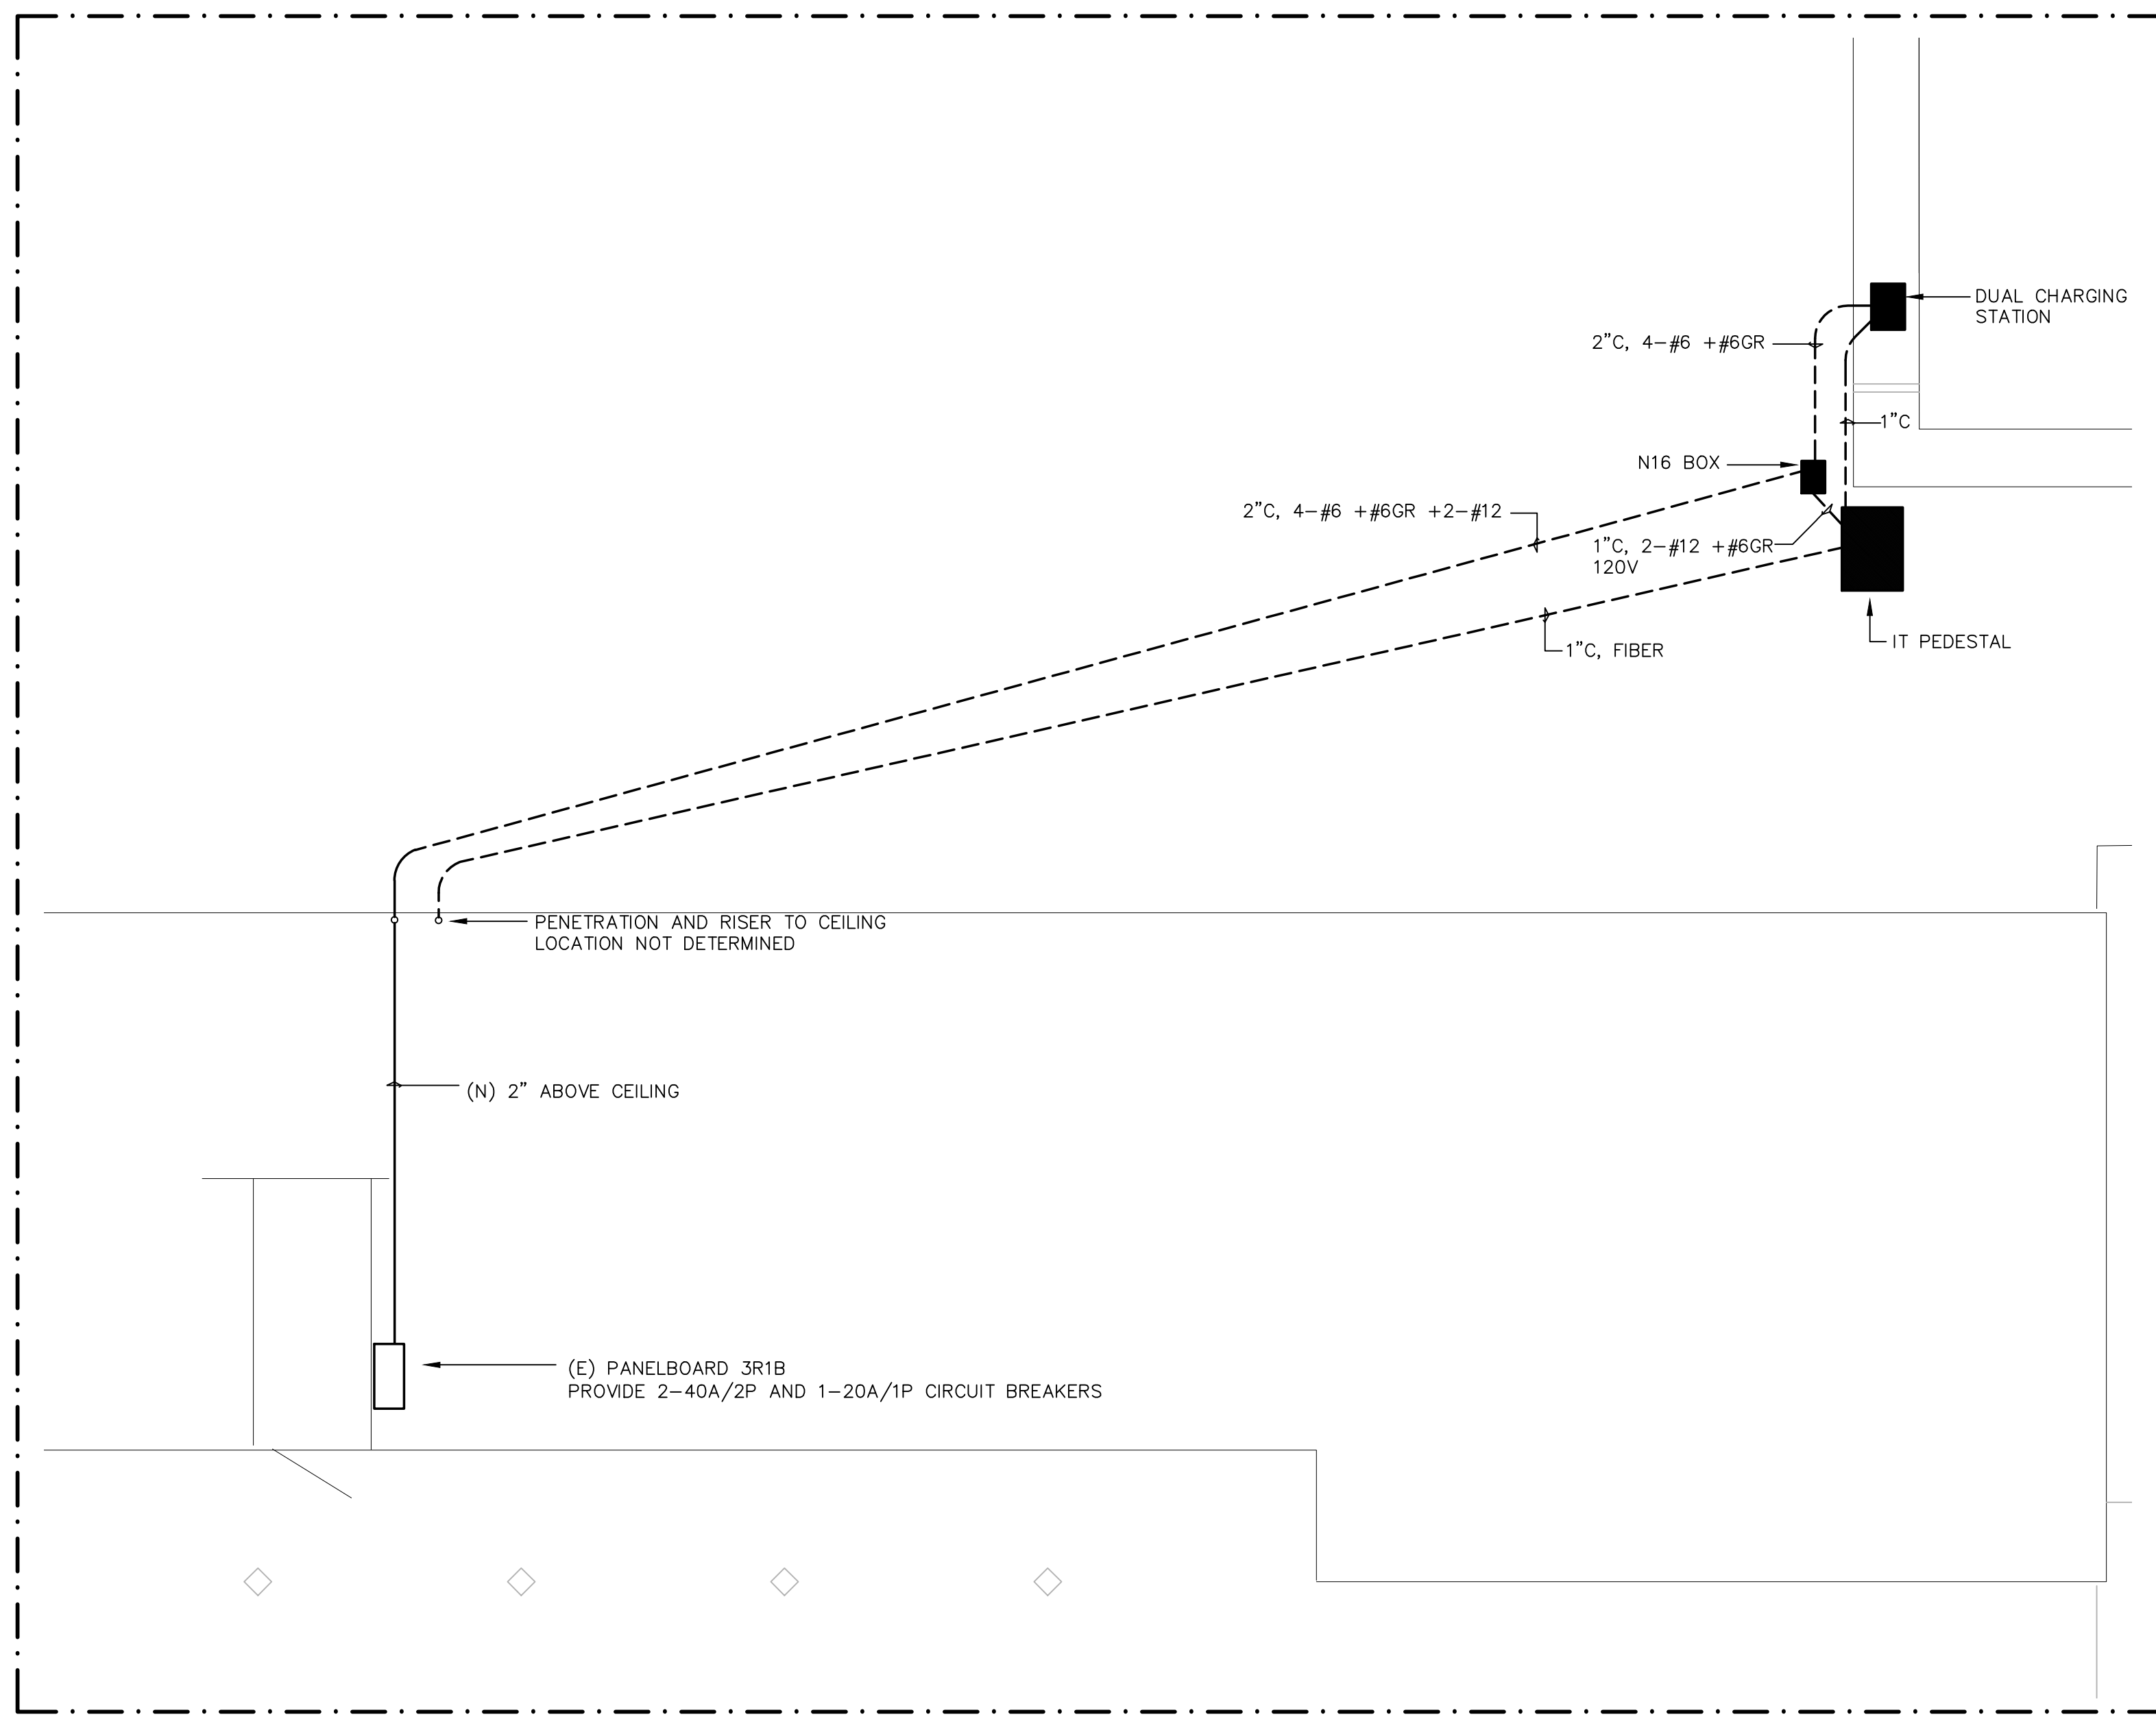

SEE DETAIL ON SHEET E1

SHEET TITLE
ELECTRICAL PLAN AND DETAILS

REVISIONS		
NO.	DATE	DESCRIPTION

DATE FEBRUARY 28, 2012
DRAWN JS
CHECKED -
SCALE AS NOTED
JOB NO.

SHEET NUMBER
CSM-E3