
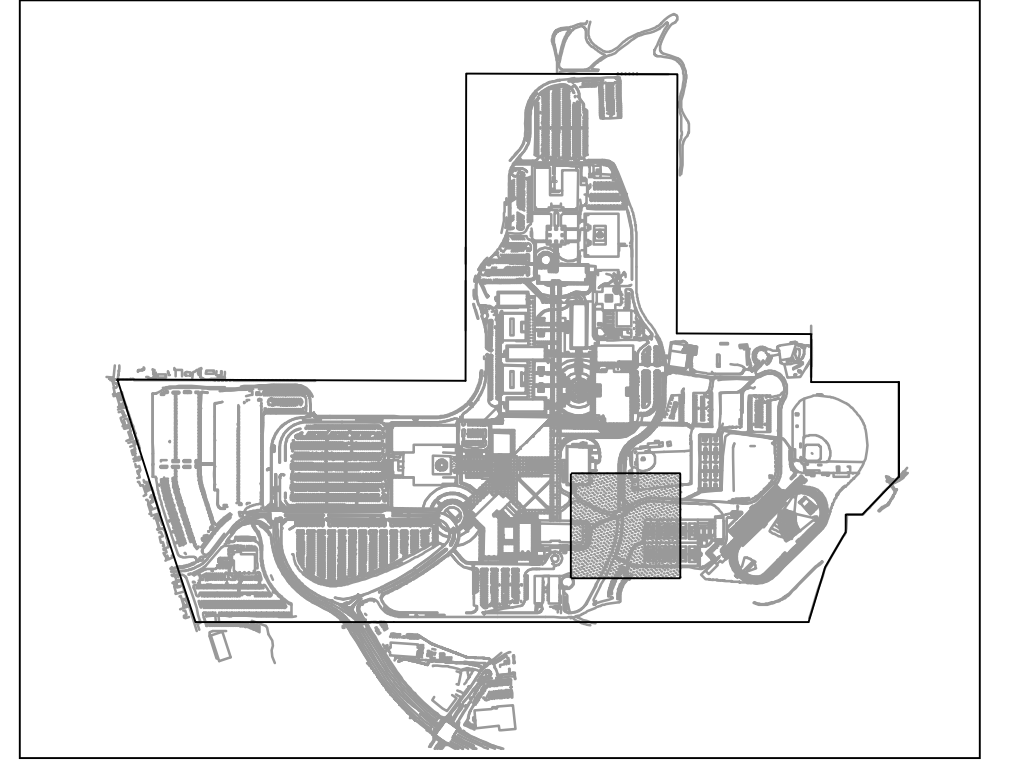
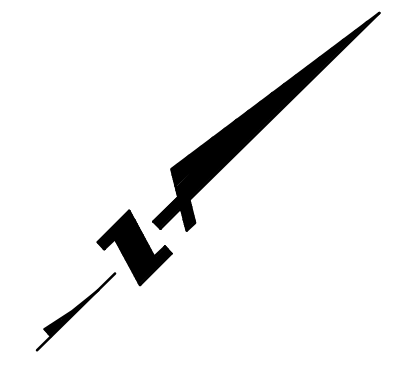


MATCH LINE - SEE SHEET C5.05

MATCH LINE - SEE SHEET C5.09

MATCH LINE - SEE SHEET C5.02

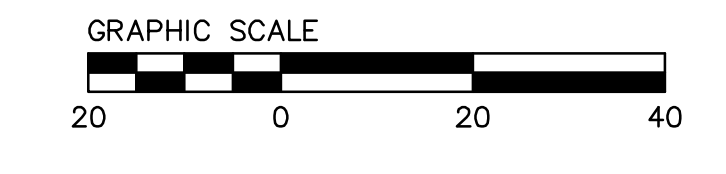

KEYMAP



McCarthy Building Companies, Inc.  
343 Sansome Street, 14th Floor  
San Francisco, California 94104  
P 415 | 364-1339  
F 415 | 397-5999



255 SHORELINE DRIVE, SUITE 200  
REDWOOD CITY, CA 94065  
PHONE: (650) 482-6300  
FAX: (650) 482-6399



IDENTIFICATION STAMP  
DIV. OF THE STATE ARCHITECT  
OFFICE OF REGULATION SERVICE  
APPL. # 01-110097  
AC: \_\_\_\_\_ FLS: \_\_\_\_\_ SS: \_\_\_\_\_  
DATE: \_\_\_\_\_  
FILE NUMBER: \_\_\_\_\_

This and all other project documents are the property of BKF Engineers, Inc. (BKF) and cannot be used, copied, or reproduced in any form or by any means without the written consent of BKF. BKF hereby grants permission to the recipient to use the project documents for the project identified herein only. Any other use, reproduction or modification (revised) is not only prohibited but also constitutes a violation of the professional seal of the recipient. BKF and its Consultants shall be held responsible for any errors or omissions in this project document. BKF and its Consultants make no representation concerning the accuracy of documents not prepared by BKF or its Consultants. BKF and its Consultants make no representation concerning the accuracy of documents not prepared by BKF or its Consultants.

© Copyright 2008

College of San Mateo  
Site Package  
San Mateo, CA

Developed for  
San Mateo County Community College District

Revision	Description	Date

Revision	Description	Date
1	SUBMITTAL	19 SEPT 2008
2	FINAL	09 APRIL 2009
3	PROJECT RECORD DRAWING	JUNE 2011

**RECORD DRAWINGS**  
THESE RECORD DOCUMENTS HAVE BEEN PREPARED BASED ON INFORMATION PROVIDED BY OTHERS. BKF ENGINEERS HAS NOT VERIFIED THE ACCURACY AND/OR COMPLETENESS OF THIS INFORMATION AND SHALL NOT BE RESPONSIBLE FOR ANY ERRORS OR OMISSIONS THAT MAY BE INCORPORATED HEREIN AS A RESULT. BKF ENGINEERS DOES NOT ASSUME ANY RESPONSIBILITY FOR THE FIELD MODIFICATIONS TO THE PLANS.  
BY: BKF ENGINEERS      DATE: JUNE 2011

Job No.	27082.30
Date	02 APRIL 2009
Drawn by	MD, JT
Checked by	RH
Scale	1"=20'

**GRADING & DRAINAGE PLAN**  
**C5.06**