


NO.	ISSUE/REVISIONS	DATE
1	100% SCHEMATIC DESIGN	04/20/08
2	50% DESIGN DEVELOPMENT	06/12/08
3	20% DESIGN DEVELOPMENT	07/29/08
4	SCHEMATICAL	07/29/08
5	100% INCORPORATE	10/10/08
6	100% INCORPORATE	11/11/08
7	100% INCORPORATE	11/11/08
8	100% INCORPORATE	12/22/08
9	100% INCORPORATE	02/06/09
10	100% INCORPORATE	04/02/09
11	100% INCORPORATE	05/22/09
12	100% INCORPORATE	06/22/09
13	100% INCORPORATE	06/22/09
14	100% INCORPORATE	06/22/09
100	100% INCORPORATE	06/22/09


THE DIVERSITY OF
 THE UNIVERSITY OF
 CALIFORNIA
 THE UNIVERSITY OF
 CALIFORNIA
 THE UNIVERSITY OF
 CALIFORNIA

SKYLINE COLLEGE
 SAN MATEO COUNTY
 COMMUNITY COLLEGE
 DISTRICT
**CIP2 DESIGN-BUILD
 PROJECT**
**BUILDING 4
 INCREMENT 3**

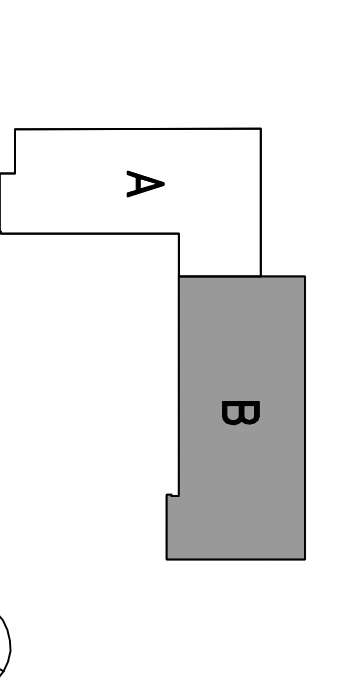

**LEVEL 3
 POWER AND SIGNAL
 PLAN**
 SECTOR B

SHEET TITLE
 PROJECT NO. SF1057010 DRAWN BY: IB
 DATE: 04/26/08 CHECKED BY: AJS
 SCALE: 3/32"=1'-0"
 SHEET NO. **E-303B**

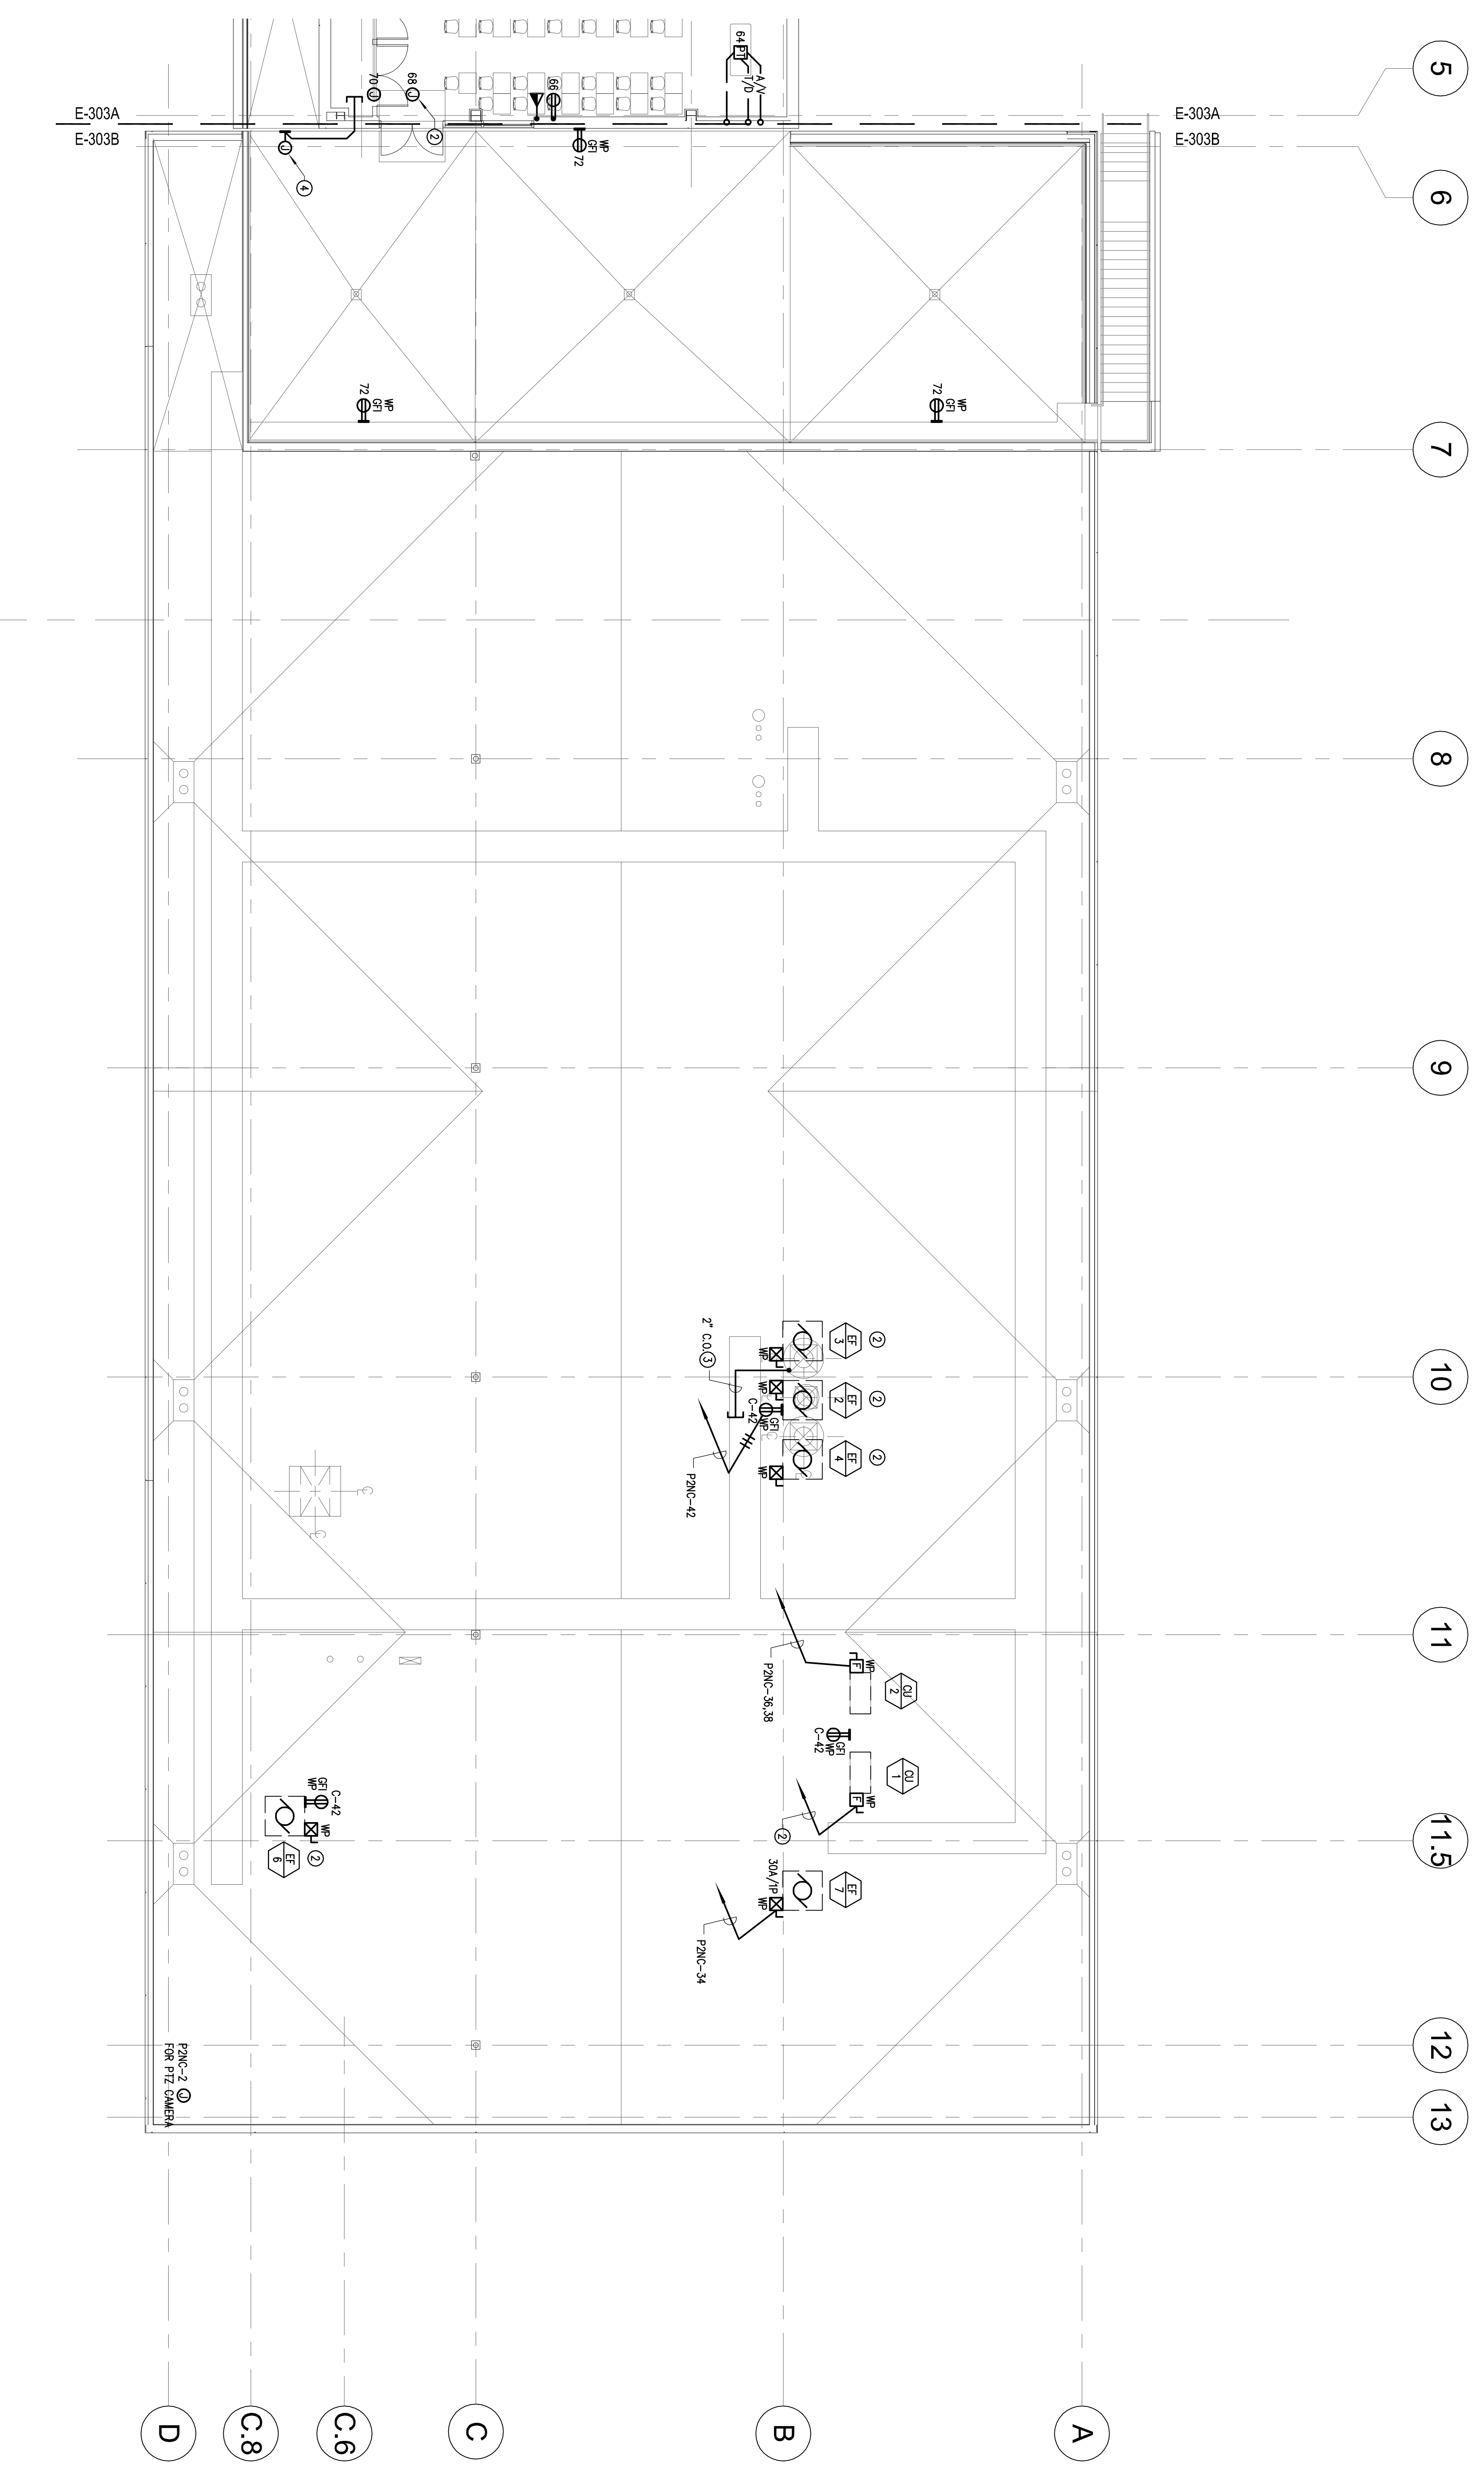

SHEET NOTES
 A. ALL DISCONNECT SWITCHES ARE 30A/25P UNAG.
 1. NOT USED.
 2. SEE SINGLE LINE DIAGRAM.
 3. PROVIDE CANNOT STOP-OUT FOR FUTURE SATELLITE DSH CASES. COORDINATE LOCATION IN FIELD.

LEVEL 3 - POWER AND SIGNAL PLAN - SECTOR B
 SCALE: 1/8"=1'-0"

All drawings and written material appearing herein constitute original and unpublished work of the Architect/Engineer and may not be duplicated, used or disclosed without consent of Architect/Engineer.

If this drawing is not 36"x42", then the drawing has been revised from its original size. Model facilities must be indicated. This line should be equal to one inch.