


1 BUILDING 17 - FIRST FLOOR PLAN DEMOLITION
 E1.21 1/8"=1'-0" N

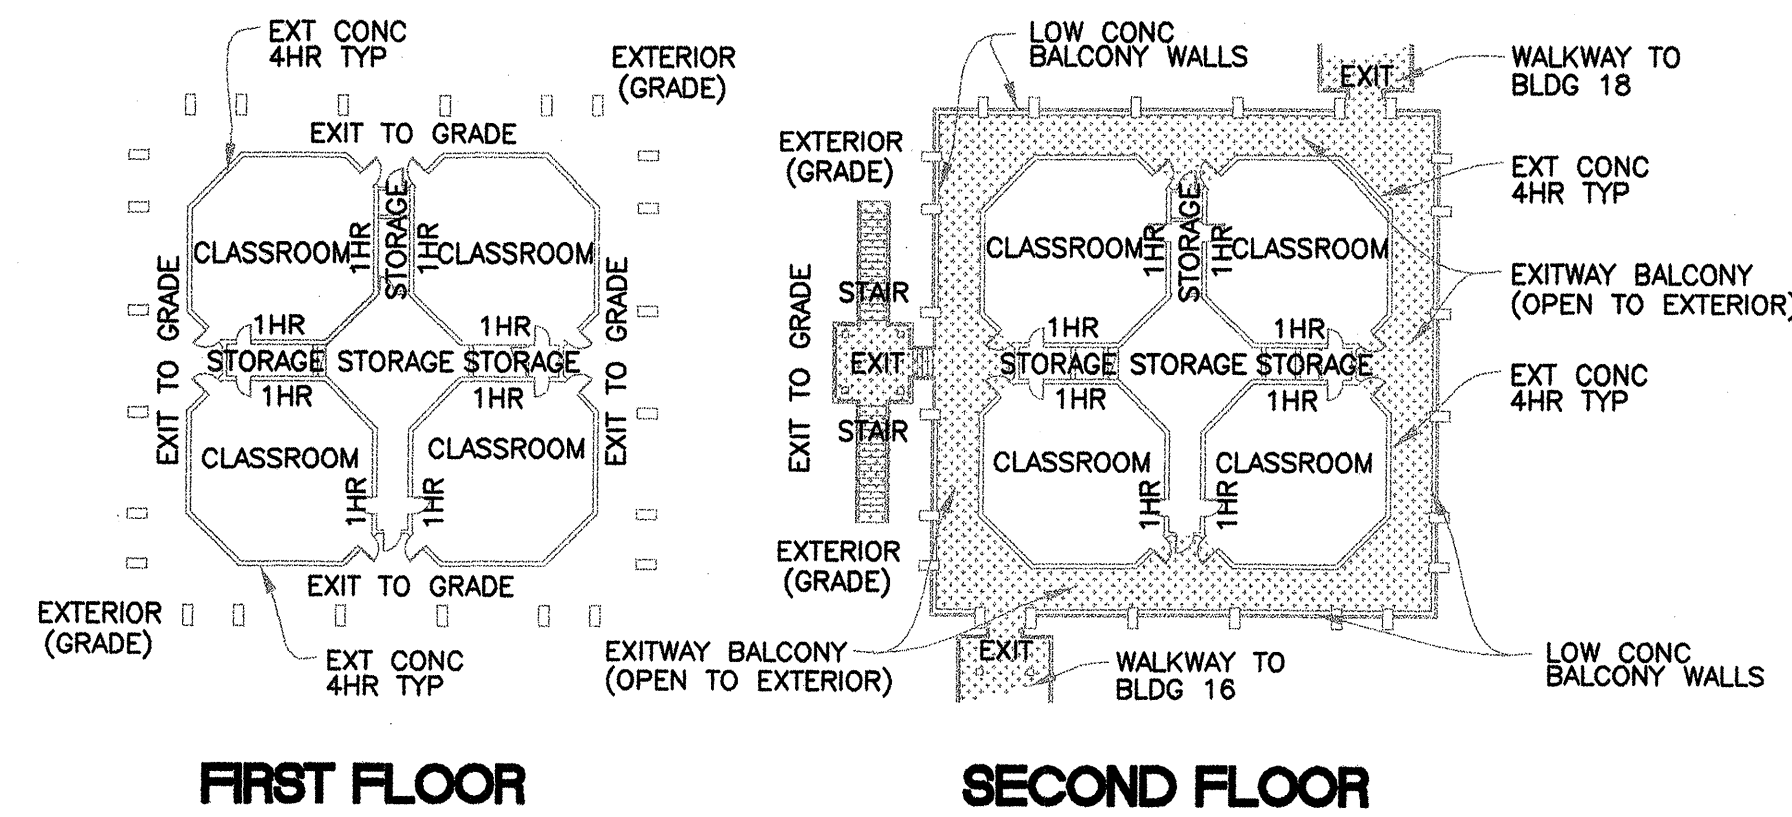

2 OVERALL FLOOR PLANS BUILDING 17
 E1.21 1/32"=1'-0" N

NOTES:

1. REFER TO DWG. E0.01 FOR ELECTRICAL GENERAL NOTES, SYMBOLS AND ABBREVIATIONS.

DEMOLITION KEY NOTES:

- ① REMOVE AND PROPERLY DISPOSE OF ALL (E) LIGHT FIXTURES COMPLETE WITH ALL ASSOCIATED CONDUIT AND WIRE BACK TO CLOSEST JUNCTION BOX.
- ② RELOCATE LIGHT SWITCH(ES), AS REQUIRED, TO ACCOMMODATE (N) DOORWAY. IF FOUR-WAY SWITCH REPLACE WITH THREE-WAY.
- ③ NOT USED.
- ④ NOT USED.
- ⑤ DISCONNECT AND REMOVE (E) PUMP DISCONNECT AND ASSOCIATED CONDUIT AND WIRE BACK TO CLOSEST JUNCTION BOX. CAP AND ABANDON WIRES.
- ⑥ (E) LIGHT SWITCH(ES) TO REMAIN.
- ⑦ REMOVE (E) LIGHT FIXTURES AND ASSOCIATED CONDUIT AND WIRE, AS REQUIRED FOR MECHANICAL WORK. REINSTALL (PENDANT MOUNT 9'-0" AFF) EXISTING LIGHT FIXTURES FOLLOWING MECHANICAL NEW WORK.
- ⑧ NOT USED.
- ⑨ DISCONNECT AND REMOVE (E) LIGHT SWITCH AND ASSOCIATED WIRE BACK TO CLOSEST JUNCTION BOX. PROVIDE BLANK STAINLESS STEEL COVER.
- ⑩ REPLACE (E) FOUR-WAY SWITCH(ES) WITH THREE-WAY SWITCH(ES).
- ⑪ DISCONNECT AND REMOVE (E) LIGHT SWITCH. REFER TO NEW WORK FOR (N) WALL-MOUNTED OCCUPANCY SENSOR.
- ⑫ DISCONNECT AND REMOVE (E) RECIRCULATION DISCONNECT SWITCH AND ASSOCIATED CONDUIT AND WIRE BACK TO CLOSEST JUNCTION BOX. MAINTAIN CIRCUIT CONTINUITY.
- ⑬ IN PANEL RR1A, REMOVE 20A, 1P CIRCUIT BREAKERS IN SPACES 22 AND 24, AND, PROVIDE A 20A, 2 POLE CIRCUIT BREAKER FOR ELECTRIC WATER HEATER. REFER TO NEW WORK PLANS.



CAÑADA COLLEGE
 BUILDING 16, 17, 18
 RENOVATION
 SMCCCD
 3401 CSM Drive
 San Mateo, CA 94402
 Cañada College
 4200 FarmHills Blvd.
 Redwood City, CA 94061

SHEET TITLE
**BUILDING 17
 FIRST FLOOR PLAN
 DEMOLITION**

REVISIONS		
NO.	DATE	DESCRIPTION


**PROJECT RECORD DOCUMENT
 BID: 86519 DATED 2-7-07**

PREPARED BY:

Engelhart
 ELECTRIC CO. INC.
 SERVES THE PENINSULA

ELECTRICAL CONTRACTOR • LICENSE #399195
 1052 Commercial Street, San Carlos, Ca. 94070
 Bus: (650) 595-1091 • Fax: (650) 595-5489

KEY PLAN

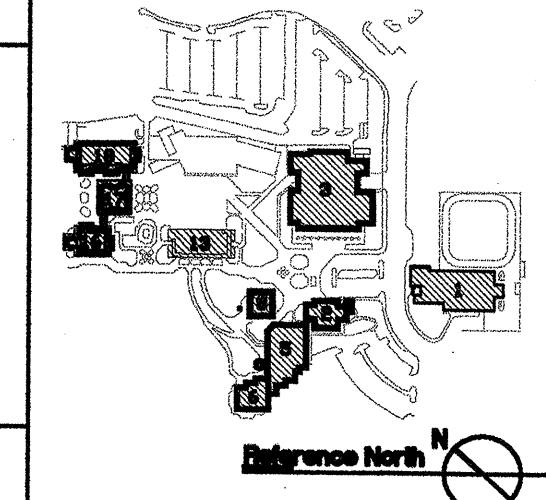

DATE
 DRAWN U. TRUONG
 CHECKED D. DIAS
 SCALE AS NOTED
 N&T JOB NO.:

SHEET NUMBER

E1.21