

SHEET NOTES

- 1 NO CHAIR RAIL OR WAINSCOT ON THIS WALL
- 2 PROVIDE ACCENT PAINT P-7 AT COLUMNS, TYP. THIS ROOM

GENERAL NOTES


- A. SEE ELECTRICAL PLANS FOR LOCATION OF ILLUMINATED EXIT SIGNS.
- B. SEE SIGNAGE SCHEDULE FOR ROOM ID SIGNS
- C. SEE FINISH GROUPS SCHEDULE AND FINISH LEGEND ON SHEET A8.1 FOR DESCRIPTION OF FINISHES AND FINISH GROUPS.
- D. EVACUATION SIGNS (SIGN TYPE 25) TO BE POSTED AT EVERY ELEVATOR LOBBY, AT EACH FIRE ALARM PULL STATION AND AT EACH EXIT. VERIFY WITH SCHOOL DISTRICT LOCATION PRIOR TO FABRICATION. EVACUATION MAPS TO BE PROVIDED BY DISTRICT USING THE ARCHITECT'S EXITING PLAN. SEE DETAIL 17/A9.3

LEGEND

SIGNAGE. SEE SHEET A8.40



Bunton Clifford Associates, Inc.
 210 Hammond Ave.
 Fremont, California 94539
 [T] 510.445.1000
 [F] 510.445.1005
 www.BCAincOnline.com

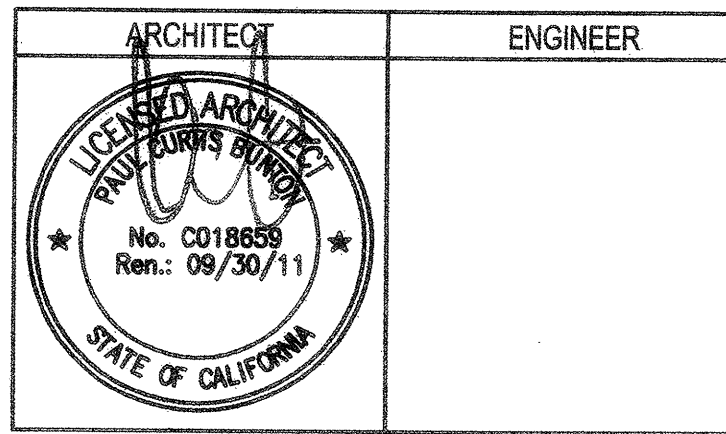

1. This sheet is part of a set and is not to be used alone.
 2. This sheet is not to be used for construction unless the architect's stamp and signature appear on the drawings and the status box indicates drawings have been released for construction.
 3. These plans and prints thereof, as instruments of service, are owned by the architect and are for use on this project only. Reproduction and/or distribution without the prior written consent of the architect is forbidden.
 4. Copyright Bunton Clifford Associates, 2009

REVISION/REMARKS	DATE
ADDENDUM NO. 1	08/18/09
ADDENDUM NO. 2	11/09/09

DRAWING STATUS	DATE
● OSA PLAN CHECK	08/26/08
● OSA BACK CHECK	01/22/09
● BIDDING	08/18/09
○ CONSTRUCTION	

FILE NO. 41-C1

IDENTIFICATION STAMP
 DIV. OF THE STATE ARCHITECT

01- 110074

AC FLS SS

DATE

BUILDINGS 5 & 6 RENOVATIONS
 San Mateo County Community College District

APPROVED BY THE STATE ARCHITECT
 AC/IM FLS/SS/IT
 APPL. NO. 110074 DATE 5/24/09

CAÑADA COLLEGE
 4200 Farm Hill Boulevard
 Redwood City, CA 94061

FIRST FLOOR
 FINISH AND SIGNAGE PLAN

Date: 08/29/08
 Scale: AS NOTED
 Project Number: 07013

Drawing Number: **A9.41**

FIRST FLOOR FINISH AND SIGNAGE PLAN 1