

THE DRAWING AND DESIGN HEREIN SHALL NOT BE DUPLICATED, USED OR DISCLOSED TO OTHERS FOR PRODUCTION OR OTHER PURPOSE (EXCEPT AS OTHERWISE AUTHORIZED BY CONTRACT) WITHOUT WRITTEN PERMISSION OF SIEMENS INDUSTRY. ALL OTHER REPRODUCTIONS SHALL BEAR THIS NOTICE.

REVISIONS

No.	Revision	By	Date	Appr.

DESIGN ENGINEER:
PROJECT 2007-0731
 CONTACT: **Interface**
INTERFACE ENGINEERING
 717 Market Street
 Suite 500
 San Francisco, CA 94103
 TEL: 415.489.7240
 FAX: 415.489.7289
 www.interfaceengineering.com

ISA STAMP:
 FILE NO. 41-C-1
 IDENTIFICATION STAMP
 DIV. OF THE STATE ARCHITECT
 01-110074
 DATE: _____

CONTRACTOR'S NAME & ADDRESS:
InterMountain
 ELECTRIC COMPANY
 947 Washington Street
 San Carlos CA 94070
 Tel 650.591.7118 Fax 650.591.7123
 contact@im-electric.com


PRODUCT MANUFACTURER:
SIEMENS Industry
 SAN FRANCISCO BRANCH
 25821 Industrial Boulevard, Suite 300
 Hayward, California 94545-2991
 Tel (510) 783-6000 Fax (510) 293-2100
 California State C10 License No. 758796
 U.L. Certificate ID No. 324787-001

JOB NAME & LOCATION (STREET ADDRESS)
FIRE ALARM
 FOR
SAN MATEO COUNTY COMMUNITY COLLEGE DISTRICT
CAÑADA COLLEGE
 BUILDINGS 5 AND 6
 MODERNIZATION
 4200 FARM HILL BOULEVARD
 REDWOOD CITY, CA 94061

SHEET CONTENTS:
COVER/ DRAWING INDEX/ EQUIPMENT LIST

INSTALLATION TYPE
 NEW INSTALLATION
 DESIGN/BUILD
 PER CONTRACT DOCUMENT
 EXISTING BASE JOB # _____
 OTHERS _____

SYSTEM SALES REP.: Kelly Rogers
 PROJECT MANAGER: Jesse Mangosing
 DRAWN BY: Ronald Babiera
 CAD FILENAME: 44OP-070529.DWG
 SCALE: N/A
 DATE DRAWN: April 07, 2010 PLOT DATE: May 11, 2010
 SHEET: FA-05 JOB NUMBER: 44OP-070529 NET NUMBER: 5249672

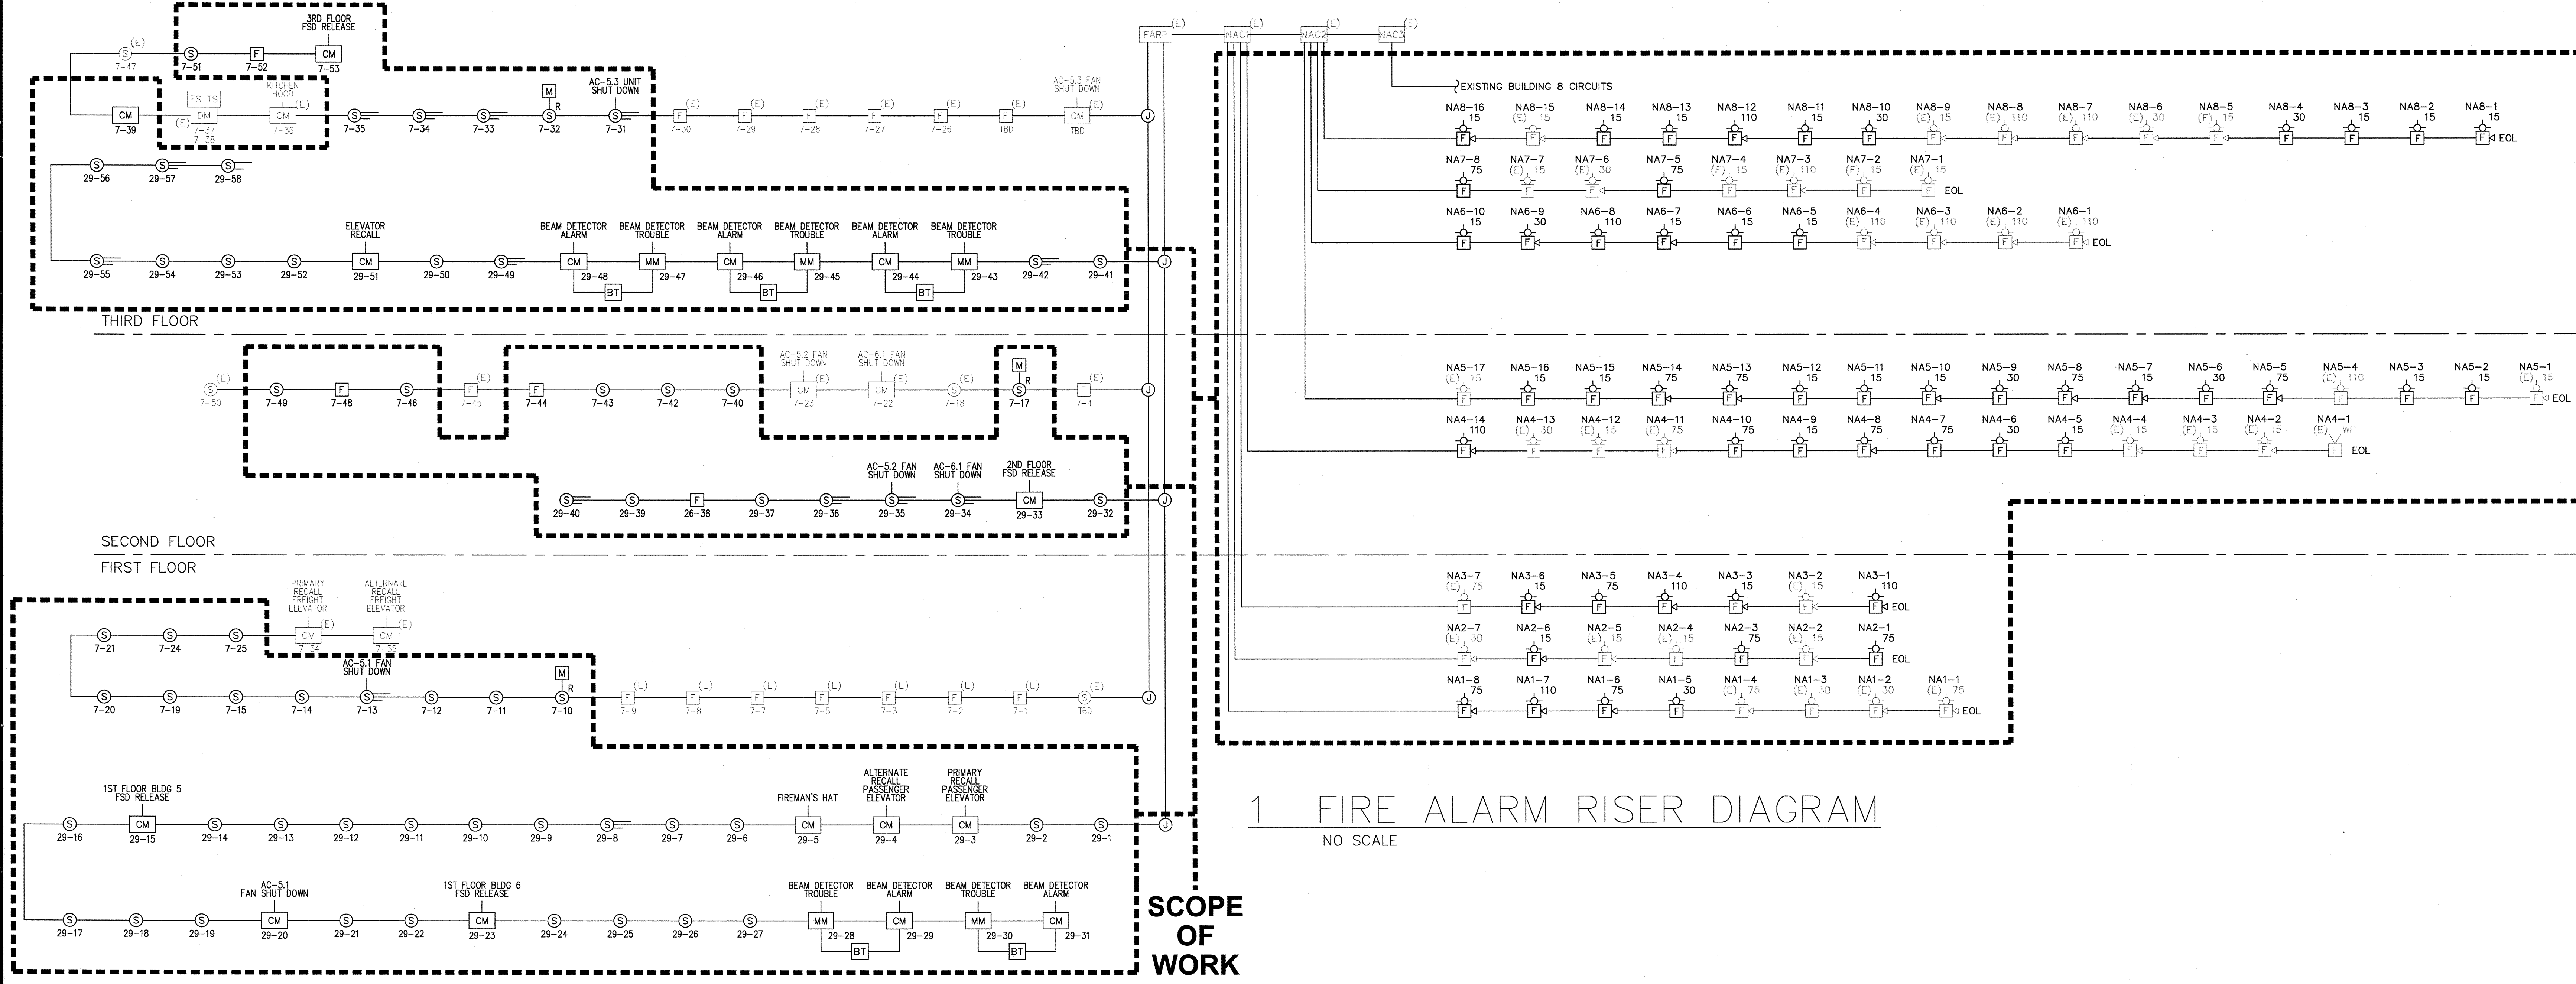

1 FIRE ALARM RISER DIAGRAM
 NO SCALE

SCOPE OF WORK

DRAWING IS SMALLER THAN 30" X 42" IF IS A REDUCED COPY