

THIS DRAWING AND DESIGN HEREIN SHALL NOT BE DUPLICATED, USED OR DISCLOSED TO OTHERS FOR PROCUREMENT OR OTHER PURPOSE EXCEPT AS OTHERWISE AUTHORIZED BY CONTRACT. WITHOUT WRITTEN PERMISSION OF SEMENS INDUSTRY, ALL OTHER REPRODUCTIONS SHALL BEAR THIS NOTICE.

REVISIONS


No.	Revision	By	Date	Appr.

GENERAL SHEET NOTES

- A. DEMOLISH EXISTING FIRE ALARM DEVICES AS REQUIRED TO ACCOMMODATE NEW CONSTRUCTION. DEMOLITION WORK SHALL BE COORDINATE AND SEQUENCED WITH THE PROVISIONS OF ALL DIVISIONS OF CONSTRUCTION DOCUMENTS.
- B. REMOVE ALL EXISTING MATERIALS CONFLICTING WITH REMODEL WORK INDICATED IN CONSTRUCTION DOCUMENTS AND SUBJECT TO THE CONDITIONS INDICATED IN SUCH.
- C. REMOVE ALL ELECTRICAL MATERIALS MOUNTED IN OR ON WALLS AND CEILING TO BE REMOVED AS INDICATED IN THE ARCHITECTURAL CONSTRUCTION DOCUMENTS.
- D. VERIFY EXISTING CONDITIONS PRIOR TO PROCEEDING WITH THE WORK, AND PROVIDE ADDITIONAL SPLICE BOXES, ETC., AS REQUIRED FOR A COMPLETE AND PROPERLY OPERATING SYSTEM. EXISTING CONDUIT THAT IS NOT REMOVED DURING DEMOLITION MAY BE REUSED IN PLACE IF IT IS SIZED IN ACCORDANCE WITH THE LATEST EDITION OF THE N.E.C. AND THOROUGHLY CLEANED AND SWABBED PRIOR TO PULLING NEW WIRES.
- E. WHERE DRAWINGS INDICATE EXISTING FIRE ALARM EQUIPMENT OR DEVICES TO BE RELOCATED OR REUSED, REFURBISH THEM. CLEAN SUCH ITEMS AND NOTIFY ARCHITECT OF ANY DEFECTS IN SUCH INSTALLATIONS. REPAIR ANY DAMAGE CAUSED BY DEMOLITION OR CONSTRUCTION PERFORMED UNDER THIS CONTRACT.

SHEET KEYNOTES

- 1 PROVIDE 1" CONDUIT WITH 16 AWG 1 PAIR TWISTED AND SHIELDED FIRE ALARM CABLE SUITABLE FOR WET LOCATION, SUCH AS WEST PENN AQUASEAL.
- 2 EXISTING DEVICE, ADDRESS TO BE FIELD VERIFIED.
- 3 BUILDING 5 3RD FLOOR FSDs TO BE SHUT DOWN BY RELAY MODULE 7-53. 120 VAC WIRE RUN TO BE DETERMINED BY ELECTRICAL CONTRACTOR.

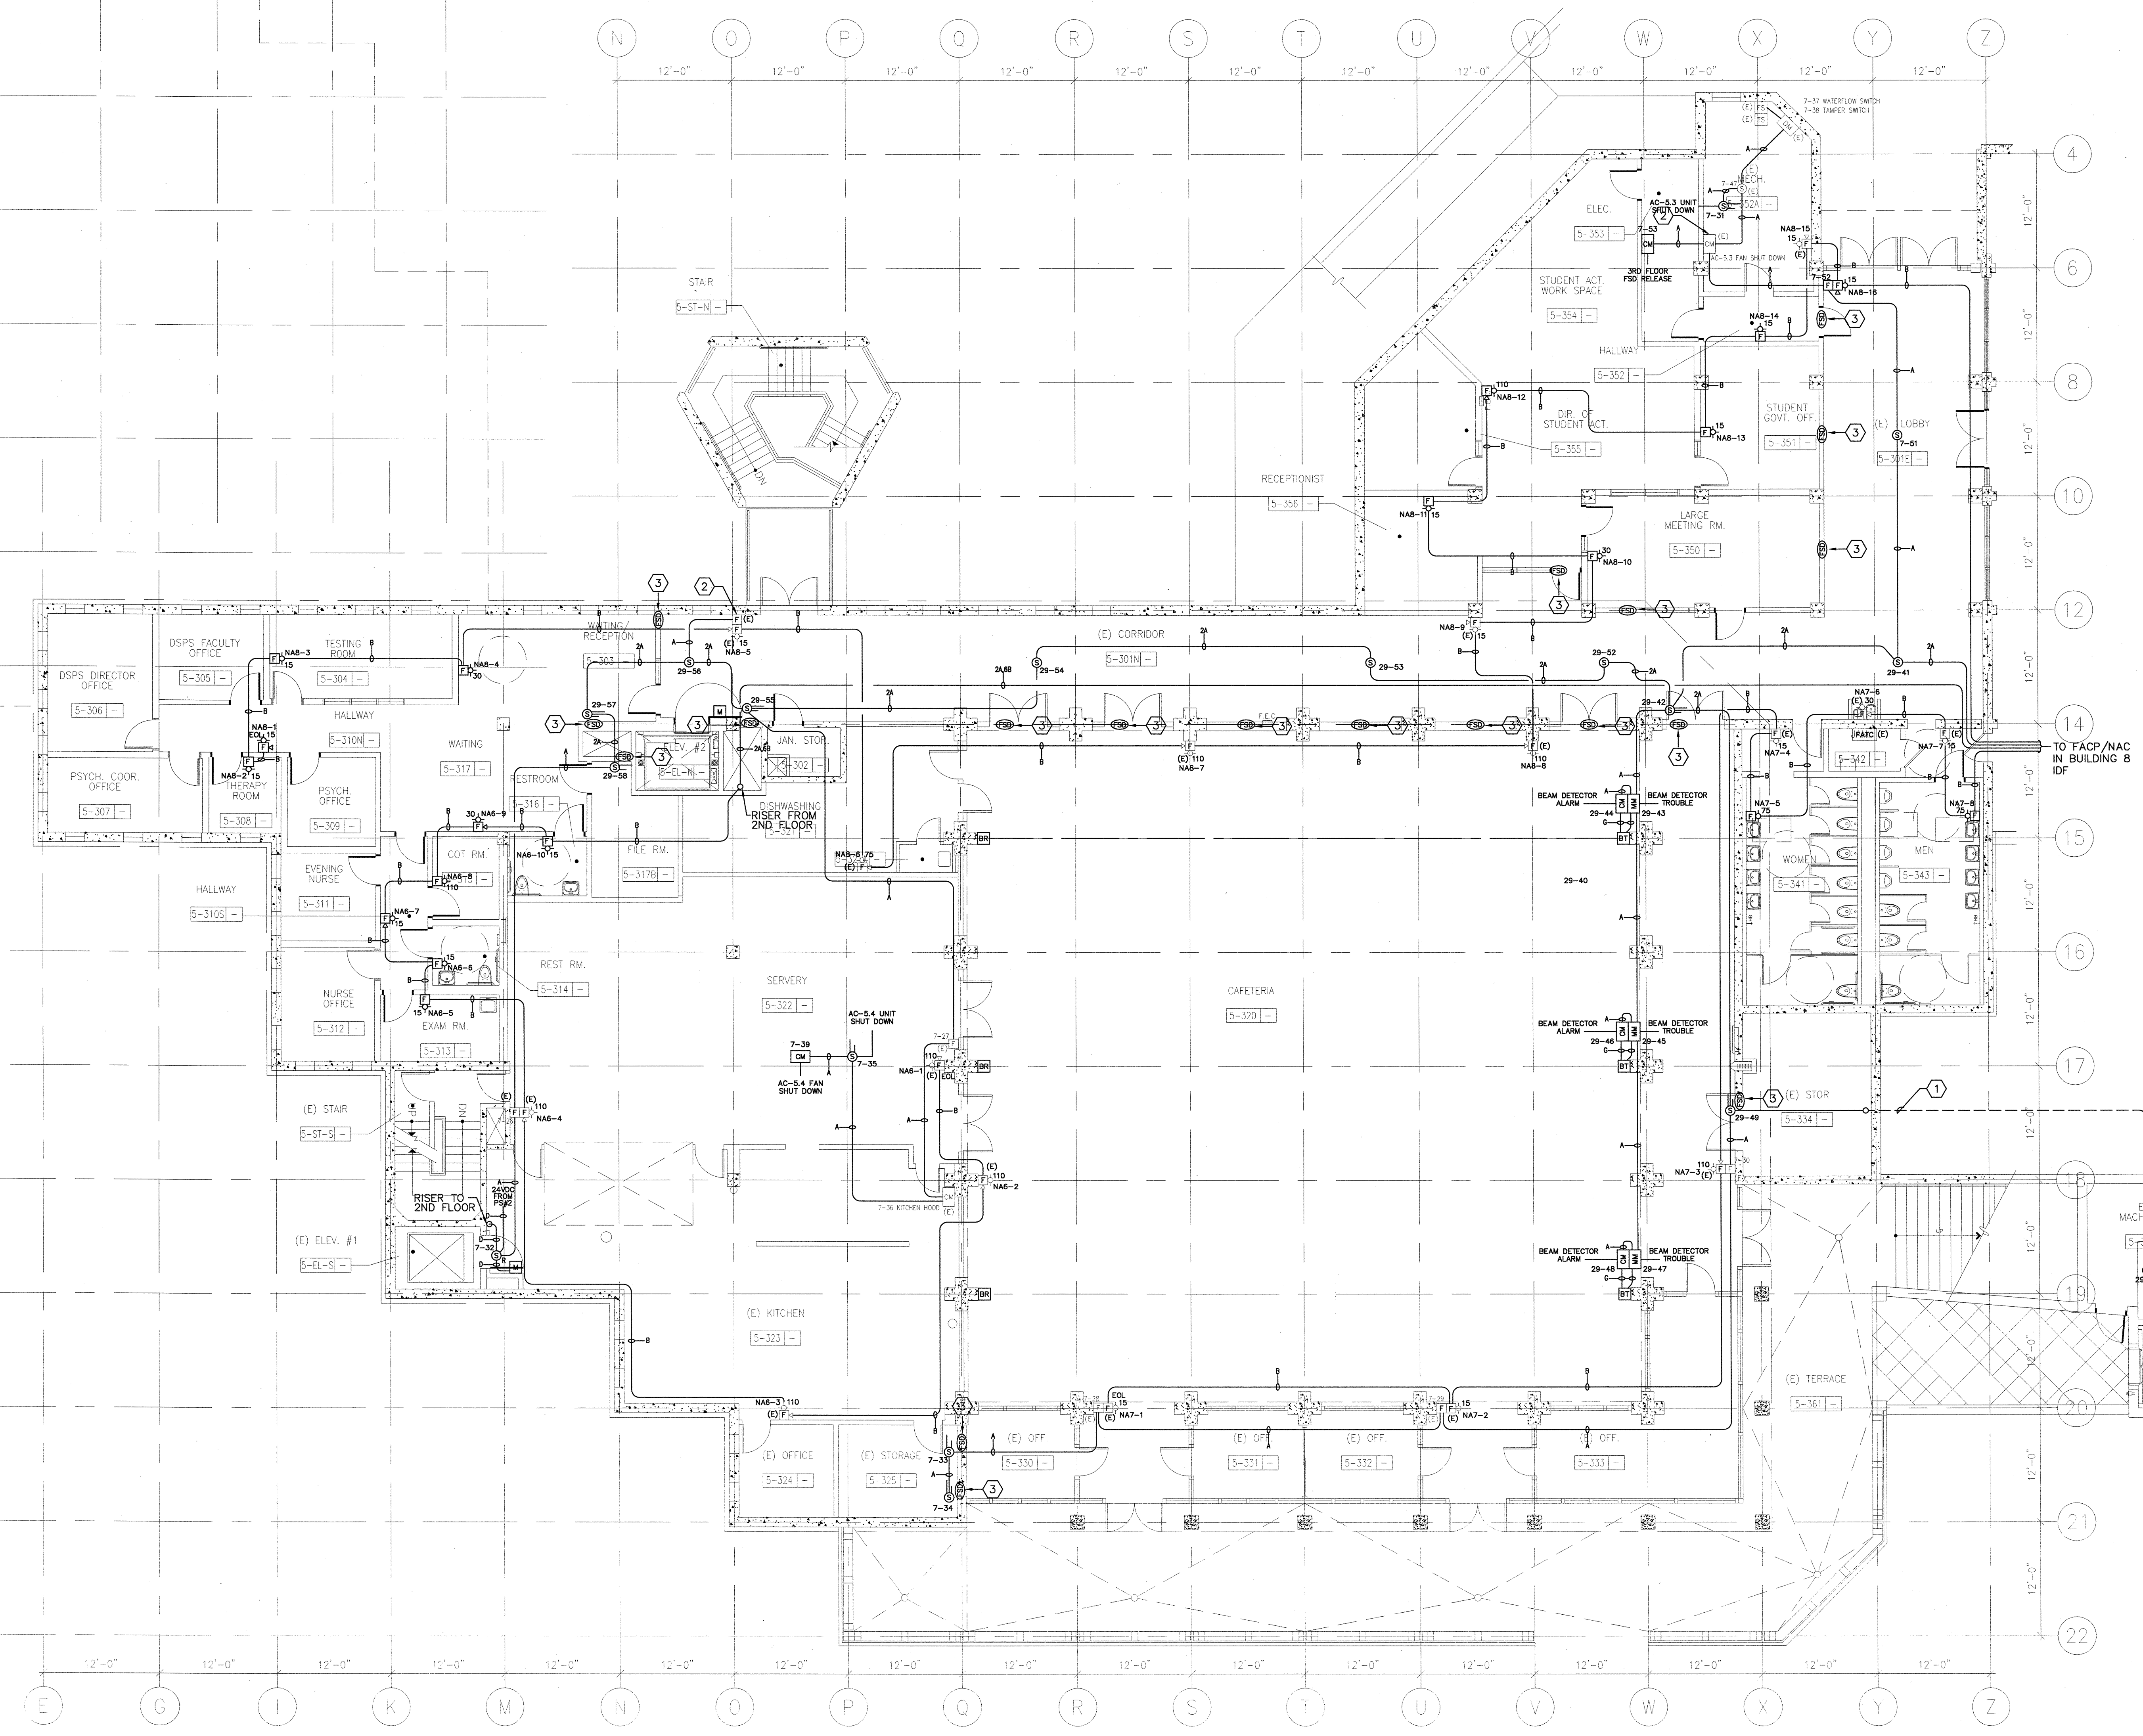

**FIRE ALARM PLAN
BUILDINGS 5 THIRD FLOOR**
SCALE: 1/8" = 1'-0"

DESIGN ENGINEER: PROJECT 2007-0731
CONTACT: **Intermountain Electric Company**

INTERFACE ENGINEERING
717 Market Street
Suite 500
San Francisco, CA 94103
TEL: 415.489.7240
FAX: 415.489.7289
www.interfaceengineering.com

ISA STAMP:

FILE NO. 41-C1

IDENTIFICATION STAMP
DIV. OF THE STATE ARCHITECT

01-110074

DATE: _____

CONTRACTOR'S NAME & ADDRESS:

InterMountain Electric Company
947 Washington Street
San Carlos CA 94070
Tel 650.591.7118 Fax 650.591.7123
contact@im-electric.com

PRODUCT MANUFACTURER:

SIEMENS Industry
SAN FRANCISCO BRANCH
25621 Industrial Boulevard, Suite 300
Hayward, California 94545-2991
Tel (510) 783-6000 Fax (510) 293-2100
California State C10 License No. 758796
U.L. Certificate ID No. 324787-001

JOB NAME & LOCATION (STREET ADDRESS):
FIRE ALARM FOR SAN MATEO COUNTY COMMUNITY COLLEGE DISTRICT

CAÑADA COLLEGE
BUILDINGS 5 AND 6
MODERNIZATION
4200 FARM HILL BOULEVARD
REDWOOD CITY, CA 94061

SHEET CONTENTS:
**FIRE ALARM PLAN
Bldg. 5 & 6 1ST FLOOR**

- INSTALLATION TYPE
- NEW INSTALLATION
 - DESIGN/BUILD
 - PER CONTRACT DOCUMENT
 - EXISTING BASE JOB # _____
 - OTHERS _____

SYSTEM SALES REP.: Kelly Rogers
PROJECT MANAGER: Jesse Mangosing
DRAWN BY: Ronald Babiera
CAD FILENAME: 440P-070529.DWG
SCALE: N/A
DATE DRAWN: April 07, 2010 PLOT DATE: May 11, 2010
SHEET: FA-08 JOB NUMBER: 440P-070529 NET NUMBER: 5249672

DRAWING IS SMALLER THAN 30" X 42" IT IS A REDUCED COPY