


BCA architecture planning interiors
210 Howard Ave. Fremont, California 94538
(774) 934-4400
(774) 934-4400

BCA Title: CONDENSER RELOCATION - FIRST FLOOR
Project Name: CANADA COLLEGE - BUILDINGS 5 & 6 RENOVATIONS
4200 FARM HILL BOULEVARD
REDWOOD CITY, CA 94061
FILE NO. 43-C1 APPL. 01-110074

PROFESSIONAL SEAL: BEN CAO, No. 032802, Exp. 12-31-2010, State of California

PROJECT CONTACT: 2007-0731, Ben Cao, Interface Engineering, 717 Market Street, Suite 300, San Francisco, CA 94103, Tel: 415-488-7288, Fax: 415-488-7289, www.interfaceengineering.com

Revision: DRAWING NO. 16
RFI-0183
Date: 08/27/10
Drawing Number: MSK-23
Project Number: 07013

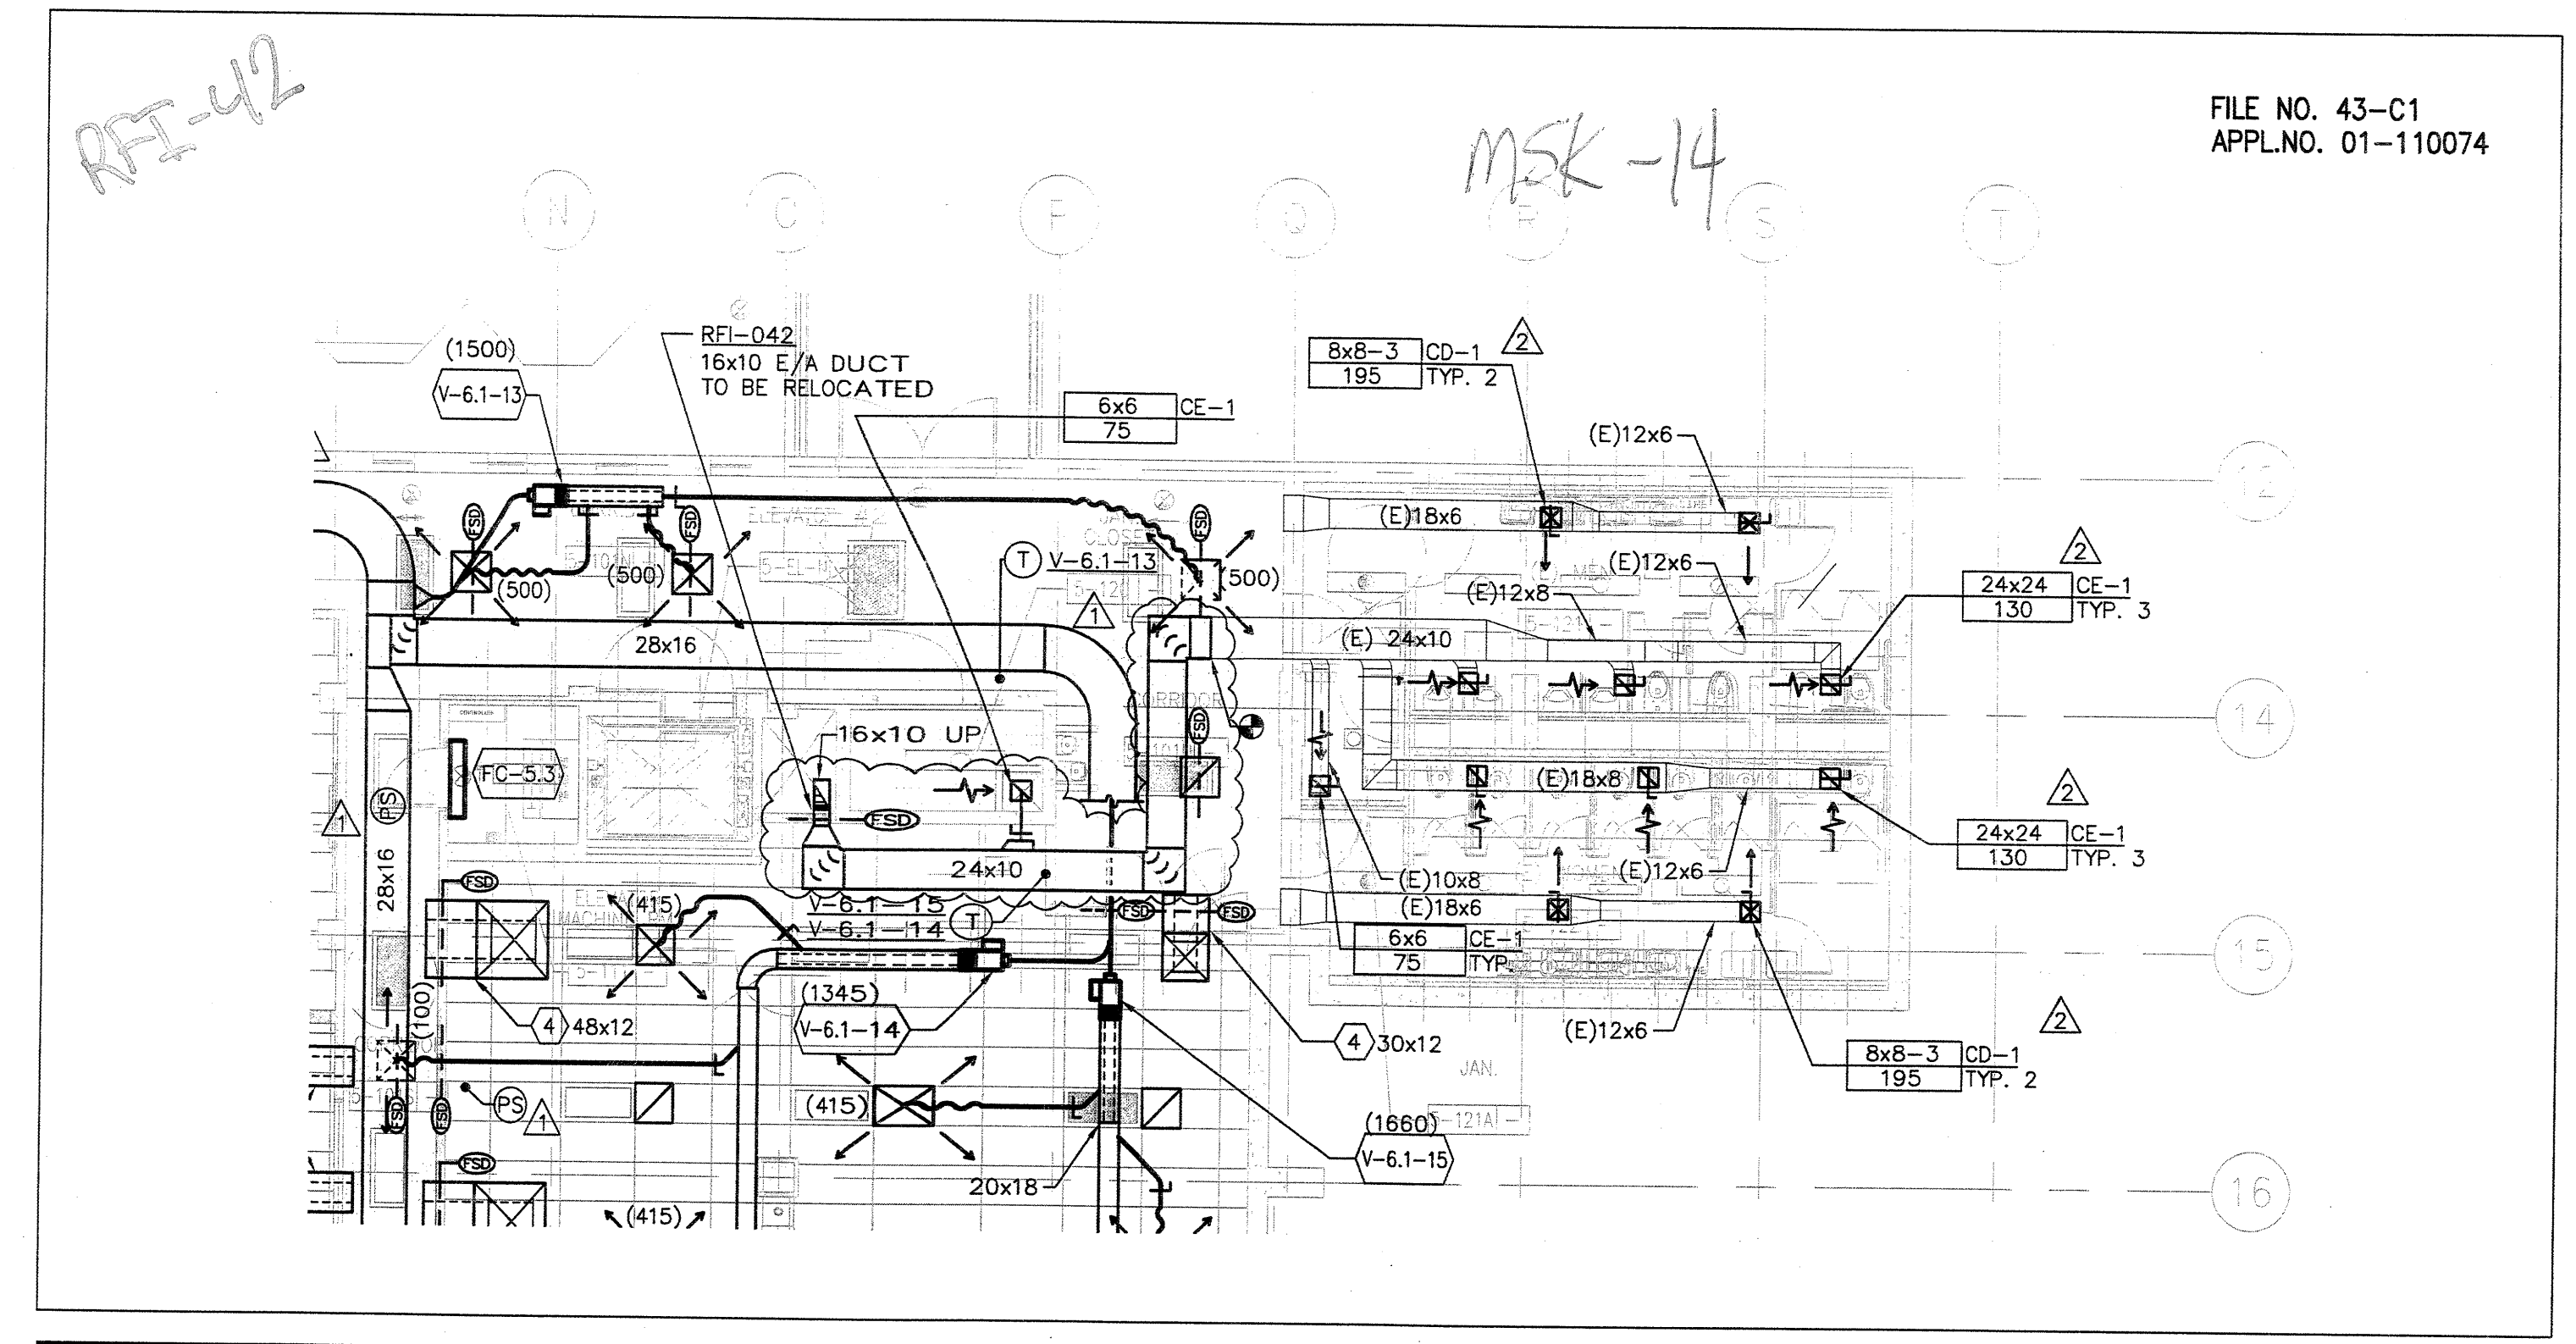

BCA architecture planning interiors
210 Howard Ave. Fremont, California 94538
(774) 934-4400
(774) 934-4400

BCA Title: PARTIAL MECHANICAL DUCTWORK PLAN - FIRST FLOOR
Project Name: CANADA COLLEGE - BUILDINGS 5 & 6 RENOVATIONS
4200 FARM HILL BOULEVARD
REDWOOD CITY, CA 94061
FILE NO. 43-C1 APPL. 01-110074


PROFESSIONAL SEAL: BEN CAO, No. 032802, Exp. 12-31-2010, State of California

PROJECT CONTACT: 2007-0731, Ben Cao, Interface Engineering, 717 Market Street, Suite 300, San Francisco, CA 94103, Tel: 415-488-7288, Fax: 415-488-7289, www.interfaceengineering.com


Revision: DRAWING NO. 16
RFI-0042
Date: 04/21/10
Drawing Number: MSK-14
Project Number: 07013

FILE: 0731M210.DWG - MSK14 | EDIT: 5/11/2010 11:33 AM BY ALLEN | PLOT: 5/11/2010 11:40 AM BY ALLEN |


Handwritten: RFP-46

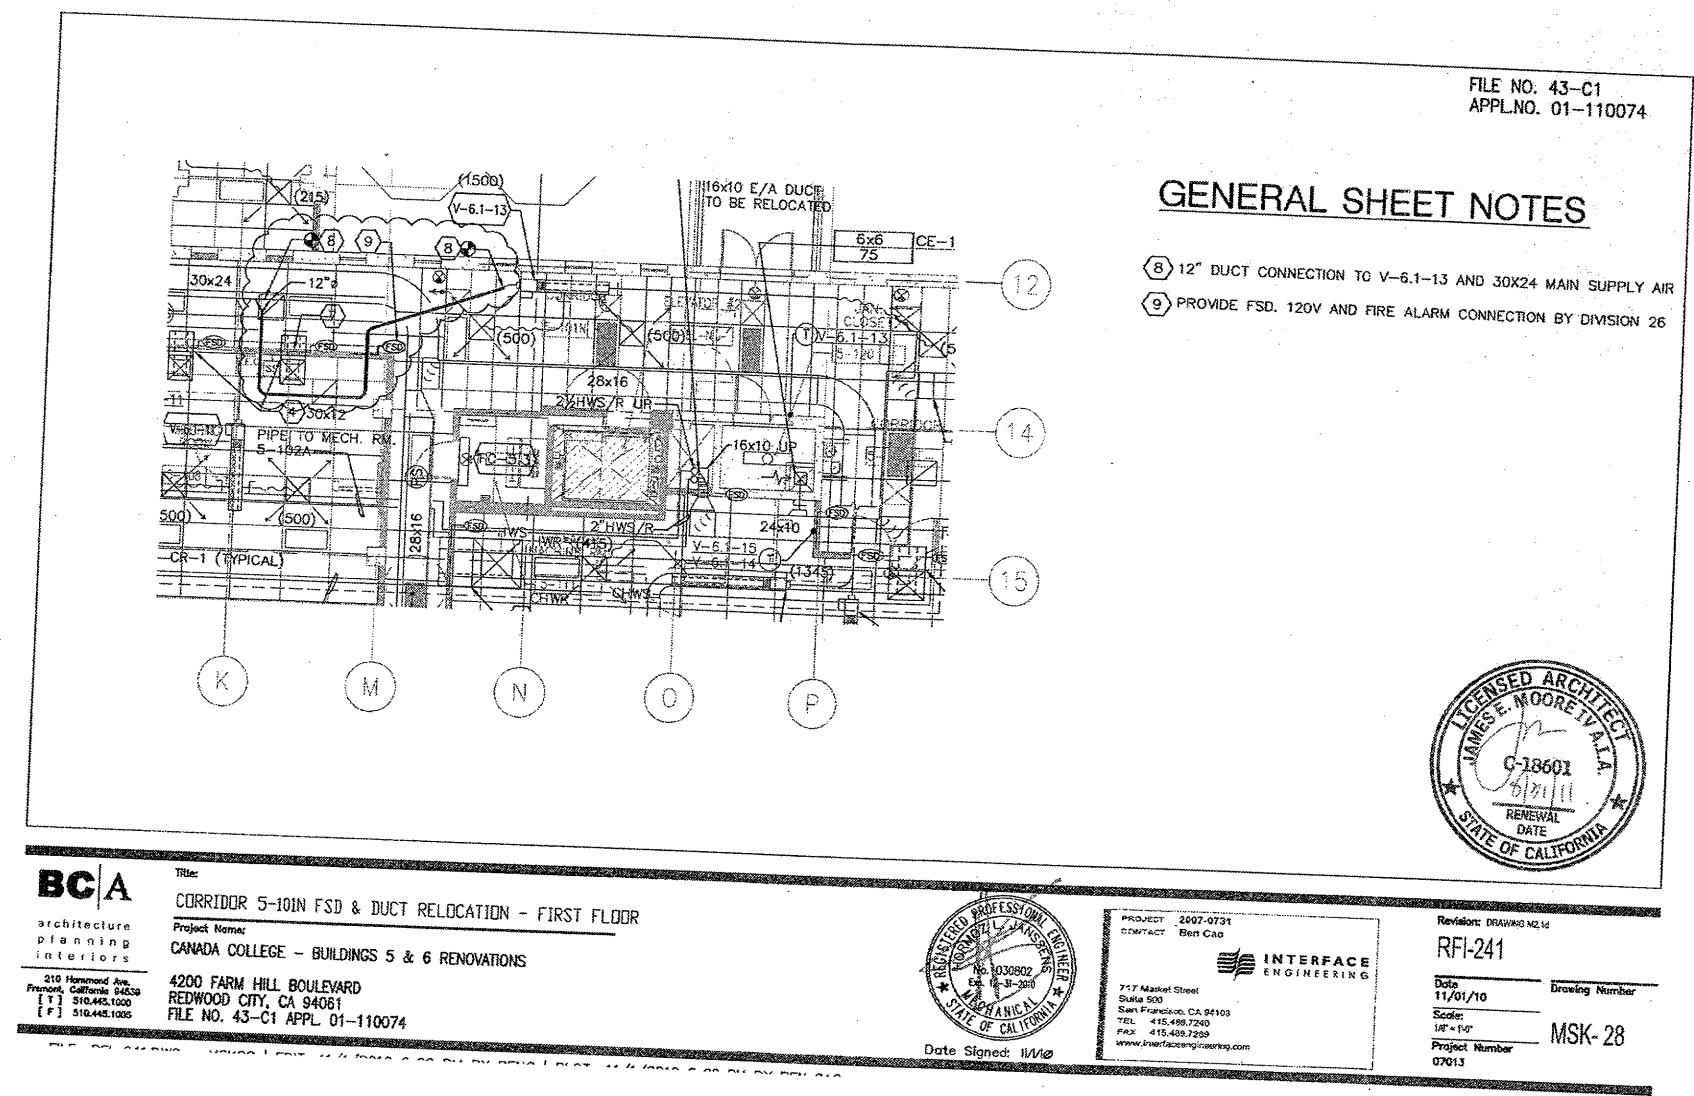

Handwritten: RFP-54

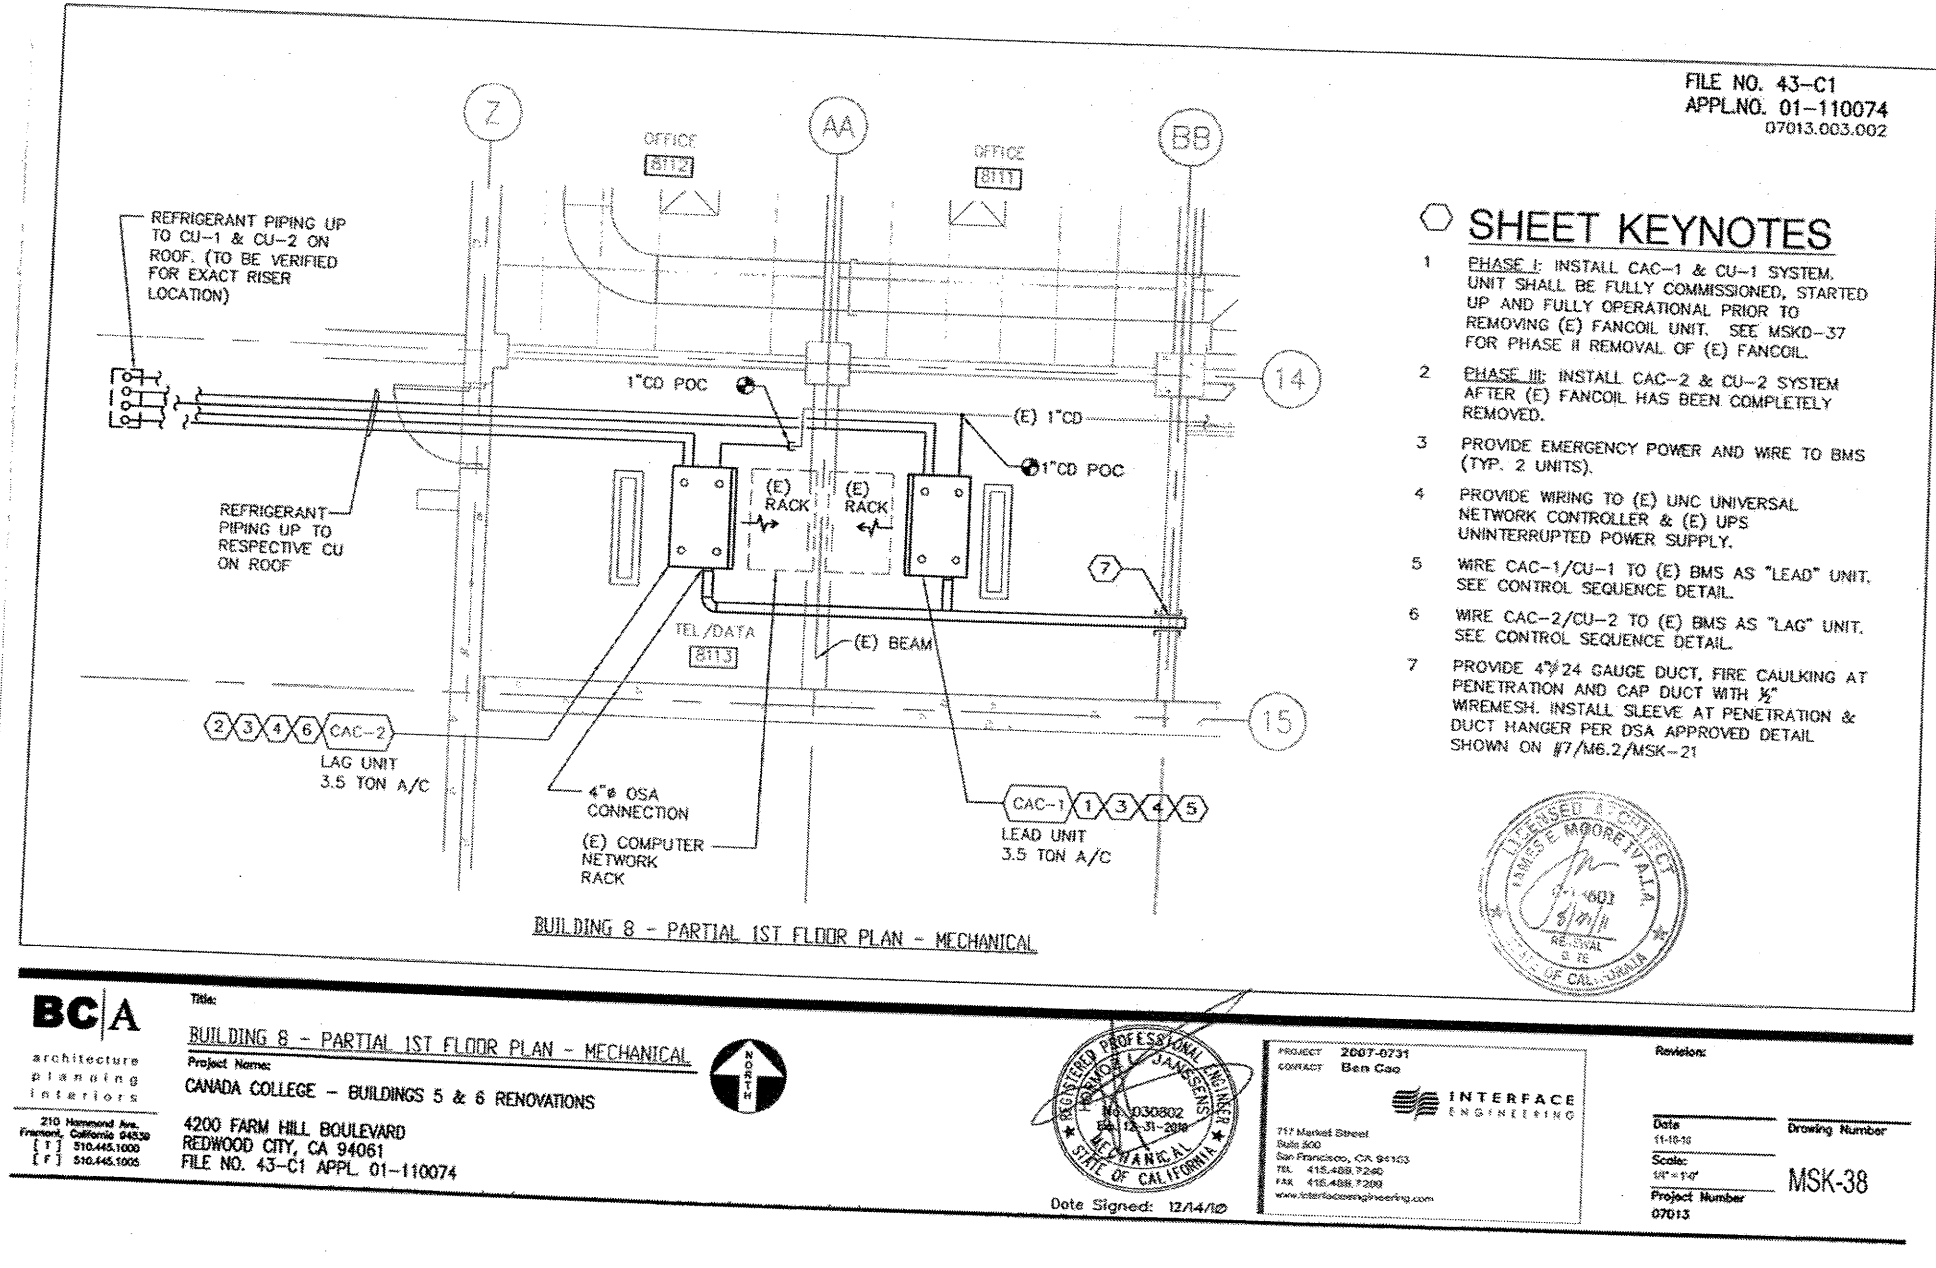

Handwritten: RFP-55

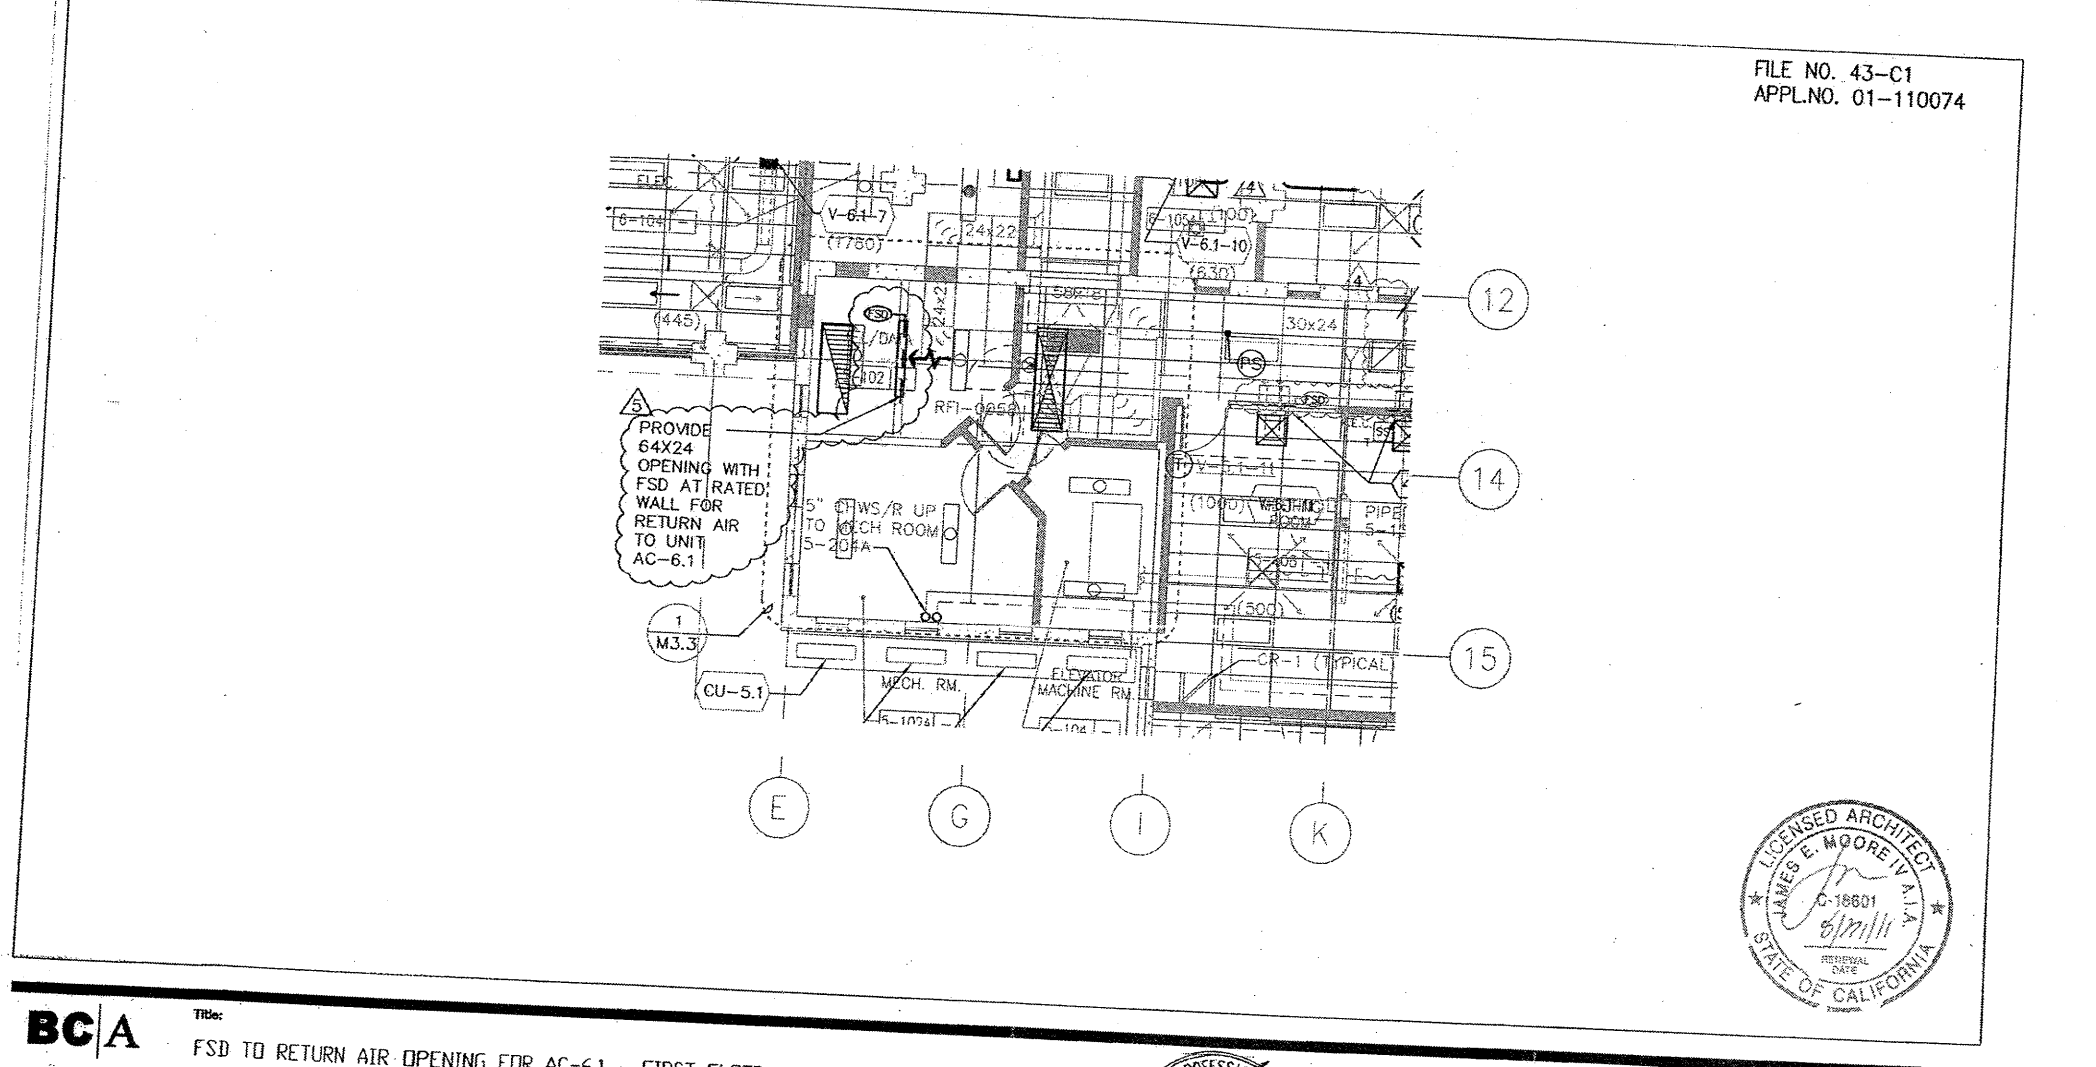

BCA Title: FSD TO RETURN AIR OPENING FOR AC-6.1 - FIRST FLOOR
Project Name: CANADA COLLEGE - BUILDINGS 5 & 6 RENOVATIONS
4200 FARM HILL BOULEVARD
REDWOOD CITY, CA 94061
FILE NO. 43-C1 APPL. 01-110074

PROFESSIONAL SEAL: BEN CAO, No. 032802, Exp. 12-31-2010, State of California

PROJECT CONTACT: 2007-0731, Ben Cao, Interface Engineering, 717 Market Street, Suite 300, San Francisco, CA 94103, Tel: 415-488-7288, Fax: 415-488-7289, www.interfaceengineering.com

Revision: DRAWING NO. 16
RFI-1812
Date: 08/27/10
Drawing Number: MSK-38
Project Number: 07013