


RFP-8

RFP-8

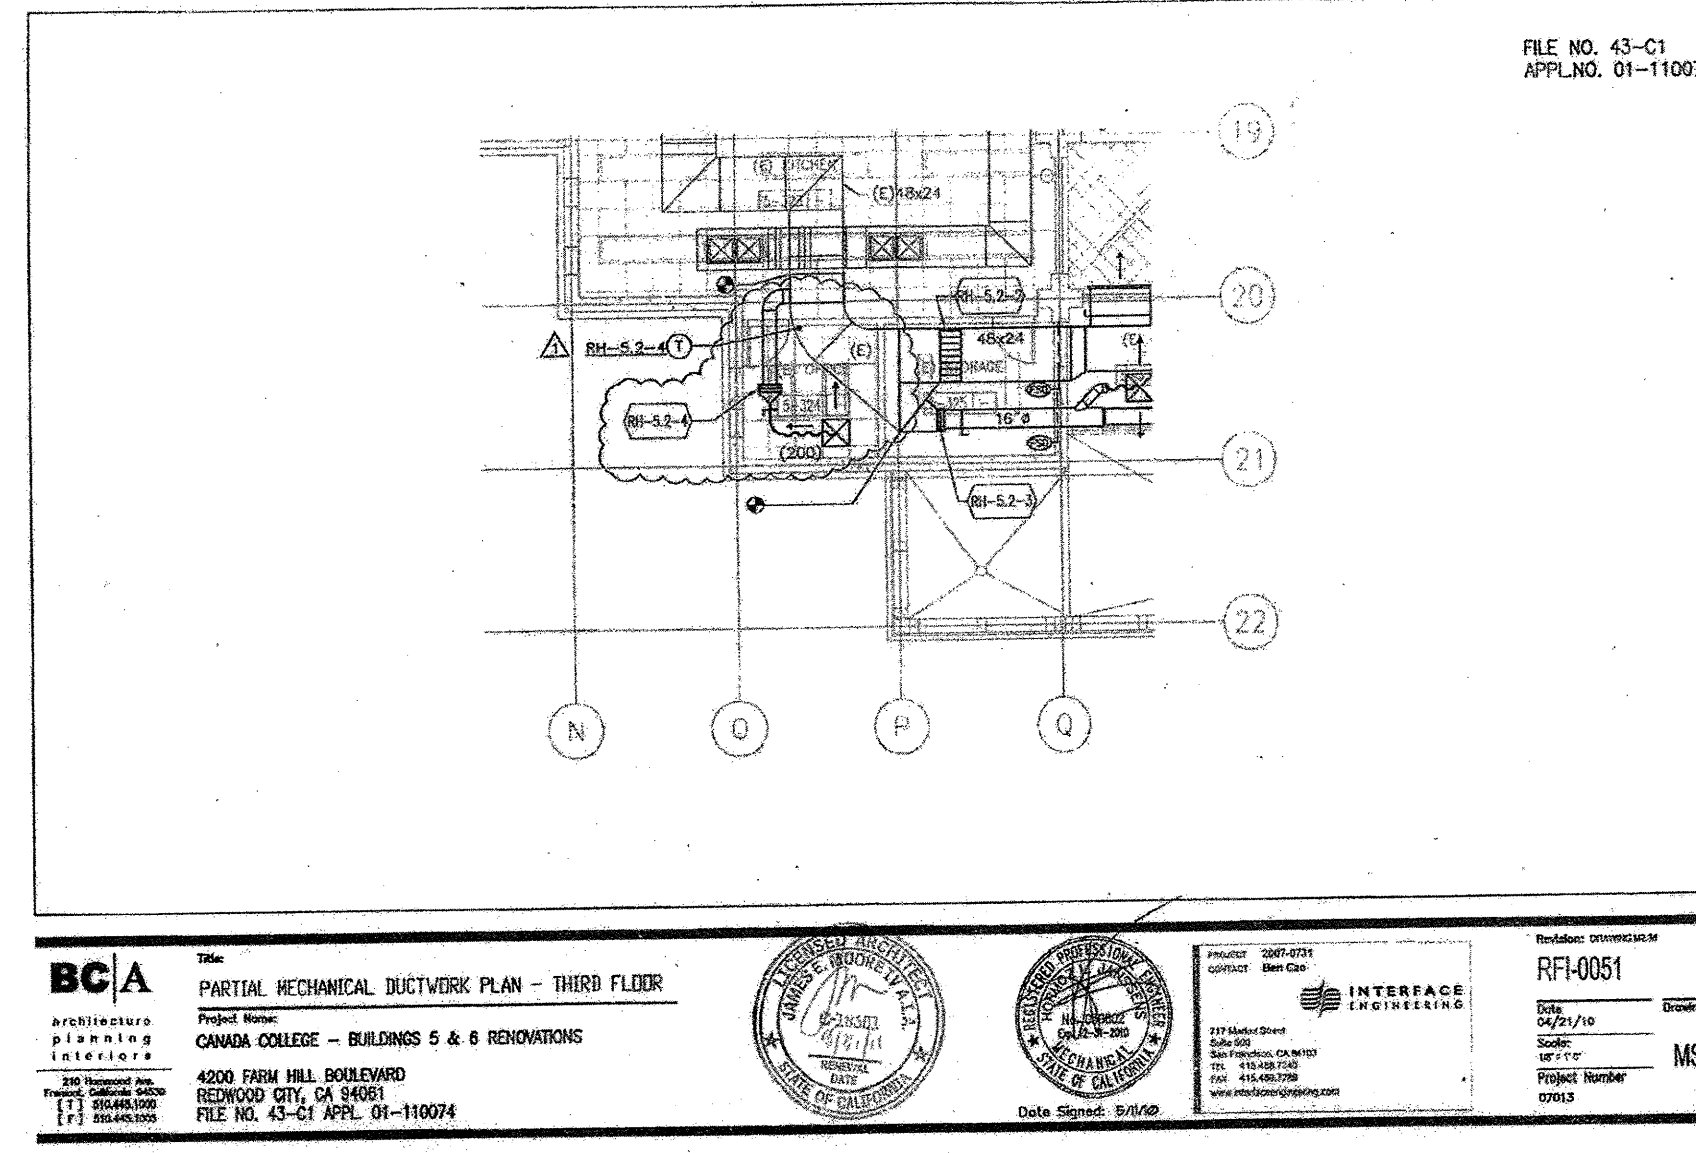


BCA PARTIAL MECHANICAL DUCTWORK PLAN - THIRD FLOOR
 CANADA COLLEGE - BUILDINGS 5 & 6 RENOVATIONS
 4200 FARM HILL BOULEVARD
 REDWOOD CITY, CA 94061
 FILE NO. 43-C1 APPL. 01-110074

INTERFACE ENGINEERING
 No. 030802
 No. 12-3-2010
 717 Market Street
 Suite 500
 San Francisco, CA 94103
 TEL: 415.469.7200
 FAX: 415.469.7269
 www.interfaceengineering.com

Revision: RFP-001
 Date: 05/11/10
 Scale: AS SHOWN
 Project Number: 07013

RFP-35

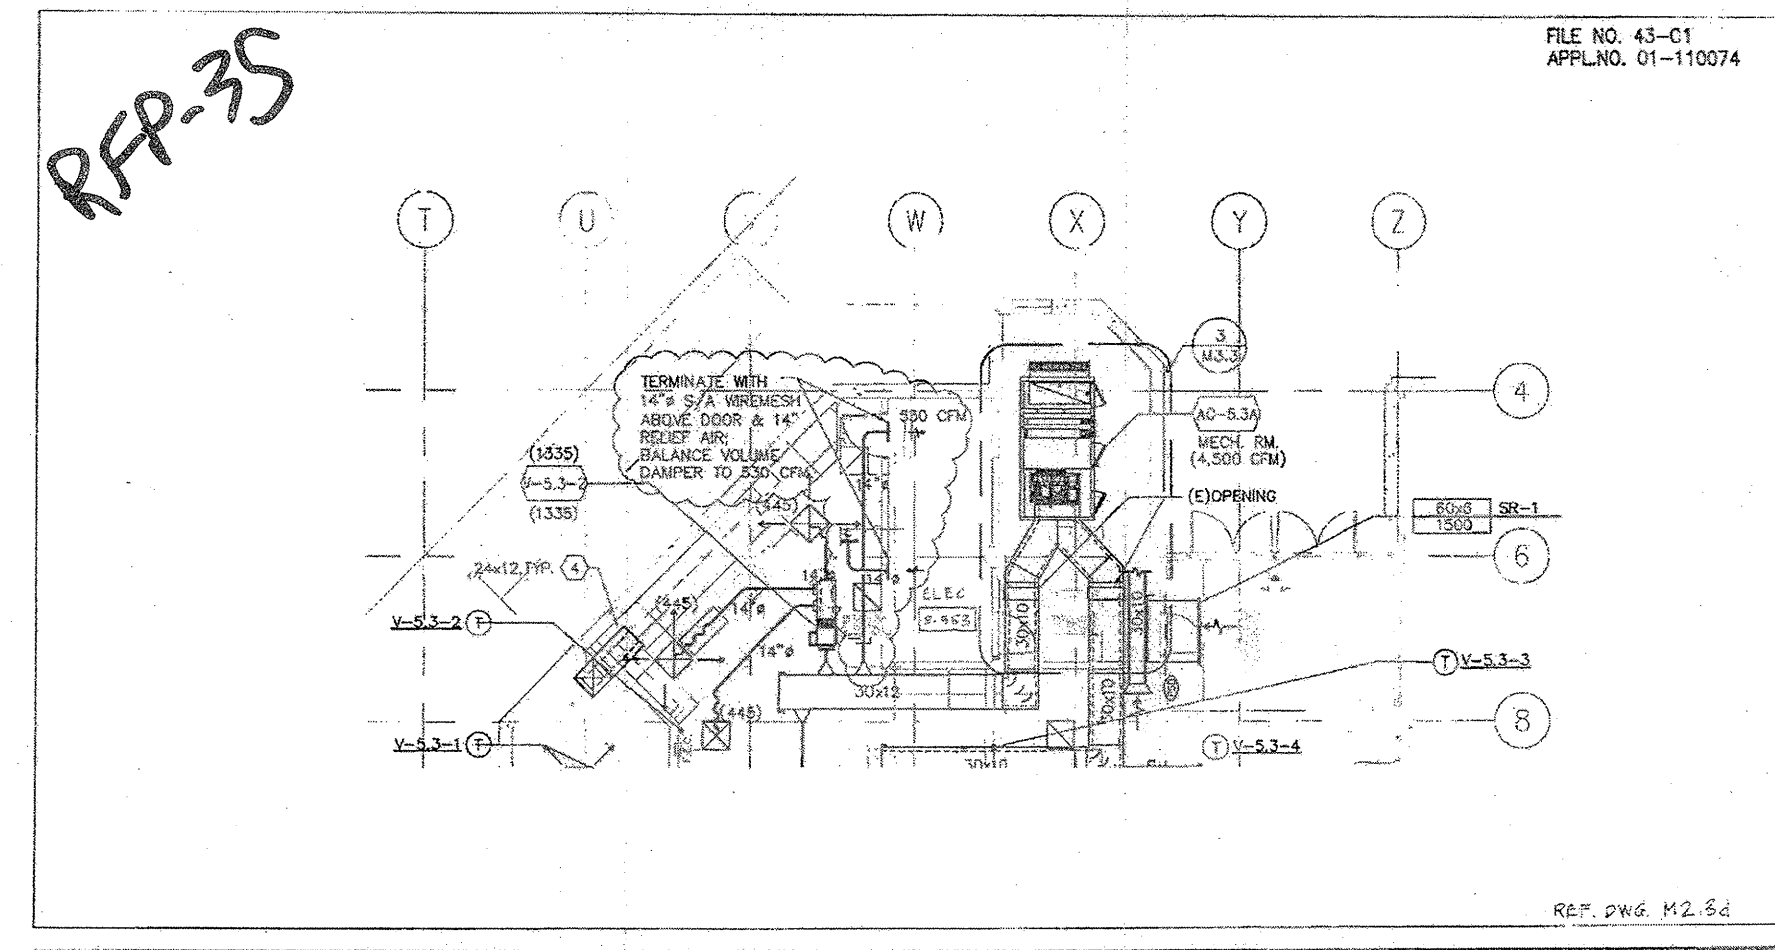


BCA ELECTRICAL ROOM 5-353 - THIRD FLOOR
 CANADA COLLEGE - BUILDINGS 5 & 6 RENOVATIONS
 4200 FARM HILL BOULEVARD
 REDWOOD CITY, CA 94061
 FILE NO. 43-C1 APPL. 01-110074

INTERFACE ENGINEERING
 No. 030802
 No. 12-3-2010
 717 Market Street
 Suite 500
 San Francisco, CA 94103
 TEL: 415.469.7200
 FAX: 415.469.7269
 www.interfaceengineering.com

Revision: RFP-35
 Date: 05/11/10
 Scale: AS SHOWN
 Project Number: 07013

RFP-45

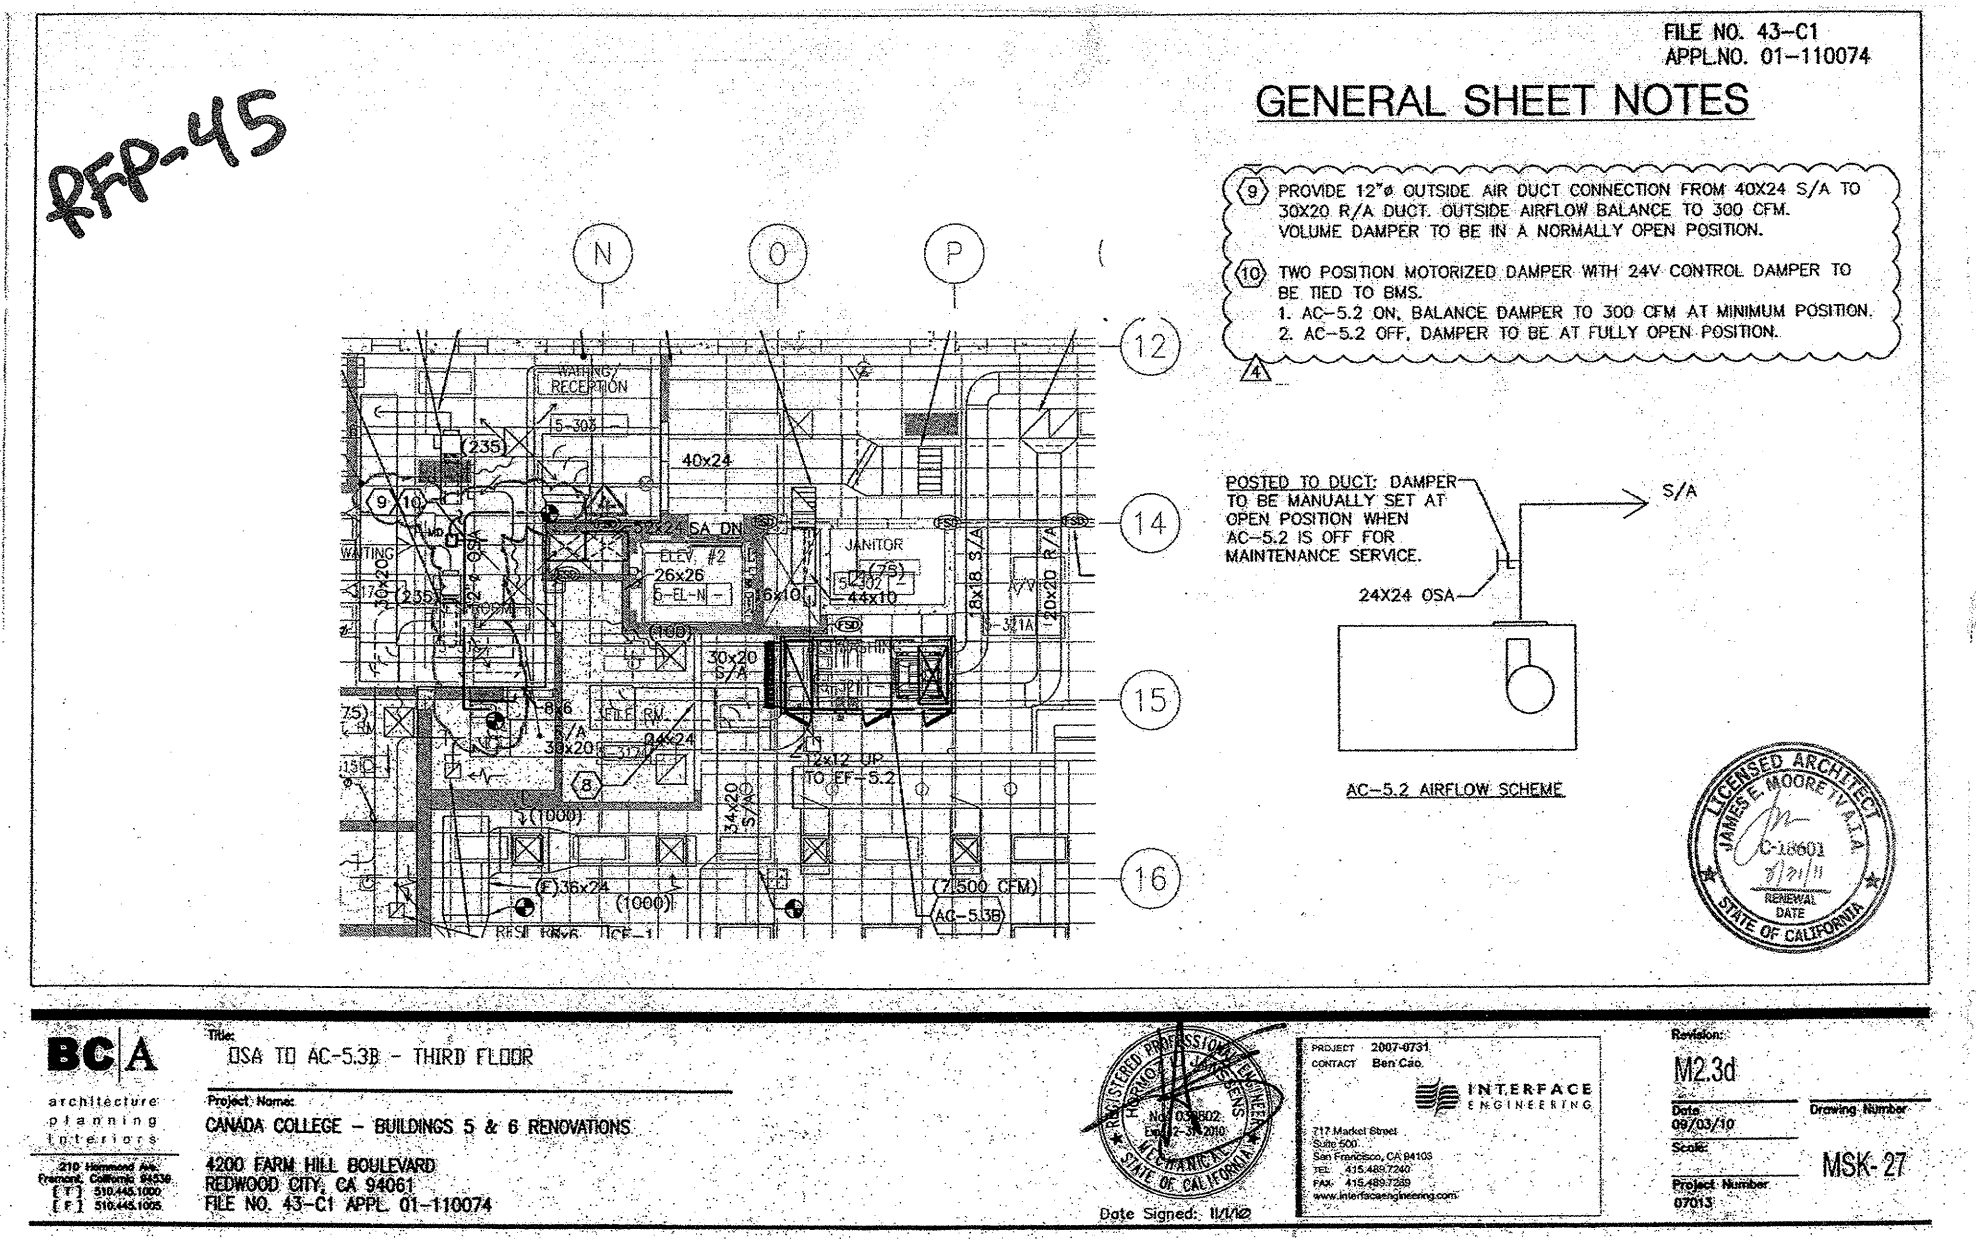


BCA PARTIAL MECHANICAL DUCTWORK PLAN - THIRD FLOOR
 CANADA COLLEGE - BUILDINGS 5 & 6 RENOVATIONS
 4200 FARM HILL BOULEVARD
 REDWOOD CITY, CA 94061
 FILE NO. 43-C1 APPL. 01-110074

INTERFACE ENGINEERING
 No. 030802
 No. 12-3-2010
 717 Market Street
 Suite 500
 San Francisco, CA 94103
 TEL: 415.469.7200
 FAX: 415.469.7269
 www.interfaceengineering.com

Revision: RFP-45
 Date: 05/11/10
 Scale: AS SHOWN
 Project Number: 07013

MSK-13

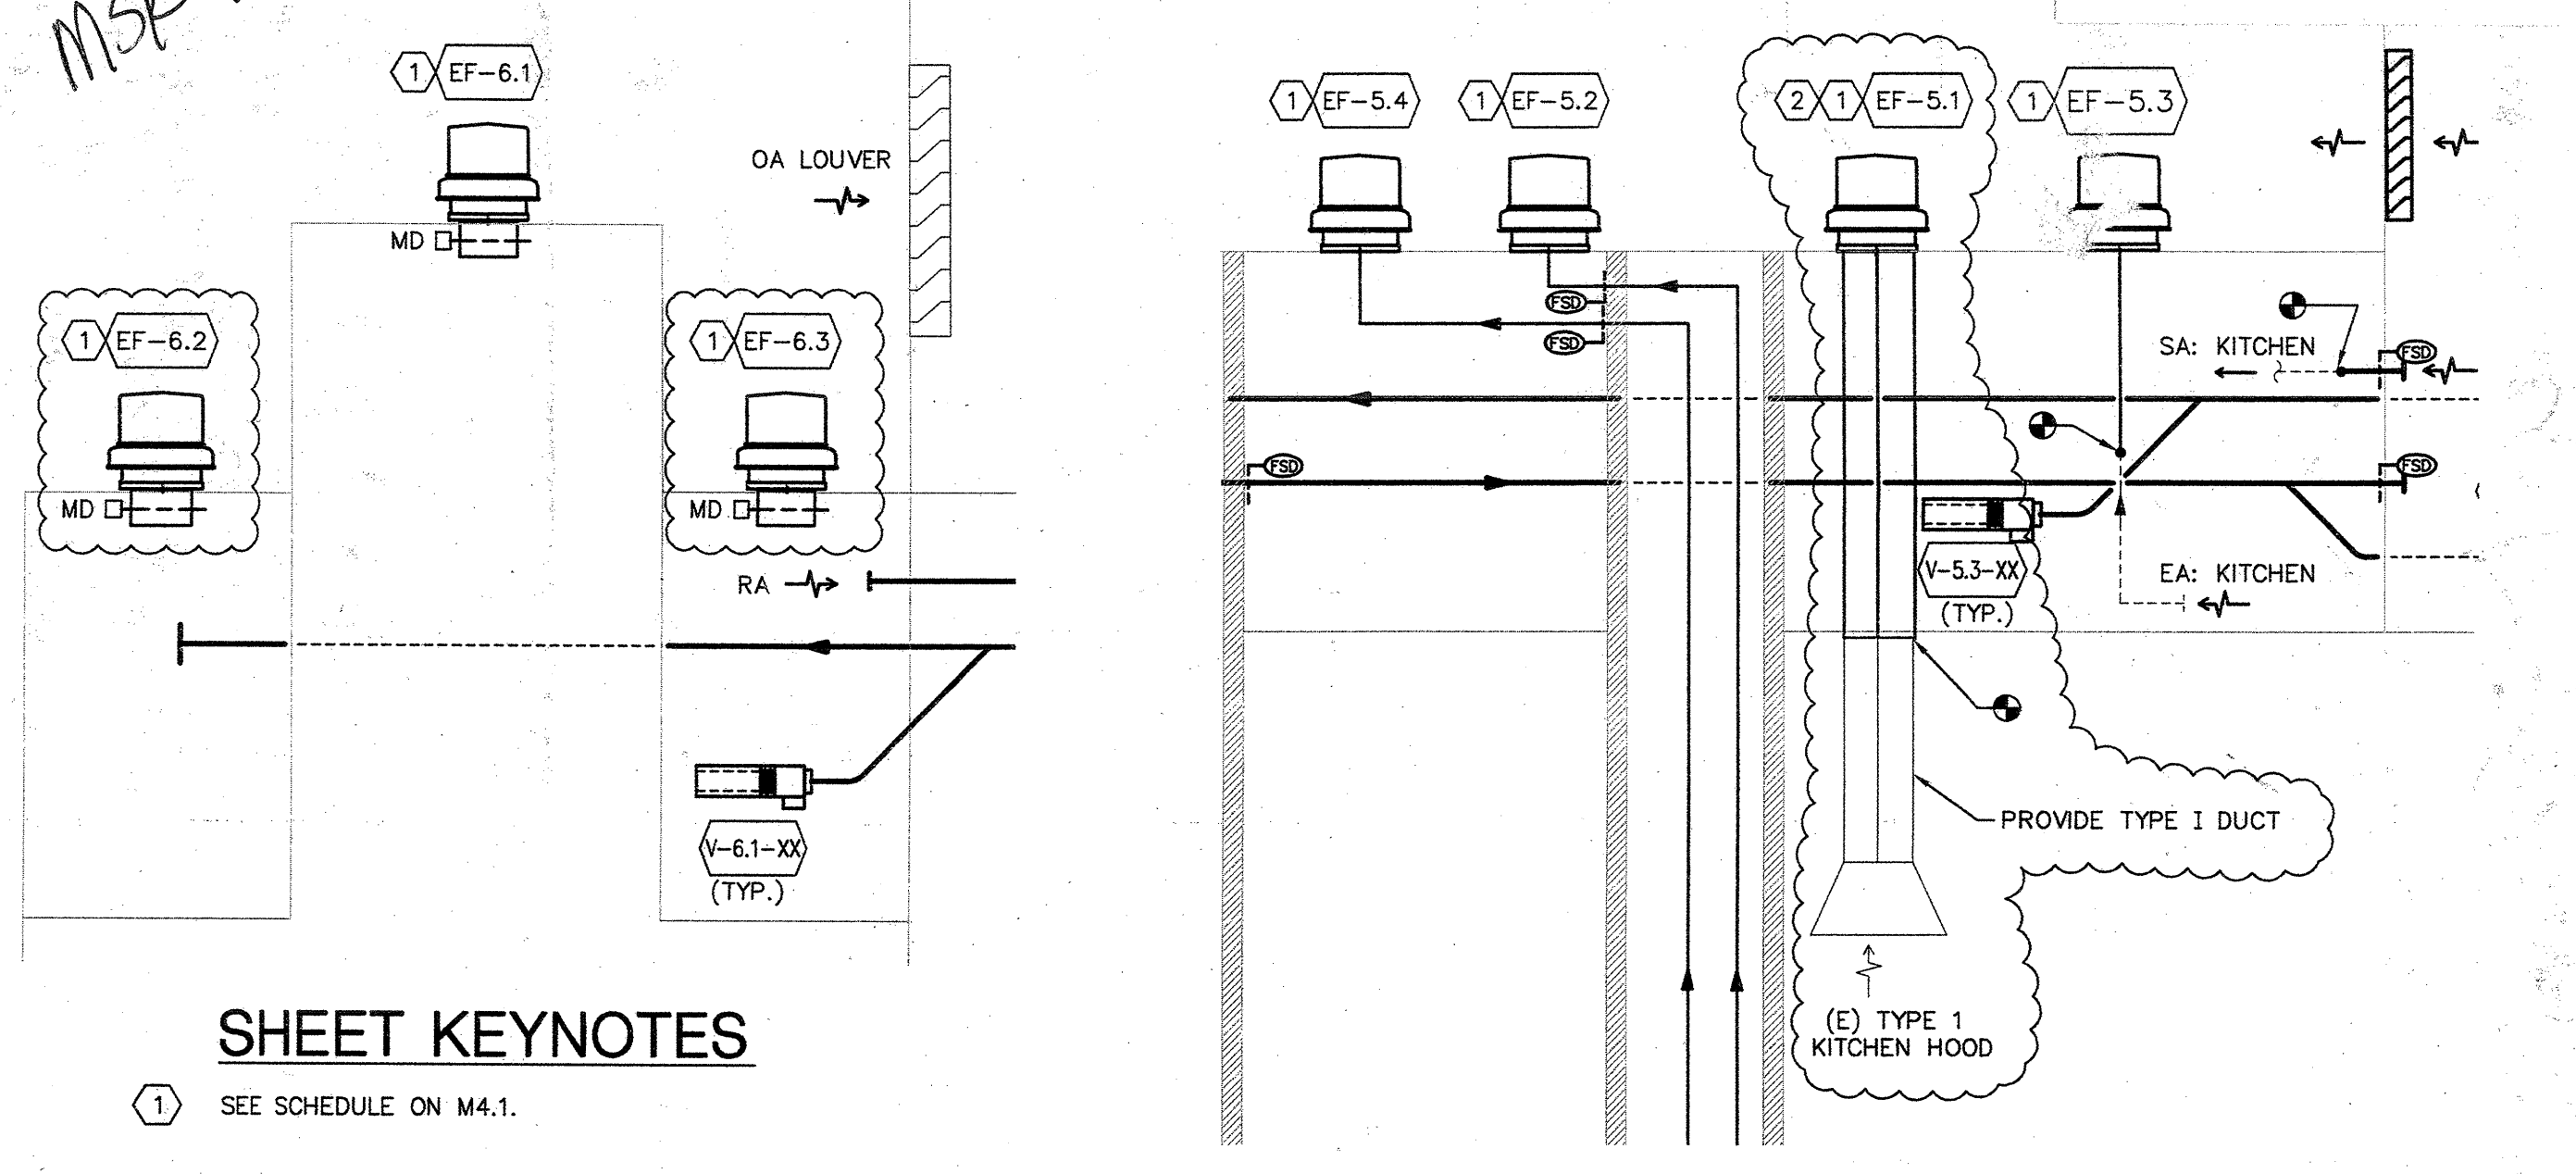


BCA ENLARGED MECHANICAL DUCTWORK PLAN - THIRD FLOOR
 CANADA COLLEGE - BUILDINGS 5 & 6 RENOVATIONS
 4200 FARM HILL BOULEVARD
 REDWOOD CITY, CA 94061
 FILE NO. 43-C1 APPL. 01-110074

INTERFACE ENGINEERING
 No. 030802
 No. 12-3-2010
 717 Market Street
 Suite 500
 San Francisco, CA 94103
 TEL: 415.469.7200
 FAX: 415.469.7269
 www.interfaceengineering.com

Revision: MSK-13
 Date: 05/11/10
 Scale: AS SHOWN
 Project Number: 07013

MSK-02

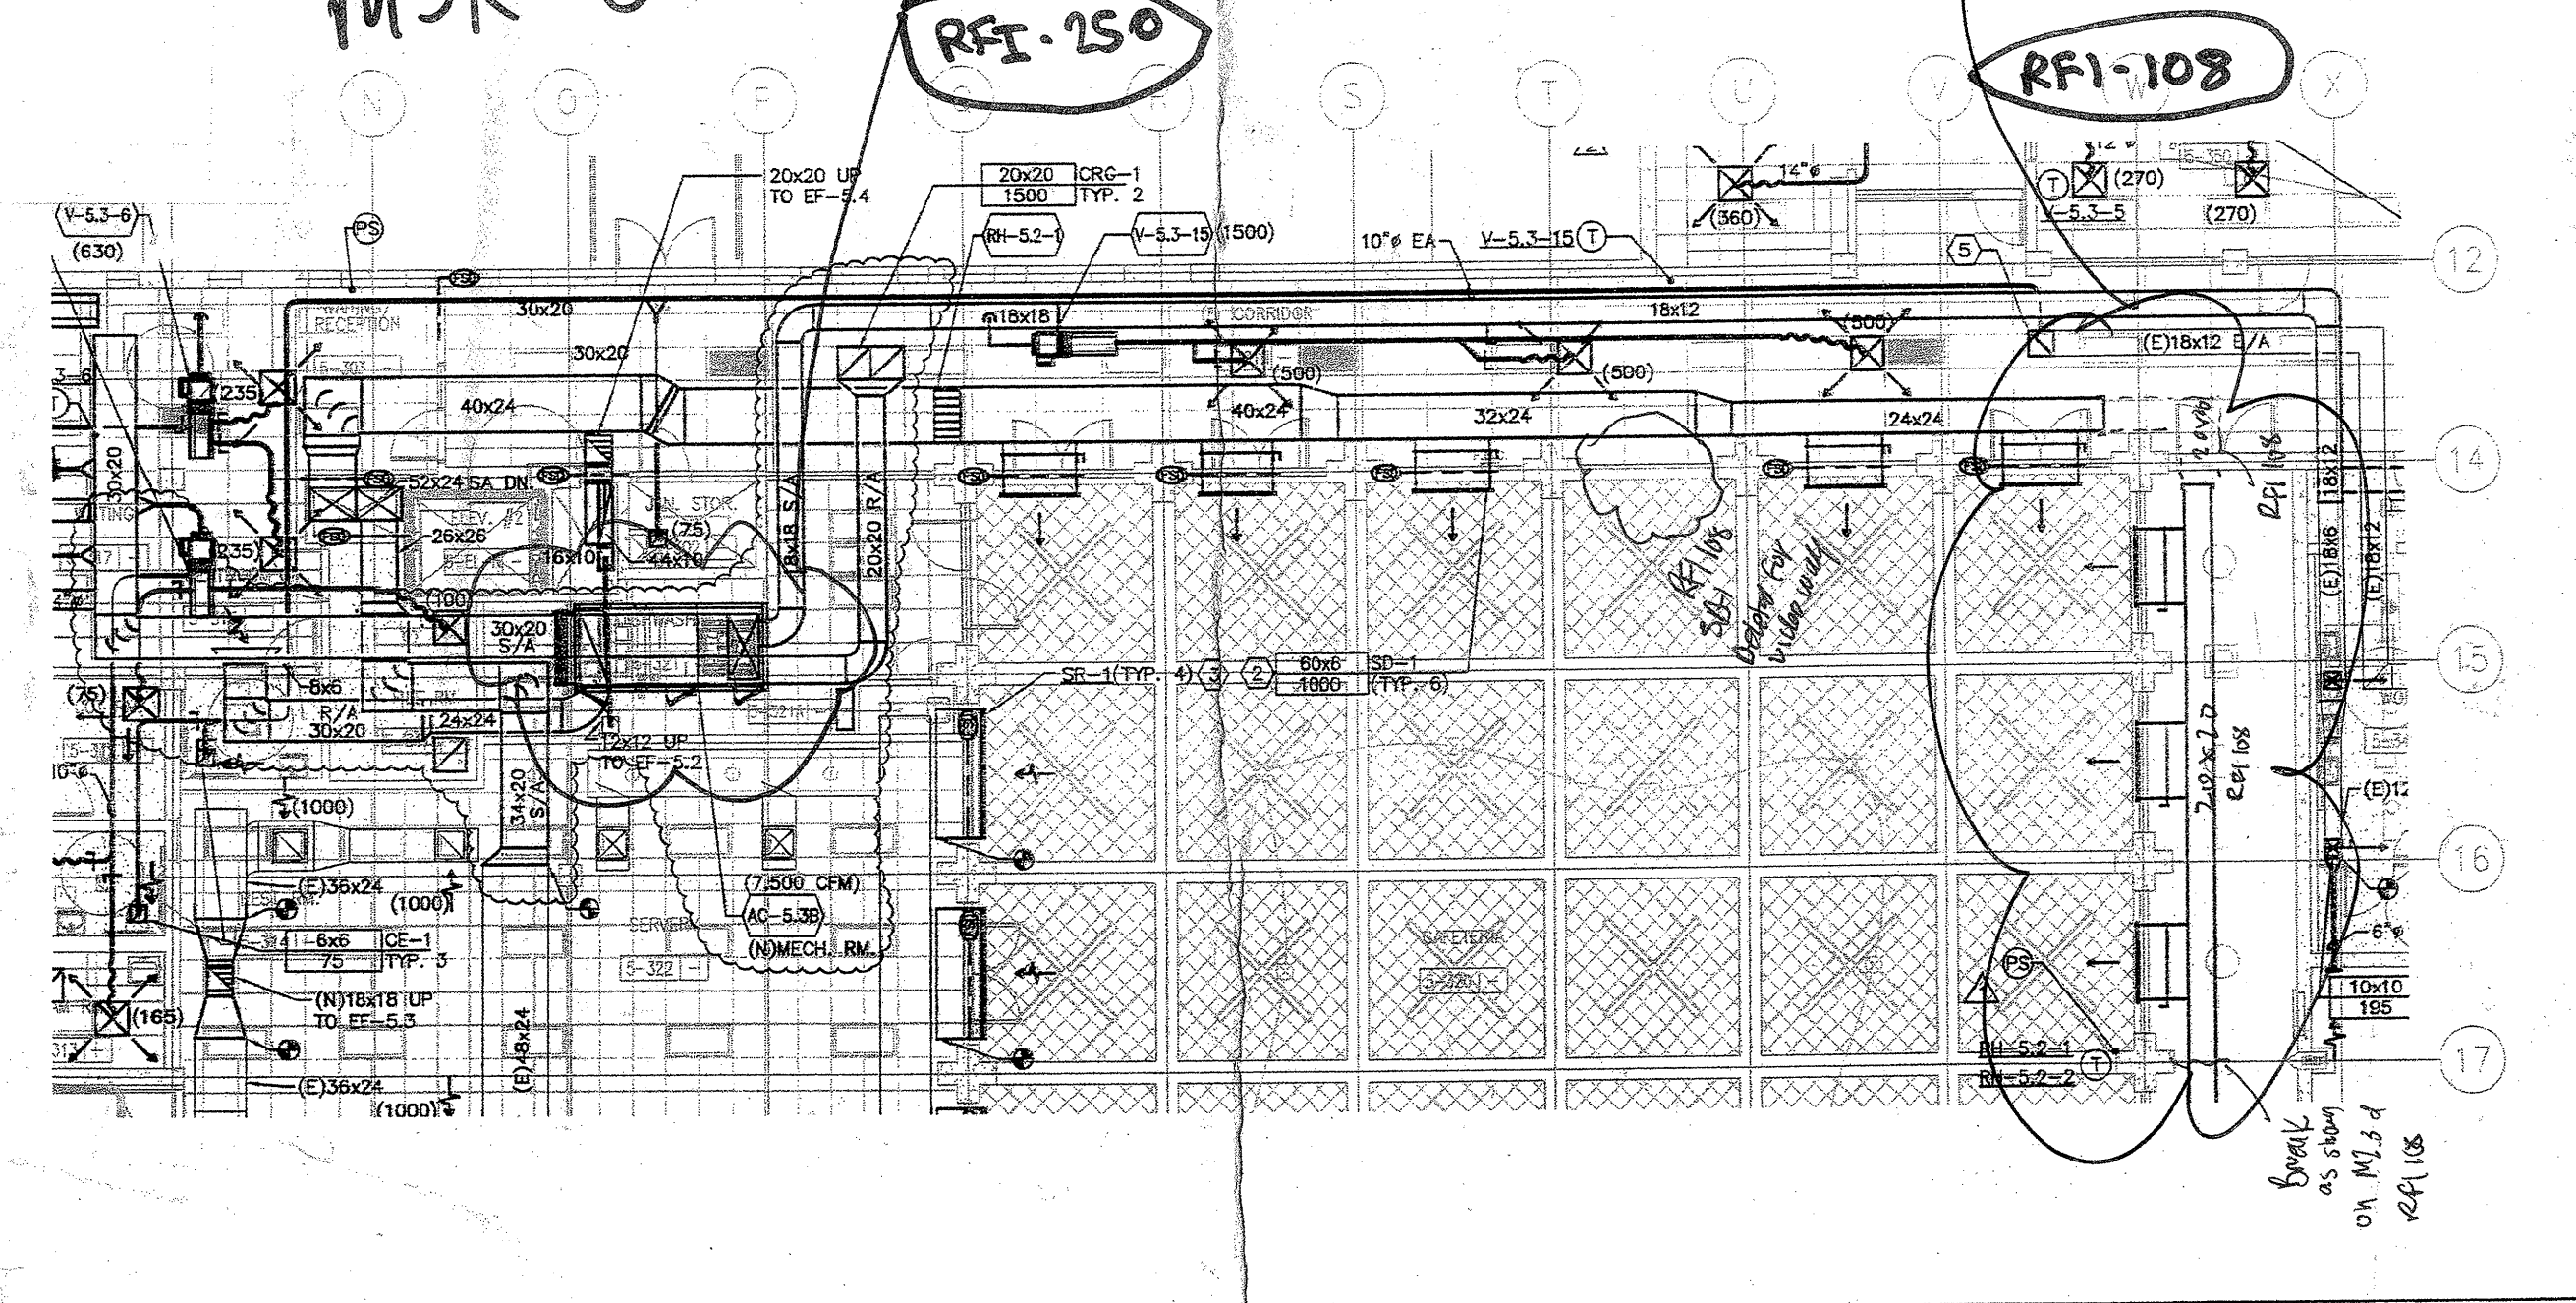


BCA PARTIAL MECHANICAL DUCTWORK PLAN - THIRD FLOOR
 CANADA COLLEGE - BUILDINGS 5 & 6 RENOVATIONS
 4200 FARM HILL BOULEVARD
 REDWOOD CITY, CA 94061
 FILE NO. 43-C1 APPL. 01-110074

INTERFACE ENGINEERING
 No. 030802
 No. 12-3-2010
 717 Market Street
 Suite 500
 San Francisco, CA 94103
 TEL: 415.469.7200
 FAX: 415.469.7269
 www.interfaceengineering.com

Revision: MSK-02
 Date: 05/11/10
 Scale: AS SHOWN
 Project Number: 07013

RFP-53

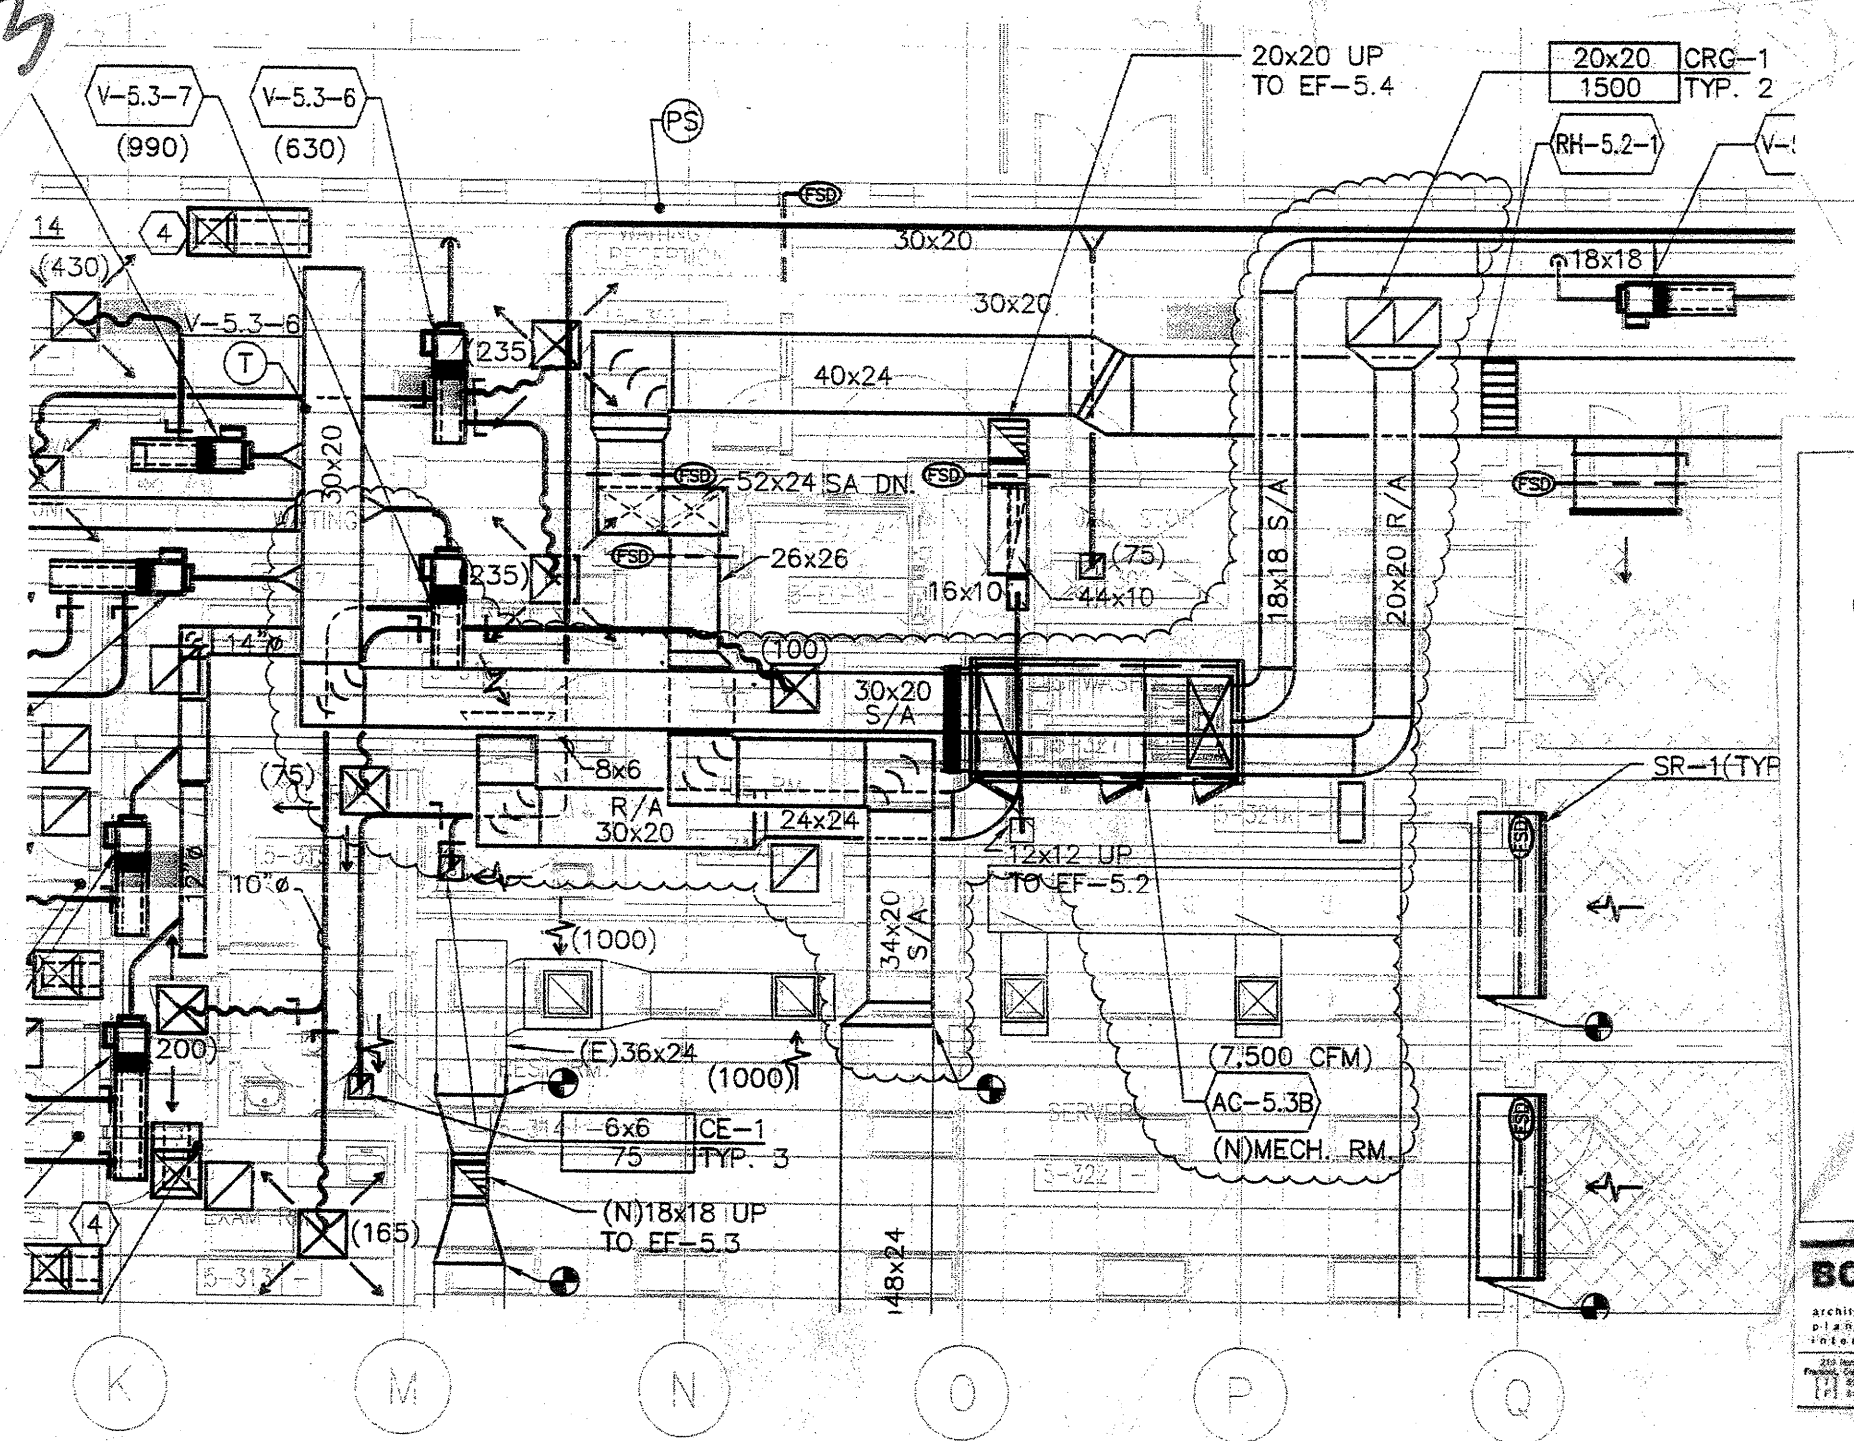


BCA ENLARGED ELEVATOR MACHINE ROOM - MECHANICAL
 CANADA COLLEGE - BUILDINGS 5 & 6 RENOVATIONS
 4200 FARM HILL BOULEVARD
 REDWOOD CITY, CA 94061
 FILE NO. 43-C1 APPL. 01-110074

INTERFACE ENGINEERING
 No. 030802
 No. 12-3-2010
 717 Market Street
 Suite 500
 San Francisco, CA 94103
 TEL: 415.469.7200
 FAX: 415.469.7269
 www.interfaceengineering.com

Revision: RFP-53
 Date: 05/11/10
 Scale: AS SHOWN
 Project Number: 07013

RFP-59

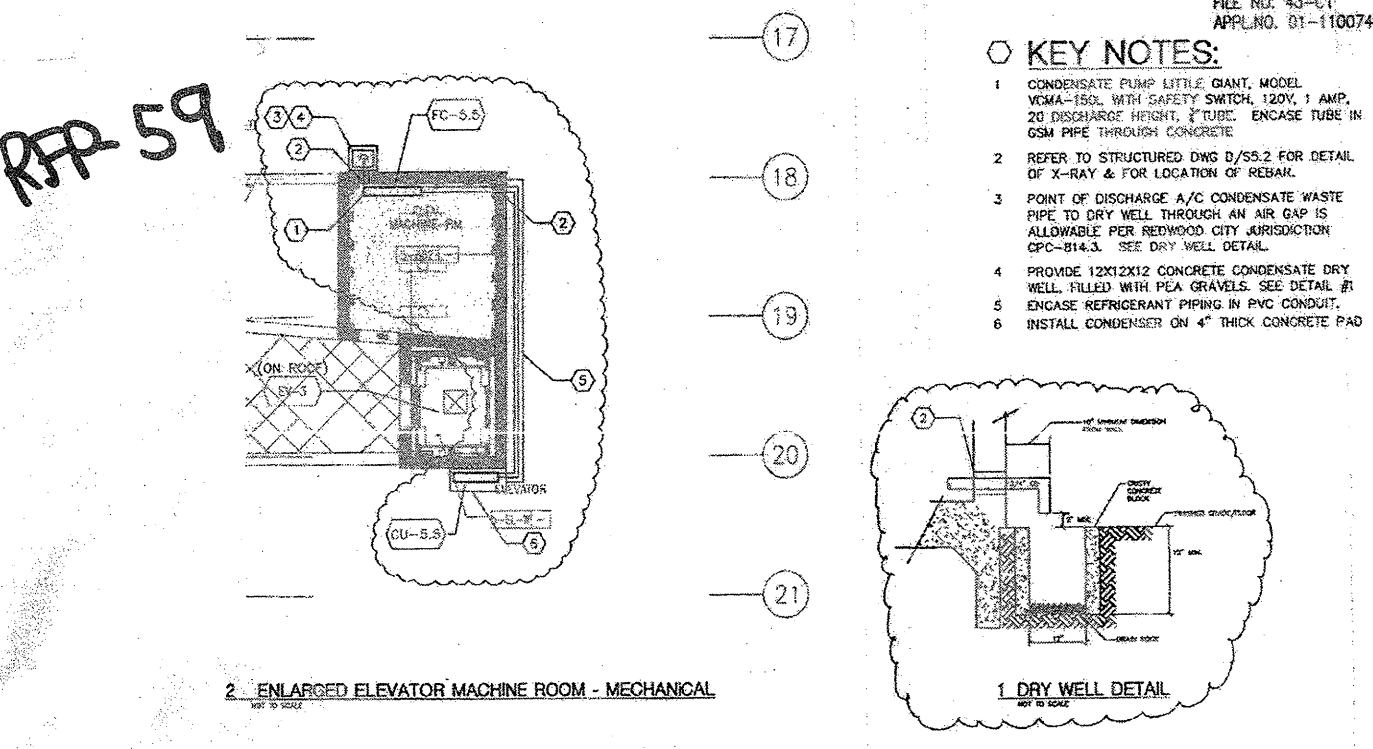


BCA LOBBY WELL DETAIL
 CANADA COLLEGE - BUILDINGS 5 & 6 RENOVATIONS
 4200 FARM HILL BOULEVARD
 REDWOOD CITY, CA 94061
 FILE NO. 43-C1 APPL. 01-110074

INTERFACE ENGINEERING
 No. 030802
 No. 12-3-2010
 717 Market Street
 Suite 500
 San Francisco, CA 94103
 TEL: 415.469.7200
 FAX: 415.469.7269
 www.interfaceengineering.com

Revision: RFP-59
 Date: 05/11/10
 Scale: AS SHOWN
 Project Number: 07013

MSK-01

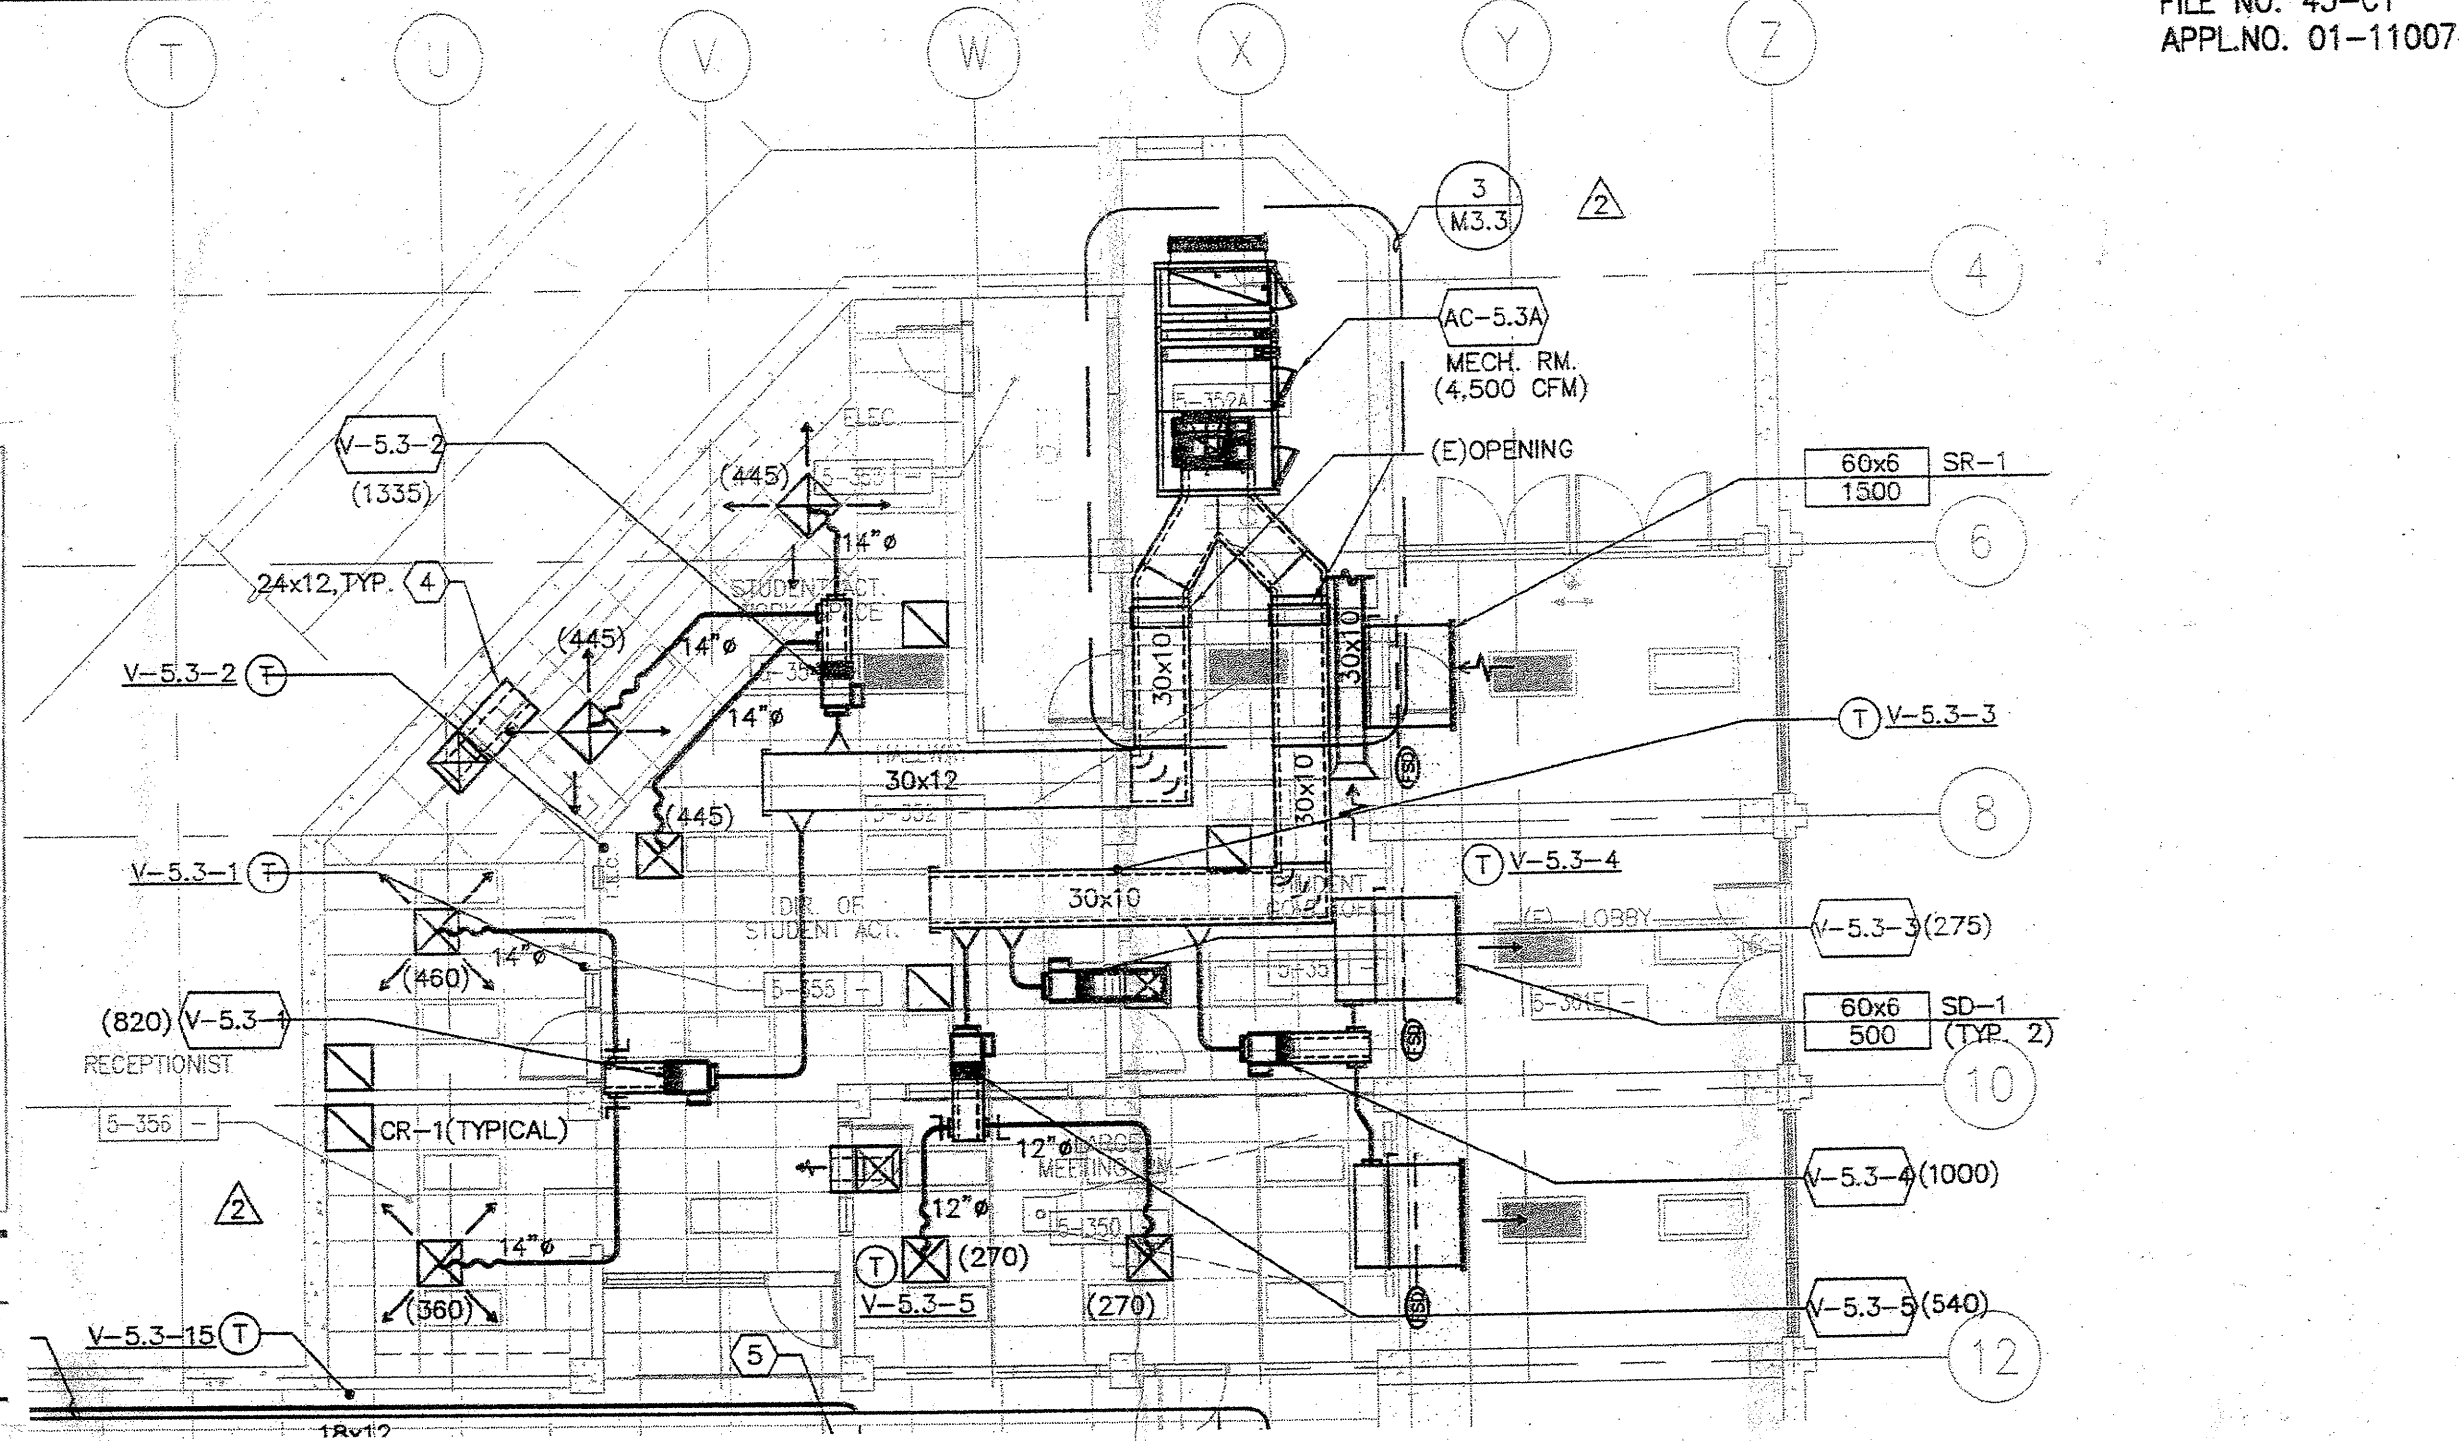

BCA PARTIAL MECHANICAL DUCTWORK PLAN - THIRD FLOOR
 CANADA COLLEGE - BUILDINGS 5 & 6 RENOVATIONS
 4200 FARM HILL BOULEVARD
 REDWOOD CITY, CA 94061
 FILE NO. 43-C1 APPL. 01-110074

INTERFACE ENGINEERING
 No. 030802
 No. 12-3-2010
 717 Market Street
 Suite 500
 San Francisco, CA 94103
 TEL: 415.469.7200
 FAX: 415.469.7269
 www.interfaceengineering.com

Revision: MSK-01
 Date: 05/11/10
 Scale: AS SHOWN
 Project Number: 07013

BCA PARTIAL MECHANICAL DUCTWORK PLAN - THIRD FLOOR
 CANADA COLLEGE - BUILDINGS 5 & 6 RENOVATIONS
 4200 FARM HILL BOULEVARD
 REDWOOD CITY, CA 94061
 FILE NO. 43-C1 APPL. 01-110074

INTERFACE ENGINEERING
 No. 030802
 No. 12-3-2010
 717 Market Street
 Suite 500
 San Francisco, CA 94103
 TEL: 415.469.7200
 FAX: 415.469.7269
 www.interfaceengineering.com

Revision: MSK-06
 Date: 05/11/10
 Scale: AS SHOWN
 Project Number: 07013

FILE: 0731M31.DWG - MSK06 | EDIT: 5/12/2010 4:23 PM BY BENC | PLOT: 5/12/2010 4:24 PM BY BEN CAO