


PROJECT 2007-0731  
CONTACT Omar Hawit  
**INTERFACE ENGINEERING**  
717 Market Street  
Suite 500  
San Francisco, CA 94103  
TEL 415.489.7240  
FAX 415.489.7289  
www.interfaceengineering.com

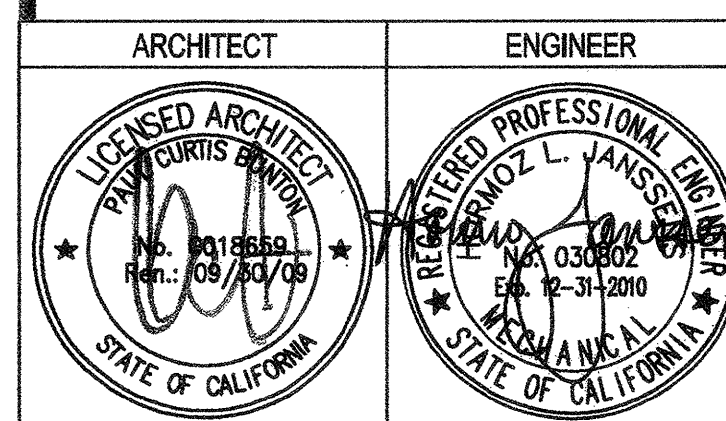

**GENERAL NOTES**

- This sheet is part of a set and is not to be used alone.
- This sheet is not to be used for construction unless the architect's stamp and signature appear on the drawings and the status box indicates drawings have been released for construction.
- These plans and prints thereof, as instruments of service, are owned by the architect and are for use on this project only. Reproduction and/or distribution without the prior written consent of the architect is forbidden.
- Copyright Bunton Clifford Associates, 2007

REMARKS	DATE
ADDENDUM NO. 1	08/18/08
ADDENDUM NO. 2	11/06/09

DRAWING STATUS	DATE
DSA PLAN CHECK	08/28/08
DSA BACK CHECK	01/22/09
BIDDING (BID #88820)	08/18/09
CONSTRUCTION	

FILE NO. 41-C1

CERTIFICATION STAMP  
DIV. OF THE STATE ARCHITECT  
01-110074  
AC\_FLS\_SS  
DATE

**BUILDINGS 5 & 6 RENOVATIONS**

San Mateo County Community College District

**BID ADDENDA**

APPROVED  
BY THE STATE ARCHITECT  
AC\_FLS\_FLS\_SS\_SSC  
APPL. NO. 110074 DATE 08/29/10

**CAÑADA COLLEGE**  
4200 Farm Hill Boulevard  
Redwood City, CA 94061

PLUMBING PLAN  
THIRD FLOOR


Date  
08/29/08  
Scale  
AS NOTED  
Project Number  
07013

Drawing Number

**P2.3**

**SHEET KEYNOTES**

- FOR CONTINUATION, SEE DRAWING PDI.3.
- 1-1/2" CW & 3/4" HW DN.
- REFER TO PDI.1 FOR CONTINUATION.
- W DN TO BELOW FLOOR.
- 3" V UP.
- SD STACK DN W/ WCO.
- POINT OF CONNECTION, (N) WORK TO (E) WORK. FIELD VERIFY EXACT SIZE AND LOCATION OF (E) WORK PRIOR TO INSTALLING (N) WORK.
- PIPE(S) ABOVE FINISHED FLOOR, INSIDE THE PLUMBING CHASE OR WALL.
- PIPING BELOW FLOOR.
- INSTALL PIPE WITH A MINIMUM SLOPE OF 1%.
- PIPING @ CEILING SPACE INSTALL AS HIGH AS POSSIBLE.
- (E) 4" V STACK.
- PROVIDE WHA (SIZES/PDI STANDARD) W/ AP.
- PROVIDE (N) WH-2.
- 1/2" HW DN & 2" V UP FROM BELOW.
- FIRE WATER RISER SIZE SHALL BE DETERMINED BY CONTRACTOR CALCULATIONS BASED ON RECENT FIRE FLOW DATA.
- PROVIDE 1/2" CW SOV TO TPV-1 W/AP @ +16" AFF FOR FD/FS.

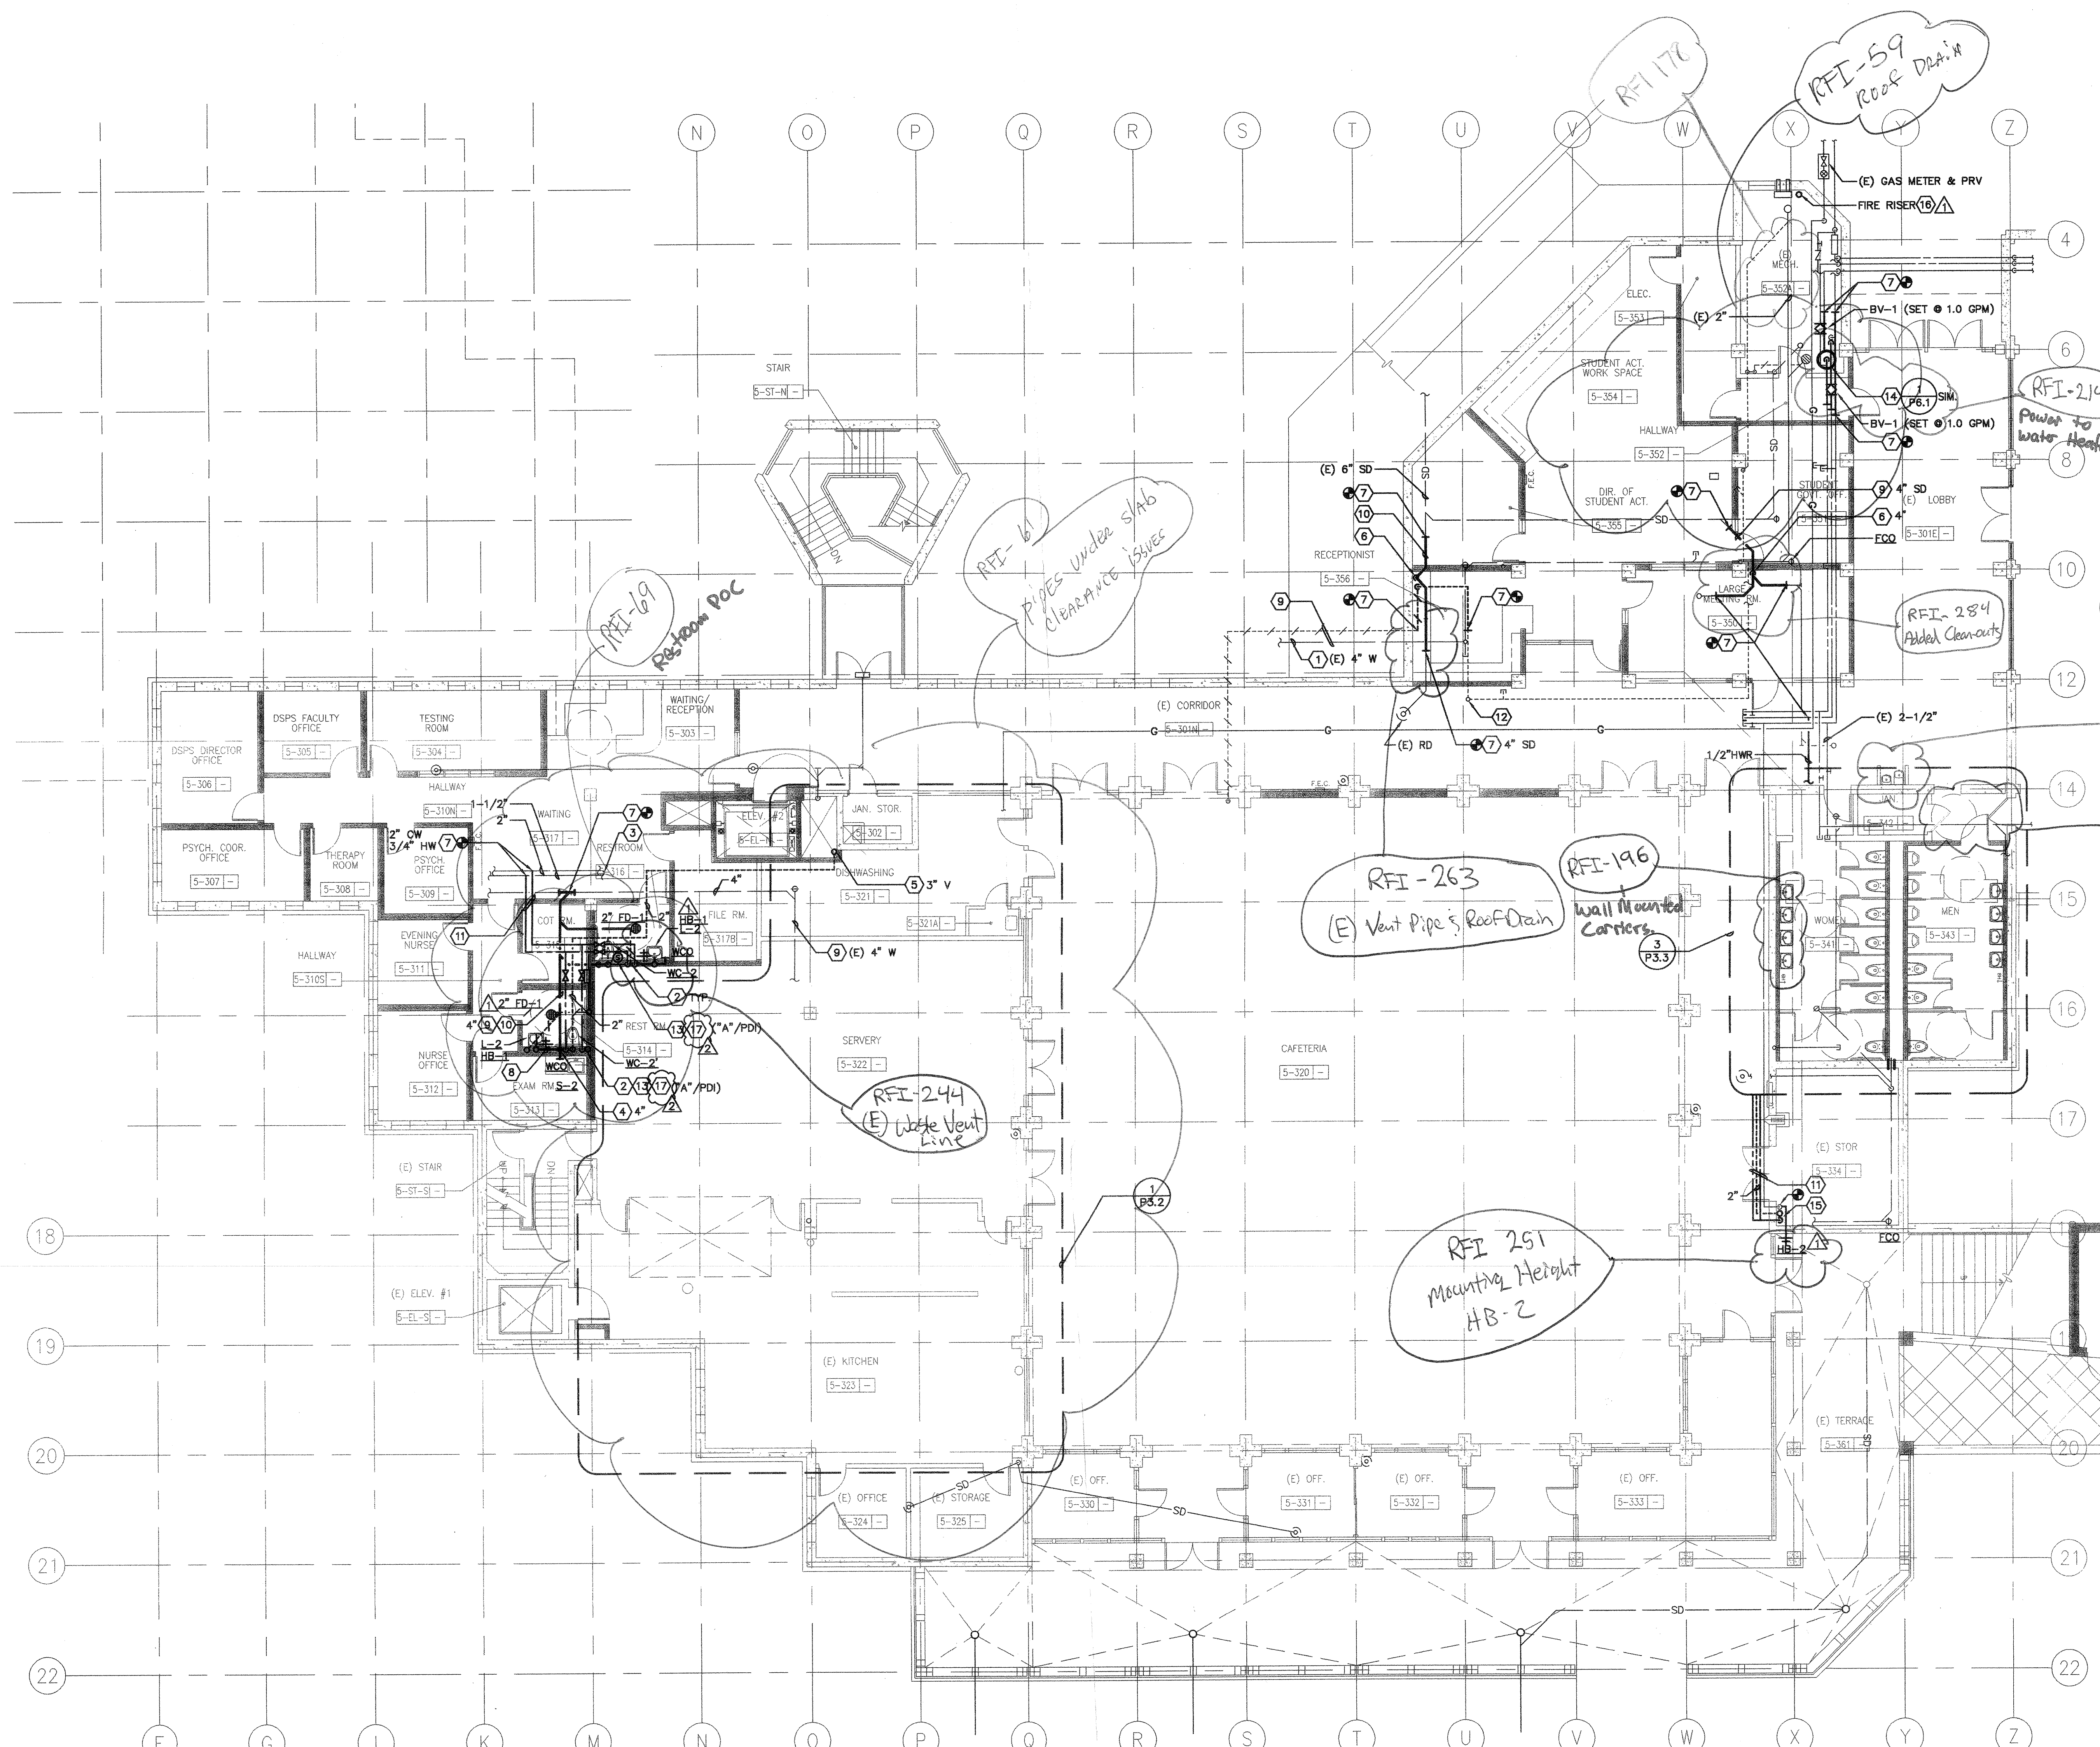

**1 PLUMBING PLAN - THIRD FLOOR**  
SCALE: 1/8"=1'-0"