




**SHEET KEYNOTES:**

- ① PROVIDE NEW RACK MOUNTED MODULAR PATCH PANELS IN SPACES WHERE OLD PANELS WERE REMOVED. COORDINATE EXACT LOCATION WITH OWNER.
- ② ROUTE ALL DATA, INTRUSION, ACCESS CONTROL, AND CCTV CABLE IN J-HOOK SYSTEM. ROUTE CABLES TO APPROPRIATE HEAD END EQUIPMENT DEVICES IN MDF.
- ③ PROVIDE (N) SECONDARY CLOCKS AND ROUTE CABLE TO (E) HEAD END EQUIPMENT IN MDF.
- ④ ROUTE ALL CABLES ASSOCIATED WITH CAMERAS, GLASS BREAK, CARD READERS, DOOR CONTACTS, ELECTRONIC DOOR LATCHES, AND REX DEVICES TO ACAMS PANELS IN MDF.

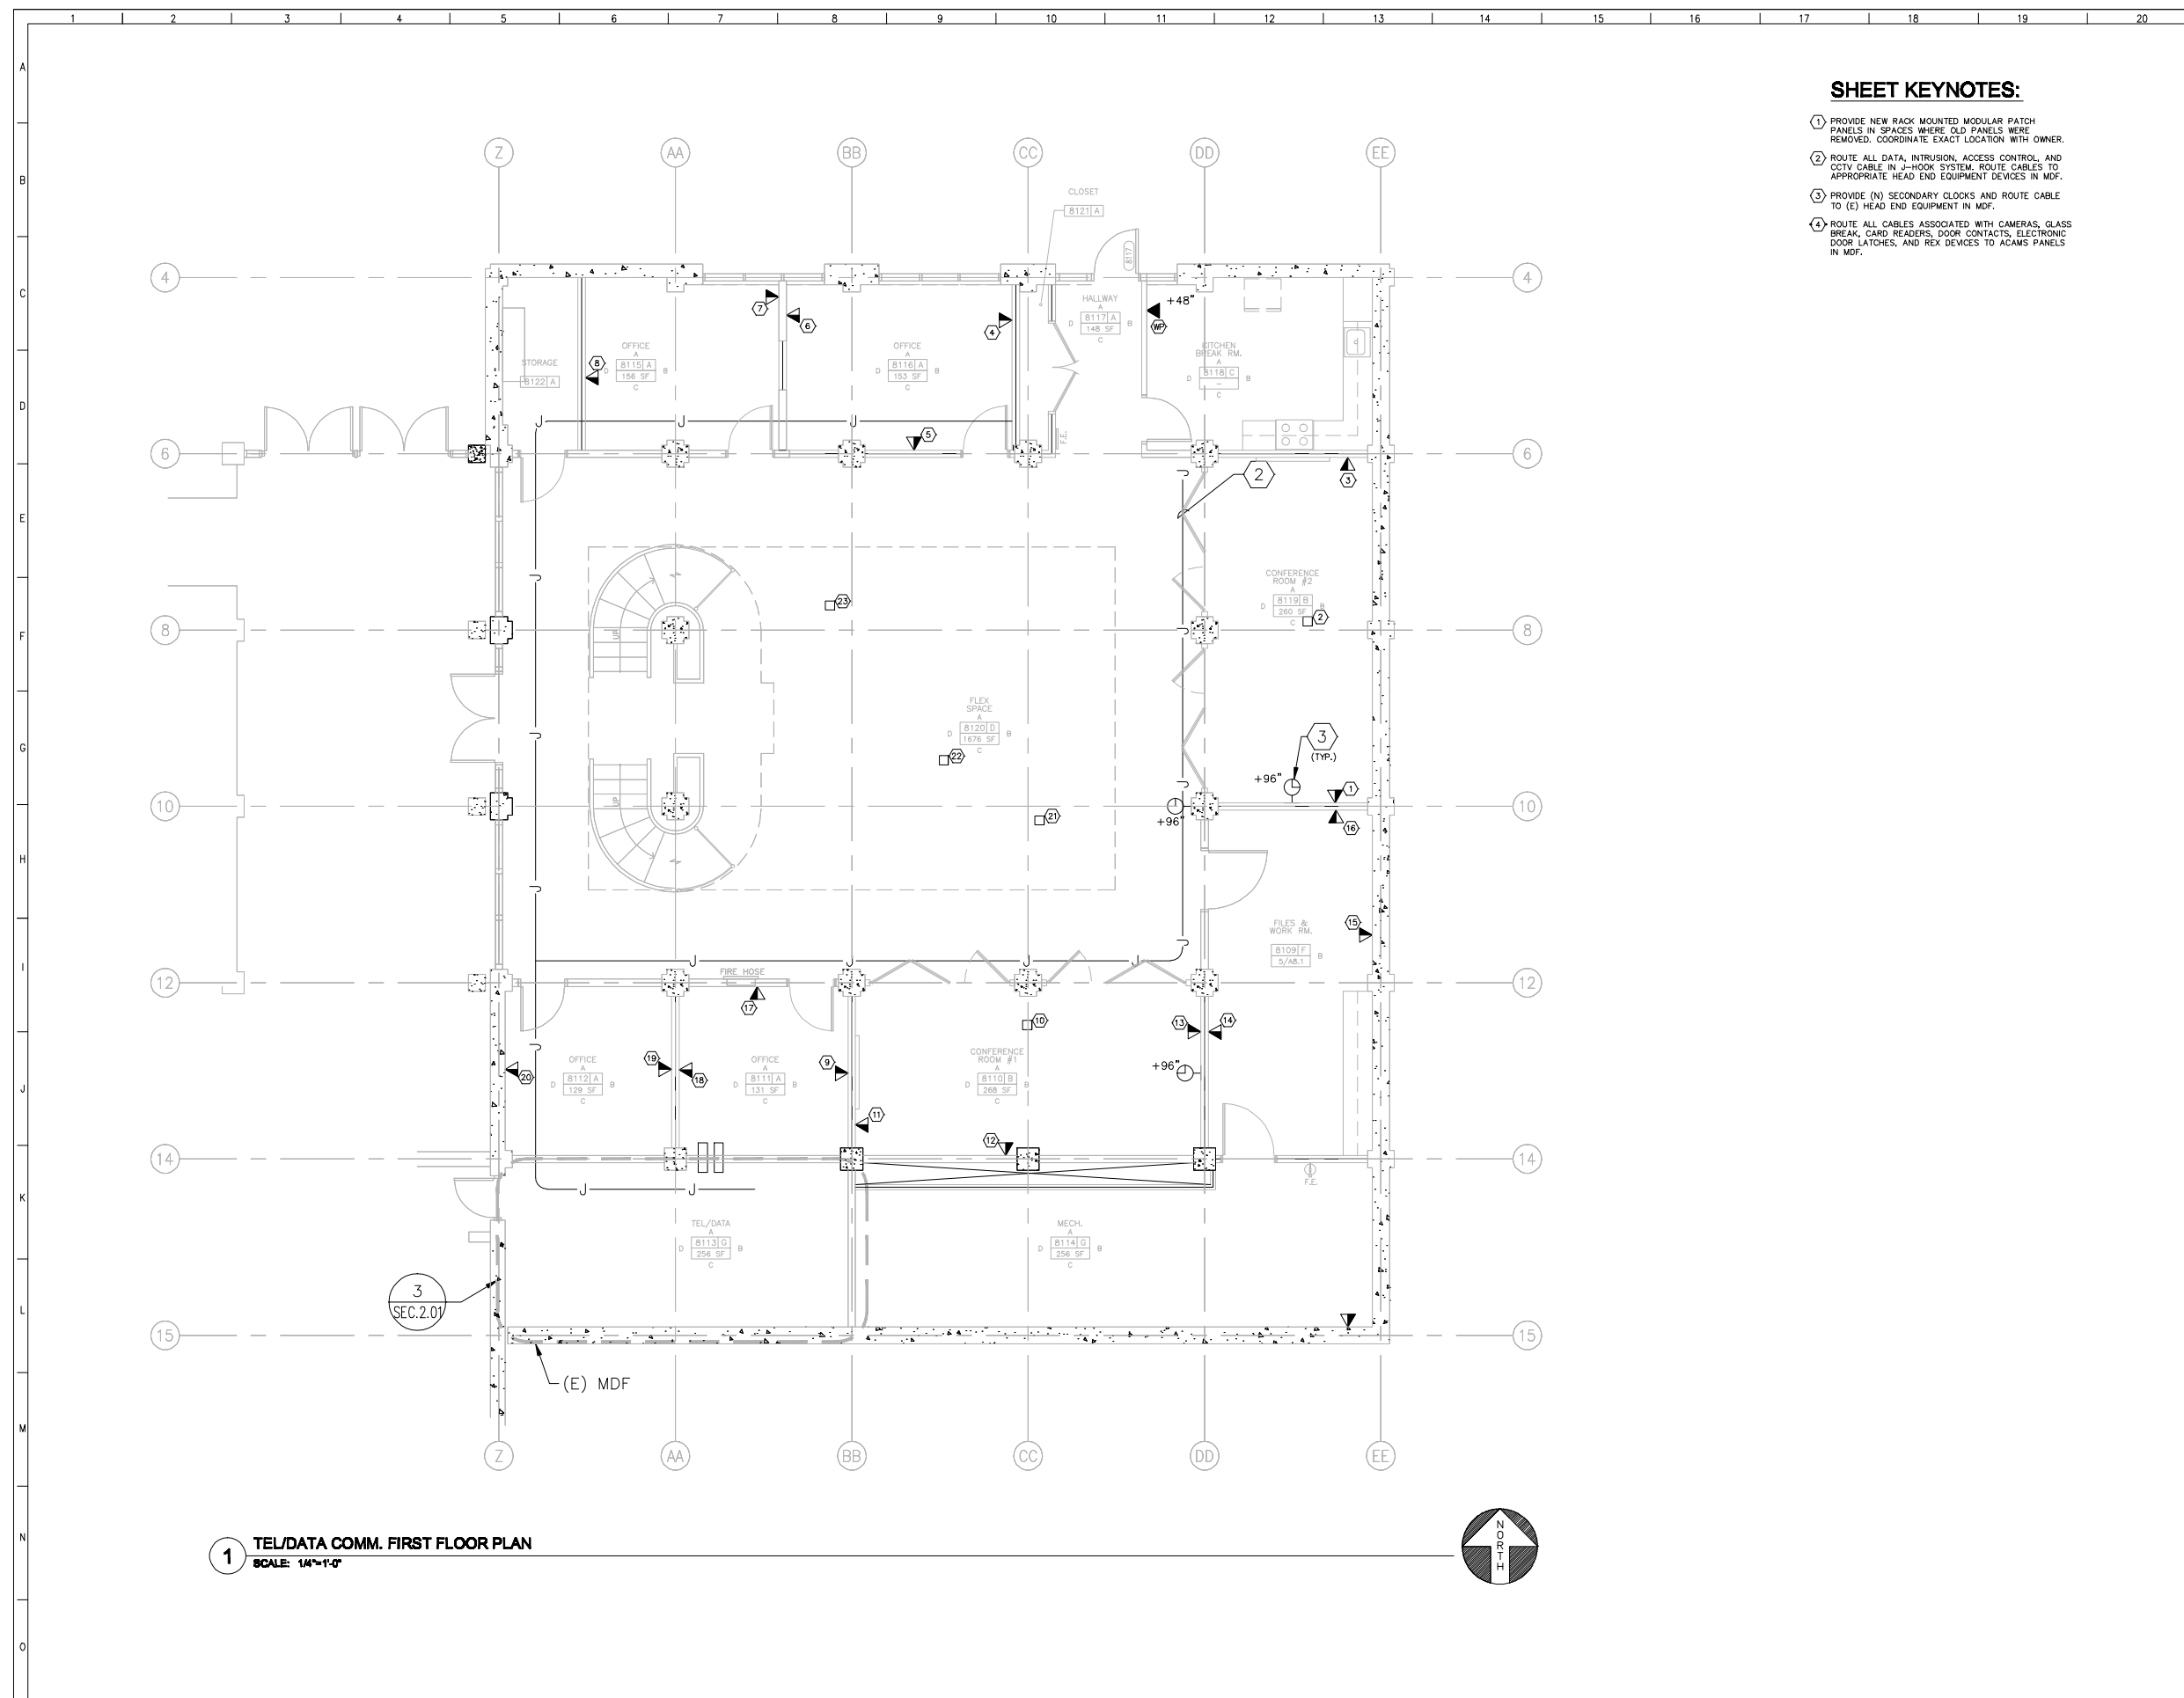

**1 TEL/DATA COMM. FIRST FLOOR PLAN**  
 SCALE: 1/4"=1'-0"

ISSUANCE:  
**AS-BUILT DRAWINGS**

PROPRIETARY INFORMATION  
 NO PART OF THIS DOCUMENT MAY BE COPIED, REPRODUCED  
 OR TRANSMITTED IN ANY FORM OR BY ANY MEANS WITHOUT  
 PRIOR WRITTEN CONSENT OF NETVERSANT.

REVISIONS		
NO.	DATE	DESCRIPTION
1	3/19/09	REVISE FOR AS-BUILTS-ML

PROJECT:  
 CANADA COLLEGE  
 BUILDING # 8 PHASE 2  
 REVOLUTION PROJECT  
 4200 FARM HILL BLVD.  
 REDWOOD CITY, CA 94061

SHEET TITLE:  
 TEL/DATA COMM.  
 1ST FLOOR PLAN

DATE:	8/25/08
DRAWN BY:	BCHUA
CHECKED BY:	JLAMANTIA
SCALE:	AS NOTED
JOB NO.:	109802306F25
SHEET NUMBER	<b>SCS.2.01</b>