


SITE IMPROVEMENT PLAN FOR CAÑADA COLLEGE REDWOOD CITY DECEMBER 2000

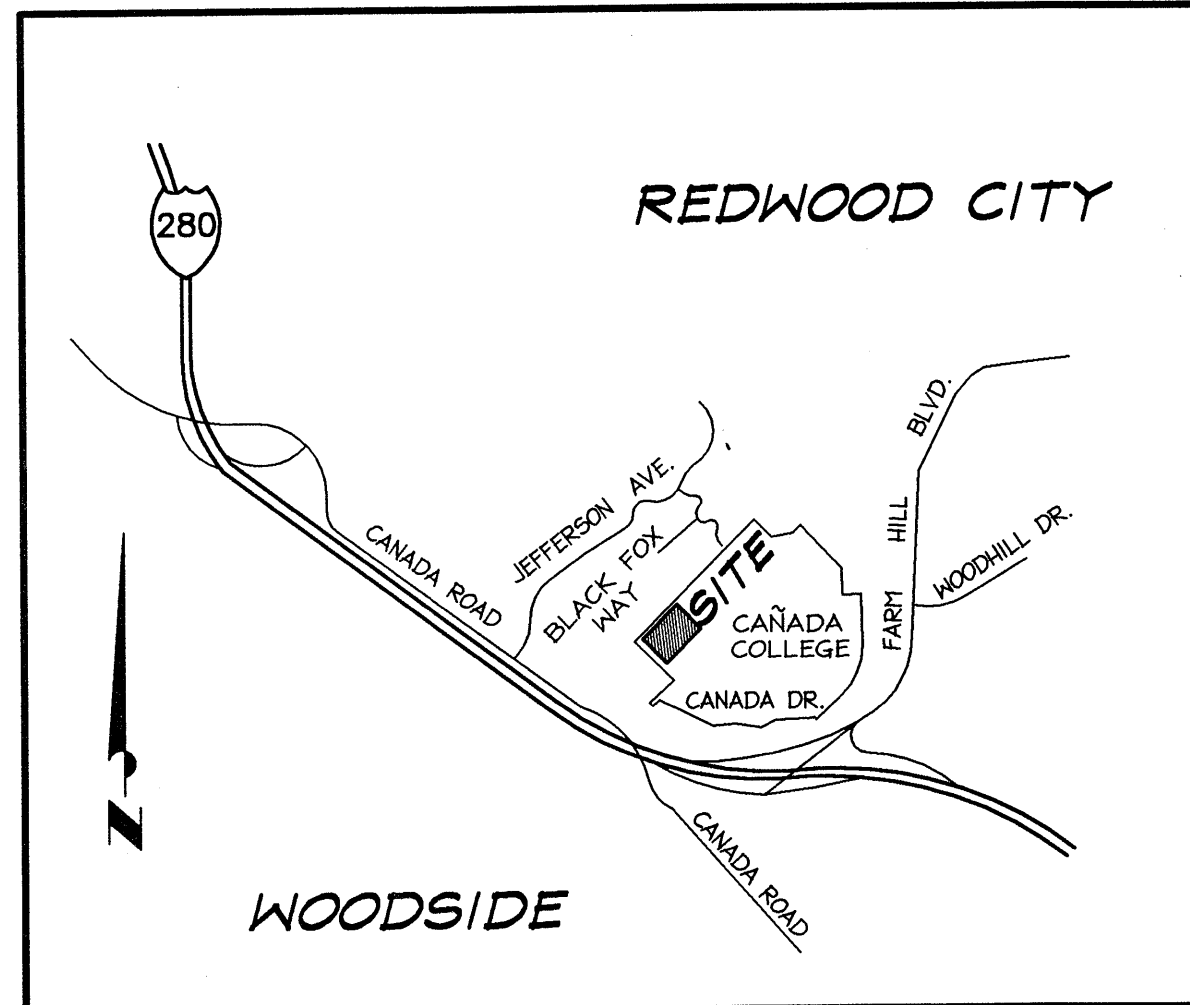

VICINITY MAP
NOT TO SCALE

OWNER:
SAN MATEO COUNTY COMMUNITY COLLEGE DISTRICT
3401 CSM DRIVE
SAN MATEO, CA 94402
(650) 574-6550

CIVIL ENGINEER:
DAVID EVANS & ASSOCIATES, INC.
5000 EXECUTIVE PKWY, STE. 125
SAN RAMON, CA. 94583
(925) 867-3380

SHEET INDEX

1. TITLE SHEET
2. NOTES & DETAILS
3. GRADING & DIMENSIONAL PLAN
4. UTILITY PLAN
5. EROSION CONTROL PLAN
- P-1 PLUMBING PLAN & DETAILS
- E-1 ELECTRICAL PLAN
- E-2 ELECTRICAL DETAILS


LEGEND:

- STORM DRAIN, MANHOLE
- DIRECTION OF DRAINAGE FLOW
- EXISTING TREE DRIPLINE
- EASEMENT LINE
- PROPOSED PROPERTY LINE
- SUBDIVISION BOUNDARY
- SS SANITARY SEWER & MANHOLE
- PROPOSED GRADING CONTOUR
- EXISTING CONTOUR
- WATER (DAM, ETC.)
- STREET SIGN
- TRAFFIC SIGN
- AREA DRAIN - NDS #11 GRATE (TYPICAL)



3-31-01

U.P. Ferguson

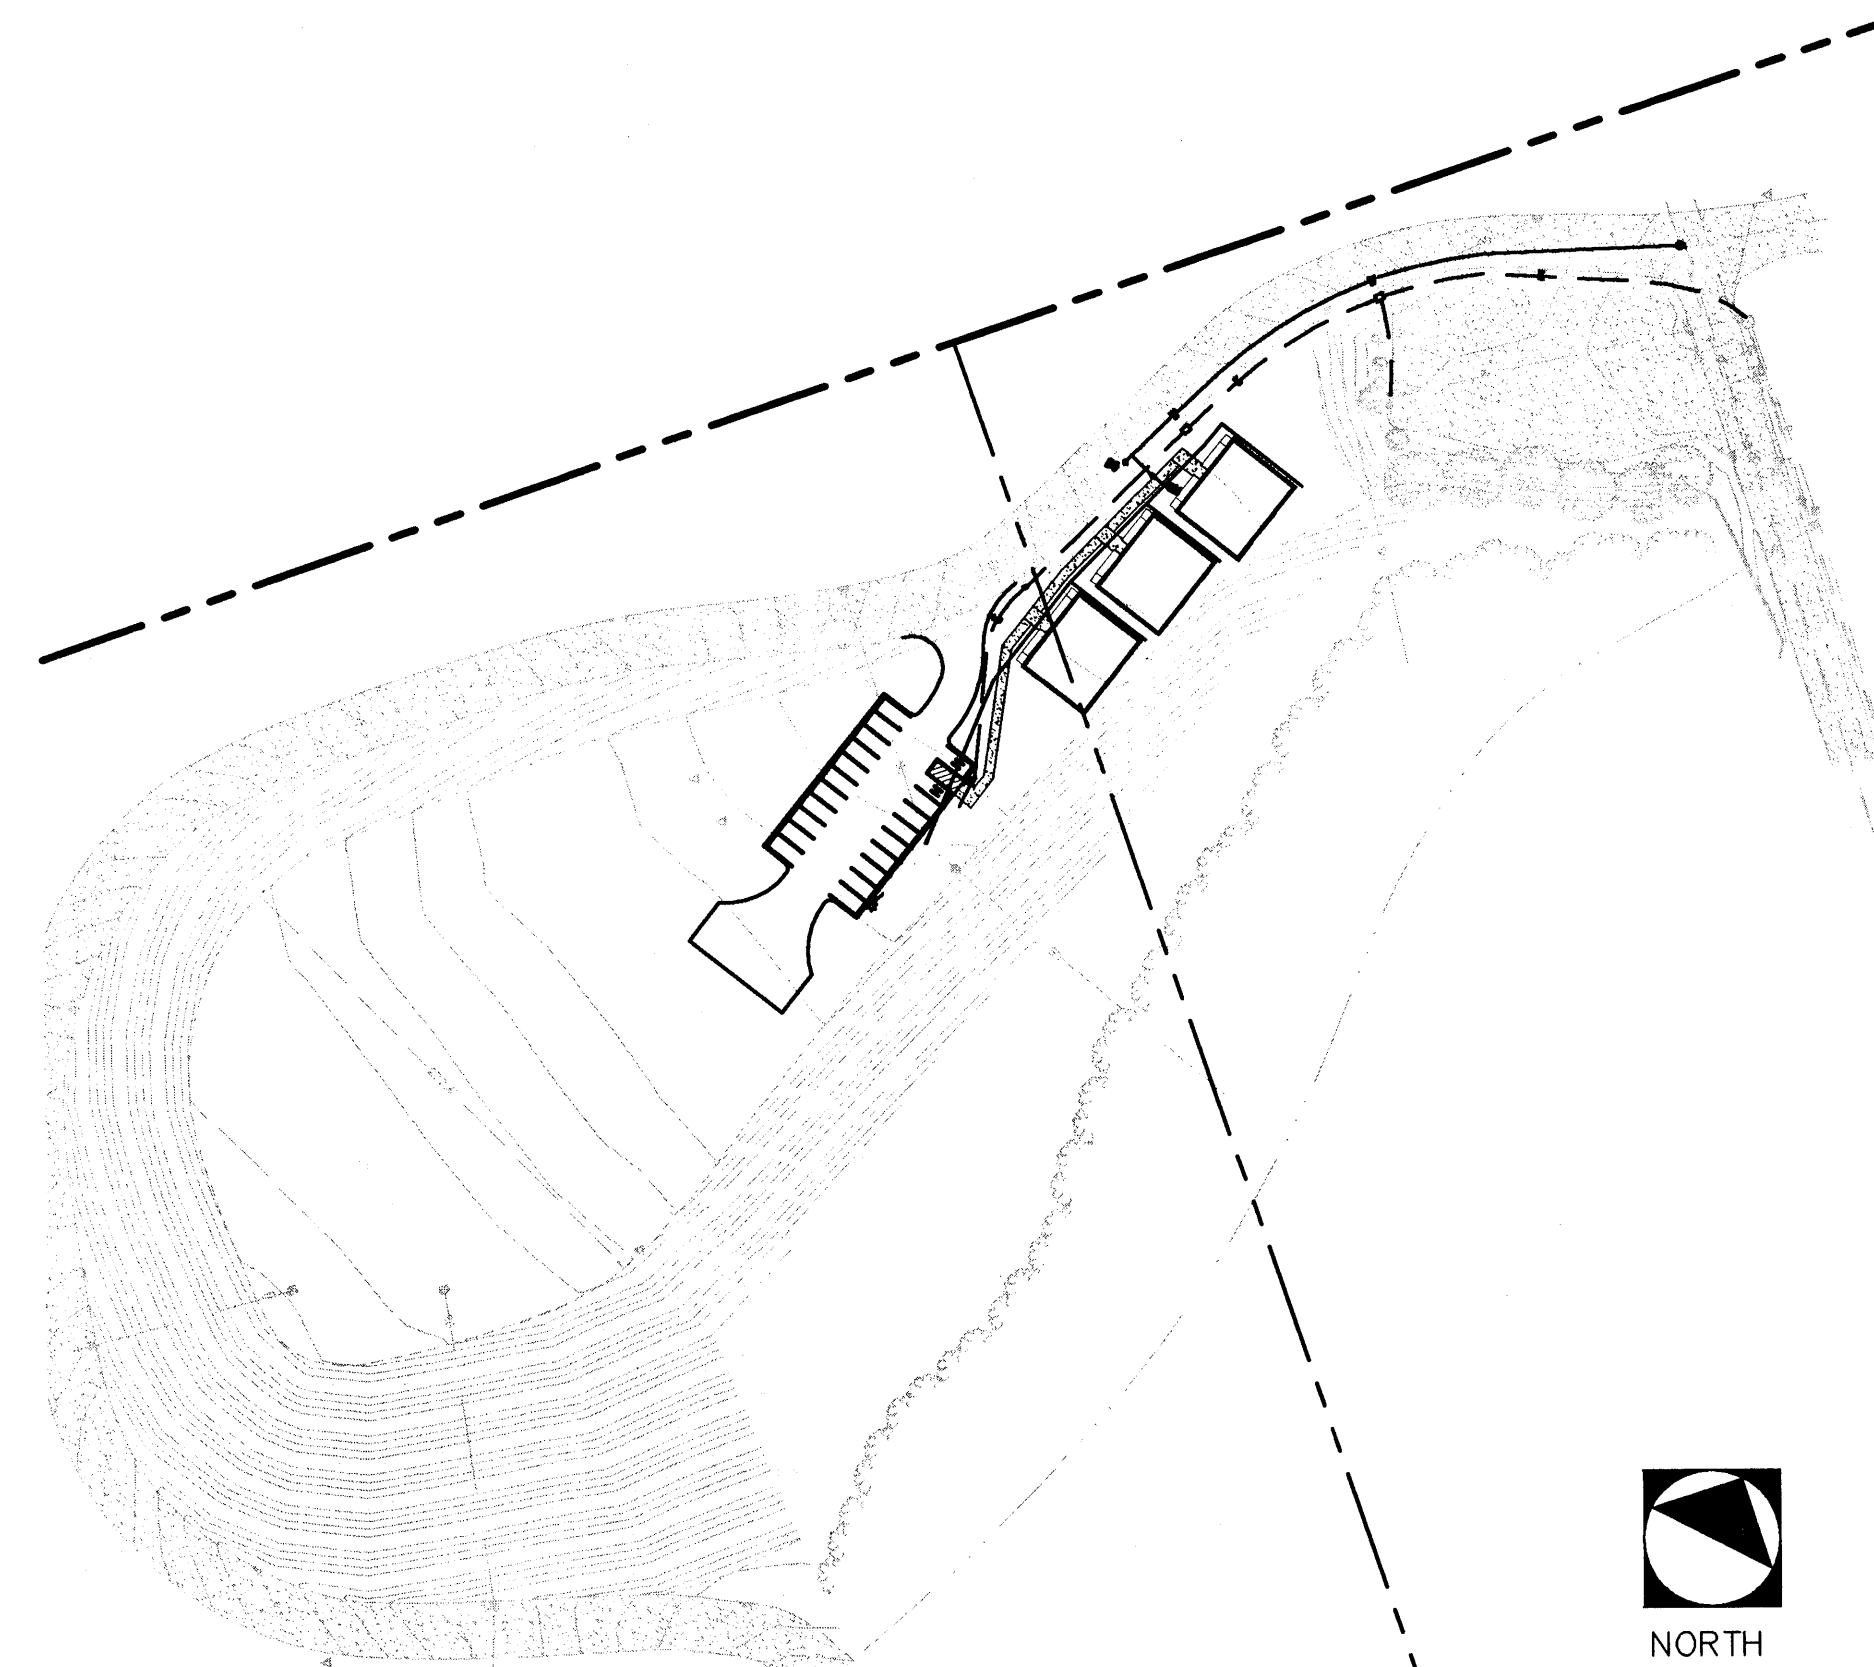

INDEX MAP

SCALE: 1"=100'

ABBREVIATIONS

AC	ASPHALT CONCRETE	INV	INVERT
ARV	AIR RELIEF VALVE	JB	JUNCTION BOX
BC	BEGIN CURVE	JP	JOINT POLE
BO	BLOW OFF	LT	LEFT
BVC	BEGINNING OF VERTICAL CURVE	LP	LOW POINT
B/W	BACK OF WALK	MH	MANHOLE
BH	BOTTOM OF WALL	P	PAD
CB	CATCH BASIN	PVI	POINT OF VERTICAL INTERSECTION OF TANGENTS
CI	CAST IRON	PMT	PAVEMENT
CIPP	CAST IN PLACE PIPE	PP	POWER POLE
CL	CENTERLINE	PRC	POINT OF REVERSE CURVE
CONC	CONCRETE	PSDE	PRIVATE STORM DRAIN EASEMENT
CO	CLEAN OUT	PUE	PUBLIC UTILITY EASEMENT
CR	CURB RETURN	PVC	POLYVINYL CHLORIDE PIPE
DIP	DUCTILE IRON PIPE	PWE	PRIVATE WATER LINE EASEMENT
DSA	DEPARTMENT OF STATE ARCHITECTURE	R	RIGHT
DWY	DRIVEWAY	RT	RADIAL
E	ELECTRICAL	(R)	(R)
EC	END CURVE	RCP	REINFORCED CONCRETE PIPE
EL	ELEVATION	RI	RODDING INLET
EP	EDGE OF PAVEMENT	R/W	RIGHT OF WAY
ER	END OF RETURN	SD	STORM DRAIN
ESMT	EASEMENT	SDE	STORM DRAIN EASEMENT
EVC	END OF VERTICAL CURVE	SNS	STREET NAME SIGN
EX	EXISTING	SS	SANITARY SEWER
FC	FACE OF CURB	SSE	SANITARY SEWER EASEMENT
FF	FINISHED FLOOR	SO	SIDE OPENING
FG	FINISH GRADE	TC	TOP OF CURB
FI	FIELD INLET	TF	TOP OF PAVEMENT
F	FLOW LINE	TN	TOP OF WALL
FH	FIRE HYDRANT	TYP	TYPICAL
FM	FORCE MAIN	VC	VERTICAL CURVE
FUT	FUTURE	VCP	VITRIFIED CLAY PIPE
GB	GRADE BREAK	W	WATER
GV	GATE VALVE		
HC	HANDICAP		
HP	HIGH POINT		

CITY APPROVAL									
PREPARED UNDER THE SUPERVISION OF	SCALE: AS SHOWN	DATE: 12/15/00	DRAWN BY: LTM	ENGINEER: MEW	CHECKED BY:	PG.	NO. BY DATE		
DAVID EVANS AND ASSOCIATES, INC. 5000 EXECUTIVE PARKWAY, SUITE 125 SAN RAMON, CALIFORNIA 94583		MARK EDWARD WOODS No. C 29851 EXPIRES 03-31-03 CIVIL STATE OF CALIFORNIA		3-31-01 <i>U.P. Ferguson</i>		TEL: (925) 867-3380 FAX: (925) 867-3388	INC.		
SAN MATEO COUNTY COMMUNITY COLLEGE DISTRICT		TITLE SHEET		CALIFORNIA		REDWOOD CITY			
SHEET NO.		1		OF 8 SHEETS		JOB No.			
SMCC0000-0003		P:\SDSK\PROJ\SMCC0003\GRAD_TITLE.DWG							