


GROUND FLOOR PLAN

SCALE: 1/8"=1'-0"


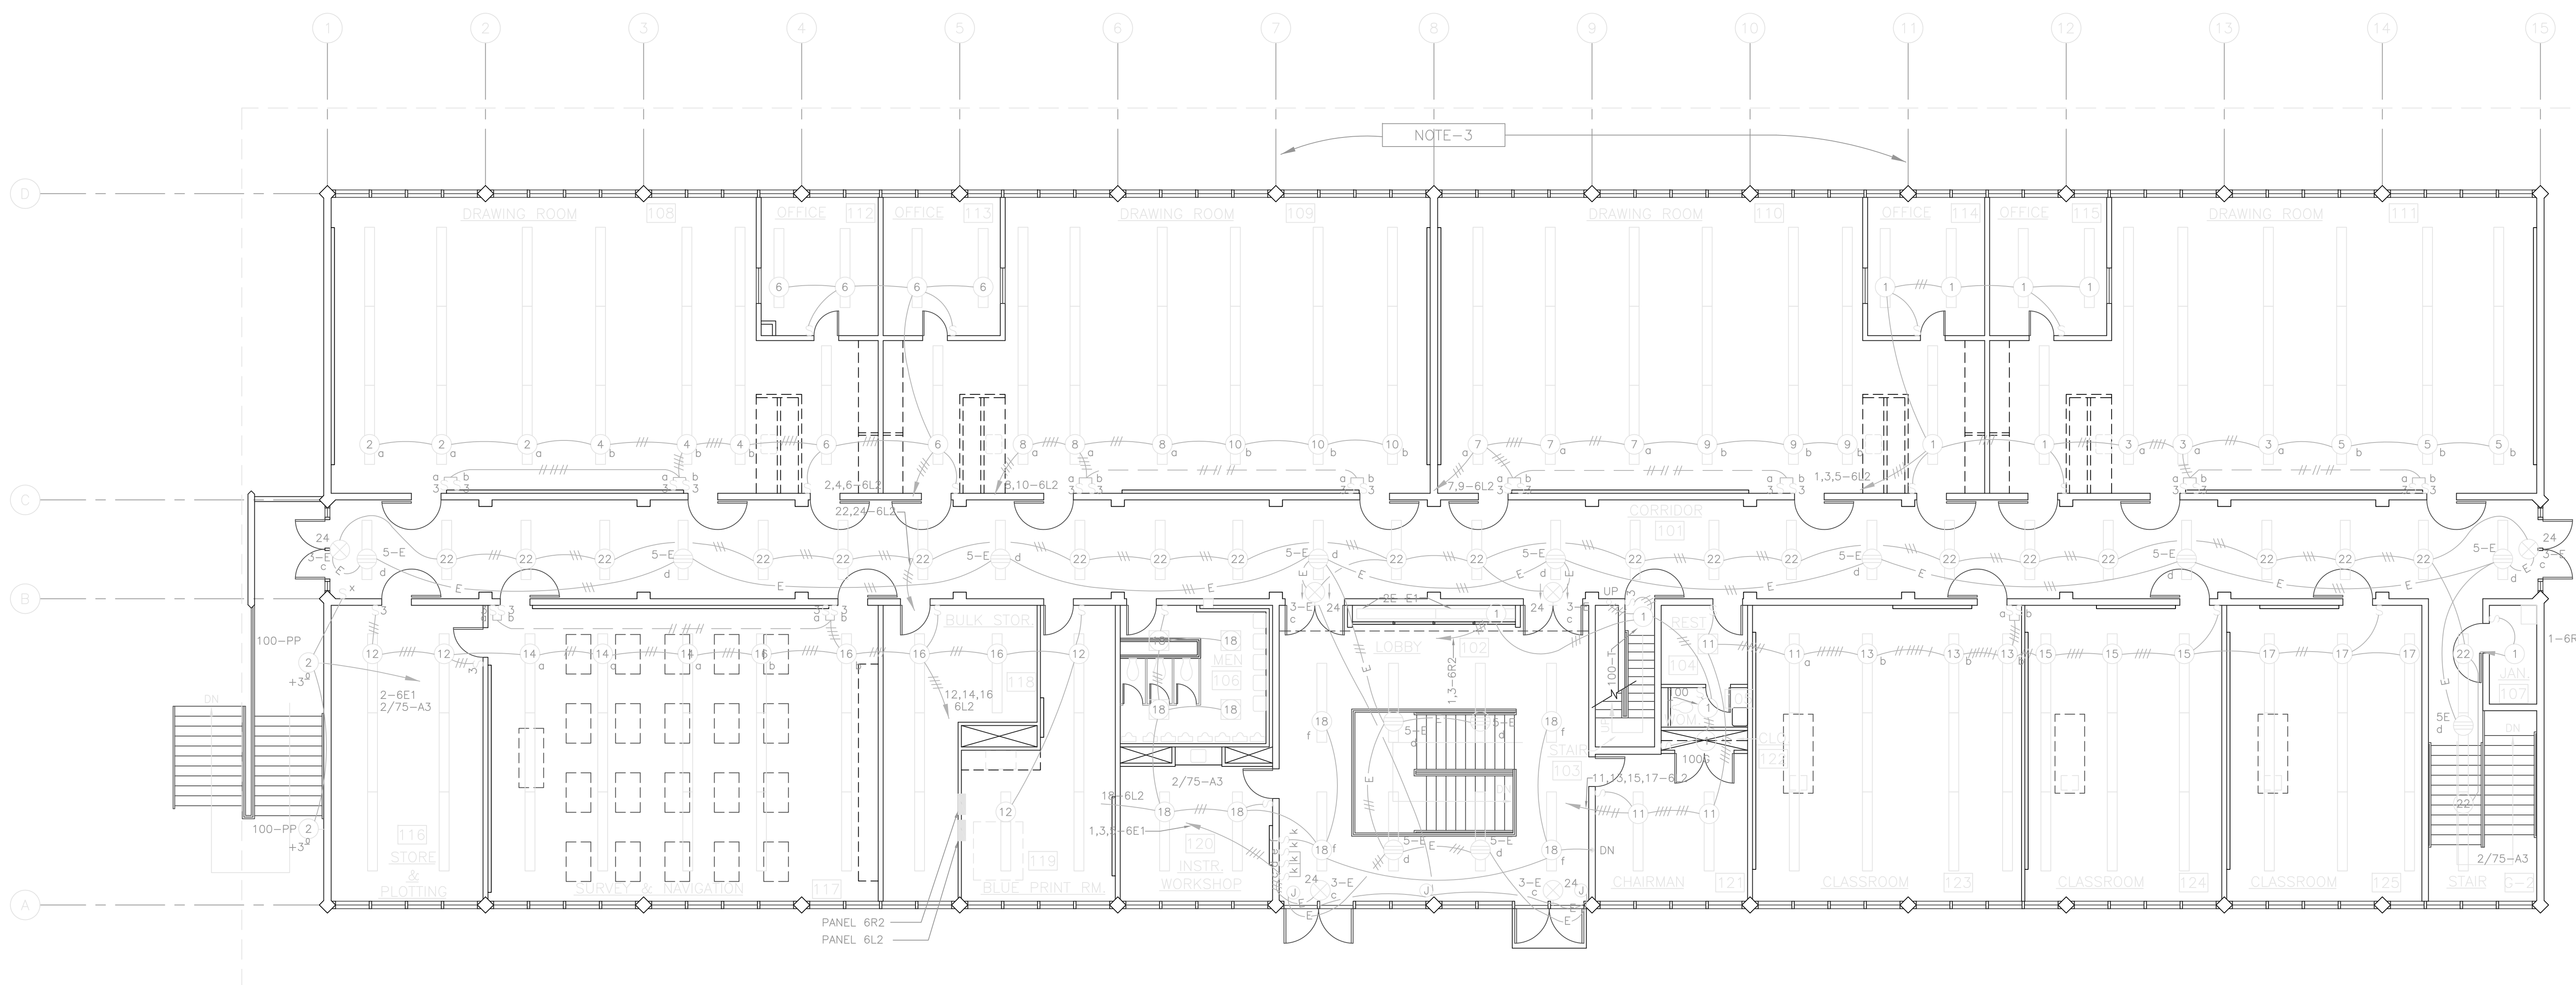


FIRST FLOOR PLAN

SCALE: 1/8"=1'-0"

LIGHTING FIXTURE SCHEDULE	
LOCATION	TYPE
CLASSROOMS, LABORATORIES, LOBBY, OFFICES	2/75-A3
DRAWING ROOMS-SURVEY & NAVIGATION	4/75-A4
ROOMS A.B.C., BATTERY, BLUE PRINT, BULK STORES	2/75-A3
TOILETS	4/20-B1
STOREROOMS, CLOSETS, JANITOR ETC.	100-G
CORRIDORS	1/58-N
EXITS	002
OTHER AREAS	AS NOTED

- NOTES:
- FOR SYMBOLS, FIXTURE SCHEDULE, & GENERAL NOTE SEE SHEET E.3.
 - ALL GROUND-FLOOR FIXTURES TYPE "A"- SURFACE MOUNT & PROVIDE TOP REFLECTOR PLATES
 - ALL FIRST FLOOR FIXTURES TYPE "A"- PENDANT MOUNT, UP 11"

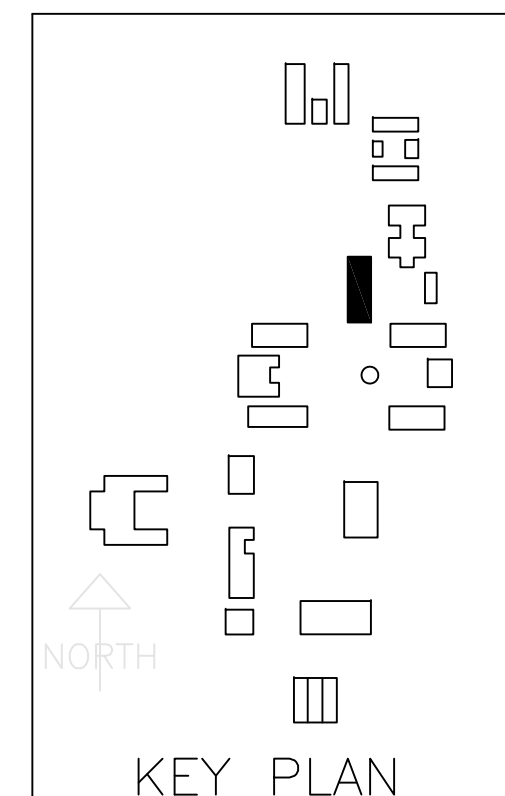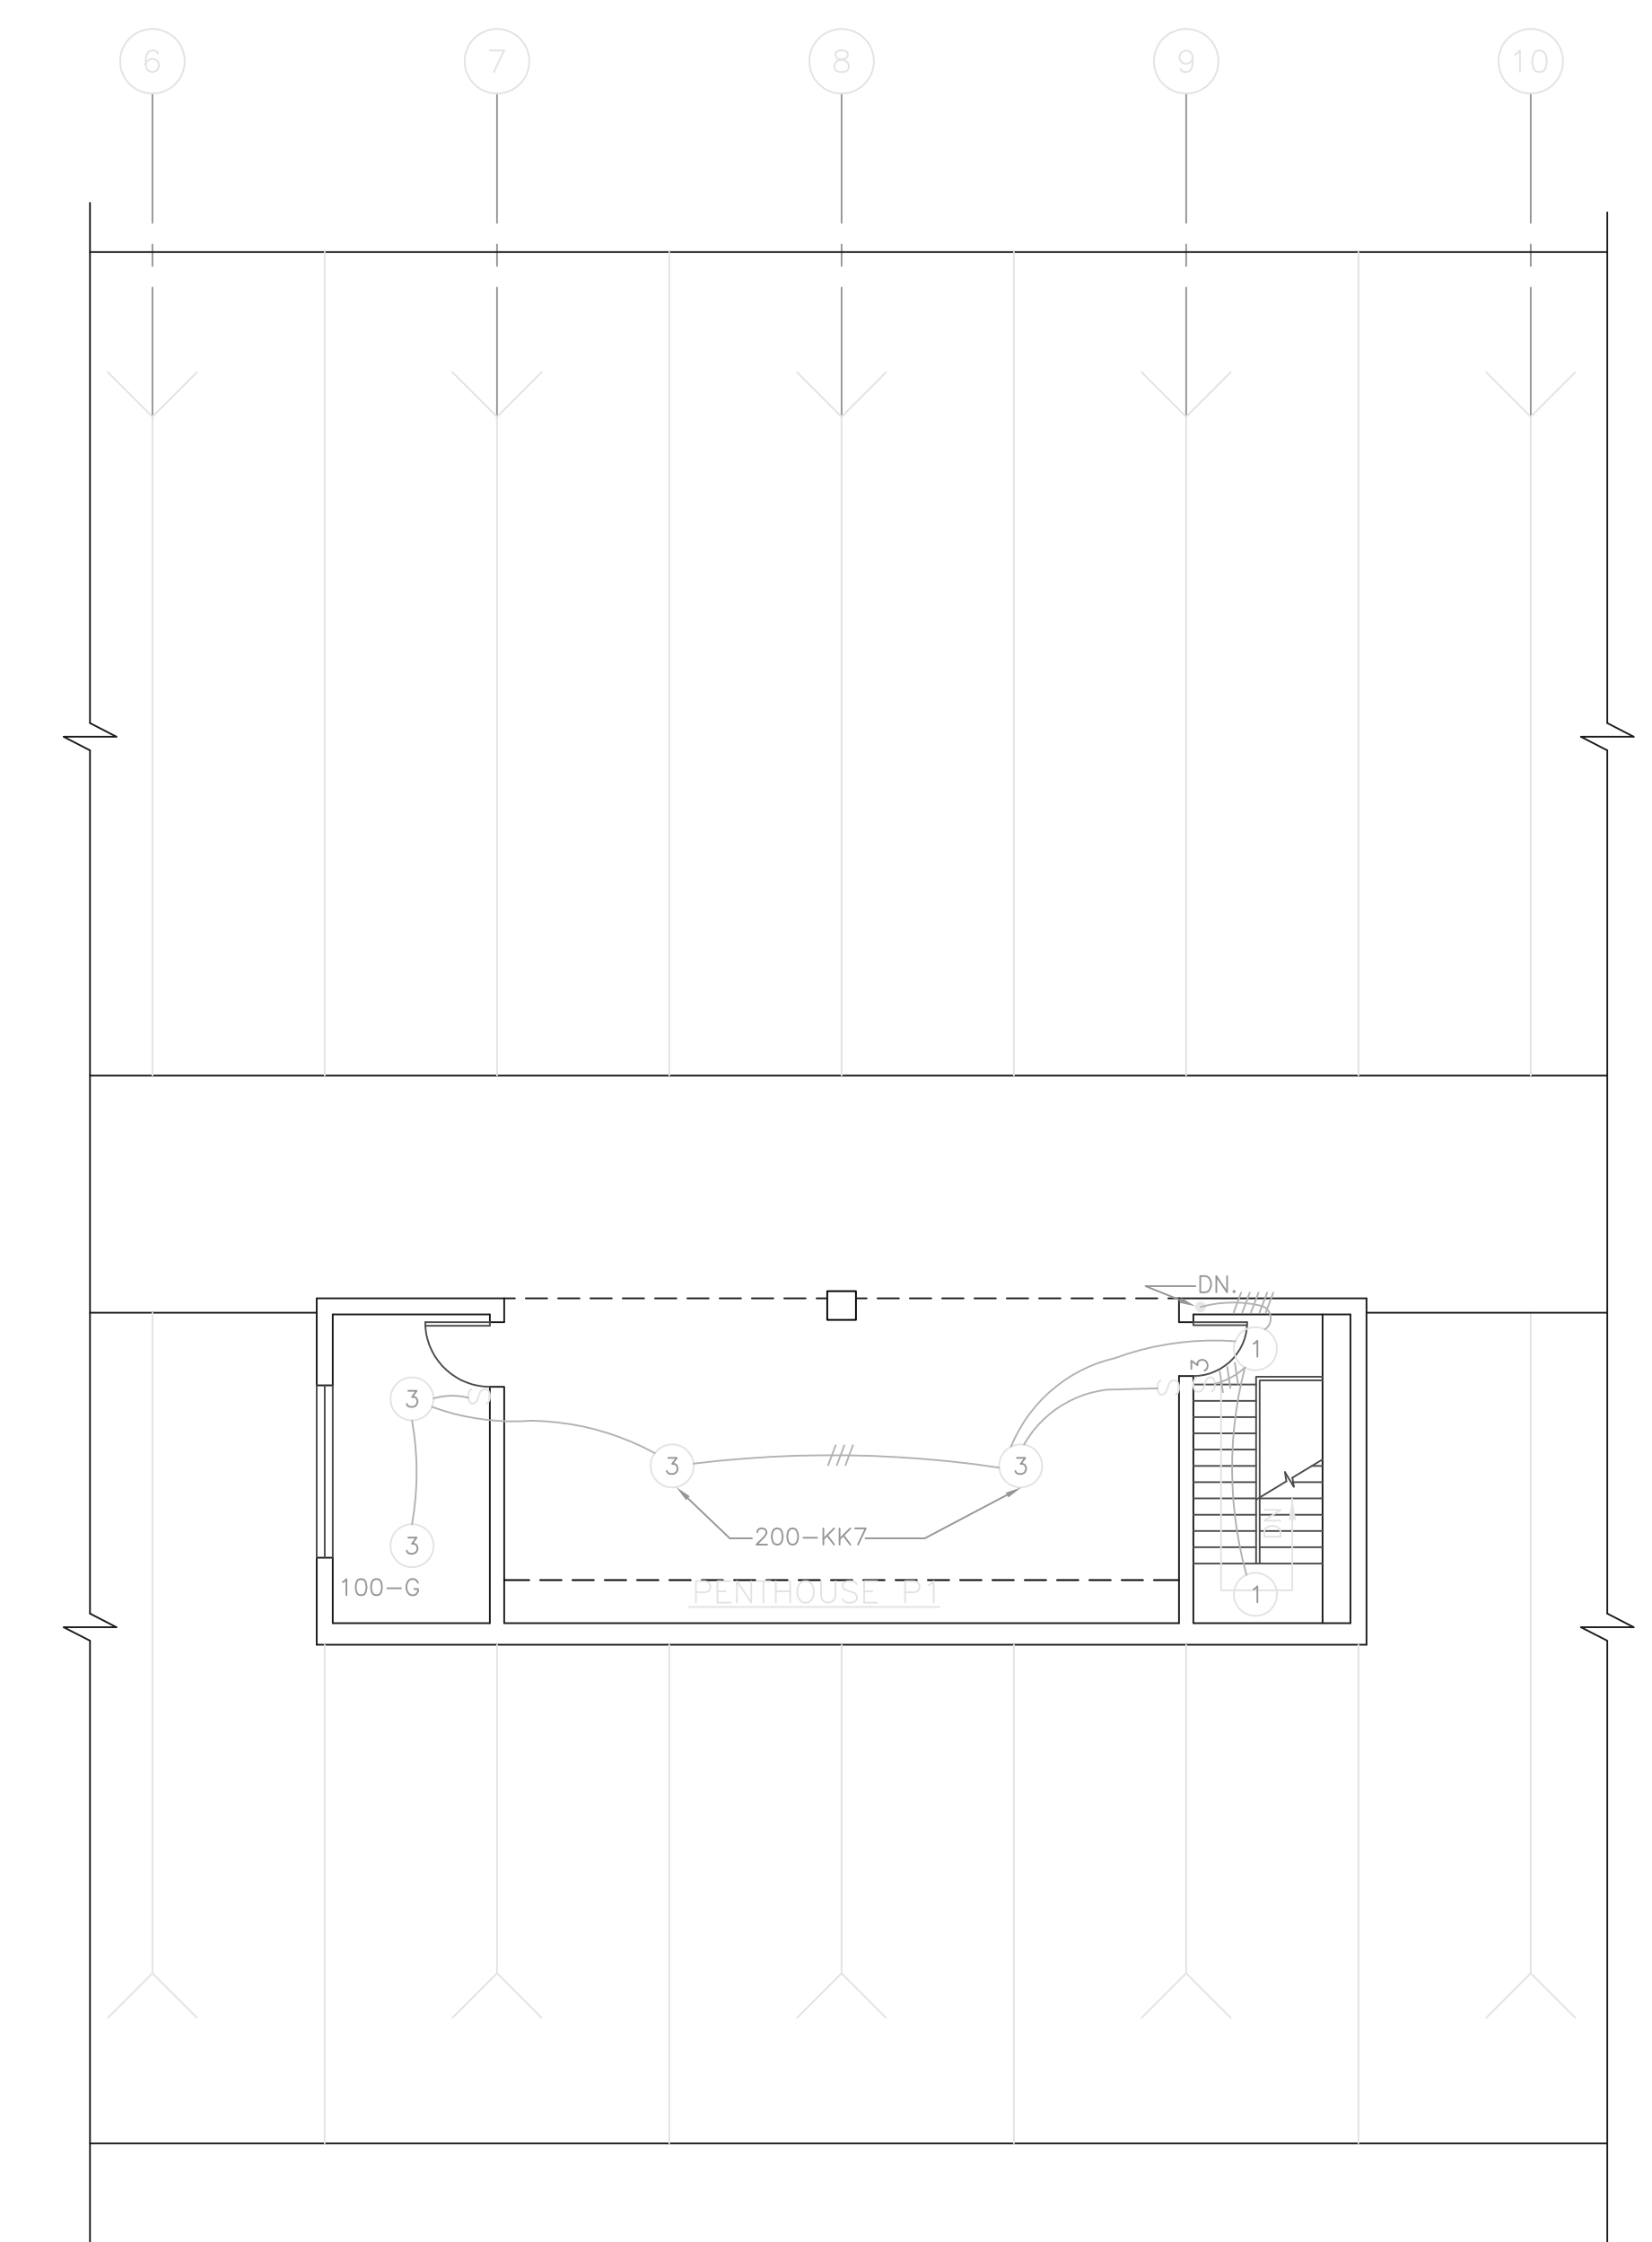

GEORGE W. HUTCHINSON
DIRECTOR OF BUILDING CONSTRUCTION
SAN MATEO JUNIOR COLLEGE DISTRICT

JULIO L. BORTOLAZZO
SUPERINTENDENT

JOHN CARL WARNECKE, ARCHITECT

JOHN A. BLUME & ASSOC. ENGINEERS
STRUCTURAL ENGINEERS

KELLER & GANNON
MECHANICAL & ELECTRICAL ENGINEERS

ROYSTON HANAMOTO AND MAYES
LANDSCAPE ARCHITECTS

JOHN CARL WARNECKE
A.I.A. ARCHITECT

111 NEW MONTGOMERY ST. • SAN FRANCISCO

COLLEGE OF SAN MATEO
COLLEGE HEIGHTS CAMPUS
SAN MATEO, CALIF.

JOB NO. DATE
DRAWN BY MFL-RL 1 DEC, 1960
CHECKED BY R.G.B.

ENGINEERING
GROUND & FIRST FLOOR LIGHTING

BLDG. NO. SHEET NO.
6 **E1**
OF 3