



ADD-ALTERNATE HVAC VERTICAL MOUNTING
SCALE: 1/2" = 1'-0"

1
S-12

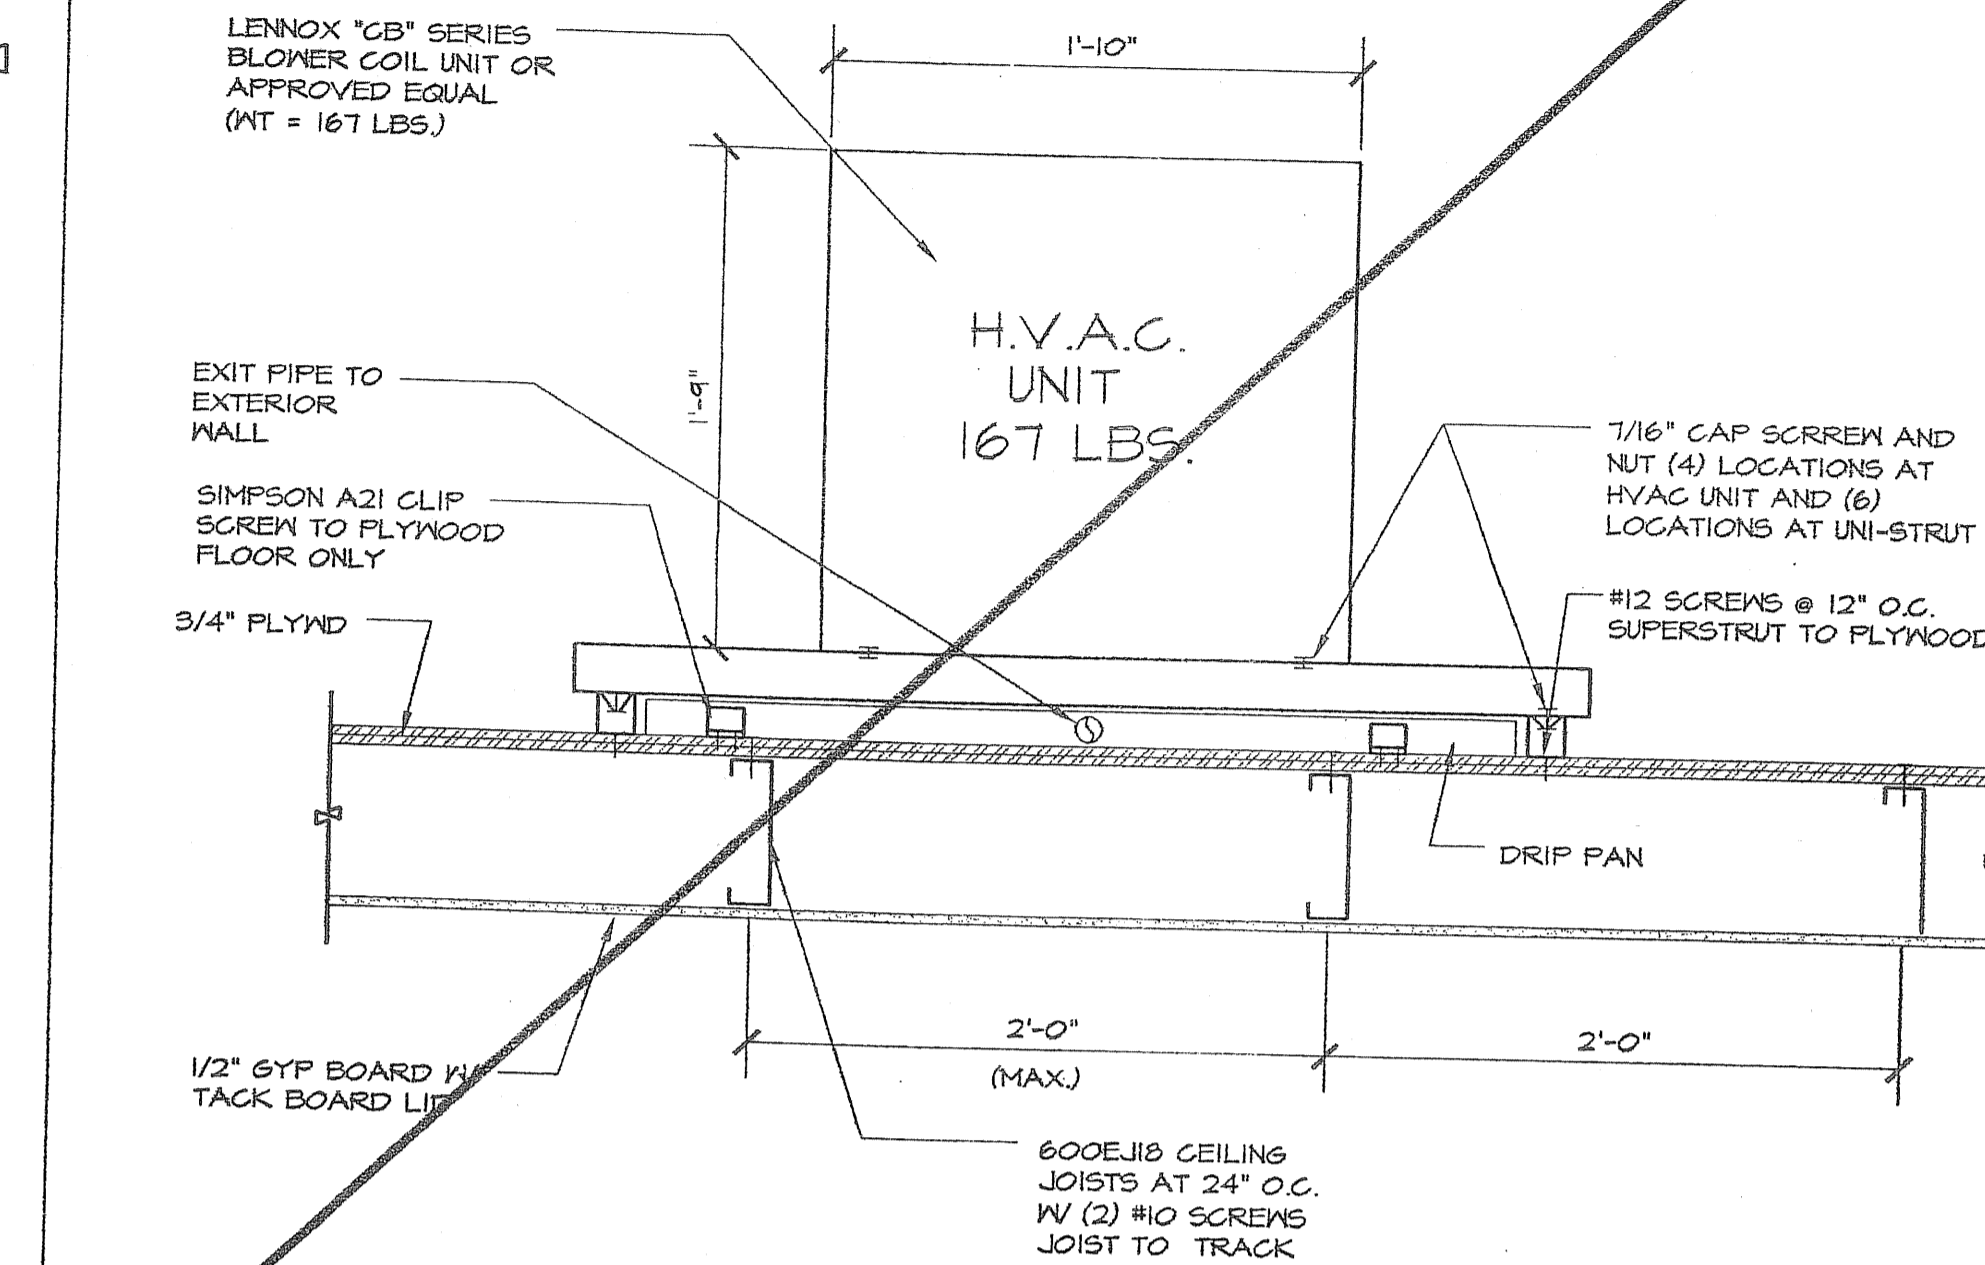


ADD-ALTERNATE HVAC HORIZONTAL MOUNTING
SCALE: 1/2" = 1'-0"

2B
S-12

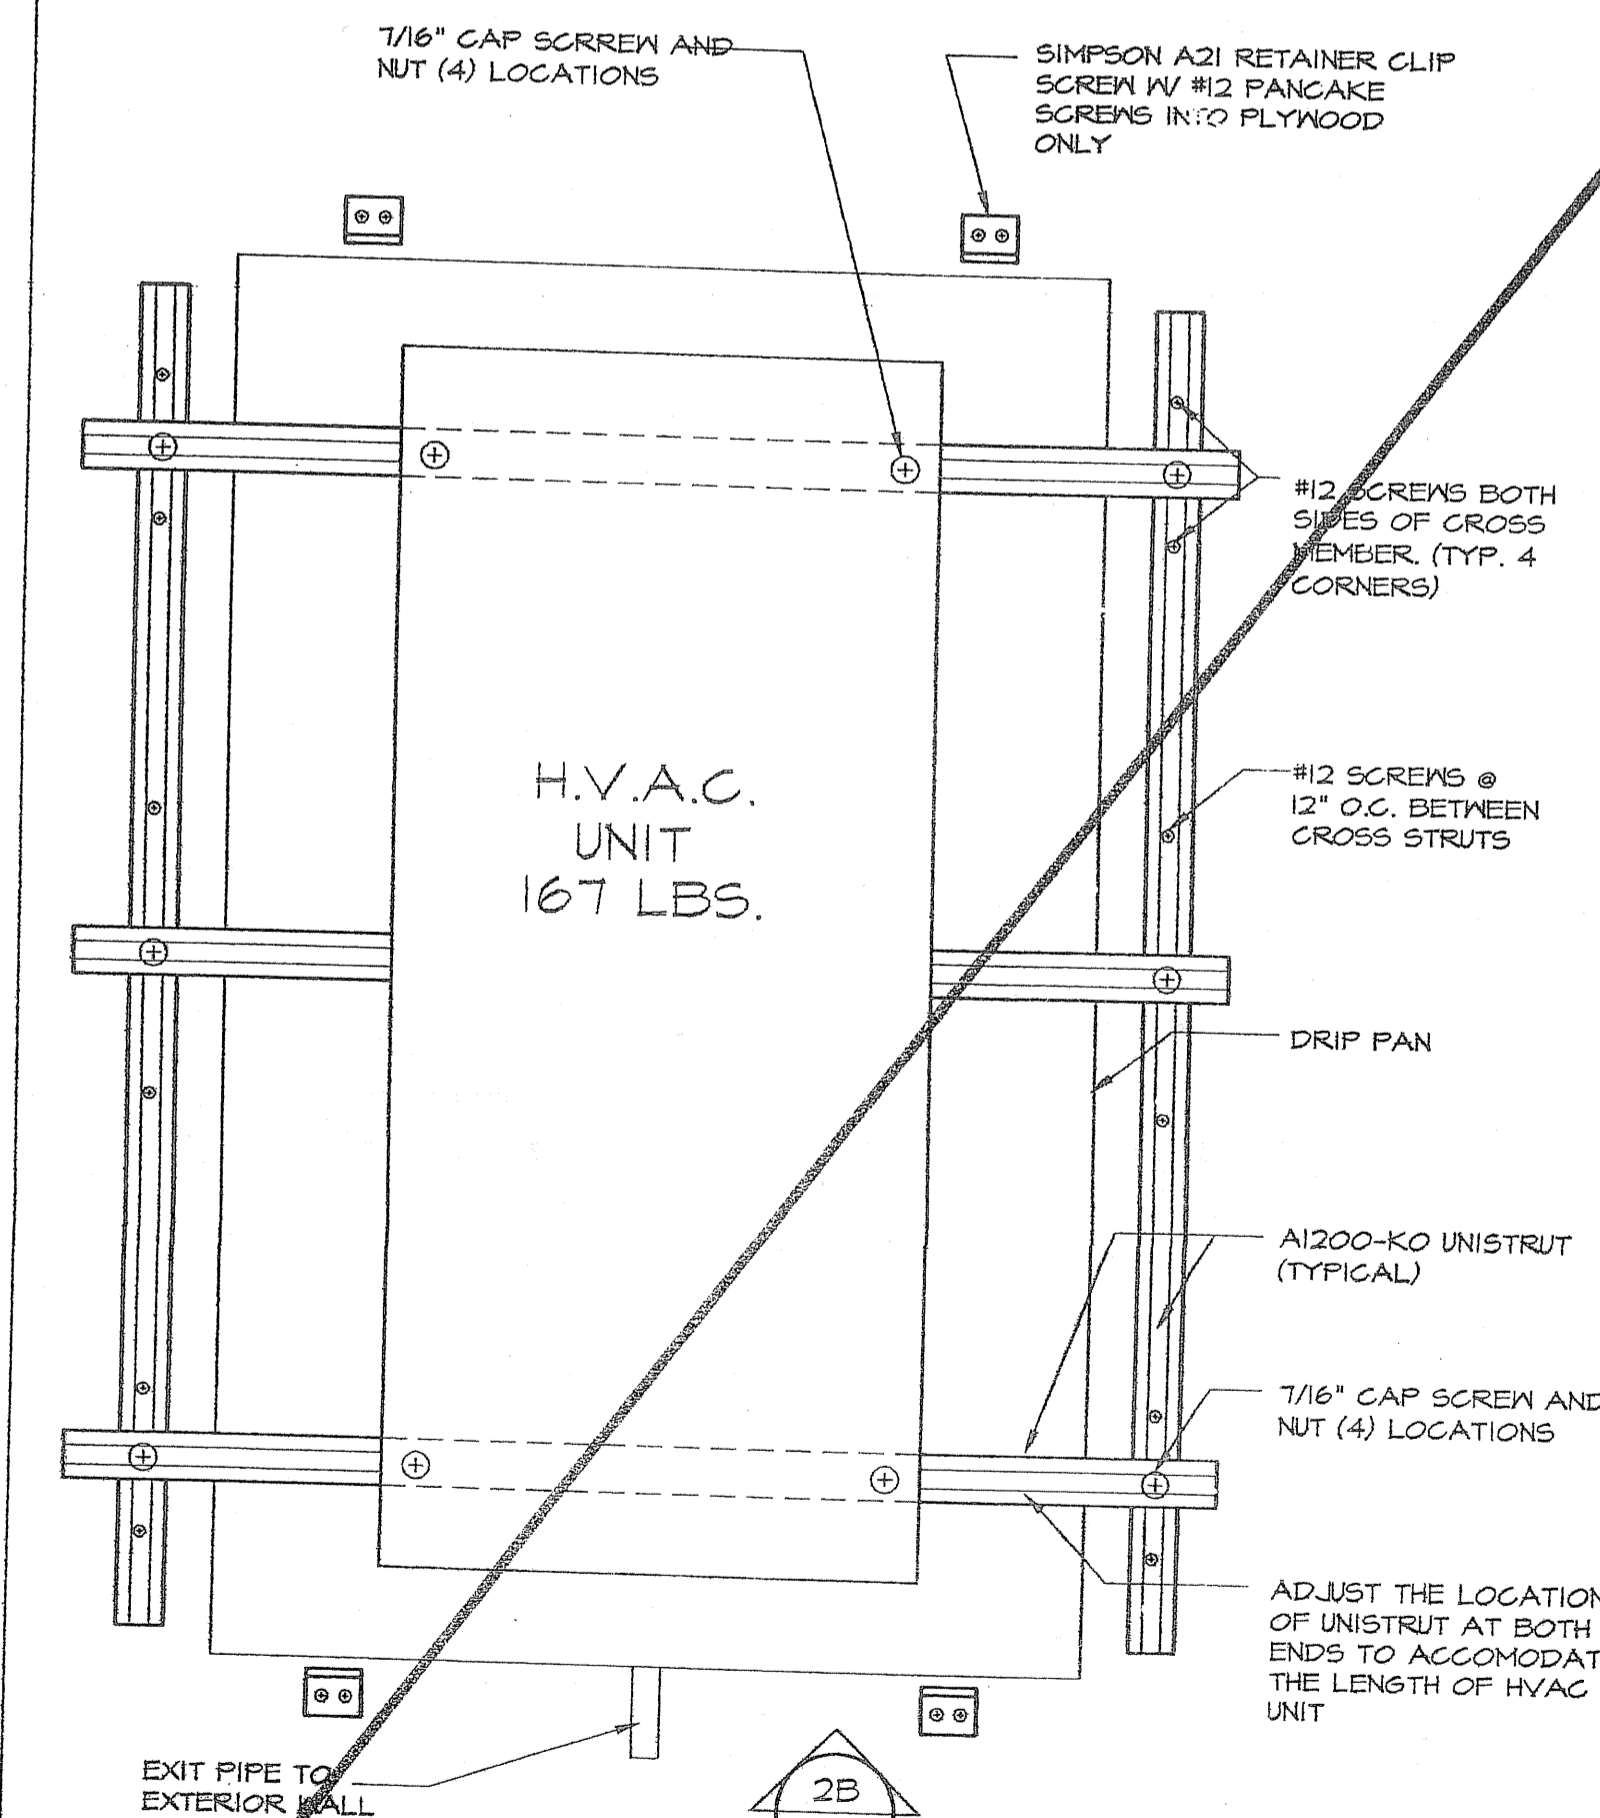

ADD-ALTERNATE HVAC HORIZONTAL MOUNTING
SCALE: 1/2" = 1'-0"

2
S-12

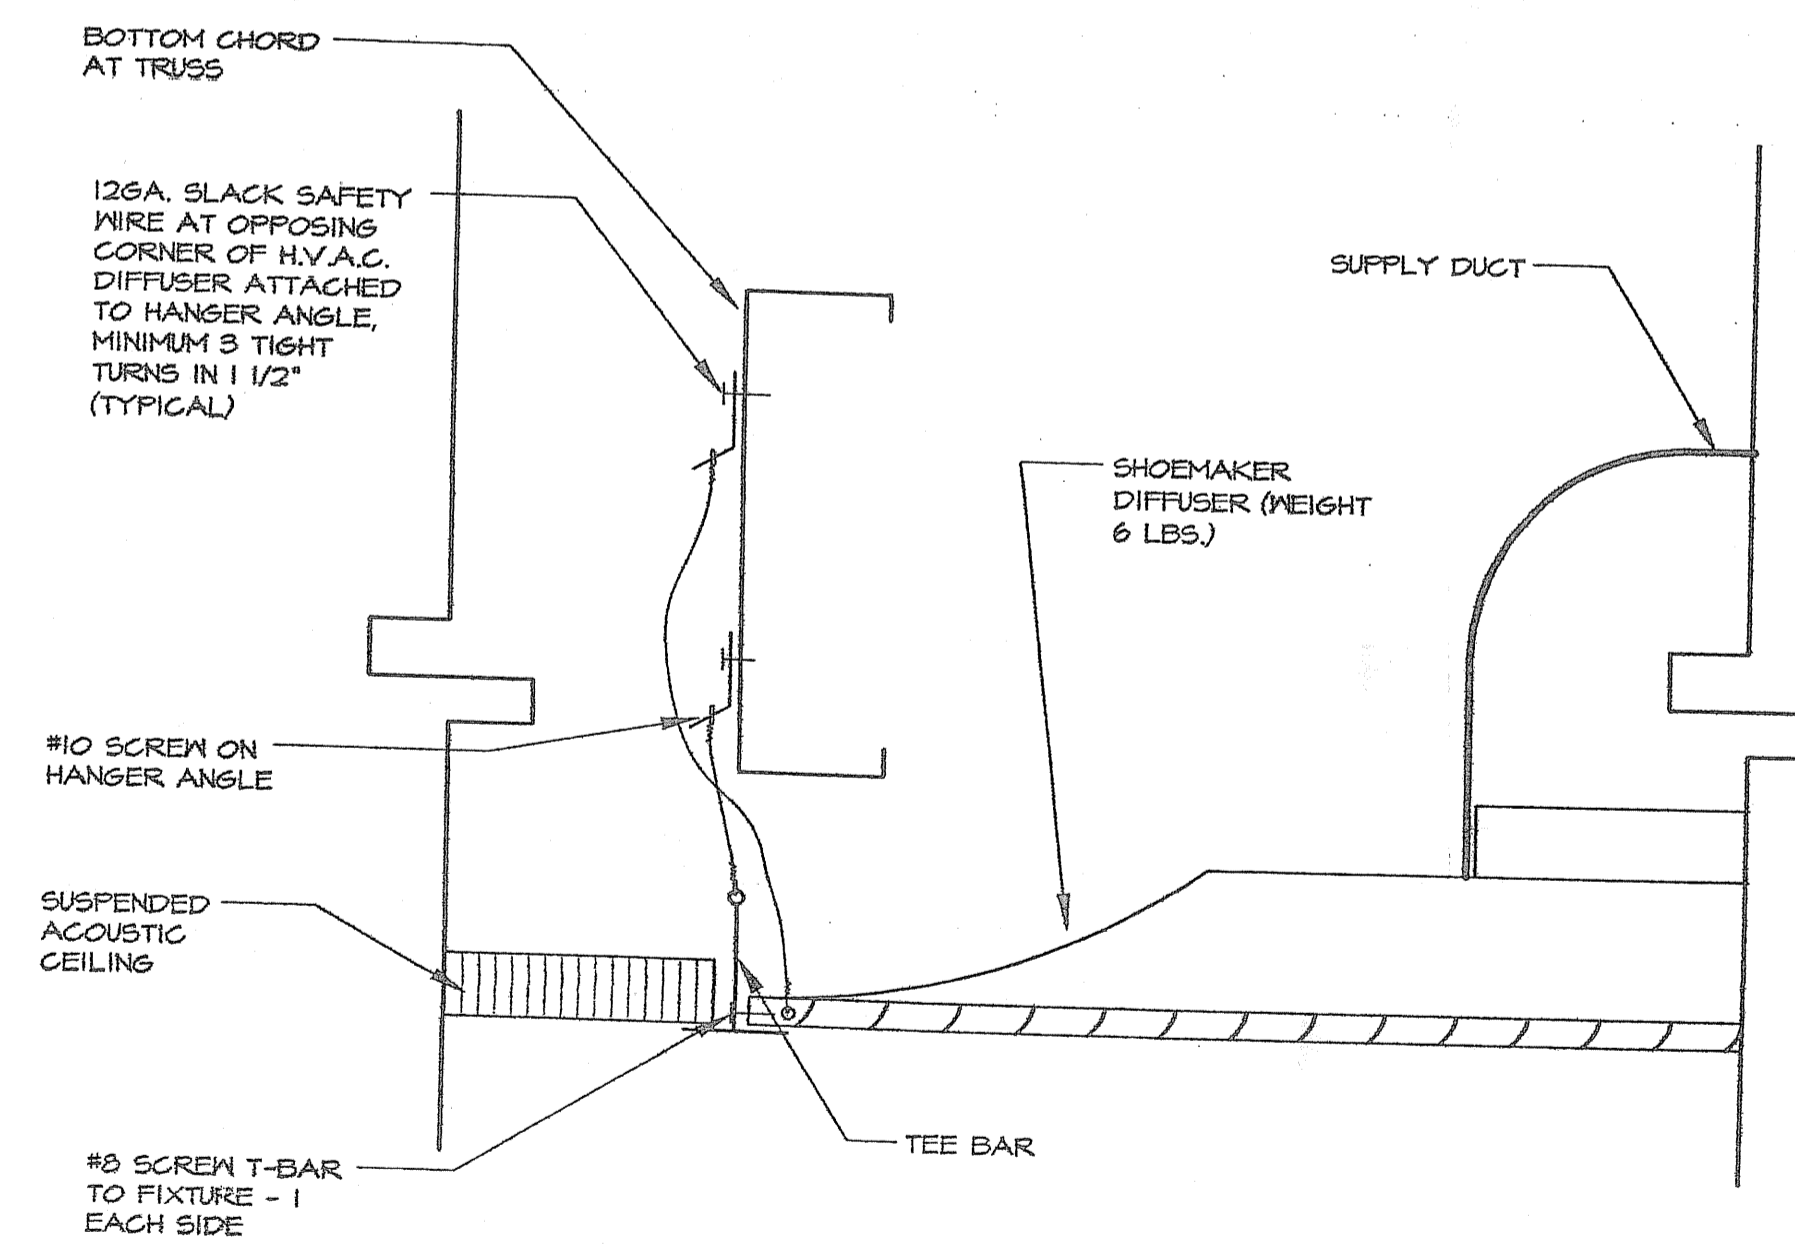

AIR SUPPLY & C.A.R. DIFFUSER
SCALE: 3/8" = 1'-0"

4
S-12



ARCHITECT OF RECORD	SITE SPECIFIC APPLICATION NO.
IDENTIFICATION STAMP DIV. OF THE STATE ARCHITECT OFFICE OF REGULATION SERVICES	
01-108848	
AC	FLS
DATE	JUL 10 2007

DRAWN:	DESIGN TEAM
DATE:	11/15/02
CHECKED:	DESIGN TEAM
SCALE:	AS SHOWN
PROJECT:	1226

S-12

REVISIONS

1		
2		
3		
4		
5		
6		

COPYRIGHT © 2002 TO BE USED IN THE YEARS 2003 - 2005. SARAMARK, INCORPORATED

THESE PLAN DRAWINGS ARE PROPRIETARY DOCUMENTS OF SARAMARK, INCORPORATED & ARE NOT TO BE DISTRIBUTED, PUBLISHED OR REPRODUCED WITHOUT THE WRITTEN CONSENT OF SARAMARK INCORPORATED.

EC CONSULTING GROUP

1250 AVIATION AVE
SUITE 200-F
SAN JOSE, CA 95110
TEL: (408) 294-5813

4000AX SERIES "EXPO 2001"


CLASSROOMS WITH 40' SPAN SCISSOR TRUSS

SARAMARK INCORPORATED

SERIES 4000AX EXPO

P.O. BOX 24380
SAN JOSE, CALIFORNIA 95114
TEL: (408) 971-8881
FAX: (408) 971-8834

TYPICAL MECHANICAL DETAILS

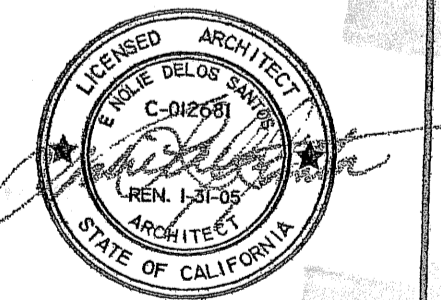

IDENTIFICATION STAMP
DIV. OF THE STATE ARCHITECT
OFFICE OF REGULATION SERVICES

PC 01-105106
AC FLS SS
DATE JUL 17 2003

DRAWN:	DESIGN TEAM
DATE:	11/15/02
CHECKED:	DESIGN TEAM
SCALE:	AS SHOWN
PROJECT:	1226

S-12

AS-BUILTS