

1ST LEVEL FLOOR PLAN
SCALE 1/8"=1'-0"


NOTES

- 1 FOR LEGEND, DETAIL ETC. SEE SHEET P-1
- 2 SLOPE SANITARY PIPING AT 1/8" PER FOOT
- 3 SLOPE STORM DRAINS AT 1/8" PER FOOT
- 4 ALL PIPING UNDER THE FIRST LEVEL GENERALLY SHALL BE INSTALLED BELOW GRADE BEAMS.


SPRINKLER NOTES

- 1 PROVIDE A COMPLETE AUTOMATIC FIRE SPRINKLER SYSTEM THROUGHOUT THE ENTIRE FIRST LEVEL EXCEPT SPRINKLERS WILL NOT BE REQUIRED IN TOILET ROOMS 12, 14, 17, 9, ELECTRICAL 7, GARDENING 1 AND LOBBY 62 EAST OF COL-1 AND SOUTH OF COL-3 (BALANCE OF LOBBY 62 SHALL BE SPRINKLERED)
- 2 SEE SHEET N2-P-02 FOR ADDITIONAL SPRINKLER WORK


ITEM	LOCATION	CAPACITY
HOT WATER GENERATOR	BLDG 10, RM 34A	STORAGE TANK: 66" DIA X 7'-0" HIGH HEATING COIL: 1250 GPH @ 100° F TEMP RISE WITH 200" IN AND 160" OUT HEATING WATER
CIRCULATING PUMP	BLDG 10, RM 34A	5 GPM @ 3' HEAD - 1/2 HP (MIN) MOTOR
WATER PRESSURE REDUCING VALVE	BLDG 10, RM 34A	140 GPM AT 15 P.S.I. PRESSURE DIFFERENTIAL
THERMOSTATIC MIXING VALVES	BLDG 10, RM 34A & 13A	125 GPM AT 45 PSI
SOAP TANKS - ALL (MARKED S.T.)	BLDG 10, SHOWER RMS	2 1/2 GAL.

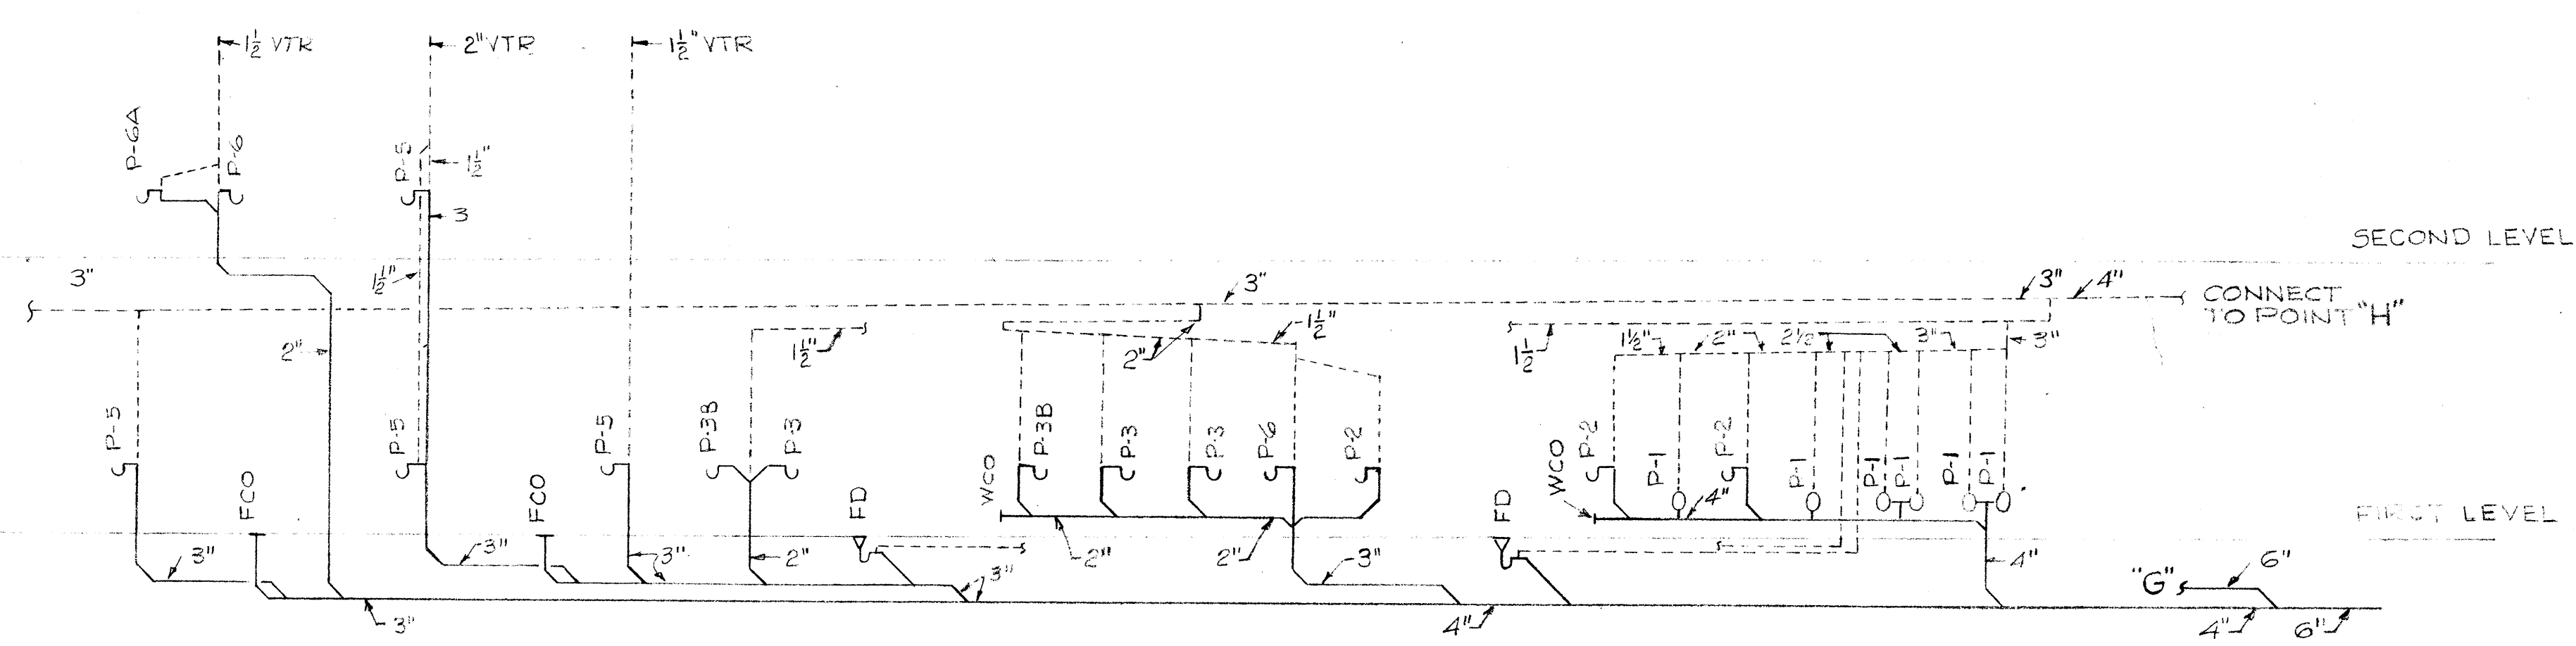

SOIL, WASTE & VENT PIPING DIAGRAM
ROOMS 1, 3, 11, 12, 14 & 130A
NO SCALE

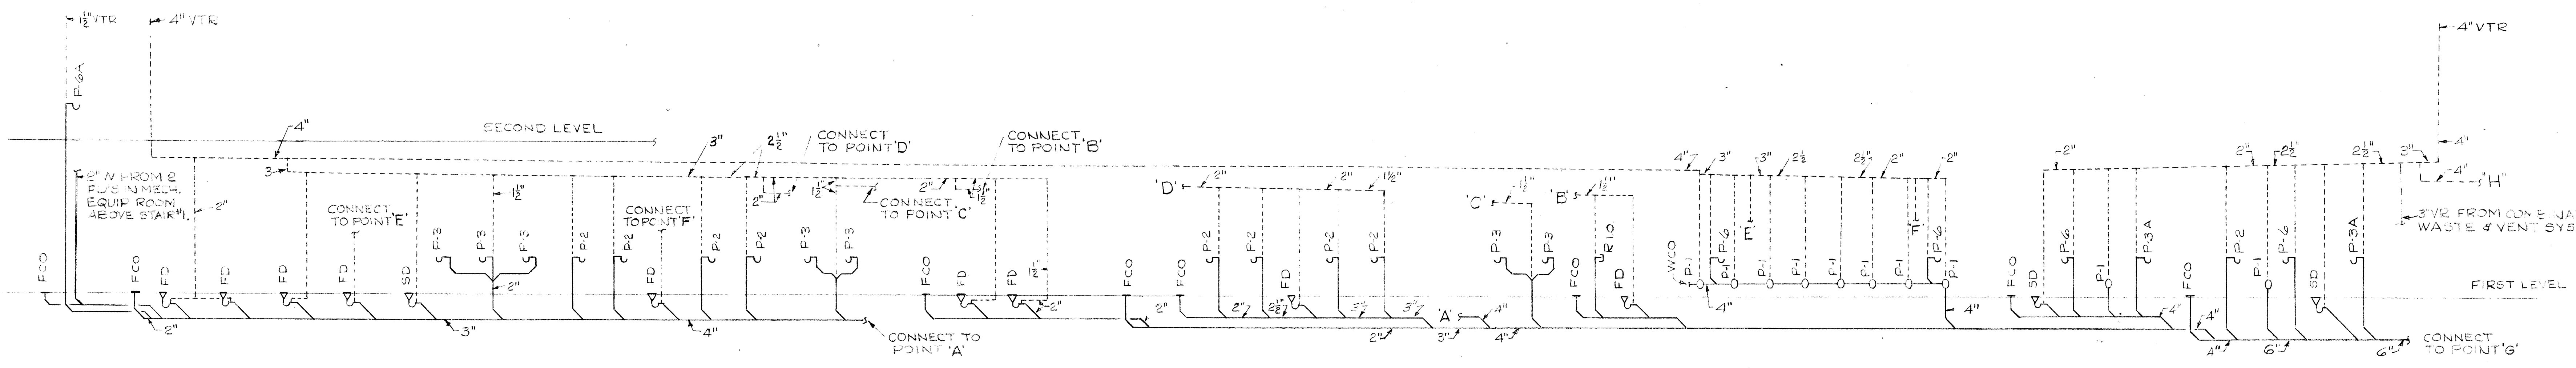

SOIL, WASTE & VENT PIPING DIAGRAM
ROOMS 100, 200, 30, 40, 38, 41, 17, 15, 30, 6 & 15
NO SCALE

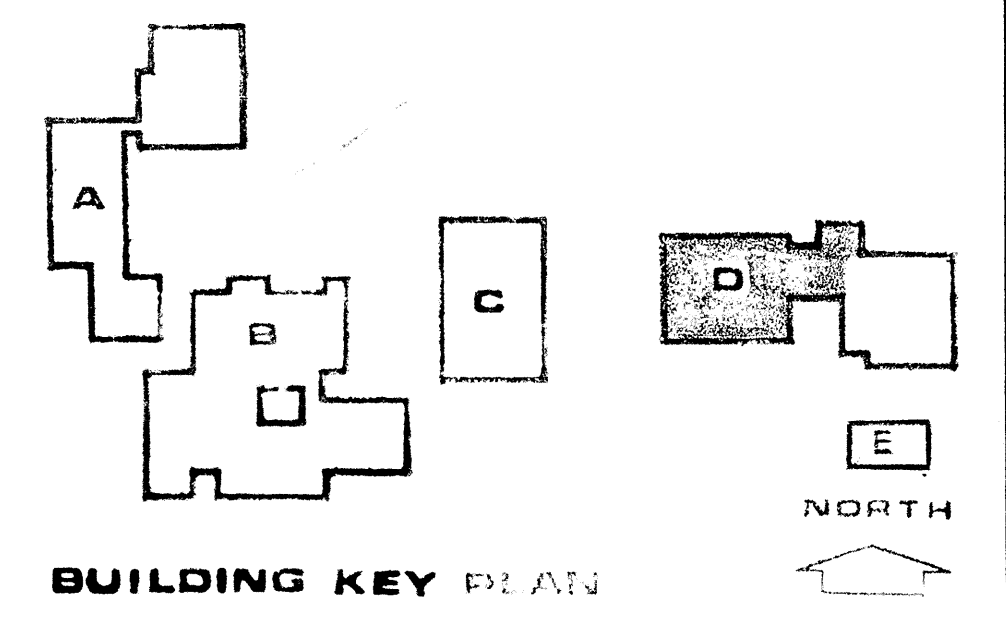

BUILDING D - PHYSICAL EDUCATION
PLUMBING 1ST LEVEL PLAN & DIAGRAM
COLLEGE OF SAN MATEO
SAN BRUNO CALIFORNIA

DATE: FEB 10 1967
CHECKED BY: GRK
JOB NO: 64-15
SCALE: AS SHOWN

DATE: FEB 10 1967
APPROVED: [Signature]
REVISION DESCRIPTION: [Blank]
SHEET NUMBER: 1 OF 4 SHEETS
REVISION NO.: