

MECHANICAL ROOM
ABOVE STAIR #1
SCALE 3/8" = 1'-0"


2ND LEVEL - FLOOR PLAN
SCALE 3/8" = 1'-0"

NOTES
1. FOR LEGEND, DETAILS ETC. SEE SHEET P-1


SPRINKLER NOTES
1. PROVIDE FIRE SPRINKLERS IN ROOMS NO. 130, 100A, 100B
2. SEE SHEET NB P-02 FOR ADDITIONAL SPRINKLER WORK.

SHOWER FITTING WATER SUPPLY PIPE SIZING CHART


SUPPLY PIPE SIZE	MAX. NO. OF SHOWER HEADS
3/4"	1
1"	3
1 1/2"	25
2"	80

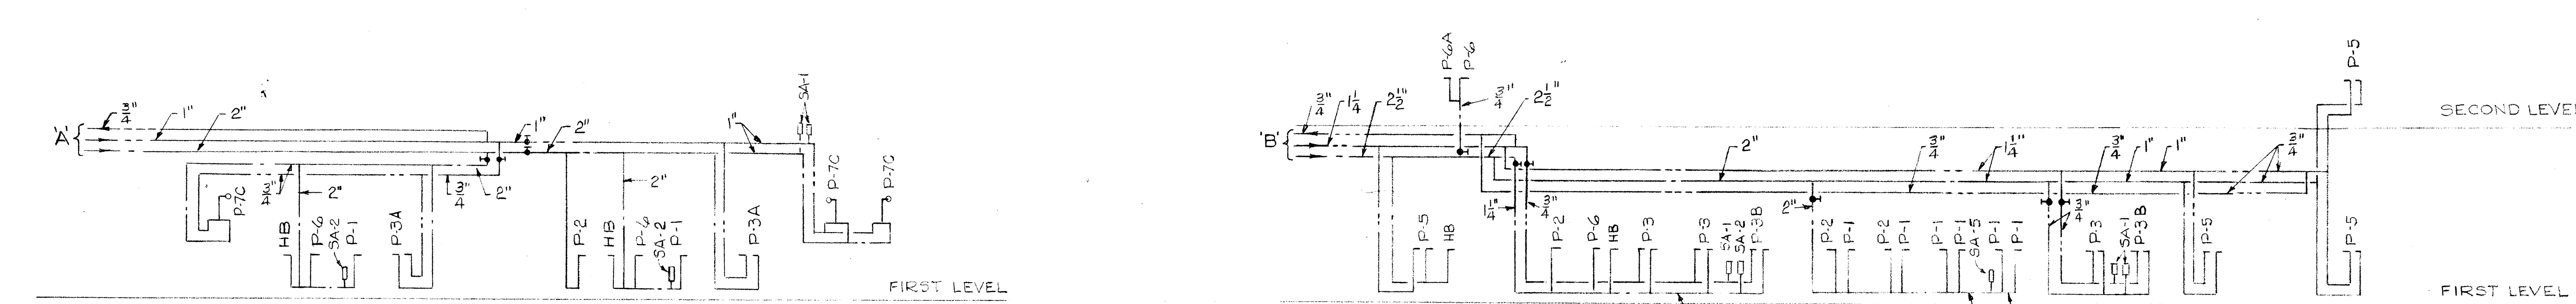

HOT & COLD WATER PIPING DIAGRAM
ROOMS 1, 5, 10, 11, 12, 14, 18, 30, 32, 40, 130
NO SCALE

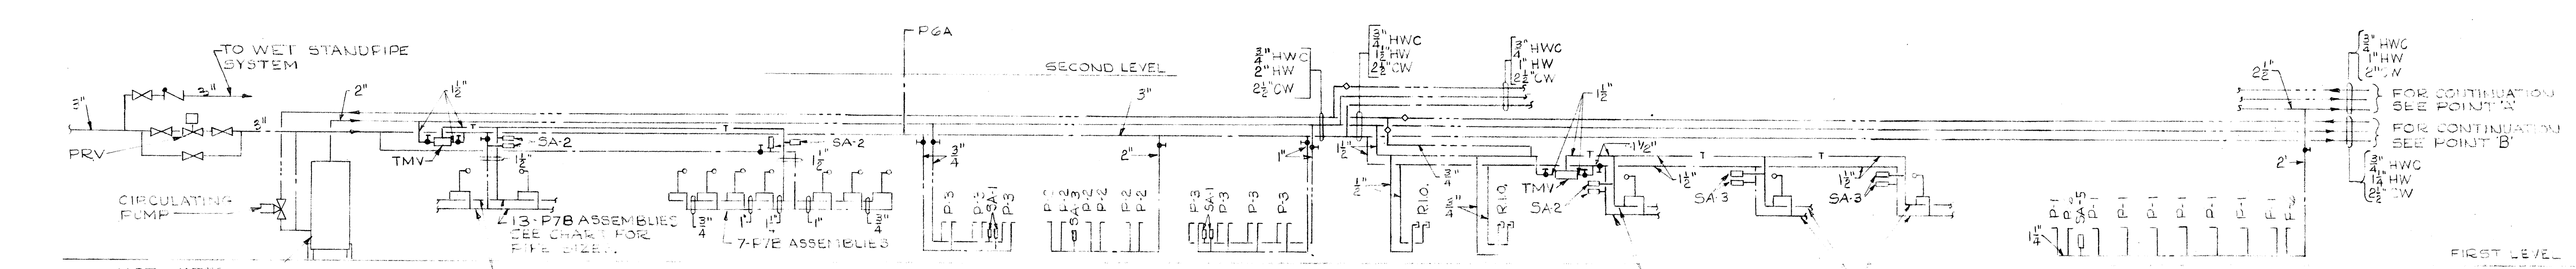

HOT & COLD WATER PIPING DIAGRAM
ROOMS 15, 17, 21, 34A, 38, 40, 100
NO SCALE

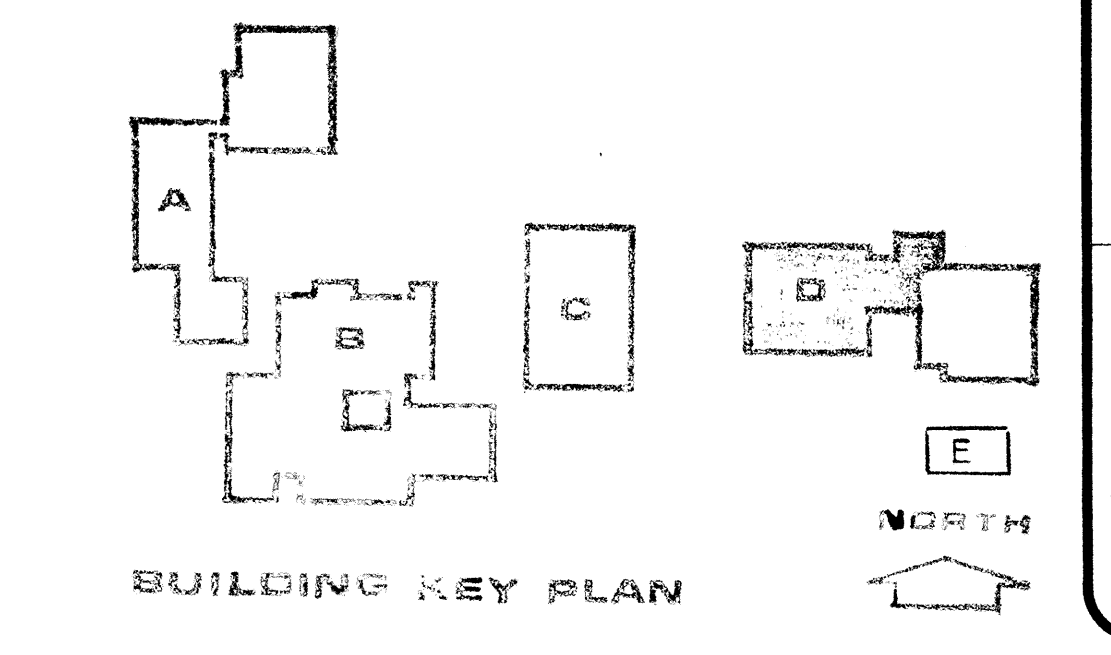

BUILDING KEY PLAN