

ABBREVIATIONS

AB ANCHOR BOLT	E EAST	INT INTERIOR	REV REVISION
AC ASPHALTIC CONC	(E) EXISTING	JST JOIST	RM ROOM
ACC ACCESS	EJ EACH	JAN JANITOR	RO ROUGH OPENING
ACOUS ACOUSTICAL	EJ EXPANSION JOINT	J BOX JUNCTION BOX	RWL RAIN WATER LEADER
AD AREA DRAIN	EL ELEVATION	JCAF CCC CHANCELLOR'S OFFICE FORM	S SOUTH
ADJ ADJACENT/ADJUSTABLE	ELEC ELECTRICAL	JT JOINT	SAF SPRAY APPLIED FIREPROOFING
AFF ABOVE FINISHED FLOOR	ELEV ELEVATOR	LAM LAMINATE	SC SOLID CORE
AGG AGGREGATE	EP ELECTRICAL PANEL	LAV LAVATORY	SCD SEE CIVIL DRAWINGS
ALT ALTERNATE	EQ EQUAL	LAC LAG BOLT	SCHD SCHEDULE
ALUM ALUMINUM	EQUIP EQUIPMENT	LF LINEAR FEET	SIST SELF DRILLING SELF TAPPING
& AND	EWC ELECTRIC WATER COOLER	LKR LOCKER	SE STRUCTURAL ENGINEER
ANOD ANODIZED	EXH EXHAUST	LT LIGHT	SEE ELECTRICAL DRAWINGS
APPROX APPROXIMATE	EXP EXPANSION	MAG MAGNETIC	SF SUPPLY FAN
@ AT	EXT EXTERIOR	MAS MASONRY	SMD SEE MECHANICAL DRAWINGS
ASF ASSIGNABLE SQUARE FEET	FA FIRE ALARM	SLAB ON GRADE	SS STAINLESS STEEL
	FD FLOOR DRAIN	MATL MATERIAL	SSD SEE STRUCTURAL DRAWINGS
	FDN FOUNDATION	MAX MAXIMUM	STD STANDARD
	FE FIRE EXTINGUISHER	MB MACHINE BOLT	SEC SECTION
	FEC FIRE EXTINGUISHER CABINET	MBR MODIFIED BITUMENT ROOF	SH SINGLE HUNG
	FF&E FURNITURE, FIXTURE & EQUIPMENT	MEMB MEMBRANE	SHT SHEET
	FOF FACE OF FINISH	MECH MECHANICAL MANUFACTURER	SHTG SHEATHING
	FIN FLR FINISHED FLOOR	MFR MANHOLE	SIM SIMILAR
	FIXT FIXTURE	MH MINIMUM	SLD SEE LANDSCAPE DRAWINGS
	FLR FLOOR	MIN MINIMUM	SP STONE PANEL
	FLUOR FLUORESCENT	MISC MISCELLANEOUS	SPC SPECIFICATION
	FOC FACE OF CONCRETE	MTD MOUNTED	SQ SQUARE
	FOF FACE OF FINISH	MTL METAL	SSK SERVICE SINK
	FOS FACE OF STUD	MUL MULLION	STL STEEL
	FR FIRE RESISTANT/RETARDANT	N NEW	STRL STRUCTURAL
	FT FOOT OR FEET	(N) NOT APPLICABLE	STOR STORAGE
	FTG FOOTING	NA NOT IN CONTRACT	SUSP SUSPENDED
	FURN FURNITURE	NTS NOT TO SCALE	SYSTEM SYSTEM
	FX FIXED	NO NUMBER	T TREAD
		NOM NOMINAL	TEL TELEPHONE
		OA OVERALL	TEMP TEMPERED
		OC ON CENTER	T&G TONGUE & GROOVE
		OD OUTSIDE DIAMETER/	THRESH THRESHOLD
		OD OVERFLOW DRAIN	THK THICK(NESS)
		OF OUTSIDE FACE	TJI TRUSS JOIST
		OF CI OWNER FURNISH- CONTRACTOR INSTALL	TOC TOP OF PAVING
		OFF OFFICE	TOP TOP OF CONCRETE/CURB
		OP OPERABLE	TOP TOP OF STEEL
		OPP HD OPPOSITE HAND	TOW TOP OF WALL
		OPNG OPENING	TS TUBE STEEL
		OPP OPPOSITE	TW TOP OF WALL
			TYP TYPICAL
		PA PLANTING AREA	UON UNLESS OTHERWISE NOTED
		PARTN PARTITION	UR URINAL
		PCC PRECAST CONCRETE	
		PL PLATE	VCT VINYL COMPOSITION TILE
		P LAM PLASTIC LAMINATE	VIF VERIFY IN FIELD
		PLAS PLASTIC	VENT VENTILATION
		PLY PLYWOOD	VERT VERTICAL
		PR PAIR	VEST VESTIBULE
		PROJ PROJECT/PROJECTOR	
		PT POINT/PRESSURE TREATED	W WEST, WIDTH
		PTD PAINTED	W/ WITH
		PVC POLYVINYLCHLORIDE	W/O WITHOUT
			WC WATER CLOSET
			WD WOOD
			WDO WINDOW
			WH WATER HEATER
			WP WATERPROOF
			WR WATER RESISTANT
			WT WEIGHT

INDEX OF DRAWINGS

GENERAL
 COVER COVER SHEET
 G0.0 INDEX, SYMBOLS & ABBREV
 G0.1 OVERALL SITE FIRE ACCESS
 G0.2 OVERALL PROPOSED PATH OF TRAVEL
 G0.3 ENLARGED PATH OF TRAVEL SITE PLAN

CIVIL
 C1.01 GRADING PLAN - FOR REFERENCE ONLY

LANDSCAPE
 L1.02 LAYOUT AND MATERIALS PLAN
 L5.00 IRRIGATION NOTES & LEGEND
 L5.02 IRRIGATION PLAN
 L5.05 IRRIGATION DETAILS
 L5.06 IRRIGATION DETAILS
 L6.02 PLANTING PLAN
 L6.05 PLANTING DETAILS

ARCHITECTURAL
 A2.01 SITE DETAILS

STRUCTURAL
 S0.01 GENERAL NOTES
 S1.01 DETAILS
 S5.01 CONCRETE TYPICAL DETAILS

ELECTRICAL
 E1 ELECTRICAL 1 LINE DIAGRAM AND DETAILS
 E2 ELECTRICAL DETAILS



729 Heinz Avenue
 Berkeley, CA 94710
 510.649.8295
 fax 510.649.3008


CALIFORNIA STATE FIRE MARSHAL APPROVED

APPROVAL OF THESE PLANS DOES NOT AUTHORIZE OR APPROVE ANY OTHER OR DEVIATION FROM APPLICABLE REGULATIONS. FINAL APPROVAL IS SUBJECT TO REGISTRATION. ONE SET OF APPROVED PLANS SHALL BE AVAILABLE ON THE PROJECT SITE AT ALL TIMES.

REVIEWED BY: _____ DATE: _____

CSM NORTH GATEWAY
LOAD CENTER & SITE WALL

1700
 West Hillsdale Blvd
 San Mateo, CA
 94402

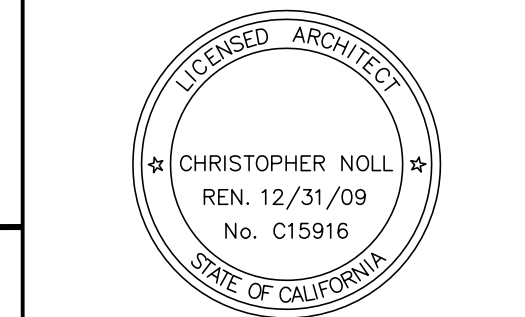

PROJECT RECORD DOCUMENT

SHEET TITLE
INDEX, SYMBOLS AND ABBREVIATIONS


REVISIONS		
NO.	DATE	DESCRIPTION

DATE: FEBRUARY 24, 2012

DRAWN: DK
 CHECKED: ML
 SCALE: NO SCALE
 JOB NO.: 2805

SHEET NUMBER
GO.0

SYMBOLS

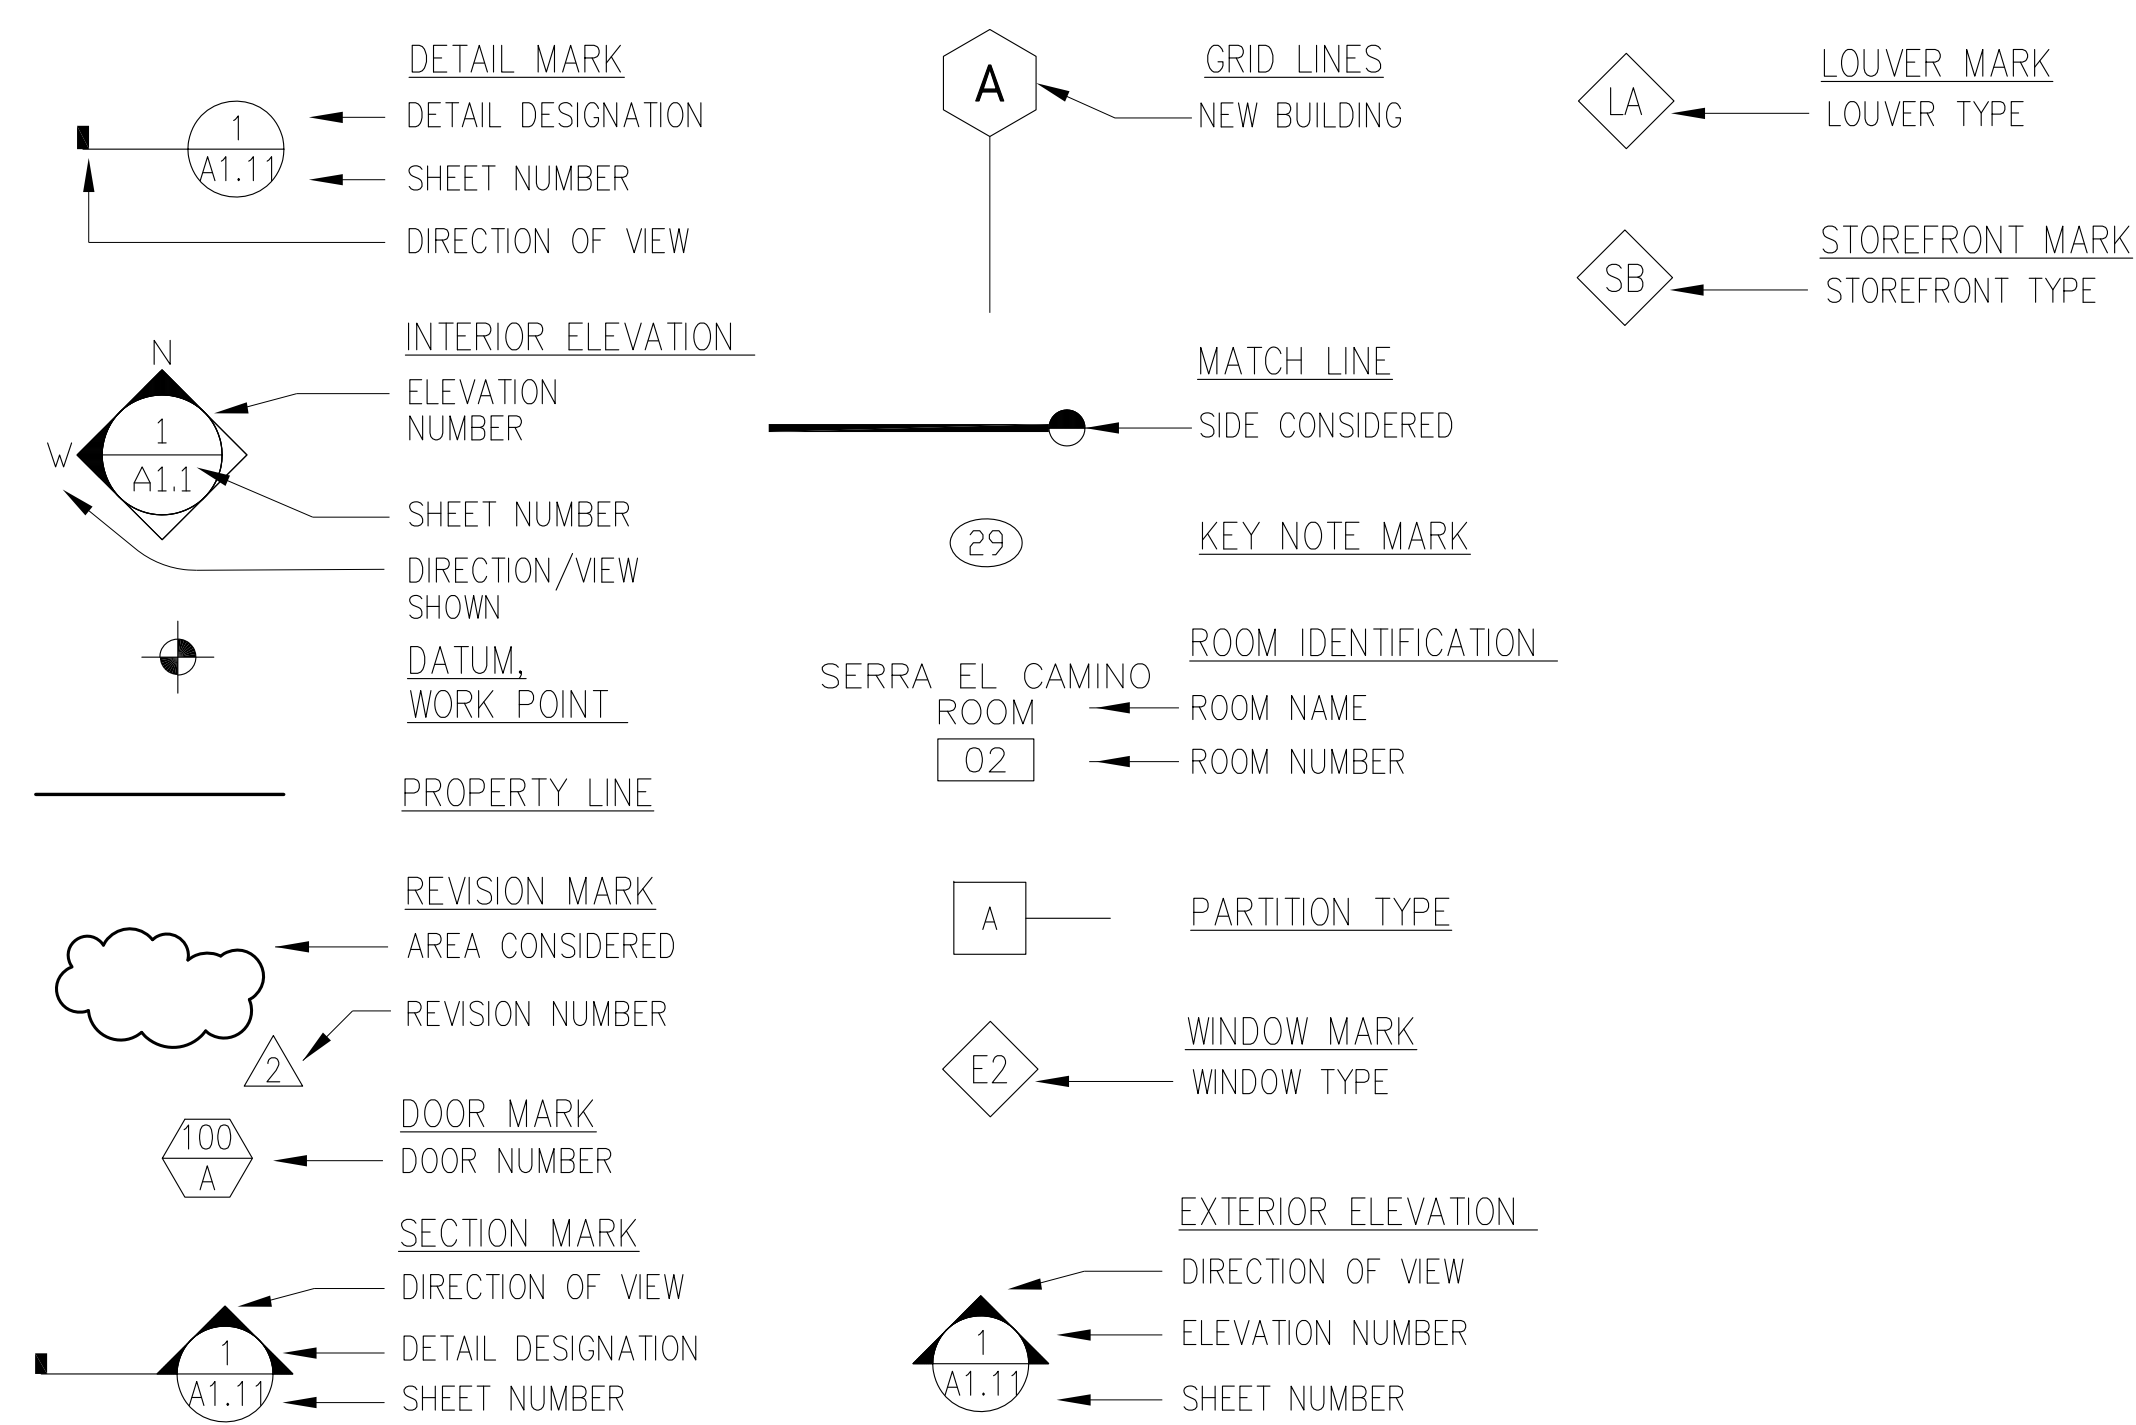

ARCHITECT'S STATEMENT

With the exception of the General (G Series) and Architectural (A Series) these drawings and/or specifications and/or calculations for the items listed above have been prepared by other design professionals or consultants who are licensed and/or authorized to prepare such drawings in this state. These documents have been examined by me for design intent and appear to meet the appropriate requirements of Title 24, California Code of Regulations and the project specifications prepared by me.

The items listed above have been coordinated with my plans and specifications and are acceptable for incorporation into the construction of this project for which I am the individual designated to be in general responsible charge.

The accepted drawings are listed above.

Christopher Noll, Principal
 NOLL & TAM Architects

Date _____

CA License No C15916
 12/31/09

Expiration Date: _____