



**HORIZONTAL CONTROL PLAN**  
SCALE: 1"=10'

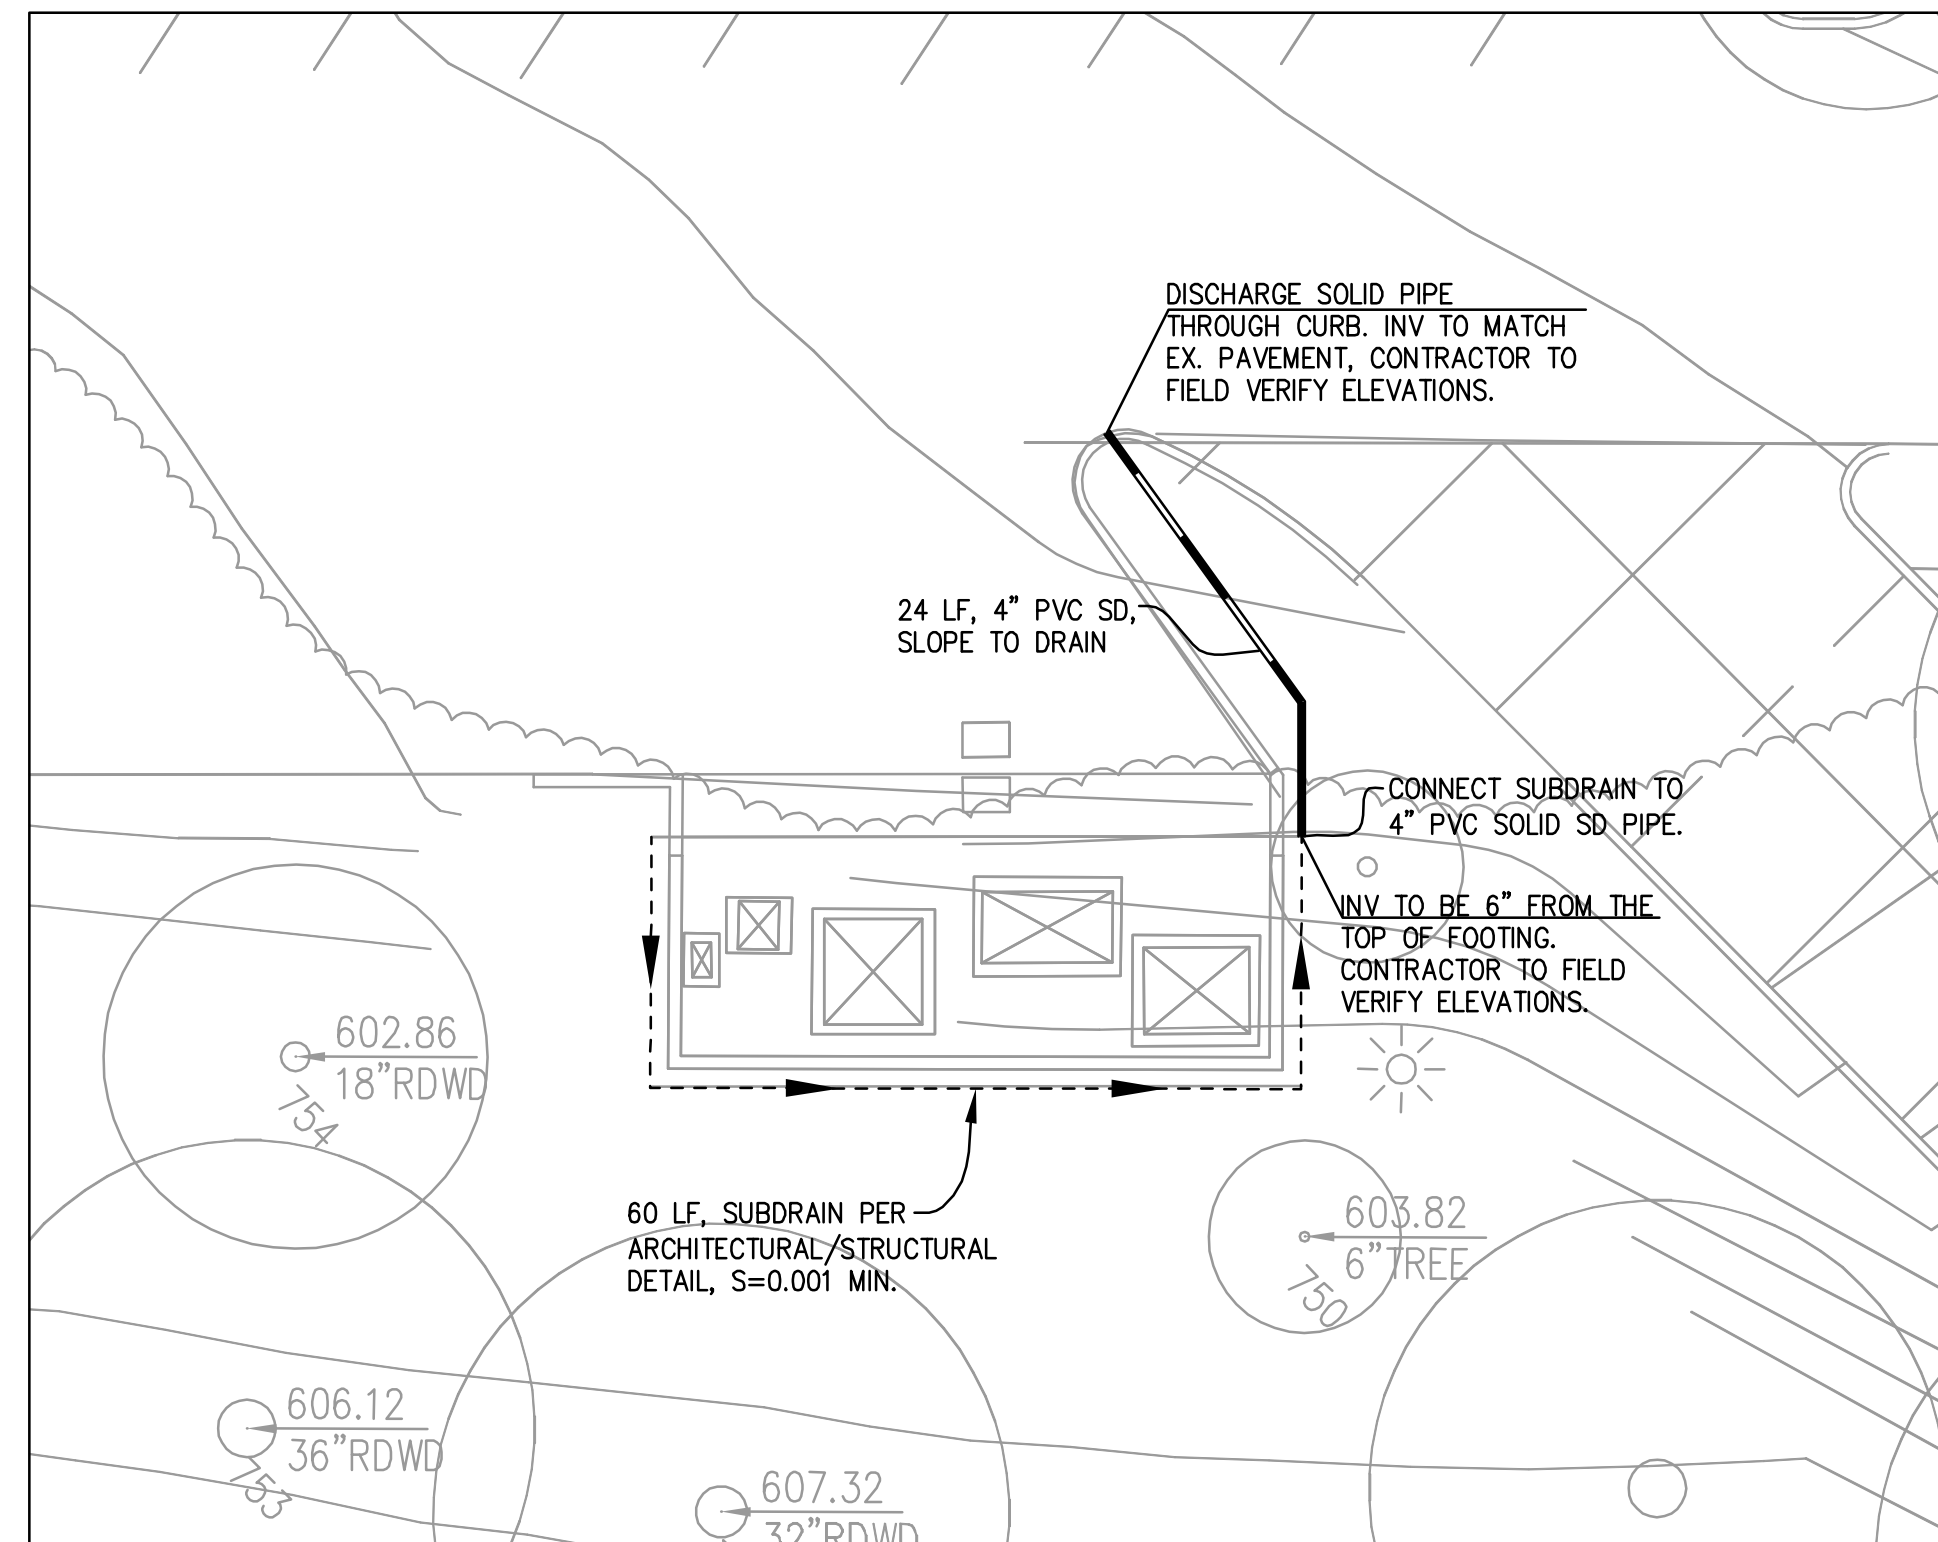



**DRAINAGE PLAN**  
SCALE: 1"=10'

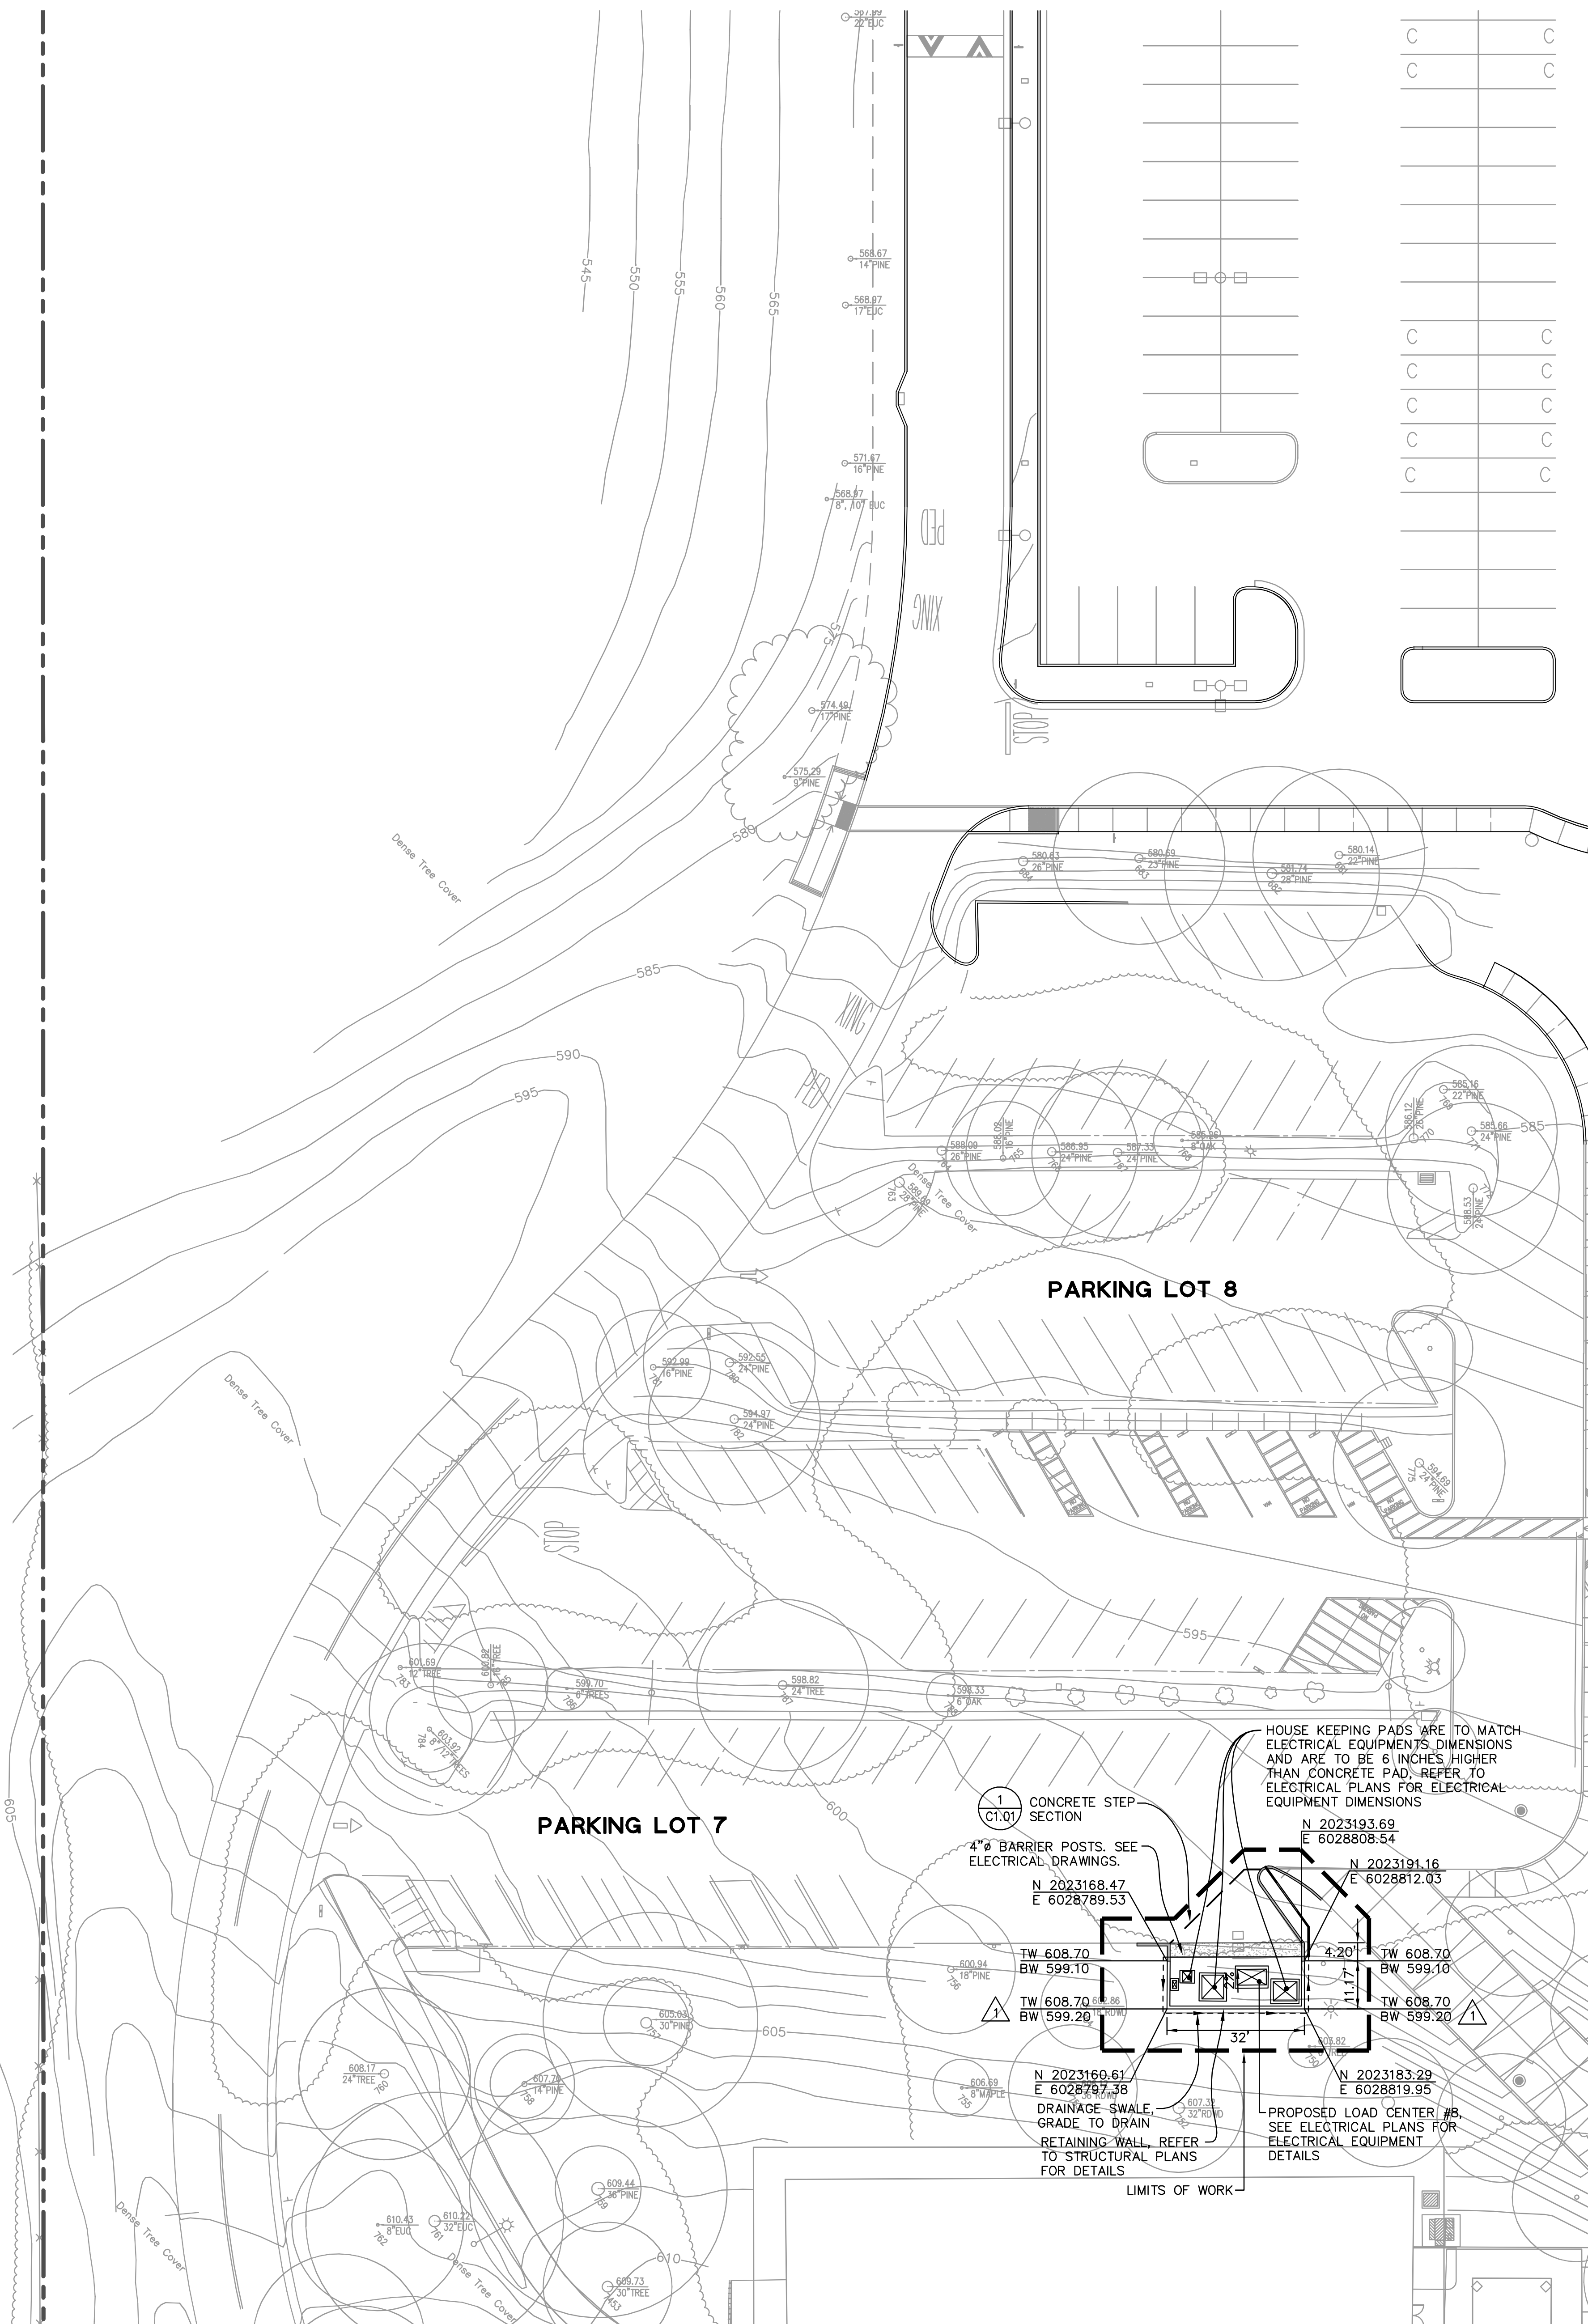

**RECORD DRAWINGS**

THESE RECORD DOCUMENTS HAVE BEEN PREPARED BASED ON INFORMATION PROVIDED BY OTHERS. BKF ENGINEERS HAS NOT VERIFIED THE ACCURACY AND/OR COMPLETENESS OF THIS INFORMATION AND SHALL NOT BE RESPONSIBLE FOR ANY ERRORS OR OMISSIONS THAT MAY BE INCORPORATED HEREIN AS A RESULT. BKF ENGINEERS DOES NOT ASSUME ANY RESPONSIBILITY FOR THE FIELD MODIFICATIONS TO THE PLANS.

BY: BKF ENGINEERS DATE: FEBRUARY 2012

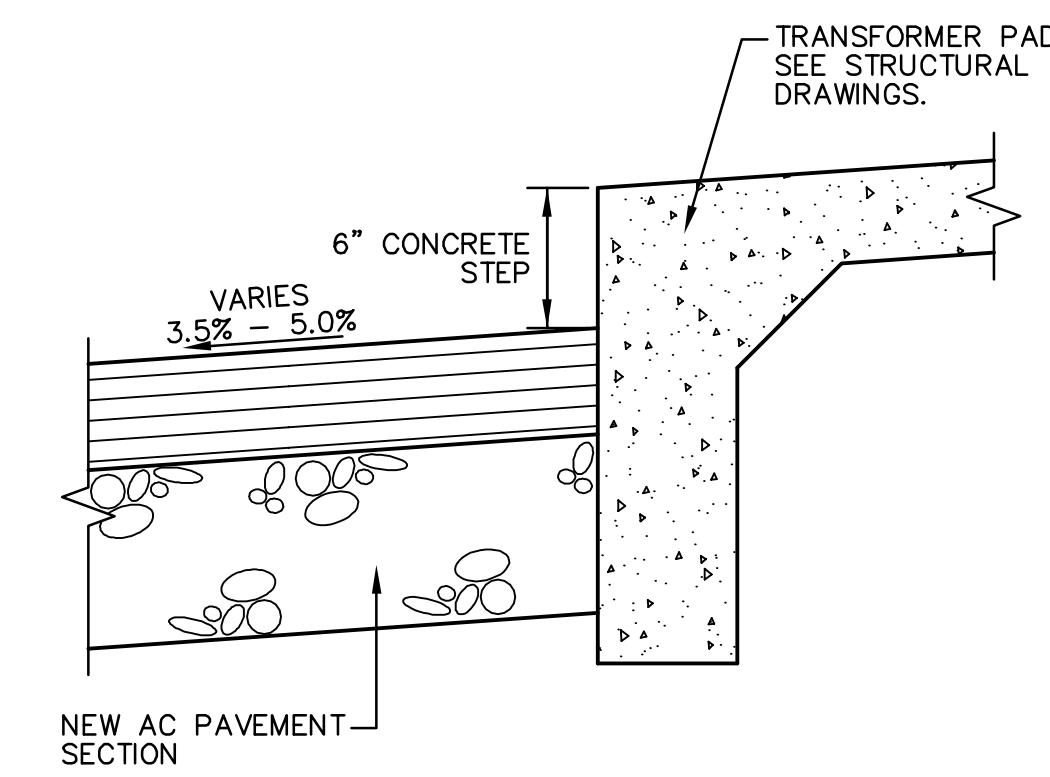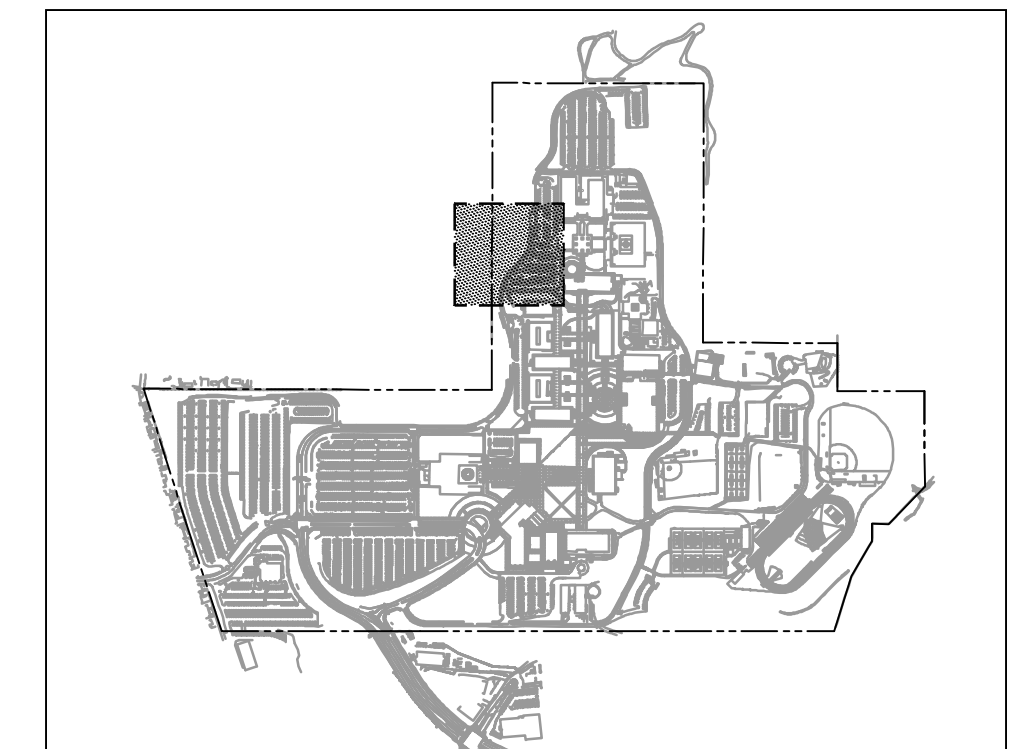

**CONCRETE STEP SECTION**  
NTS

REVISIONS		
NO.	DATE	DESCRIPTION
1	1/7/11	RFI 007
2	6/30/11	RFI 033
3	6/30/11	RFI 034

DATE	FEBRUARY 24, 2012
DRAWN	MC, JT
CHECKED	RH
SCALE	1"=20'
JOB NO.	2805