

NO.	REVISIONS/DESCRIPTIONS	DATE
1	ISSUE FOR PERMITS	12/11/09
2	ISSUE FOR CONSTRUCTION	11/17/09
3	RECORD DRAWINGS	06/19/10

DRAWING STATUS	DATE
DESIGNED/CHECKED	07/21/2008
DESIGNED/CHECKED	11/27/2009
CONSTRUCTION	
ASSEMBLED	06/21/2010

DIVISION OF THE
 STATE ARCHITECT
 APPL # 01-110894
 REG # 11621
 AC DATE
 SSS #13
 IDENTIFICATION STAMP


**AS-BUILTS
 RECORD
 SET**

**SKYLINE COLLEGE
 SAN MATEO COUNTY
 DISTRICT
 CIP2 DESIGN-BUILD
 PROJECT
 CAMPUS 12KV
 SYSTEM UPGRADE**


PROJECT NO.: SF1057011 DRAWN BY: MS
 DATE: 08/31/10 CHECKED BY: AS
 SCALE: AS INDICATED
 SHEET TITLE:

SINGLE LINE DIAGRAM

SHEET NO: **E-001**

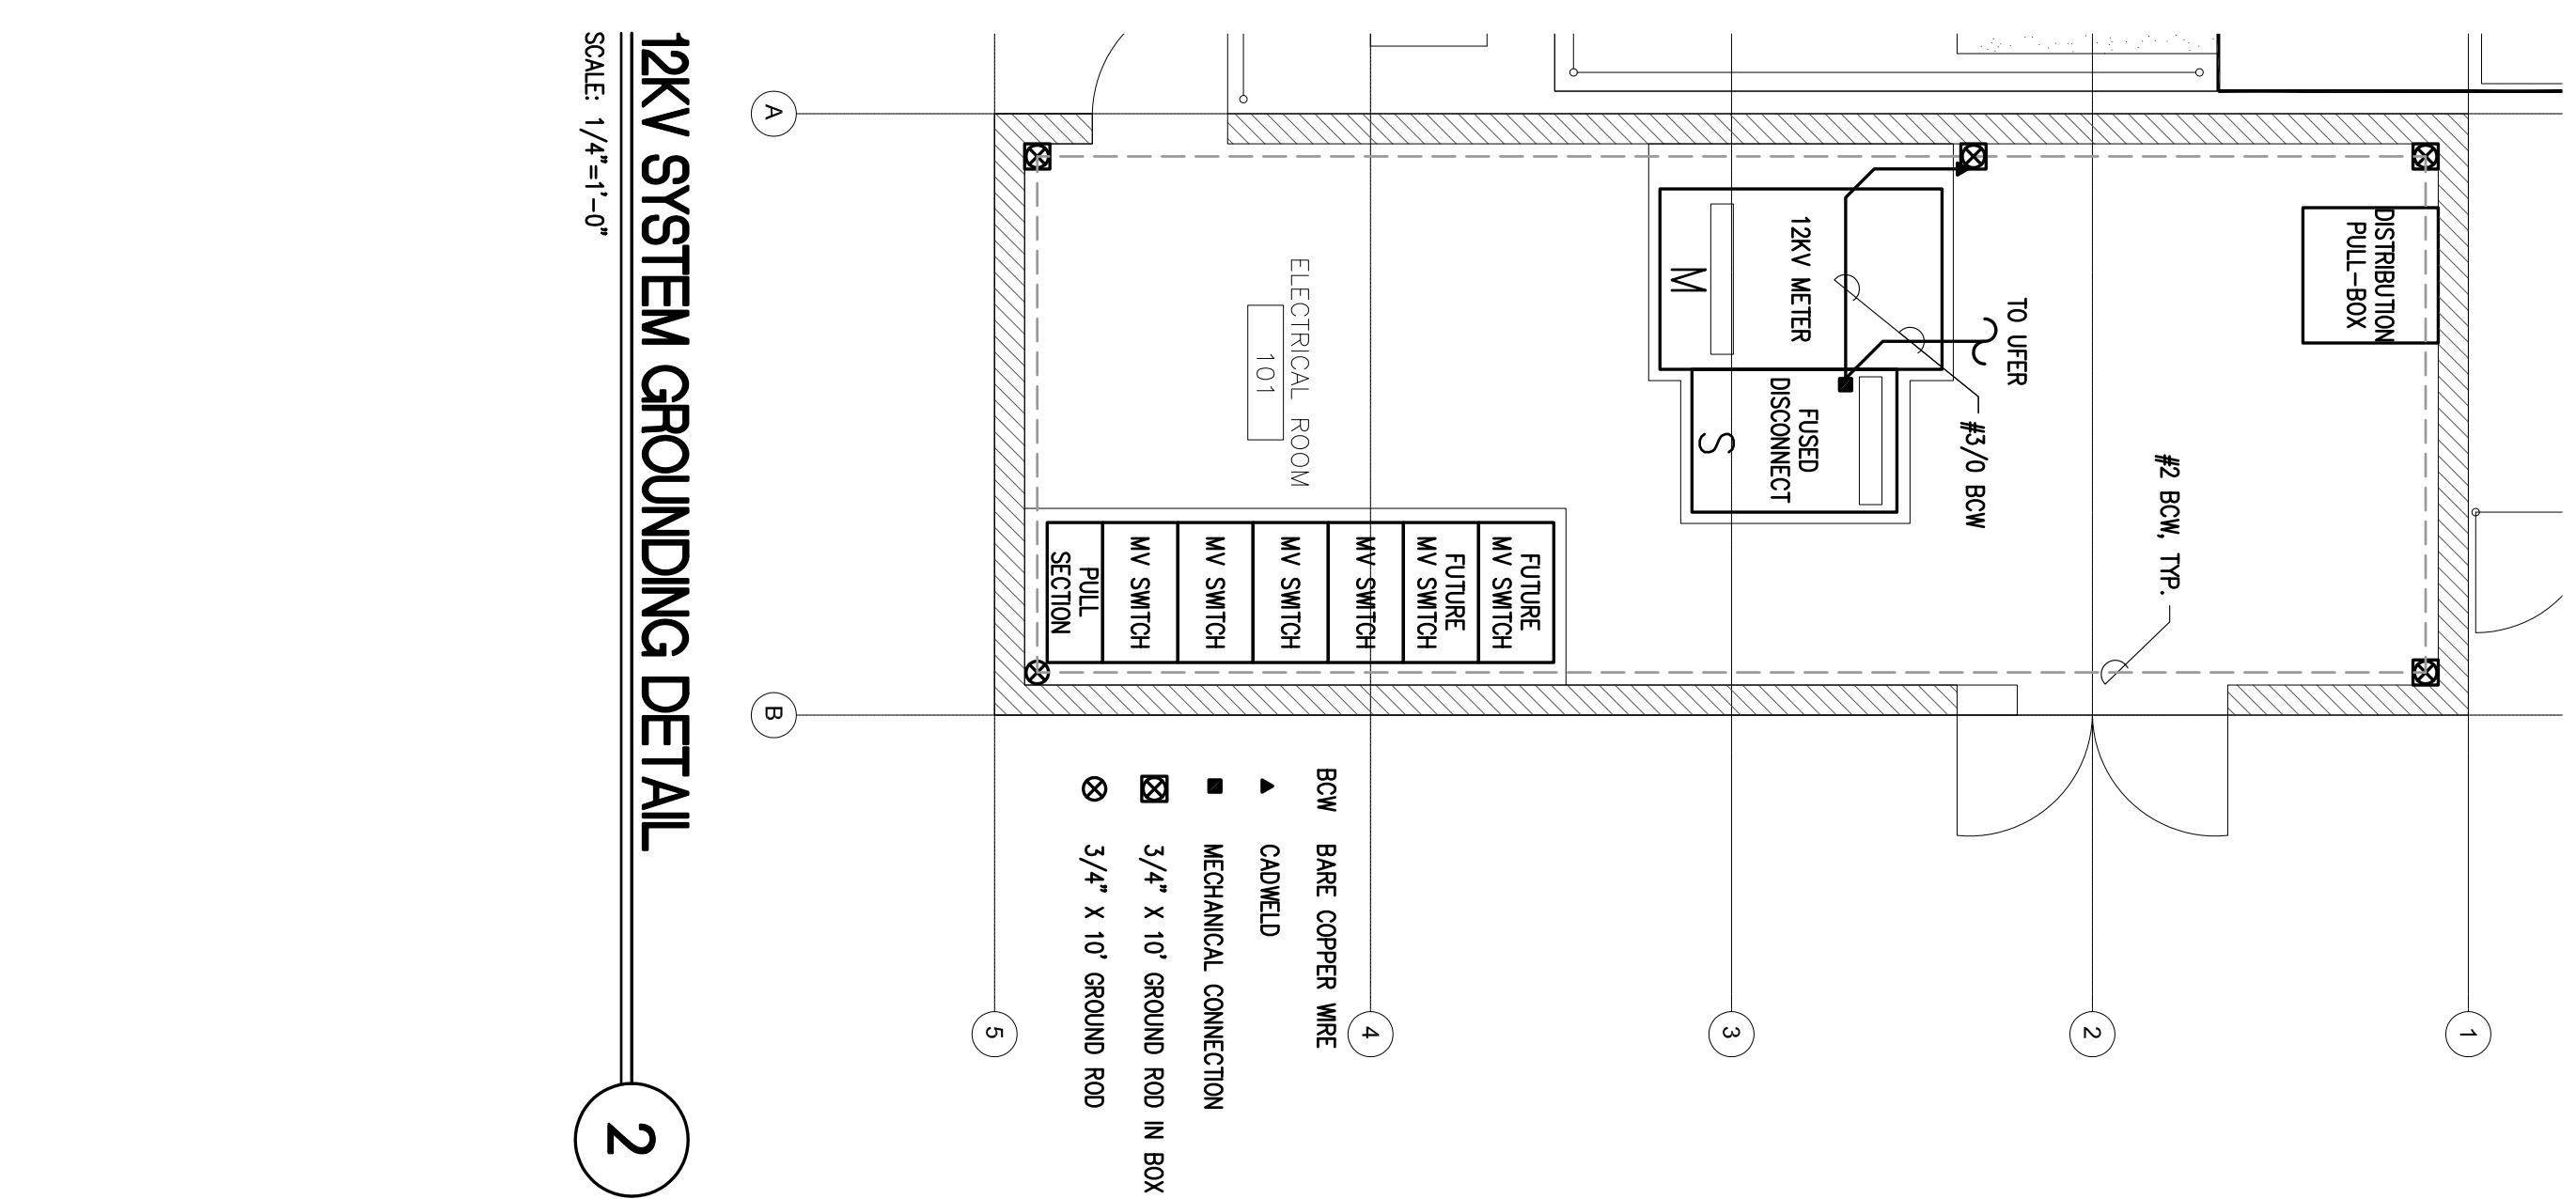

12KV SYSTEM GROUNDING DETAIL
 SCALE: 1/4"=1'-0"
2

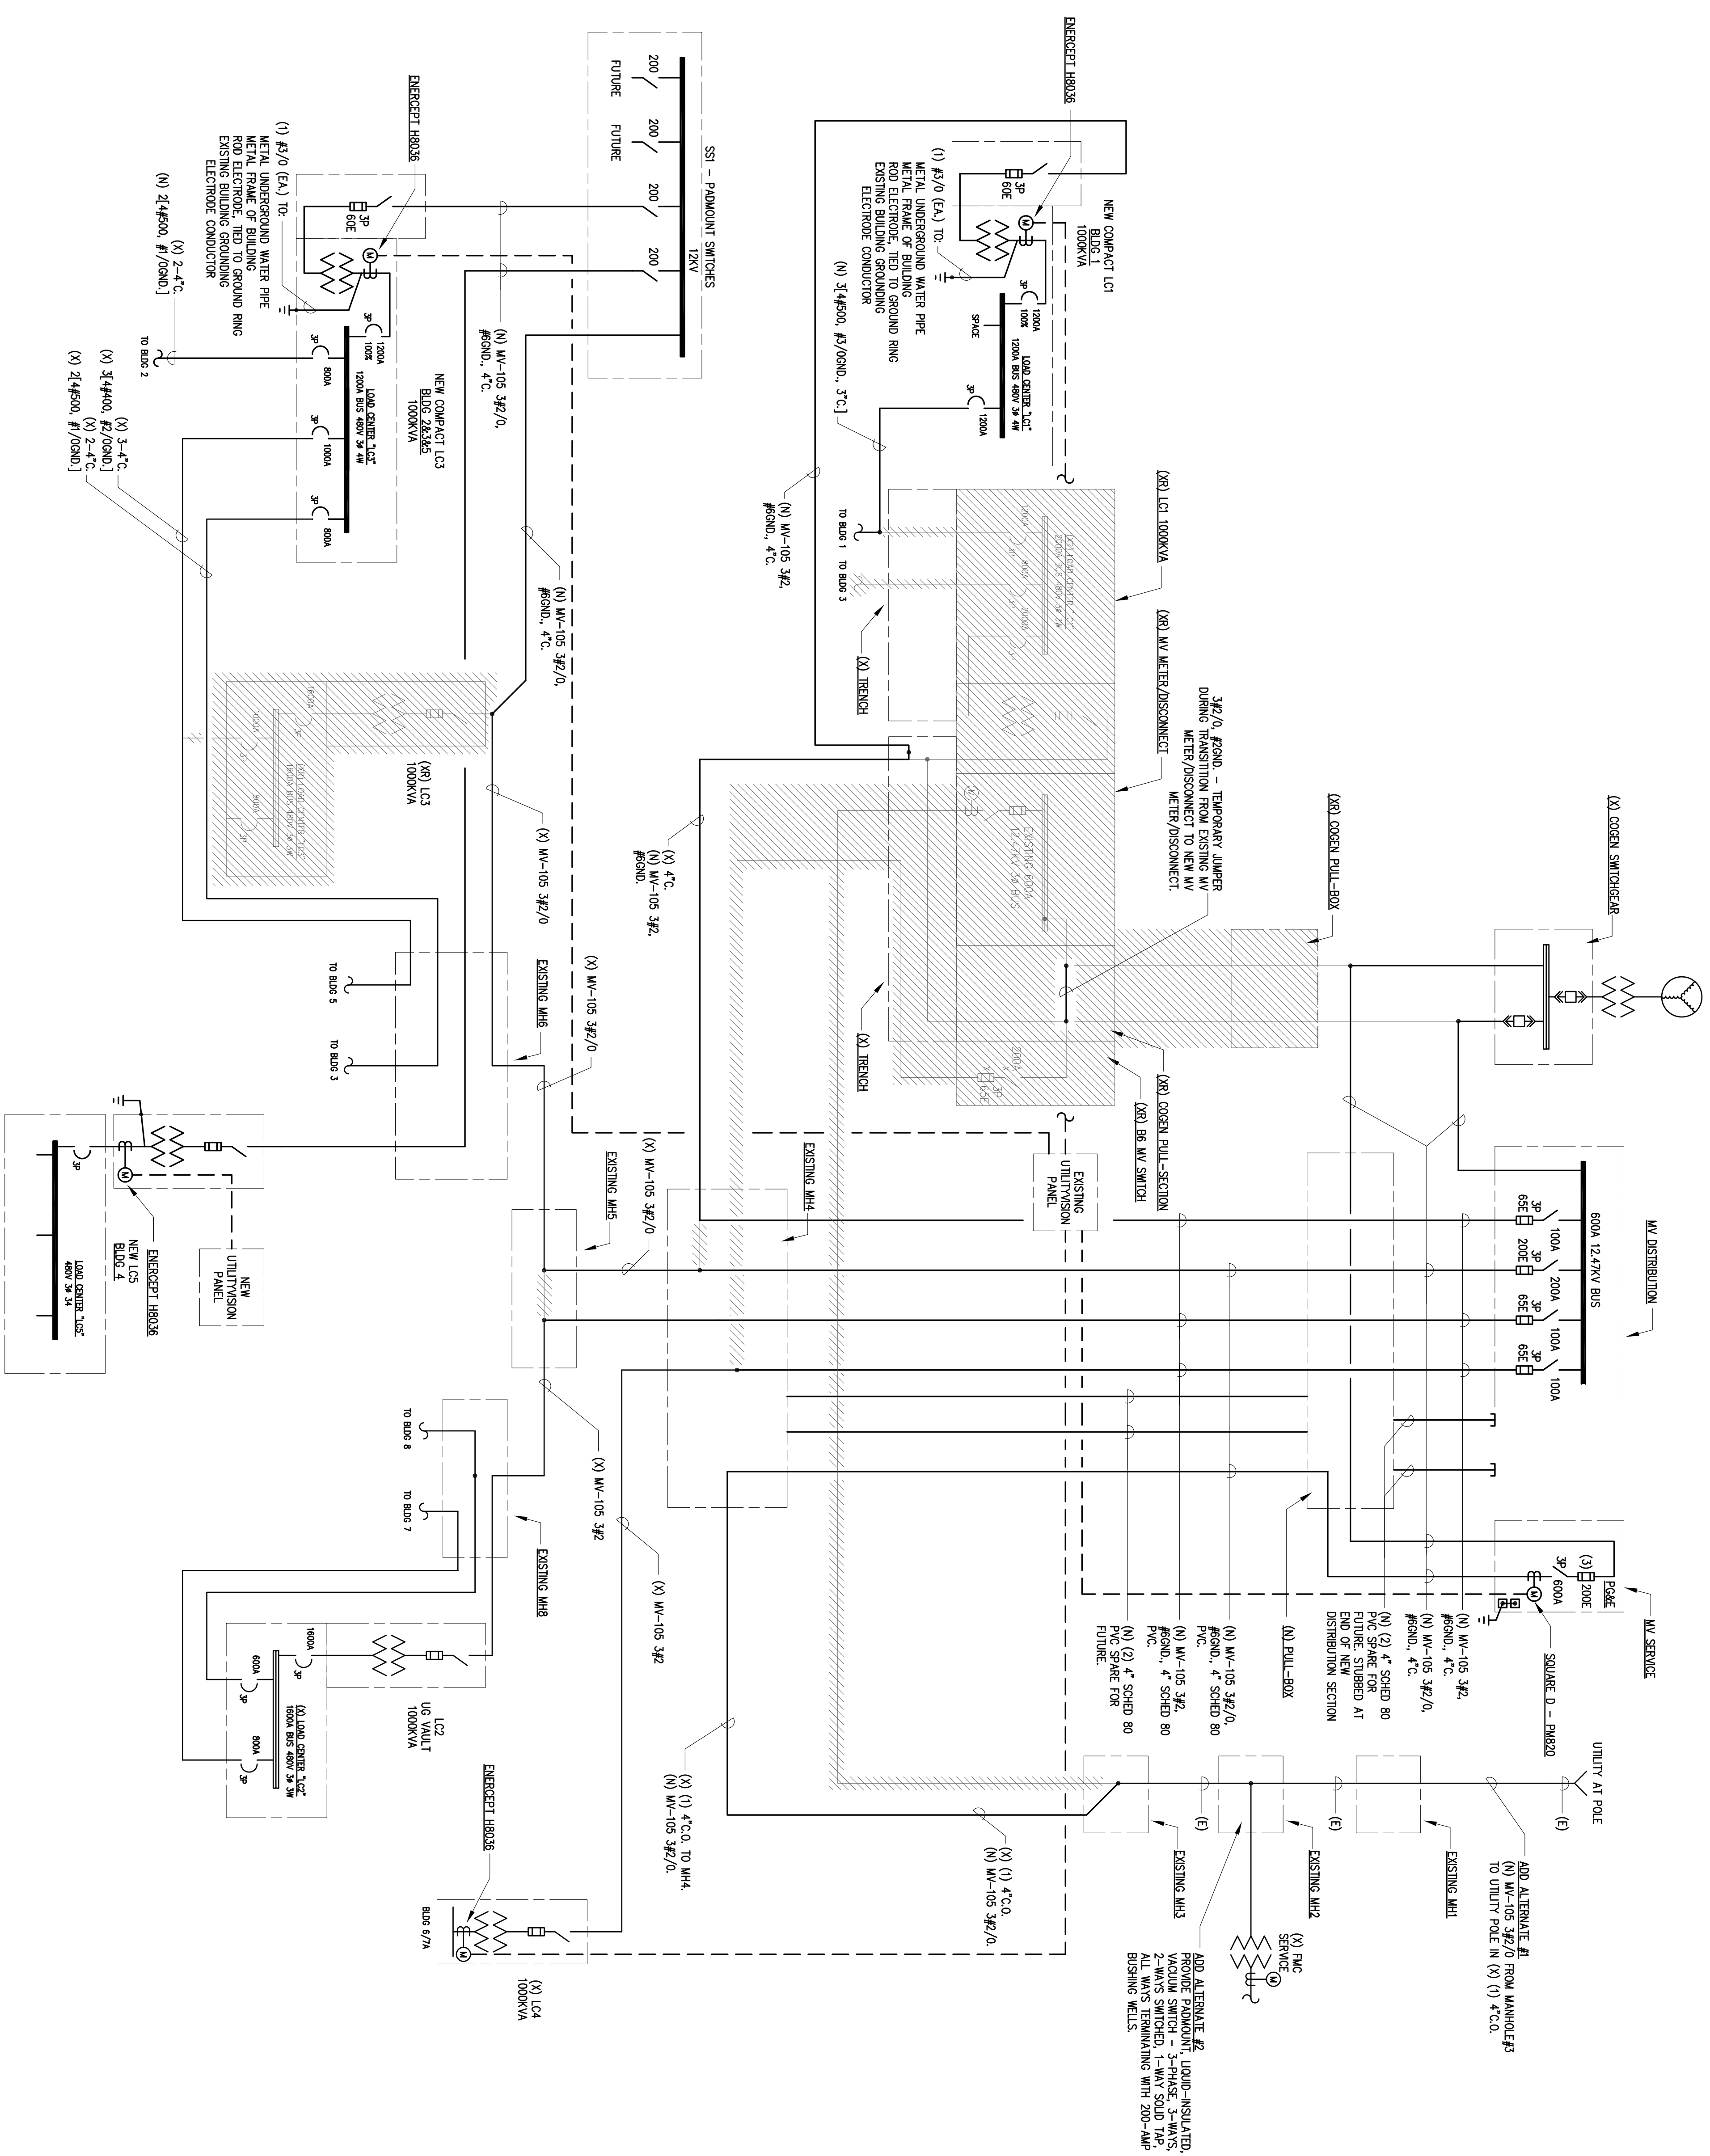

PARTIAL SINGLE LINE DIAGRAM
 SCALE: NONE
1