


NO.	DESCRIPTION	DATE
01	ISSUE FOR PERMITS	04/20/08
02	100% SCHEMATIC DESIGN	08/13/08
03	50% DESIGN DEVELOPMENT	09/17/08
04	SCHEMATIC DESIGN	07/28/08
05	CONSTRUCTION DEVELOPMENT	07/28/08
06	DATA REVIEW #1	10/10/08
07	DATA REVIEW #2	11/11/08
08	DATA REVIEW #3	11/11/08
09	DATA REVIEW #4	11/11/08
10	DATA REVIEW #5	12/22/08
11	DATA REVIEW #6	02/03/09
12	DATA REVIEW #7	04/20/09
13	DATA REVIEW #8	05/12/09
14	DATA REVIEW #9	06/10/09
15	DATA REVIEW #10	08/12/09
16	DATA REVIEW #11	09/15/09
17	DATA REVIEW #12	12/27/10

NO. DIVISION OF THE STATE ARCHITECT  
 APRIL # 01-110117  
 FILE # 41-C1  
 AC: \_\_\_\_\_ DATE: \_\_\_\_\_  
 SSS: \_\_\_\_\_ DATE: \_\_\_\_\_  
 IDENTIFICATION STAMP  
**Increment 3**

**SKYLINE COLLEGE**  
 SAN MATEO COUNTY  
 DISTRICT


**CIP2 DESIGN-BUILD PROJECT BUILDING 4 INCREMENT 3**

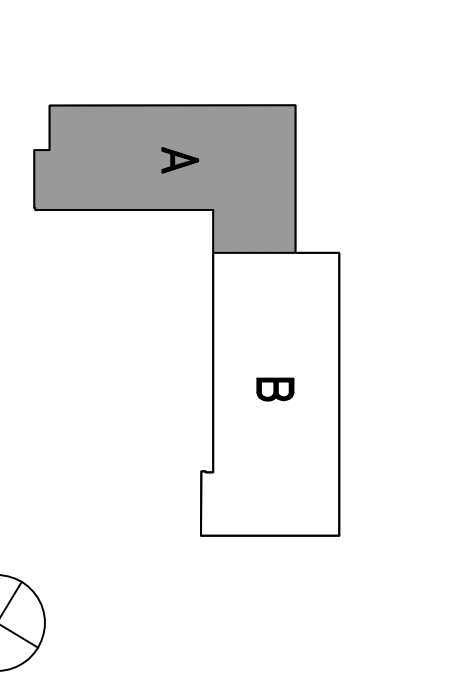

PROJECT NO: SFT057010 DRAWN BY: JB  
 DATE: 04/28/08 CHECKED BY: ALS  
 SCALE: 3/32"=1'-0"

**LEVEL 1  
 POWER AND SIGNAL  
 PLAN  
 SECTOR A**

SHEET NO: **E-301A**

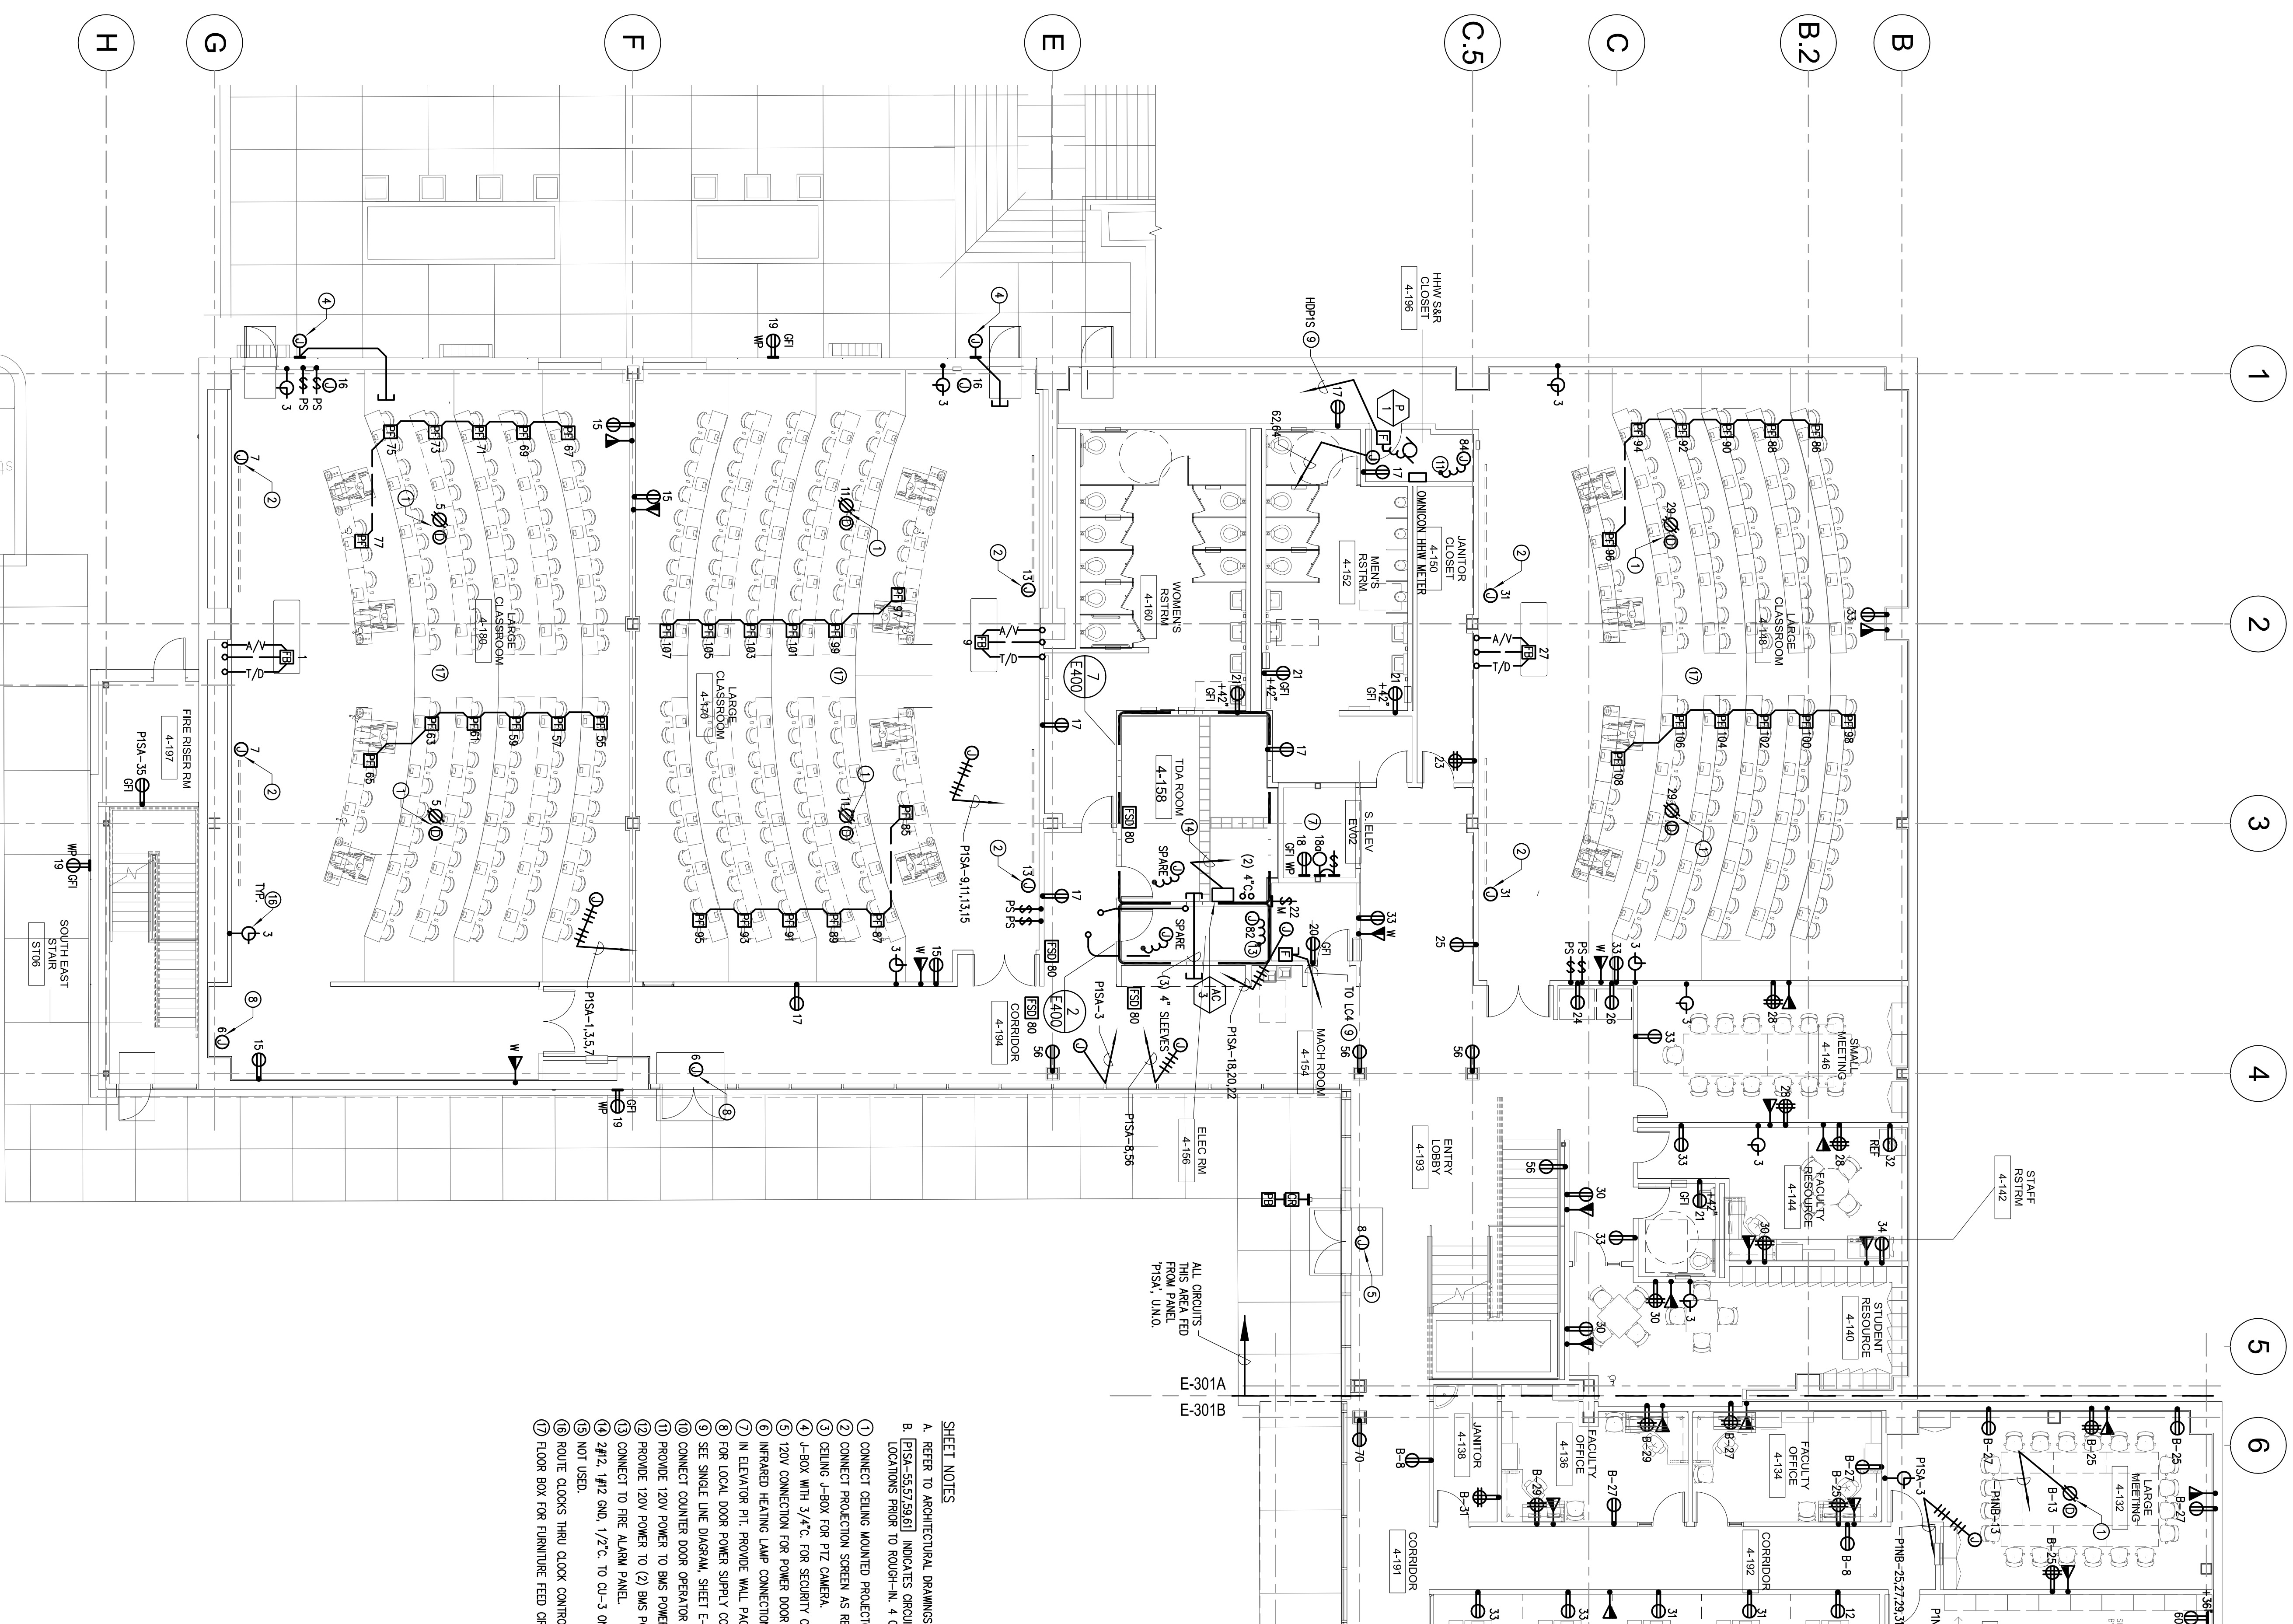

- SHEET NOTES**
- A. REFER TO ARCHITECTURAL DRAWINGS FOR EXACT DIMENSIONS AND MOUNTING HEIGHTS.
  - B. [P15A-55/2/3/3/3] INDICATES CIRCUITS FOR ELECTED FURNITURE DESK. COORDINATE FURNITURE FEED LOCATIONS FROM TO ROOM-NUM, 4 CIRCUITS, 5-WIRE SYSTEM, 4/20A, 120V, 1P/2W, 1/2"Ø, 3/4"Ø.
  - ① CONNECT CEILING MOUNTED PROJECTOR.
  - ② CONNECT PROJECTOR SCREEN AS REQUIRED.
  - ③ CEILING J-BOX FOR PTZ CAMERA.
  - ④ J-BOX WITH 3/4"Ø FOR SECURITY CAMERA. COORDINATE REQUIREMENTS WITH SECURITY DRAWINGS.
  - ⑤ 120V CONNECTION FOR POWER DOOR ASSISTANCE. COORDINATE WITH SECURITY.
  - ⑥ INFRARED HEATING LAMP CONNECTION (NO PERMITS).
  - ⑦ IN ELEVATOR PIT. PROVIDE WALL PACK LIGHT. HUBBELL CIRCUIT BOX-04, (1)-28WPT, 120V OR EQUAL.
  - ⑧ FOR LOCAL DOOR POWER SUPPLY CONNECTION. REFER TO SECURITY DRAWINGS.
  - ⑨ SEE SINGLE LINE DIAGRAM, SHEET E-100.
  - ⑩ CONNECT COUNTER DOOR OPERATOR AS REQUIRED.
  - ⑪ PROVIDE 120V POWER TO BUS POWER SUPPLY IN THIS ROOM. COORDINATE LOCATION WITH CONTRACTOR.
  - ⑫ PROVIDE 120V POWER TO (2) BUS POWER SUPPLY IN THIS ROOM. COORDINATE LOCATION WITH CONTRACTOR.
  - ⑬ CONNECT TO FIRE ALARM PANEL.
  - ⑭ 2#12, 1/2"Ø, 1/2"Ø, TO CH-3 ON ROOF.
  - ⑮ NOT USED.
  - ⑯ ROUTE CLOCKS THRU CLOCK CONTROL SYSTEM, LOCATED IN ELECTRICAL ROOM 4-156.
  - ⑰ FLOOR BOX FOR FURNITURE FEED CIRCUITS TO PANEL "P15A" IN THIS LOCATION.

**LEVEL 1 - POWER AND SIGNAL PLAN - SECTOR A**  
 SCALE: 1/8"=1'-0"

All drawings and other material prepared by or for the undersigned and not intended for use by any other person without the written consent of the undersigned.

This drawing is not to be used for any other project without the written consent of the undersigned.