


SHEET NOTES:

1. ALL CHILLED WATER PIPING 3" AND SMALLER AND HEATING HOT WATER PIPING SHALL BE TYPE L COPPER
2. ALL CHILLED WATER PIPING SHALL BE TYPE L COPPER SCHEDULE 40S STEEL WITH VICTALIC FITTINGS
3. ALL CHILLED AND HEATING HOT WATER PIPING SHALL BE INSULATED PER THE REQUIREMENTS OF TITLE 24. PROVIDE PROTECTIVE COATING FOR PIPE INSULATION IN EQUIPMENT ROOMS.
4. ALL PIPING SHALL BE SUPPORTED AND BRACED PER THE REQUIREMENTS OF DSA. REFER TO 1.8 A.T. DRAWINGS FOR DETAILED REQUIREMENTS.
5. REFER TO PIPING DETAILS M4.01 FOR MECHANICAL EQUIPMENT CONNECTION.



McCarthy Building Companies, Inc.
 343 Sanson Street, 14th Floor
 San Francisco, California 94104
 P 415 397-5939

IDENTIFICATION STAMP
 DIVISION OF THE STATE
 APPL. APPROVED
 ACC. FLS. SS
 DATE _____

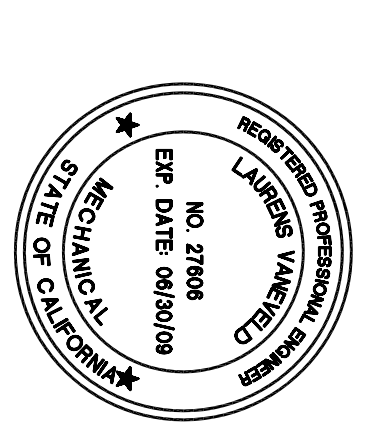


WESTERN ALLIED MECHANICAL INC.
 MECHANICAL CONTRACTORS
 1840 CENTRAL EXPRESS
 REDWOOD CITY, CA 94063
 (650) 372-2426 FAX
 (650) 372-2426 FAX
 EIR: (WWW.WA-MECHANICAL.COM)

The design is the exclusive property of Western Allied Mechanical, Inc. The contractor shall retain the original drawings and shall remain the property of Western Allied Mechanical, Inc. No part of this design shall be reproduced, stored in a retrieval system, or transmitted in any form or by any means, electronic, mechanical, photocopying, recording, or by any information storage and retrieval system, without the prior written consent of Western Allied Mechanical, Inc. The design is provided for the contractor's use only. Any reproduction of this design without the prior written consent of Western Allied Mechanical, Inc. constitutes a violation of the design agreement.

College of San Mateo Building 5N
 DSA Submittal
 San Mateo, CA
 Developed for College of San Mateo

Revision	Description	Date

Job No.	118051
Date	June 13, 2008
Drawn by	RJ
Checked by	LV
Scale	SEE DRAWING
PROJECT NORTH	
FLOOR PLAN - LEVEL 1 WEST	
M2-01P	

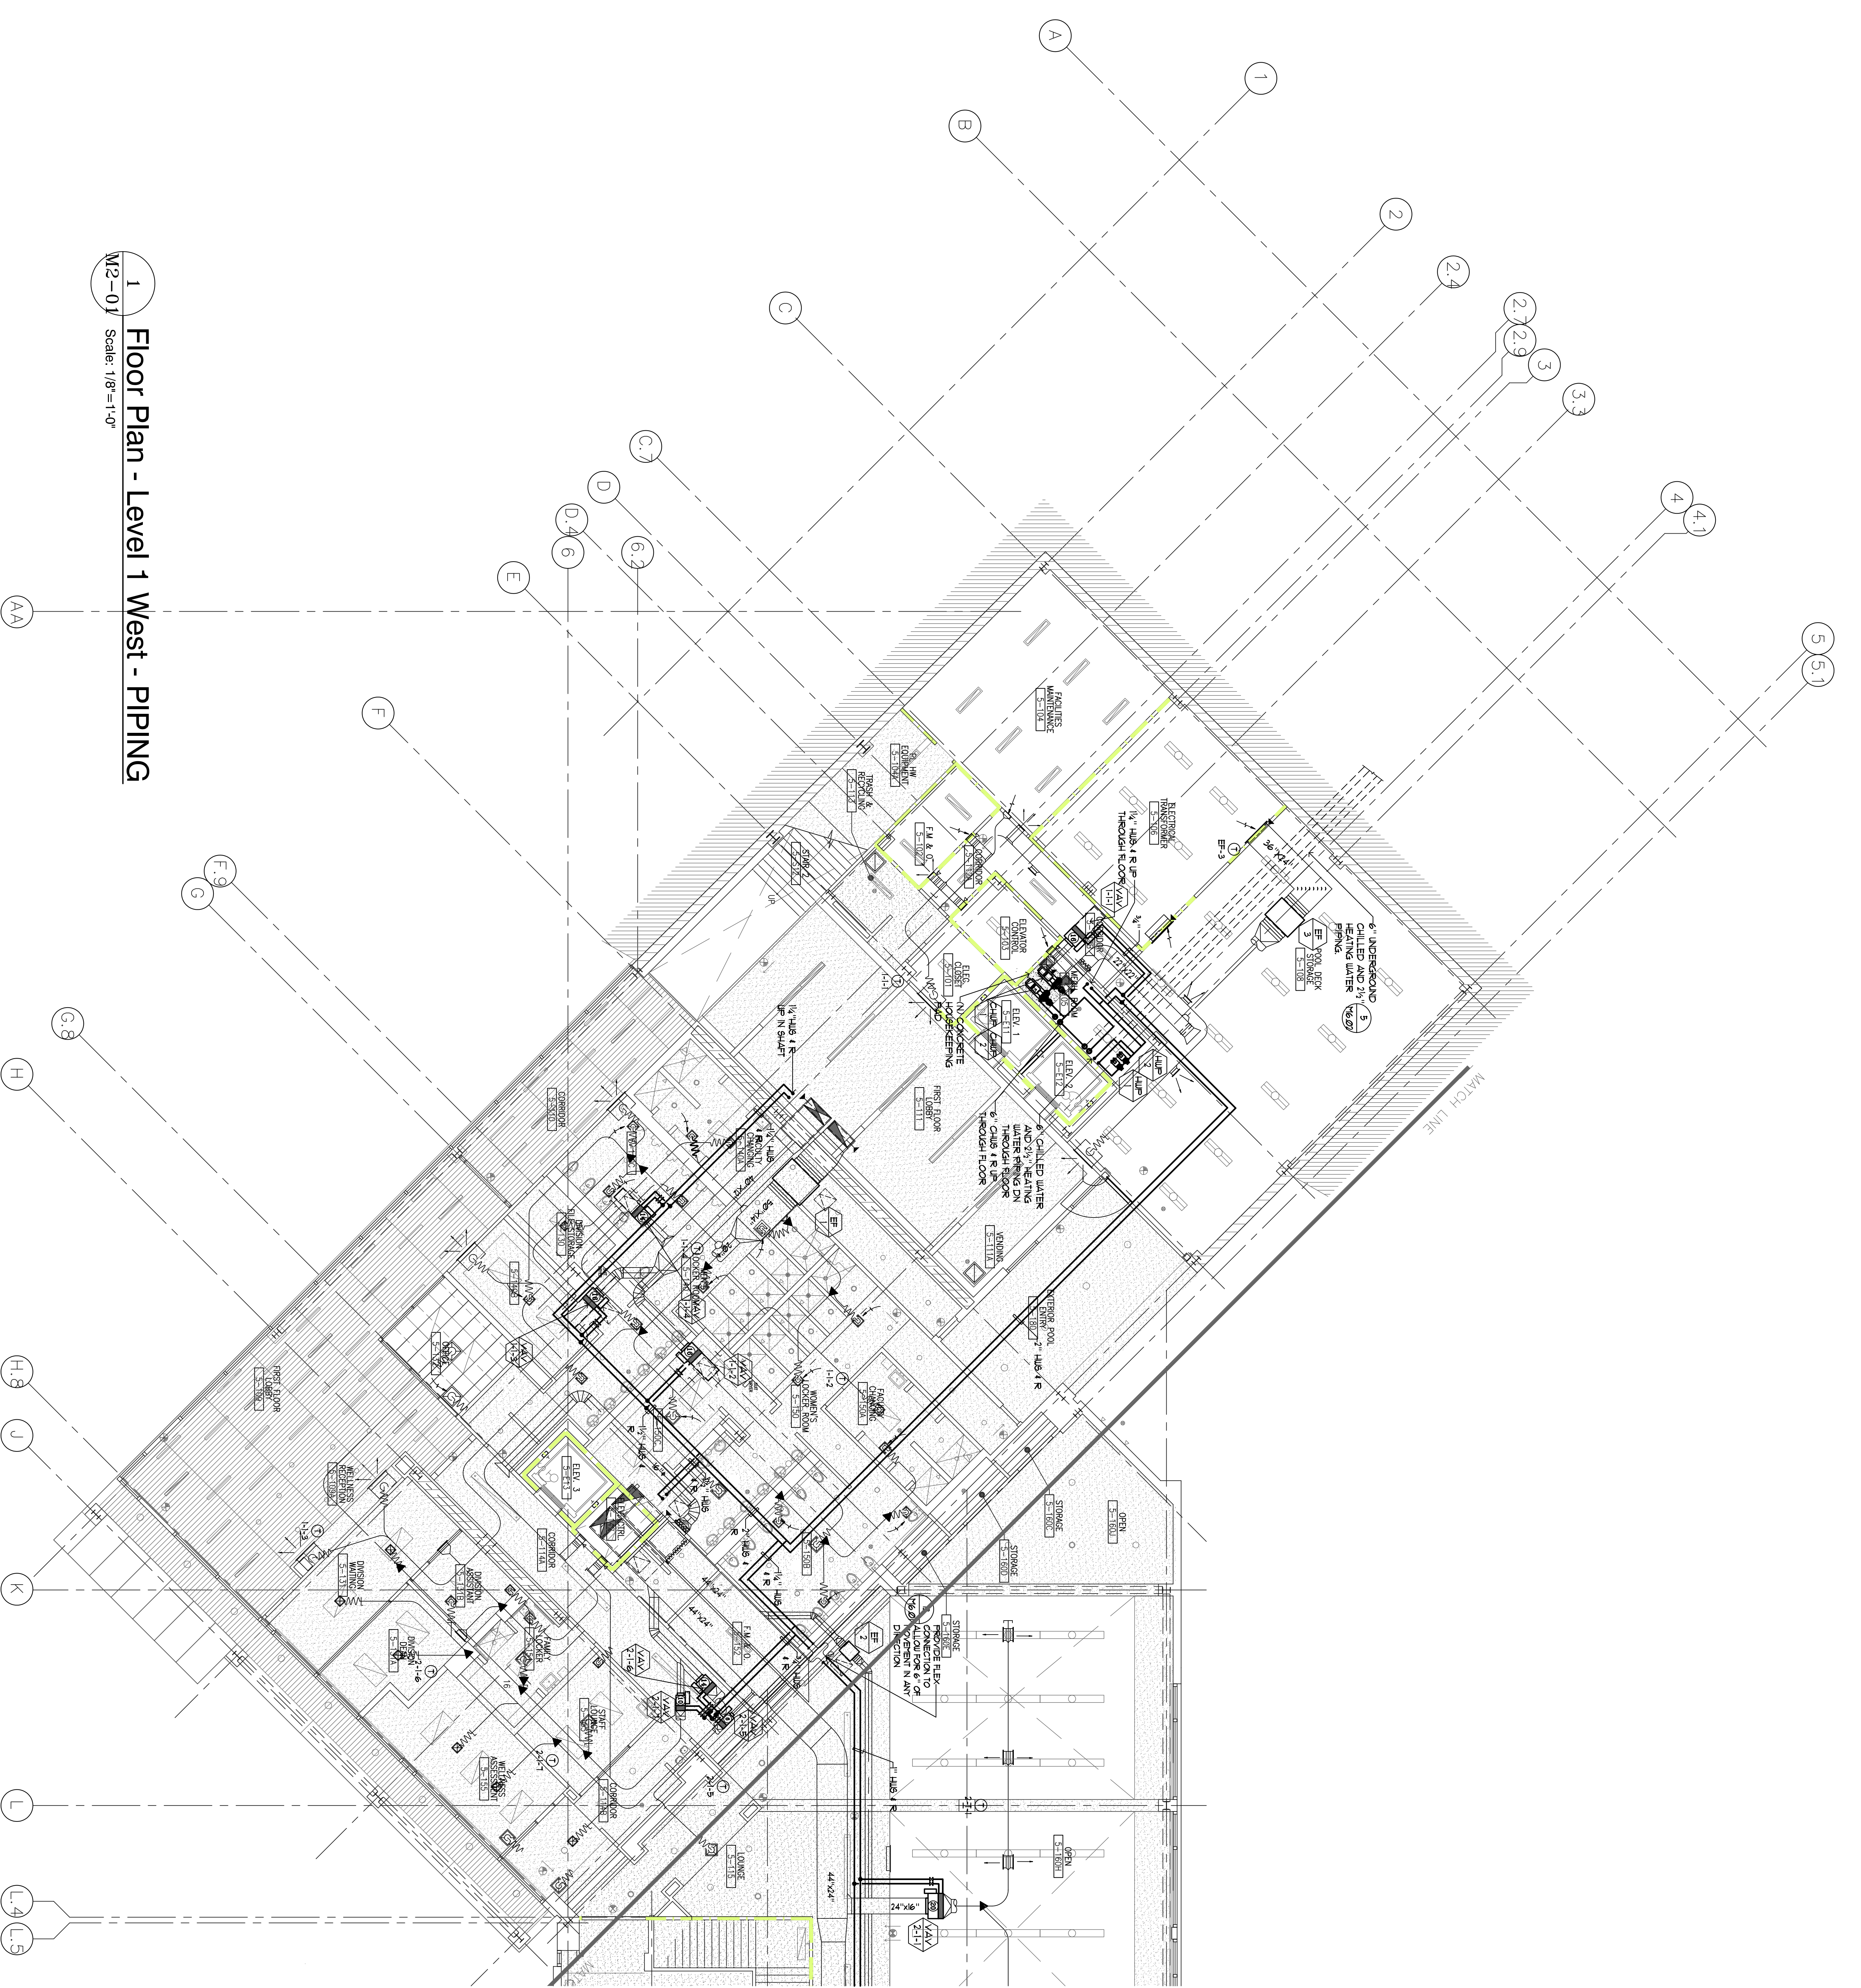

1 Floor Plan - Level 1 West - PIPING
 M2-01P Scale: 1/8"=1'-0"