




Revision	Description	Date

Revision	Description	Date



Job No. 118951
 Date: June 13, 2008
 Drawn by: RJ
 Checked by: LV
 Scale: SEE DRAWING
 MECHANICAL DETAILS
M6-02

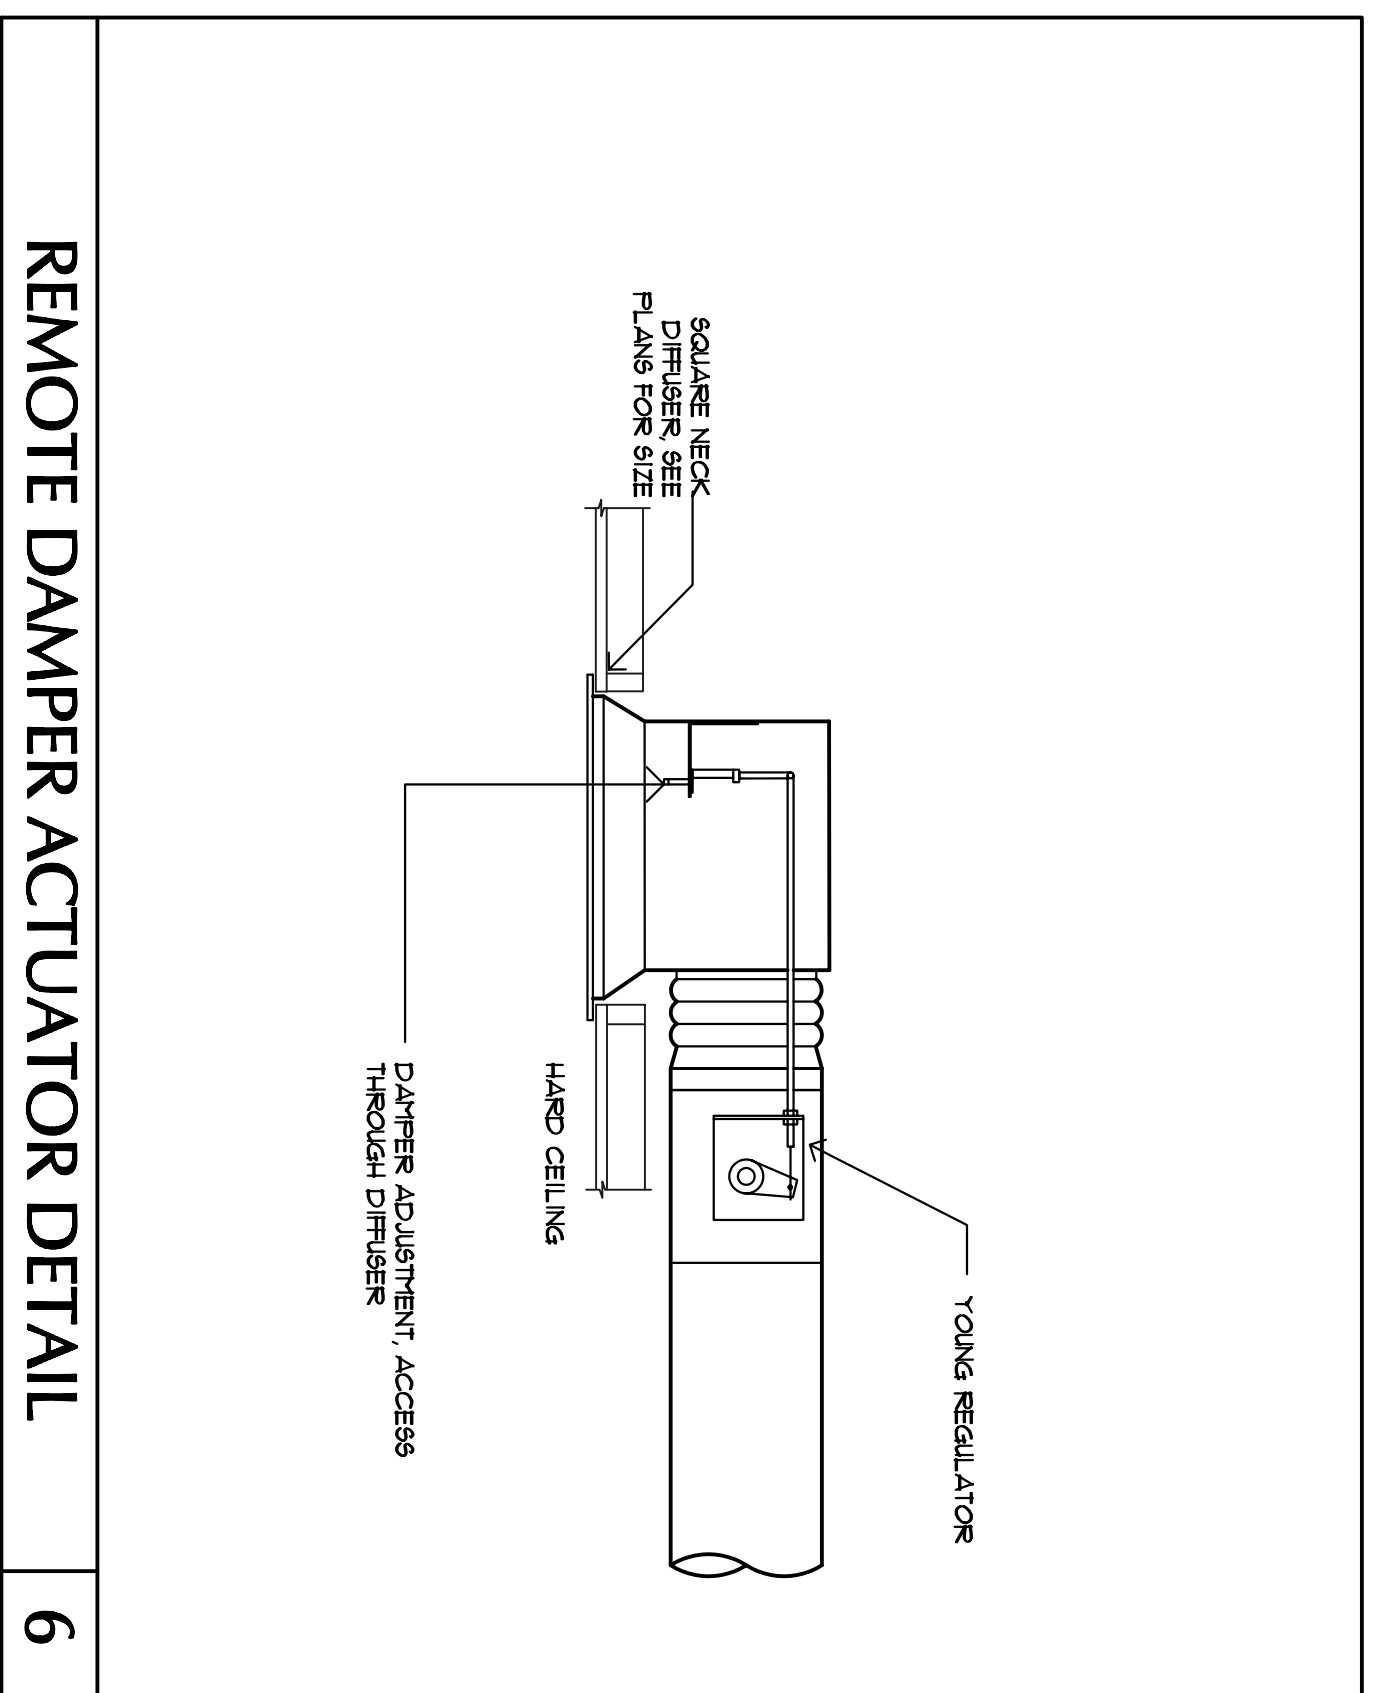



REMOTE DAMPER ACTUATOR DETAIL 6

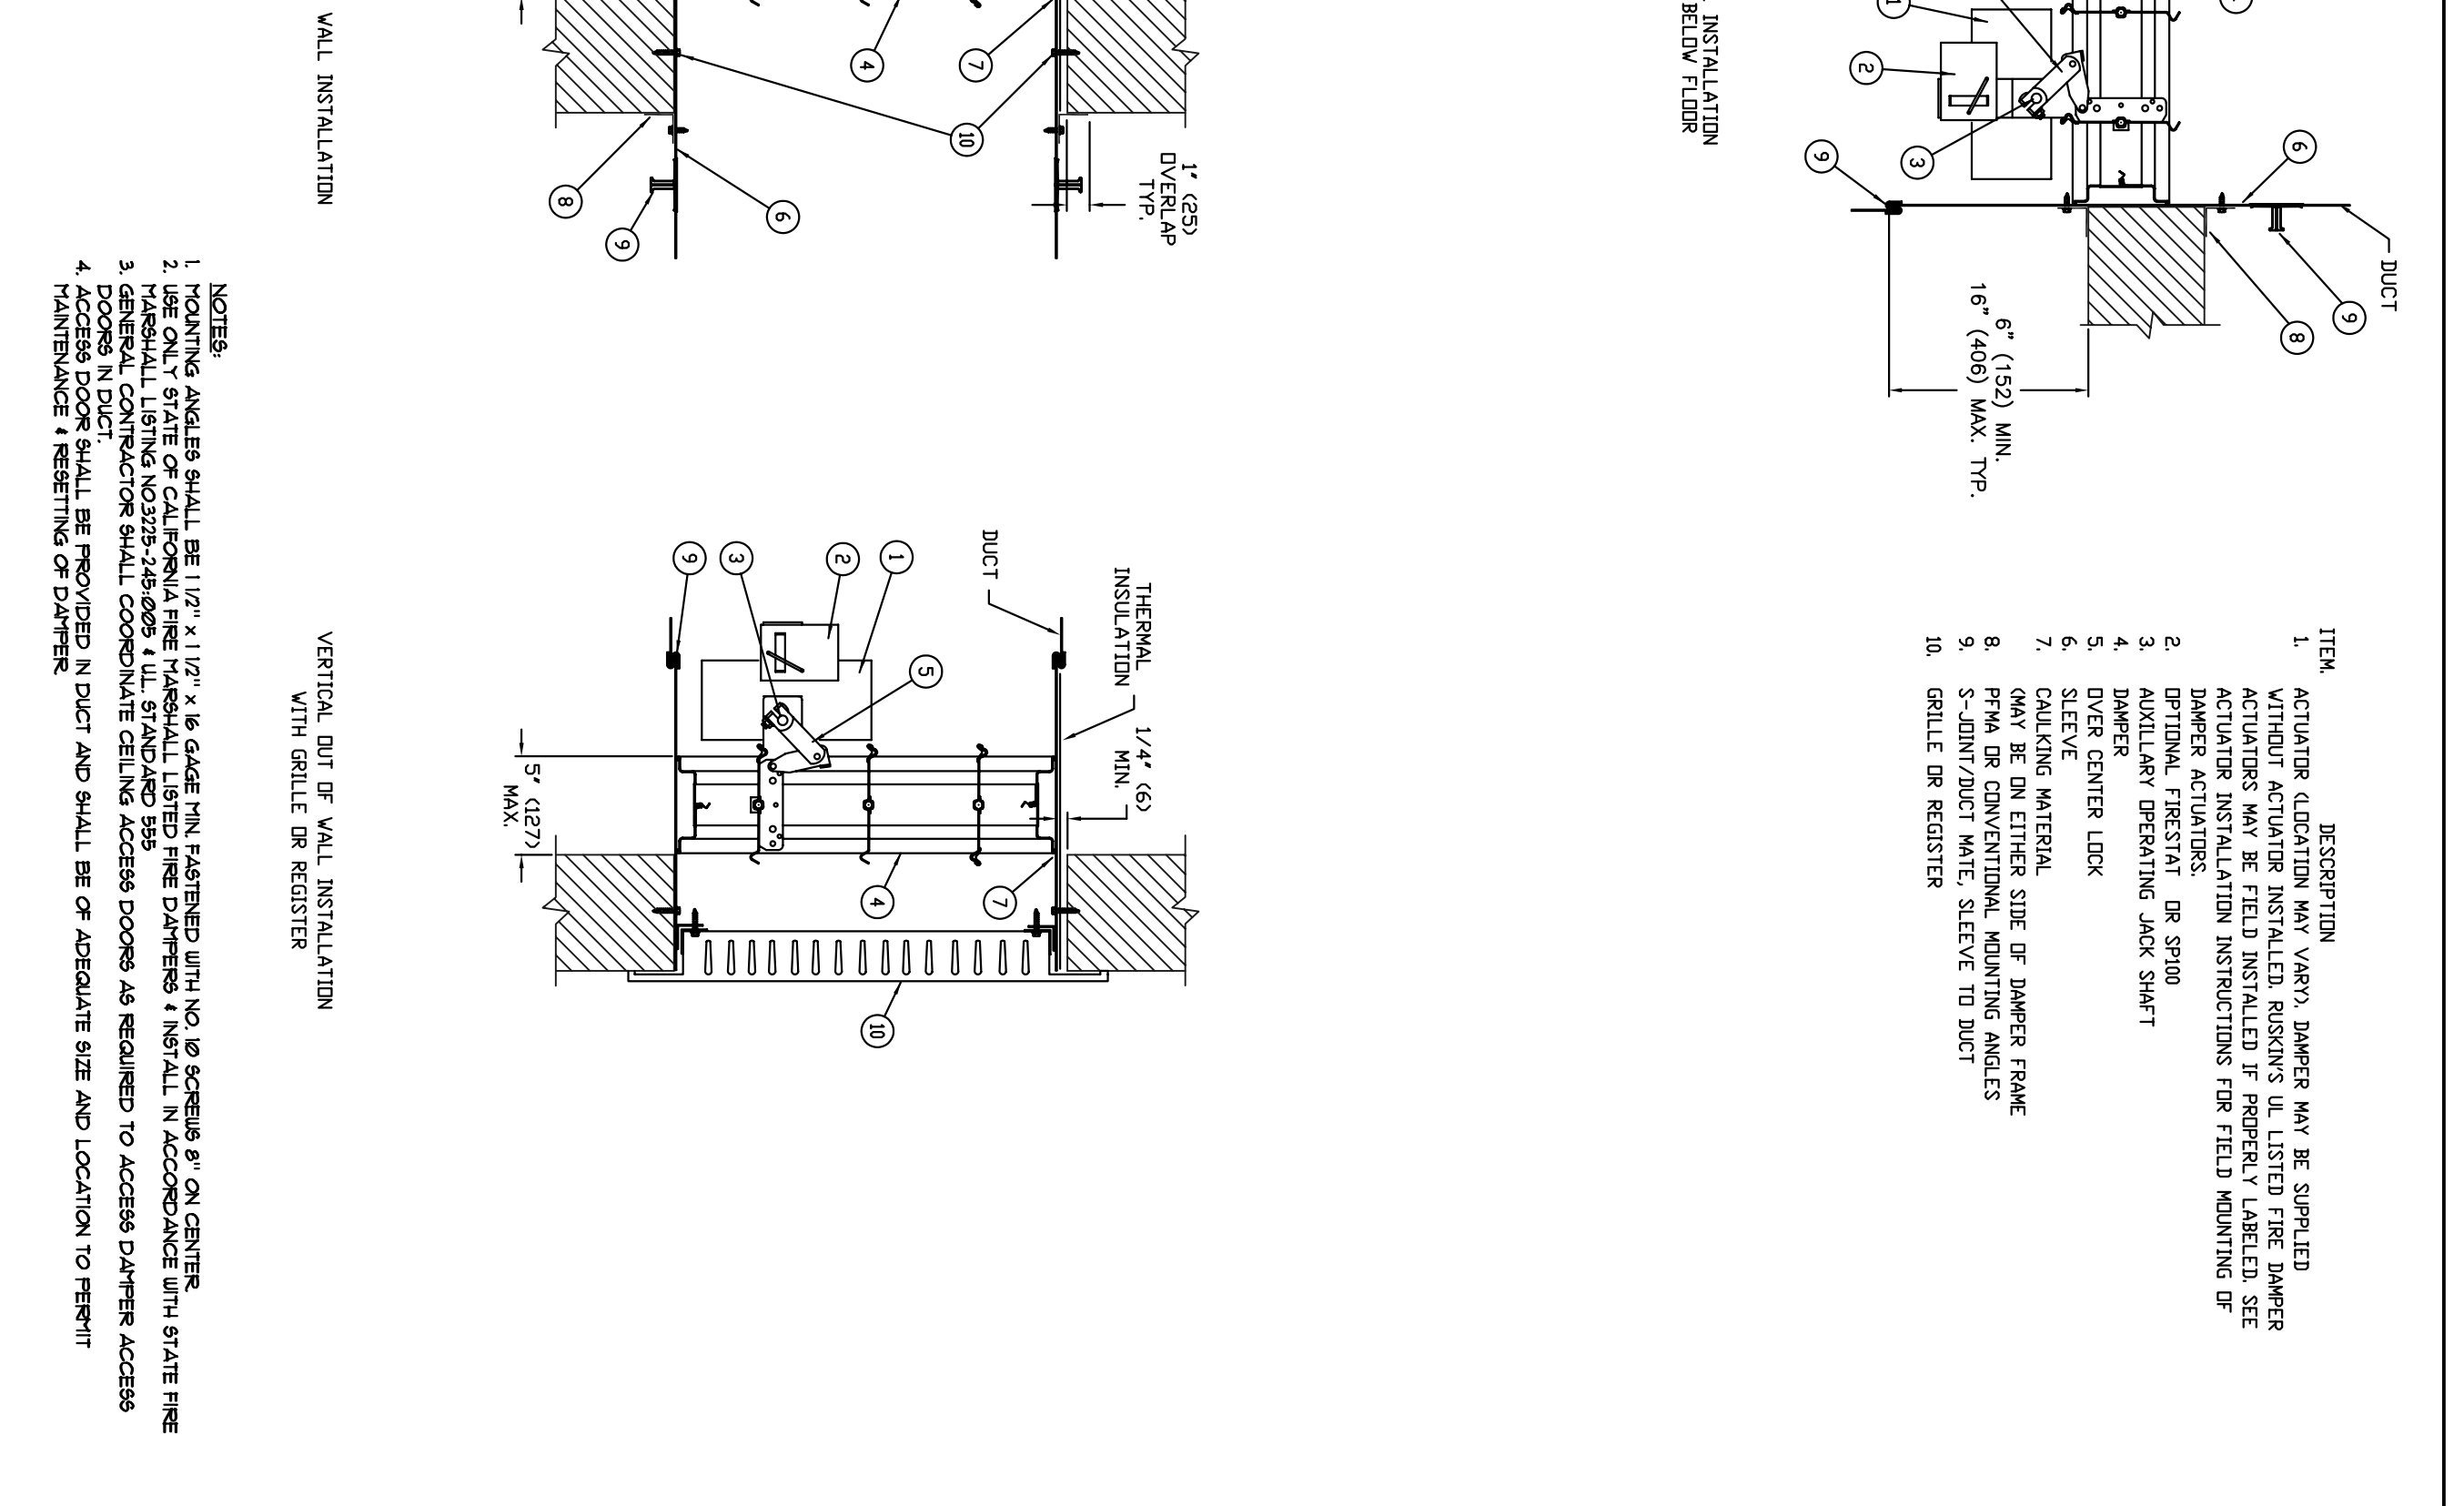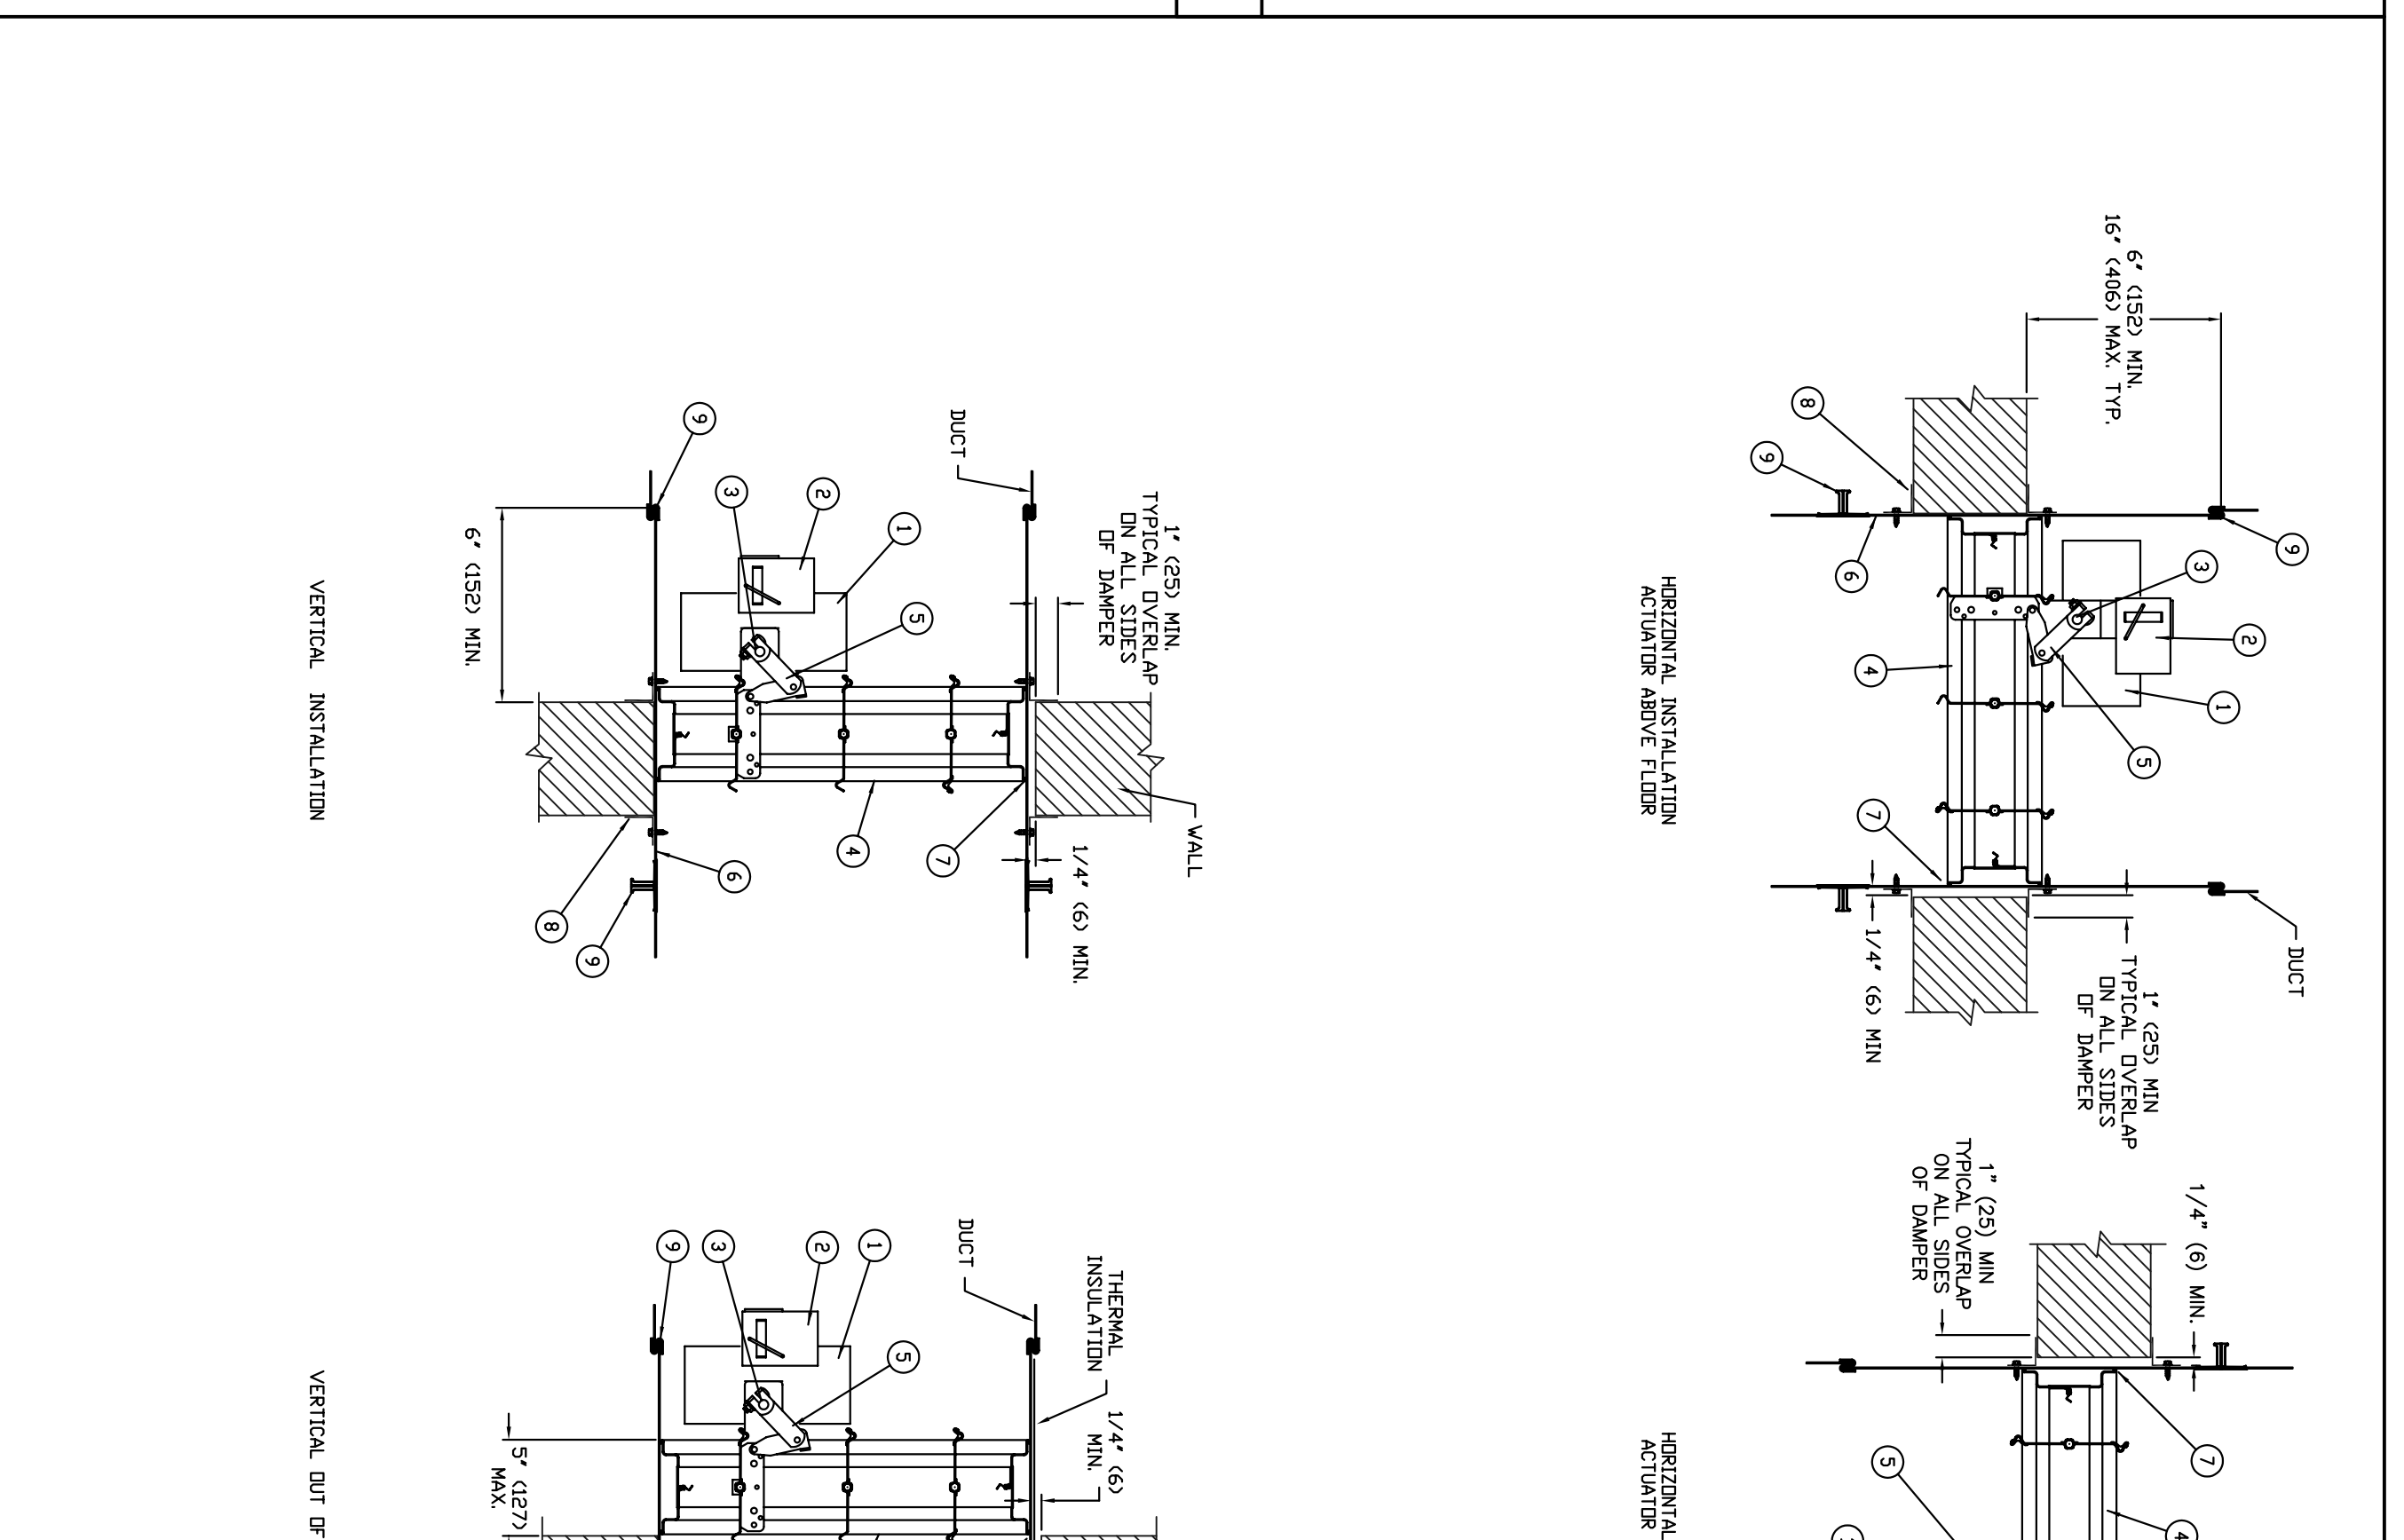

CHILLED WATER PUMP MOUNTING DETAIL 4

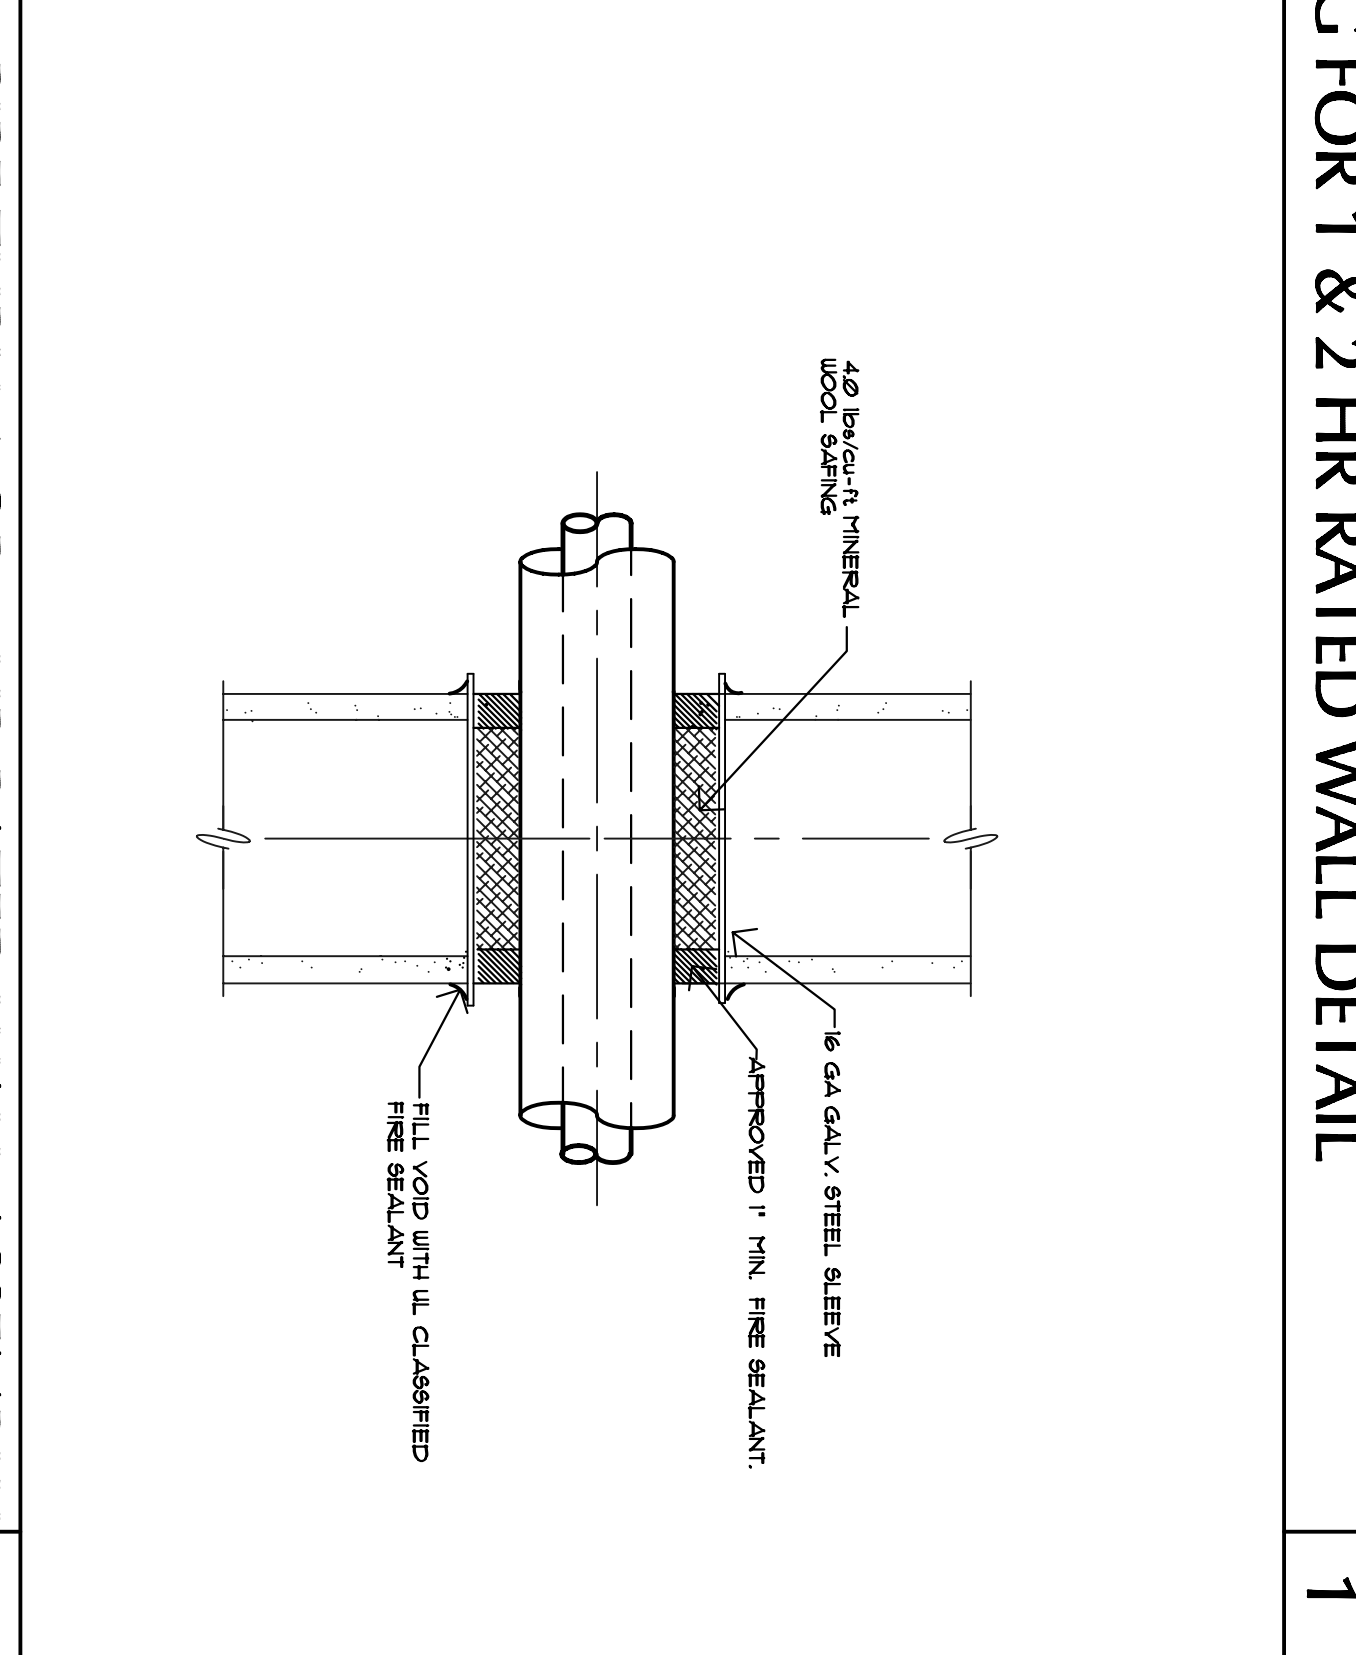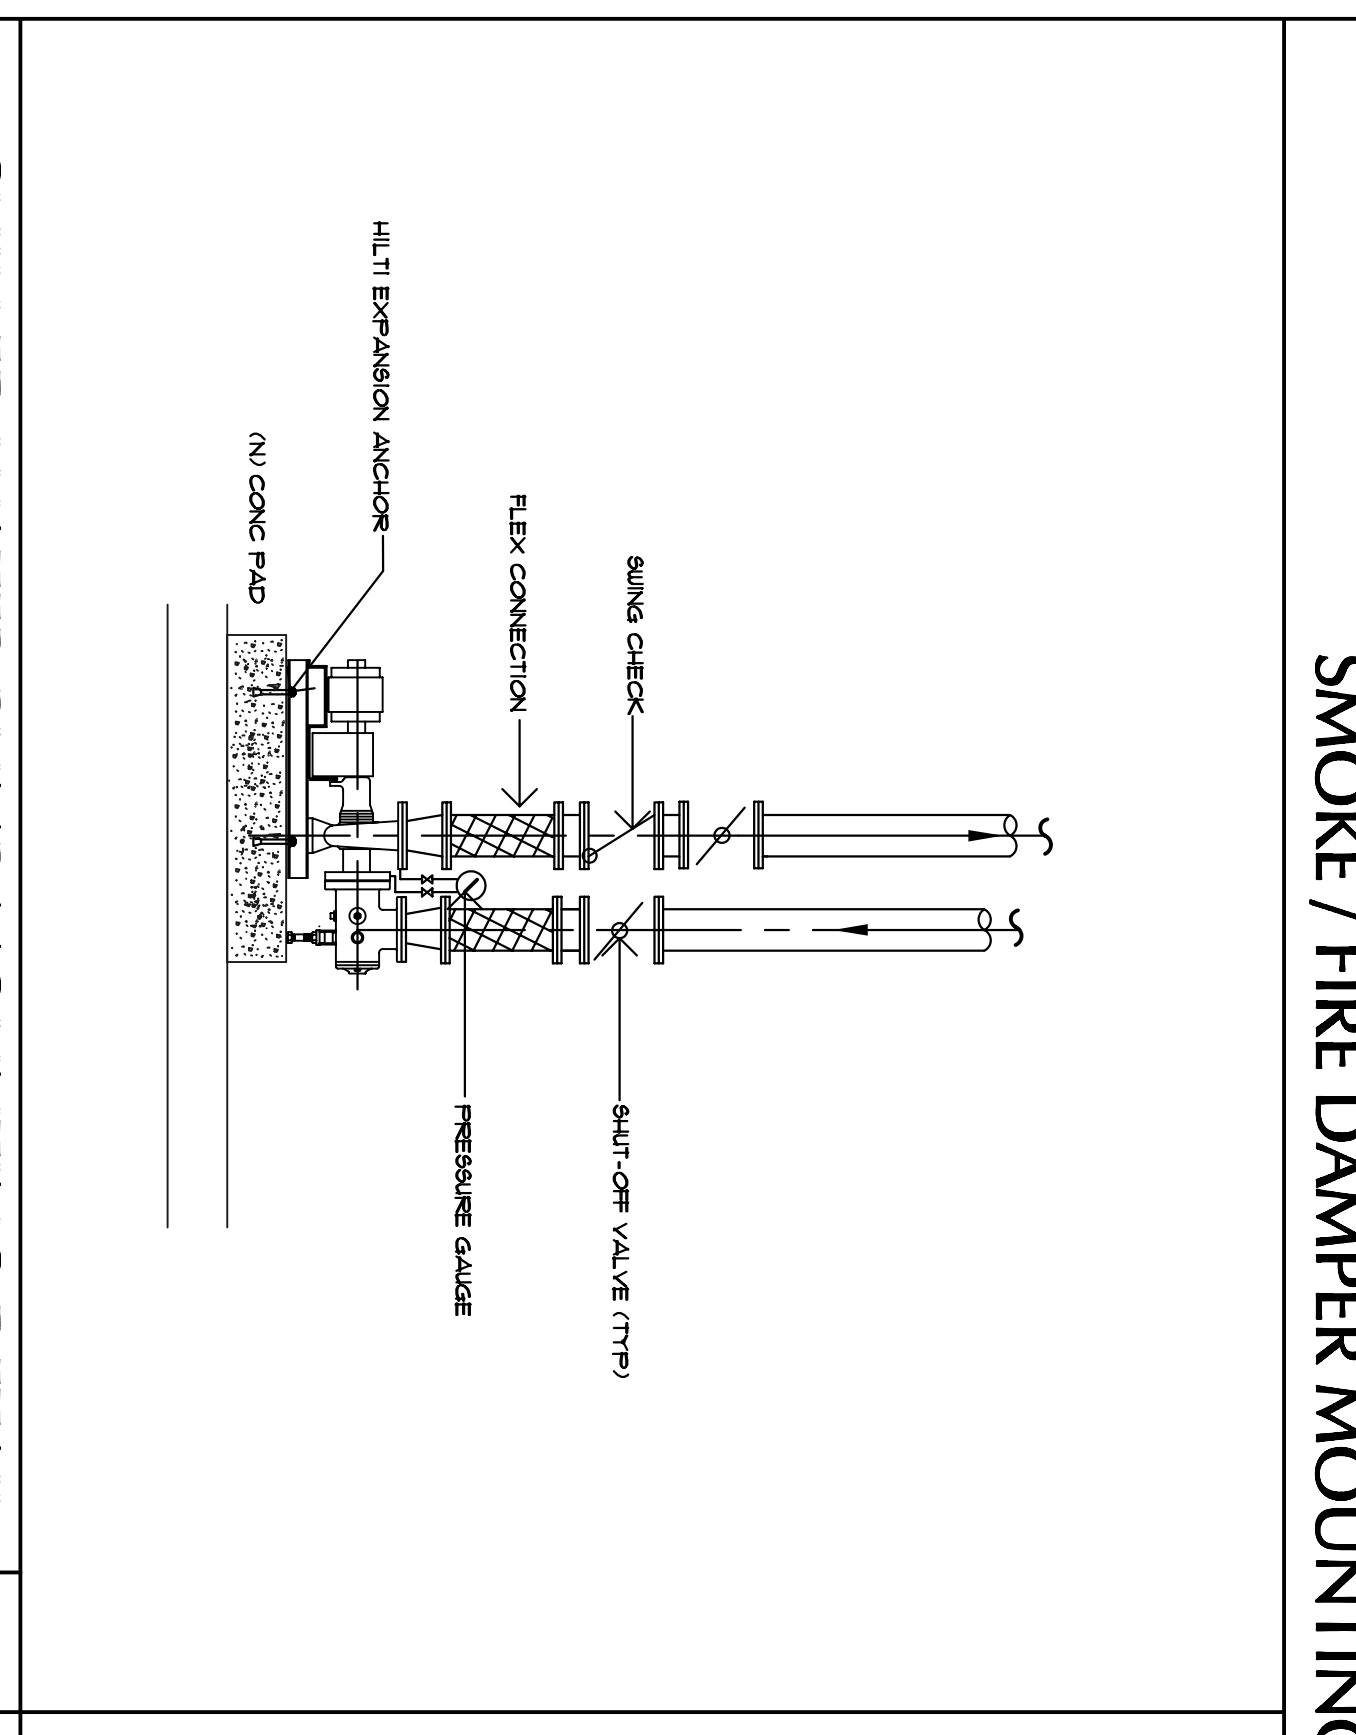

BURIED PIPE DETAIL 5

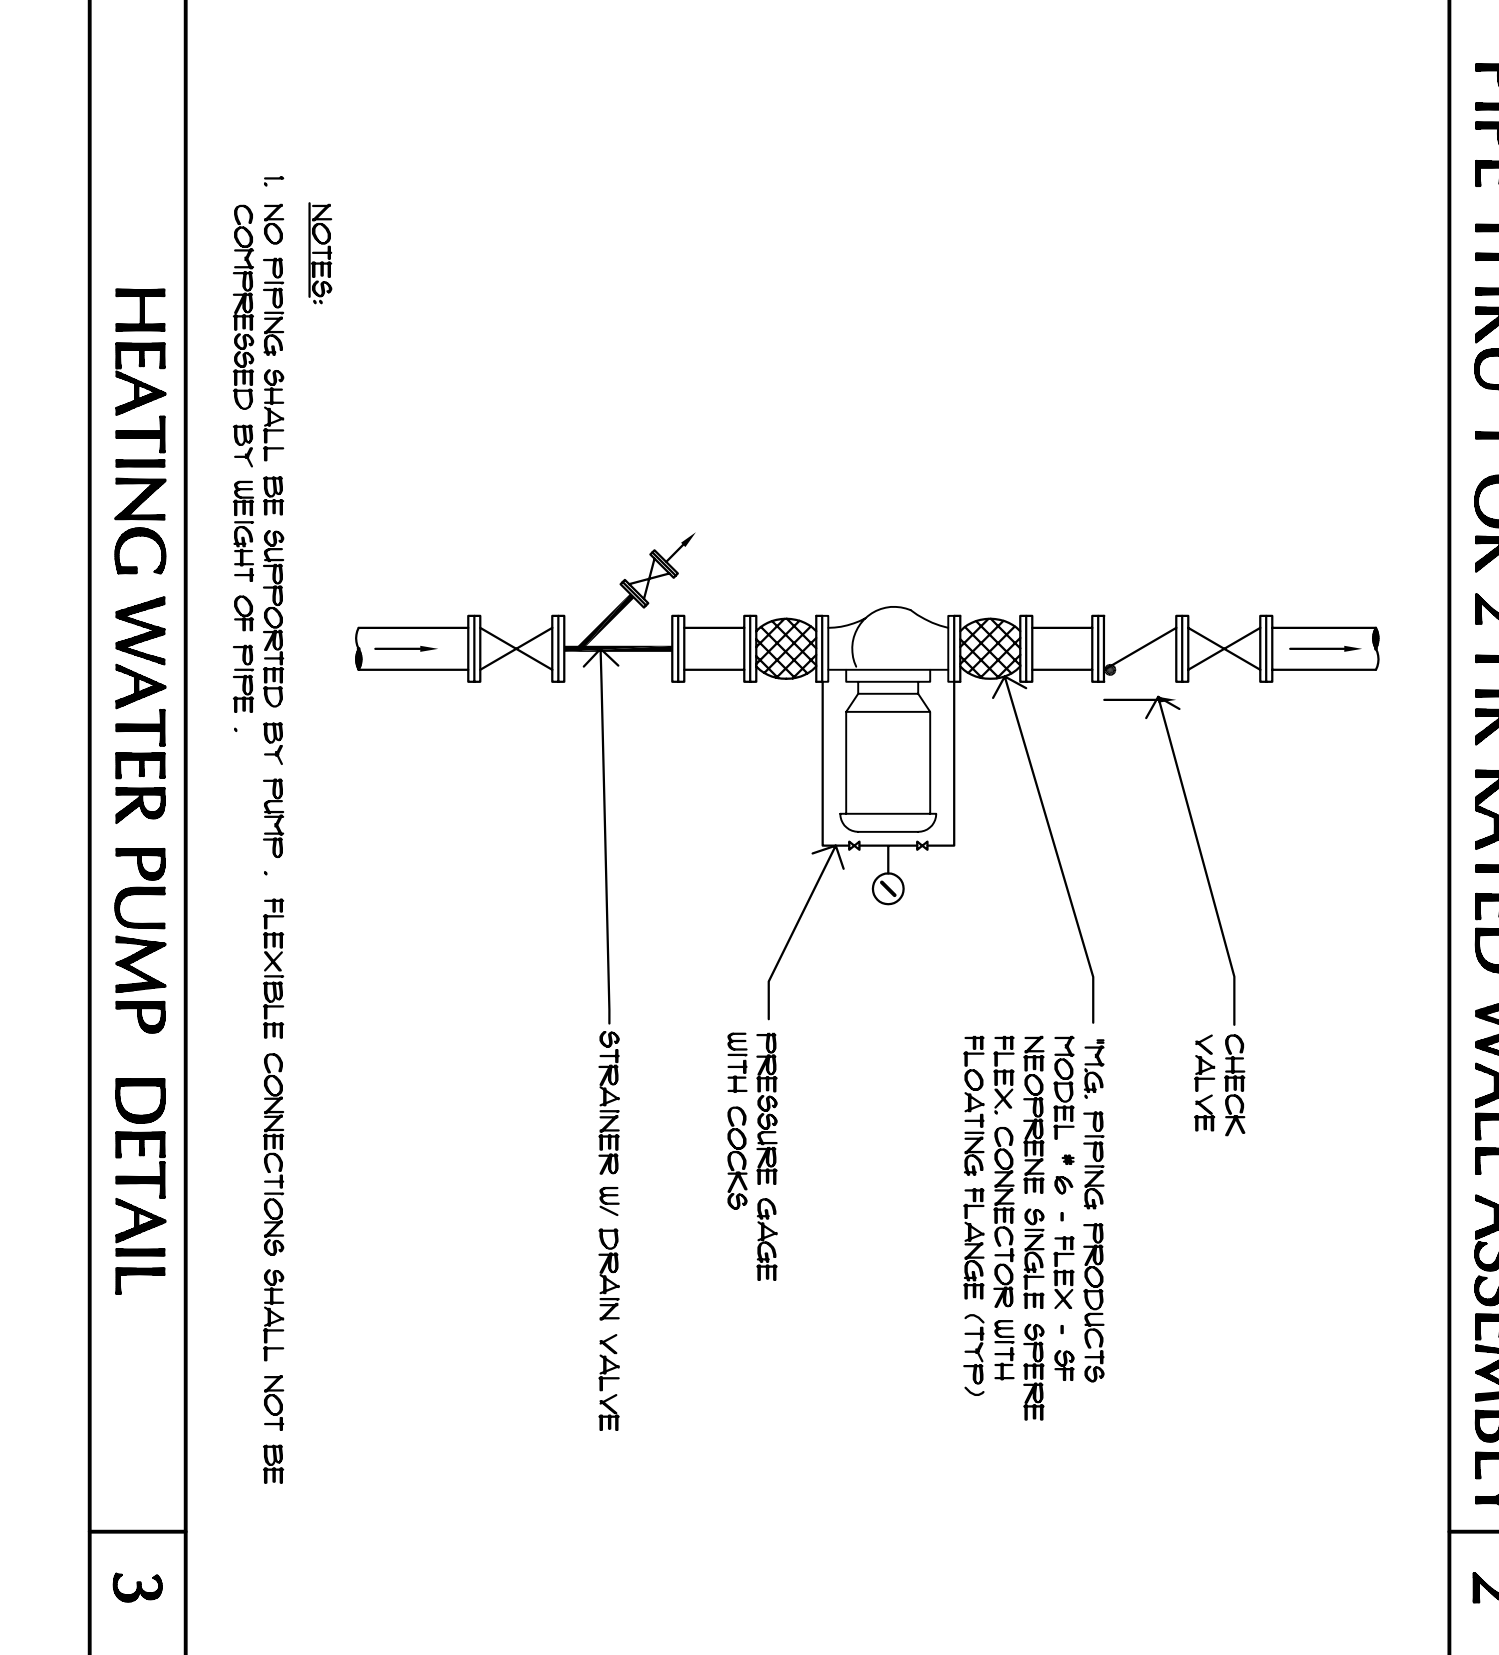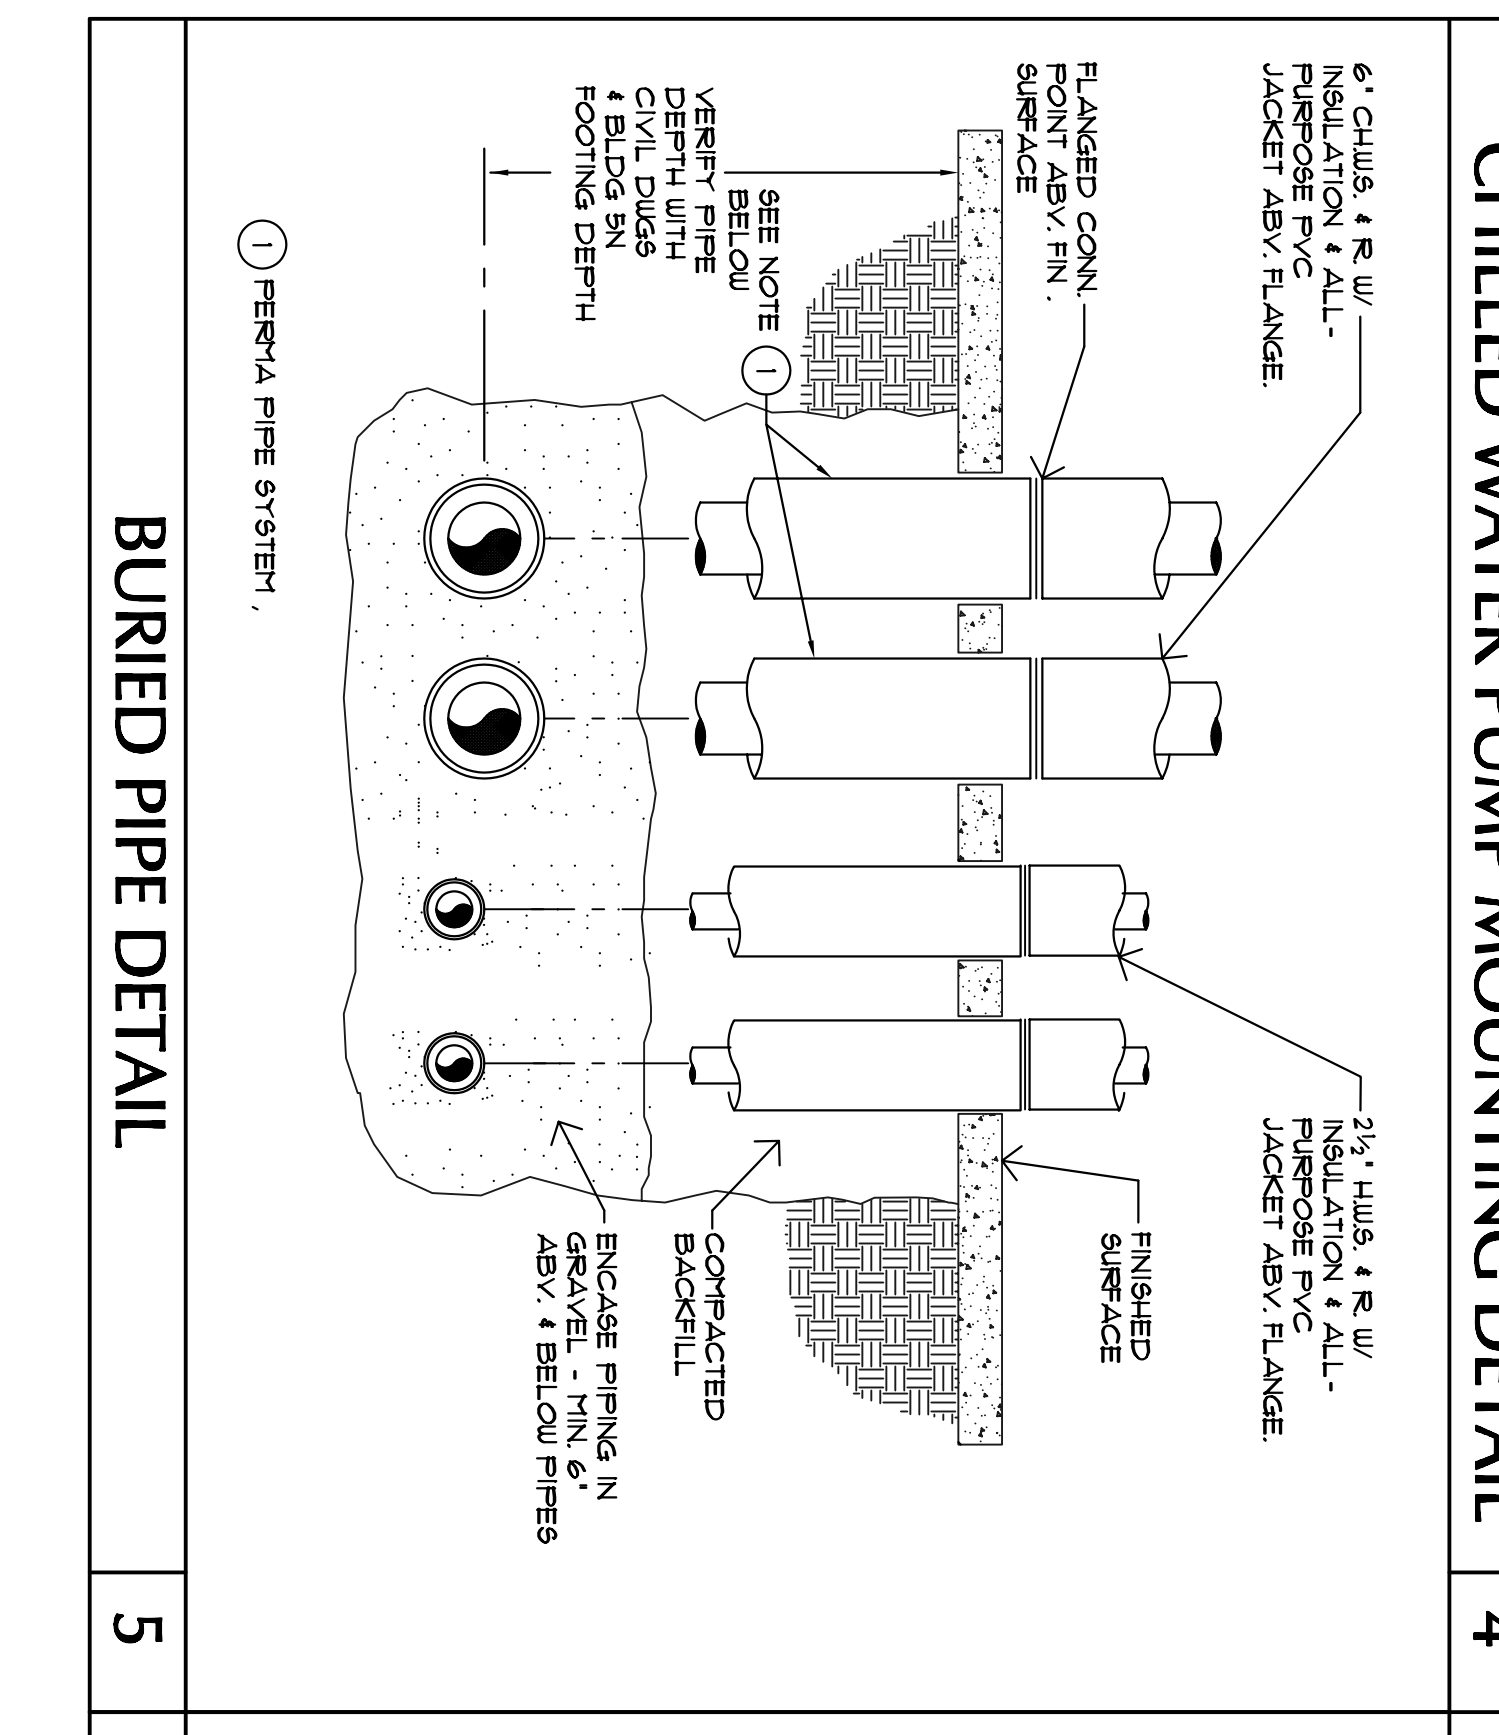

BURIED PIPE DETAIL 5