




TYPICAL HOT WATER REHEAT ZONE

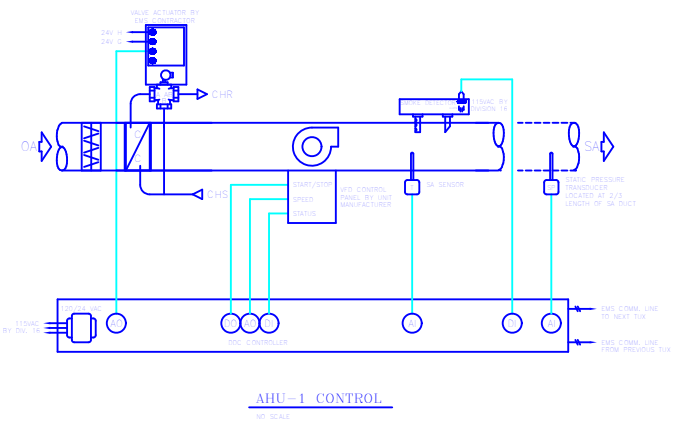


AHU-1 CONTROL

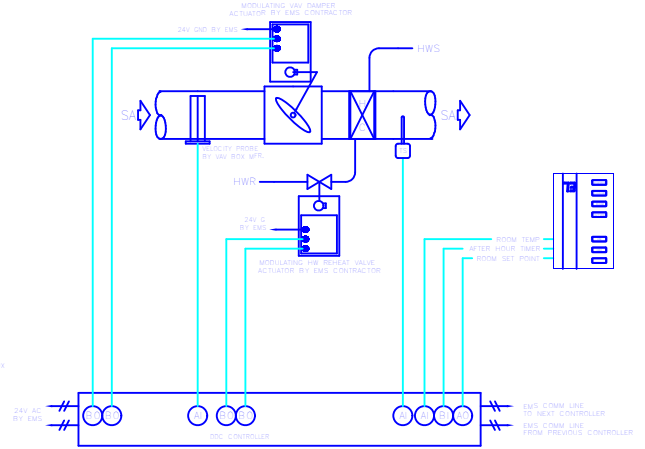


TYPICAL VAV BOX W/ HOT WATER REHEAT

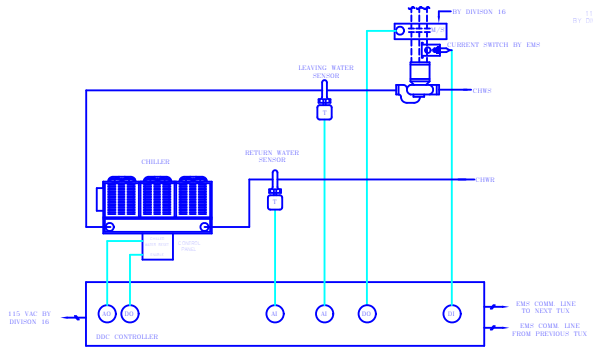


CHILLED WATER CONTROL

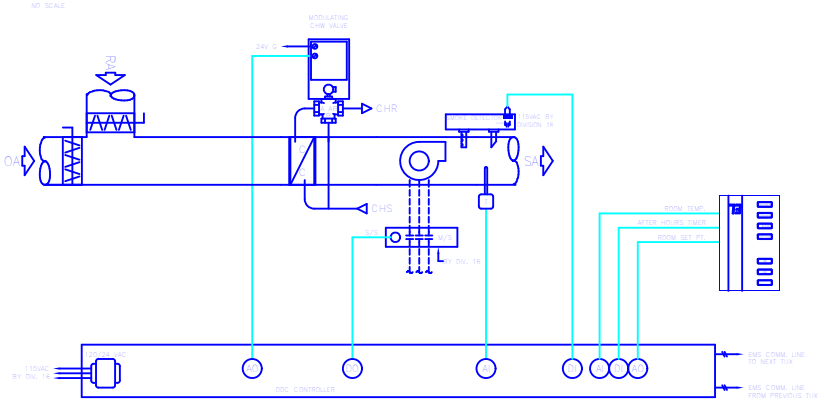

AHU-2 CONTROL

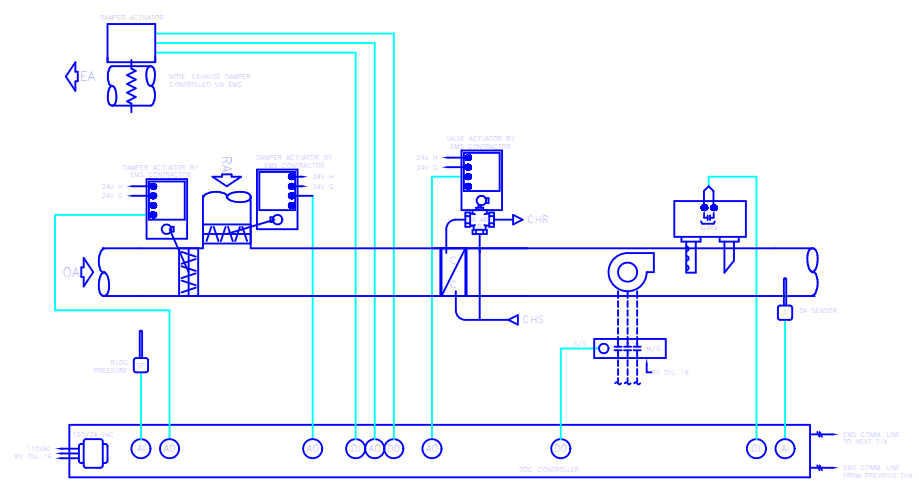


AHU-3 CONTROL

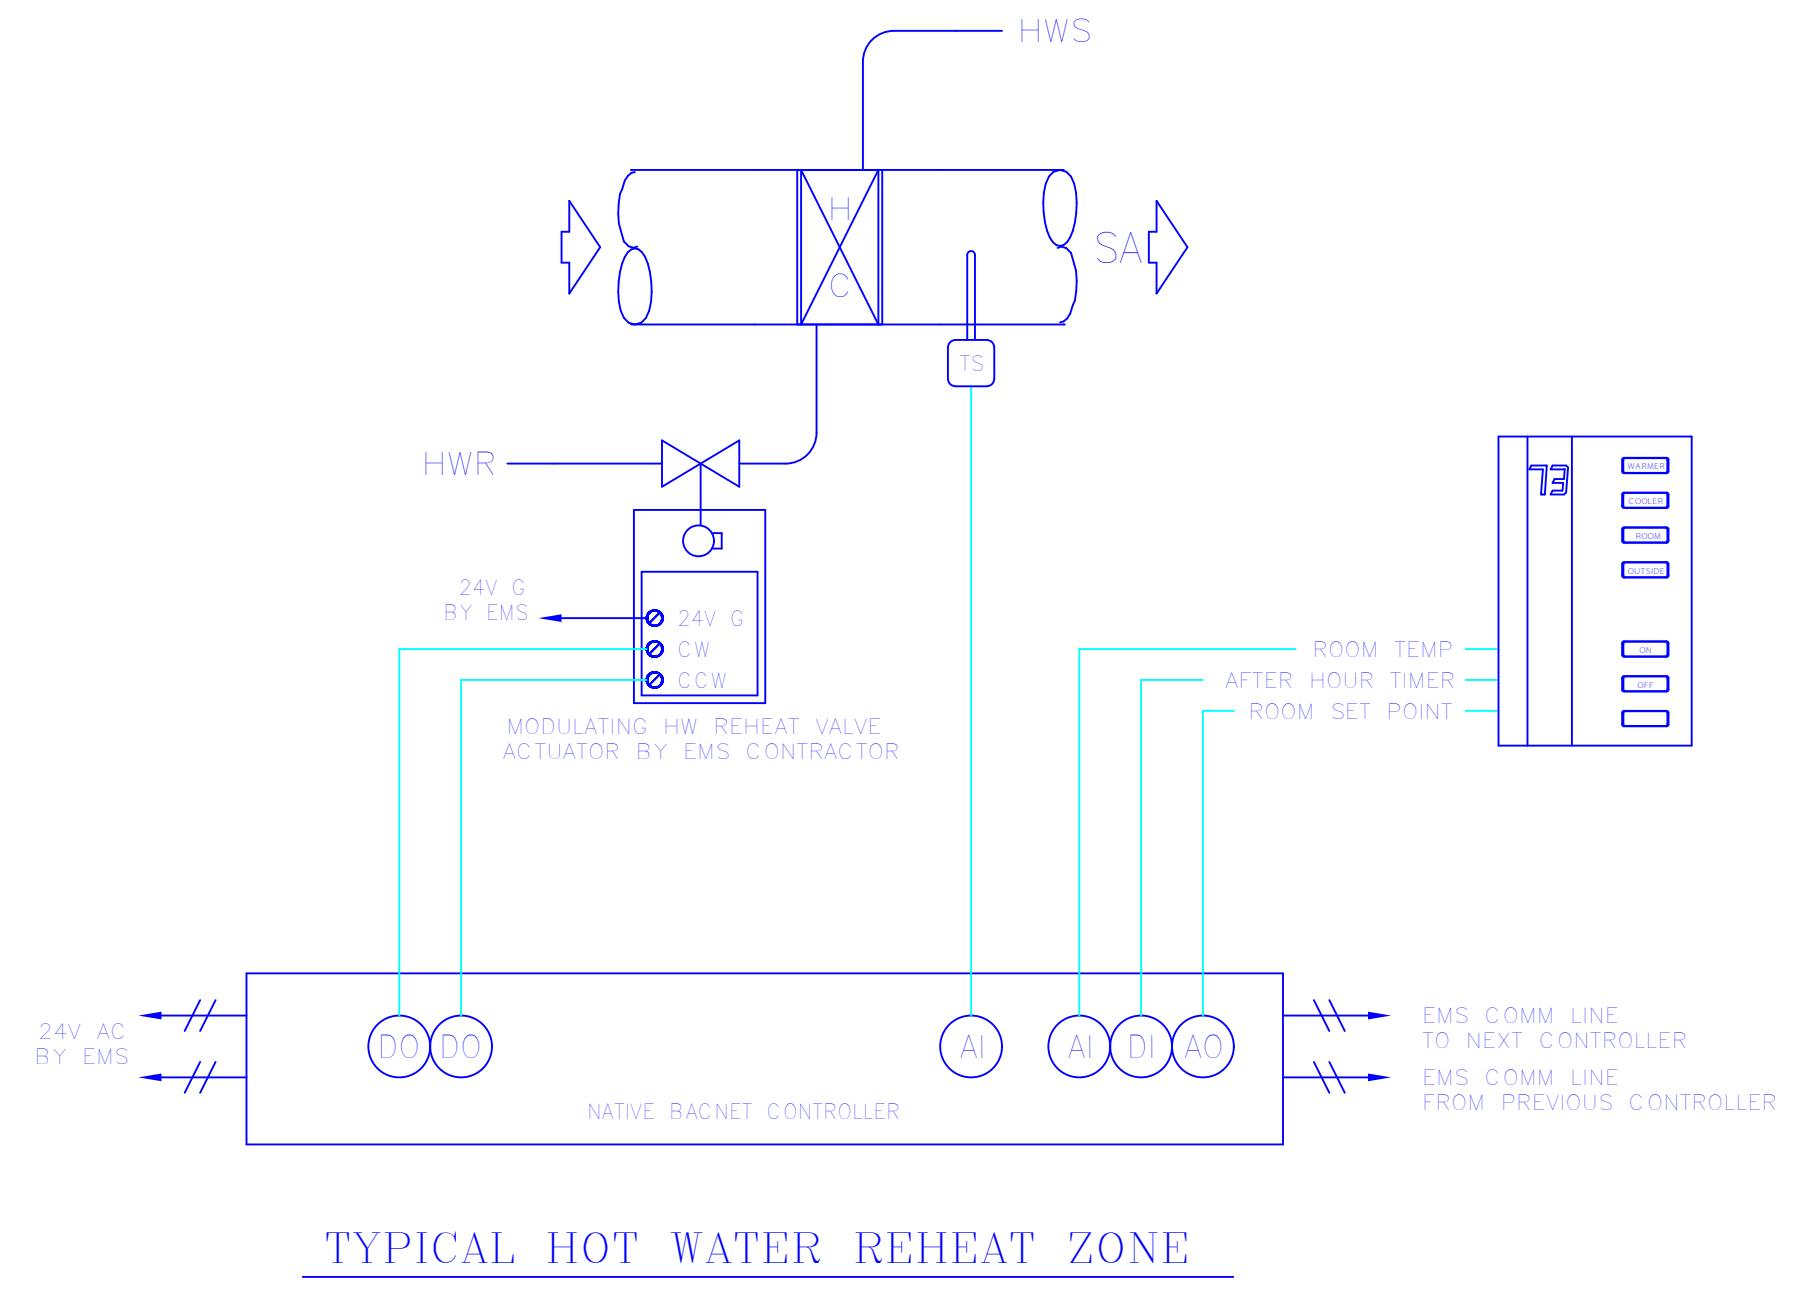


TYPICAL HOT WATER REHEAT ZONE

NO SCALE

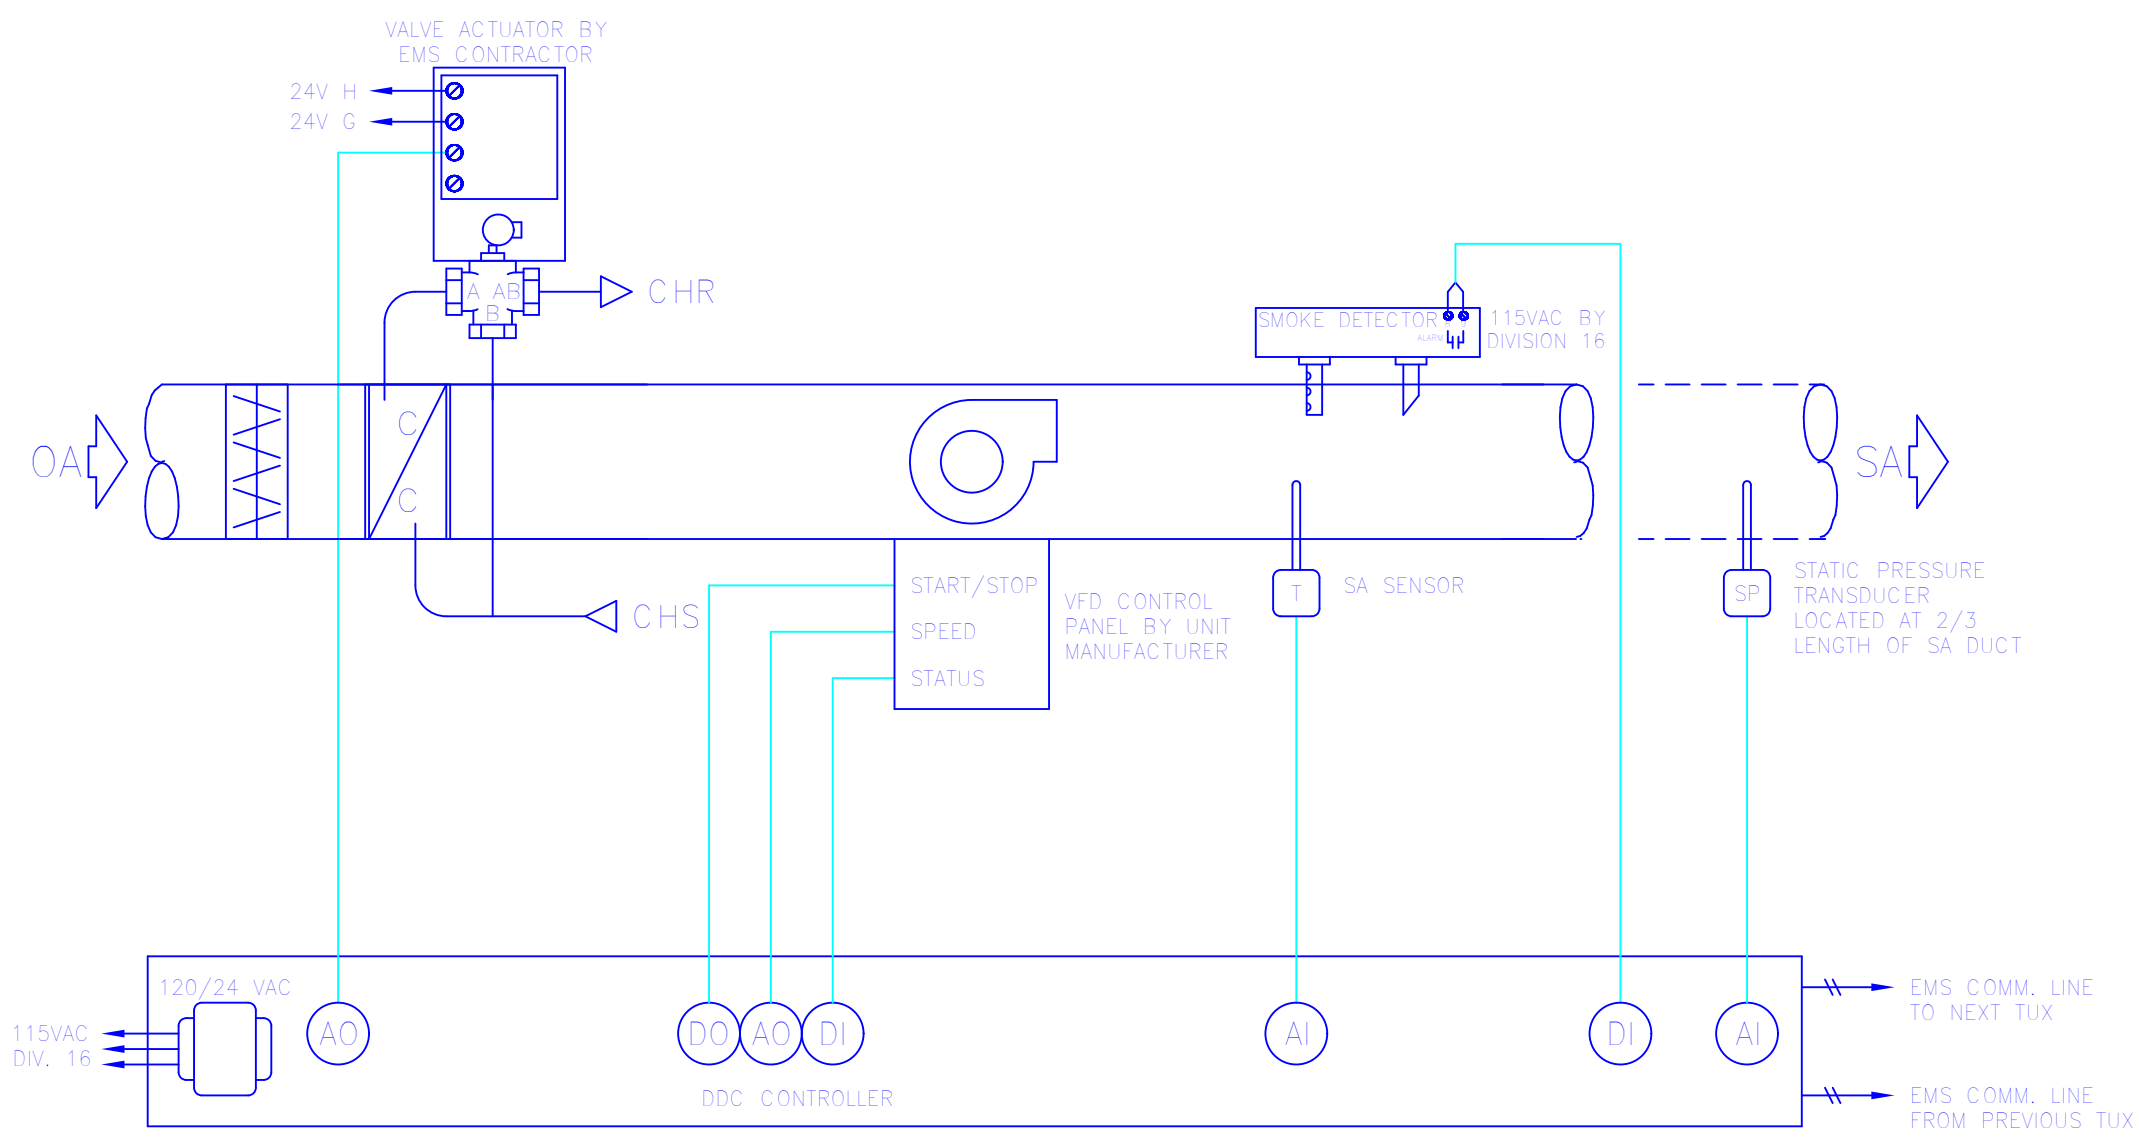


AHU-1 CONTROL

NO SCALE

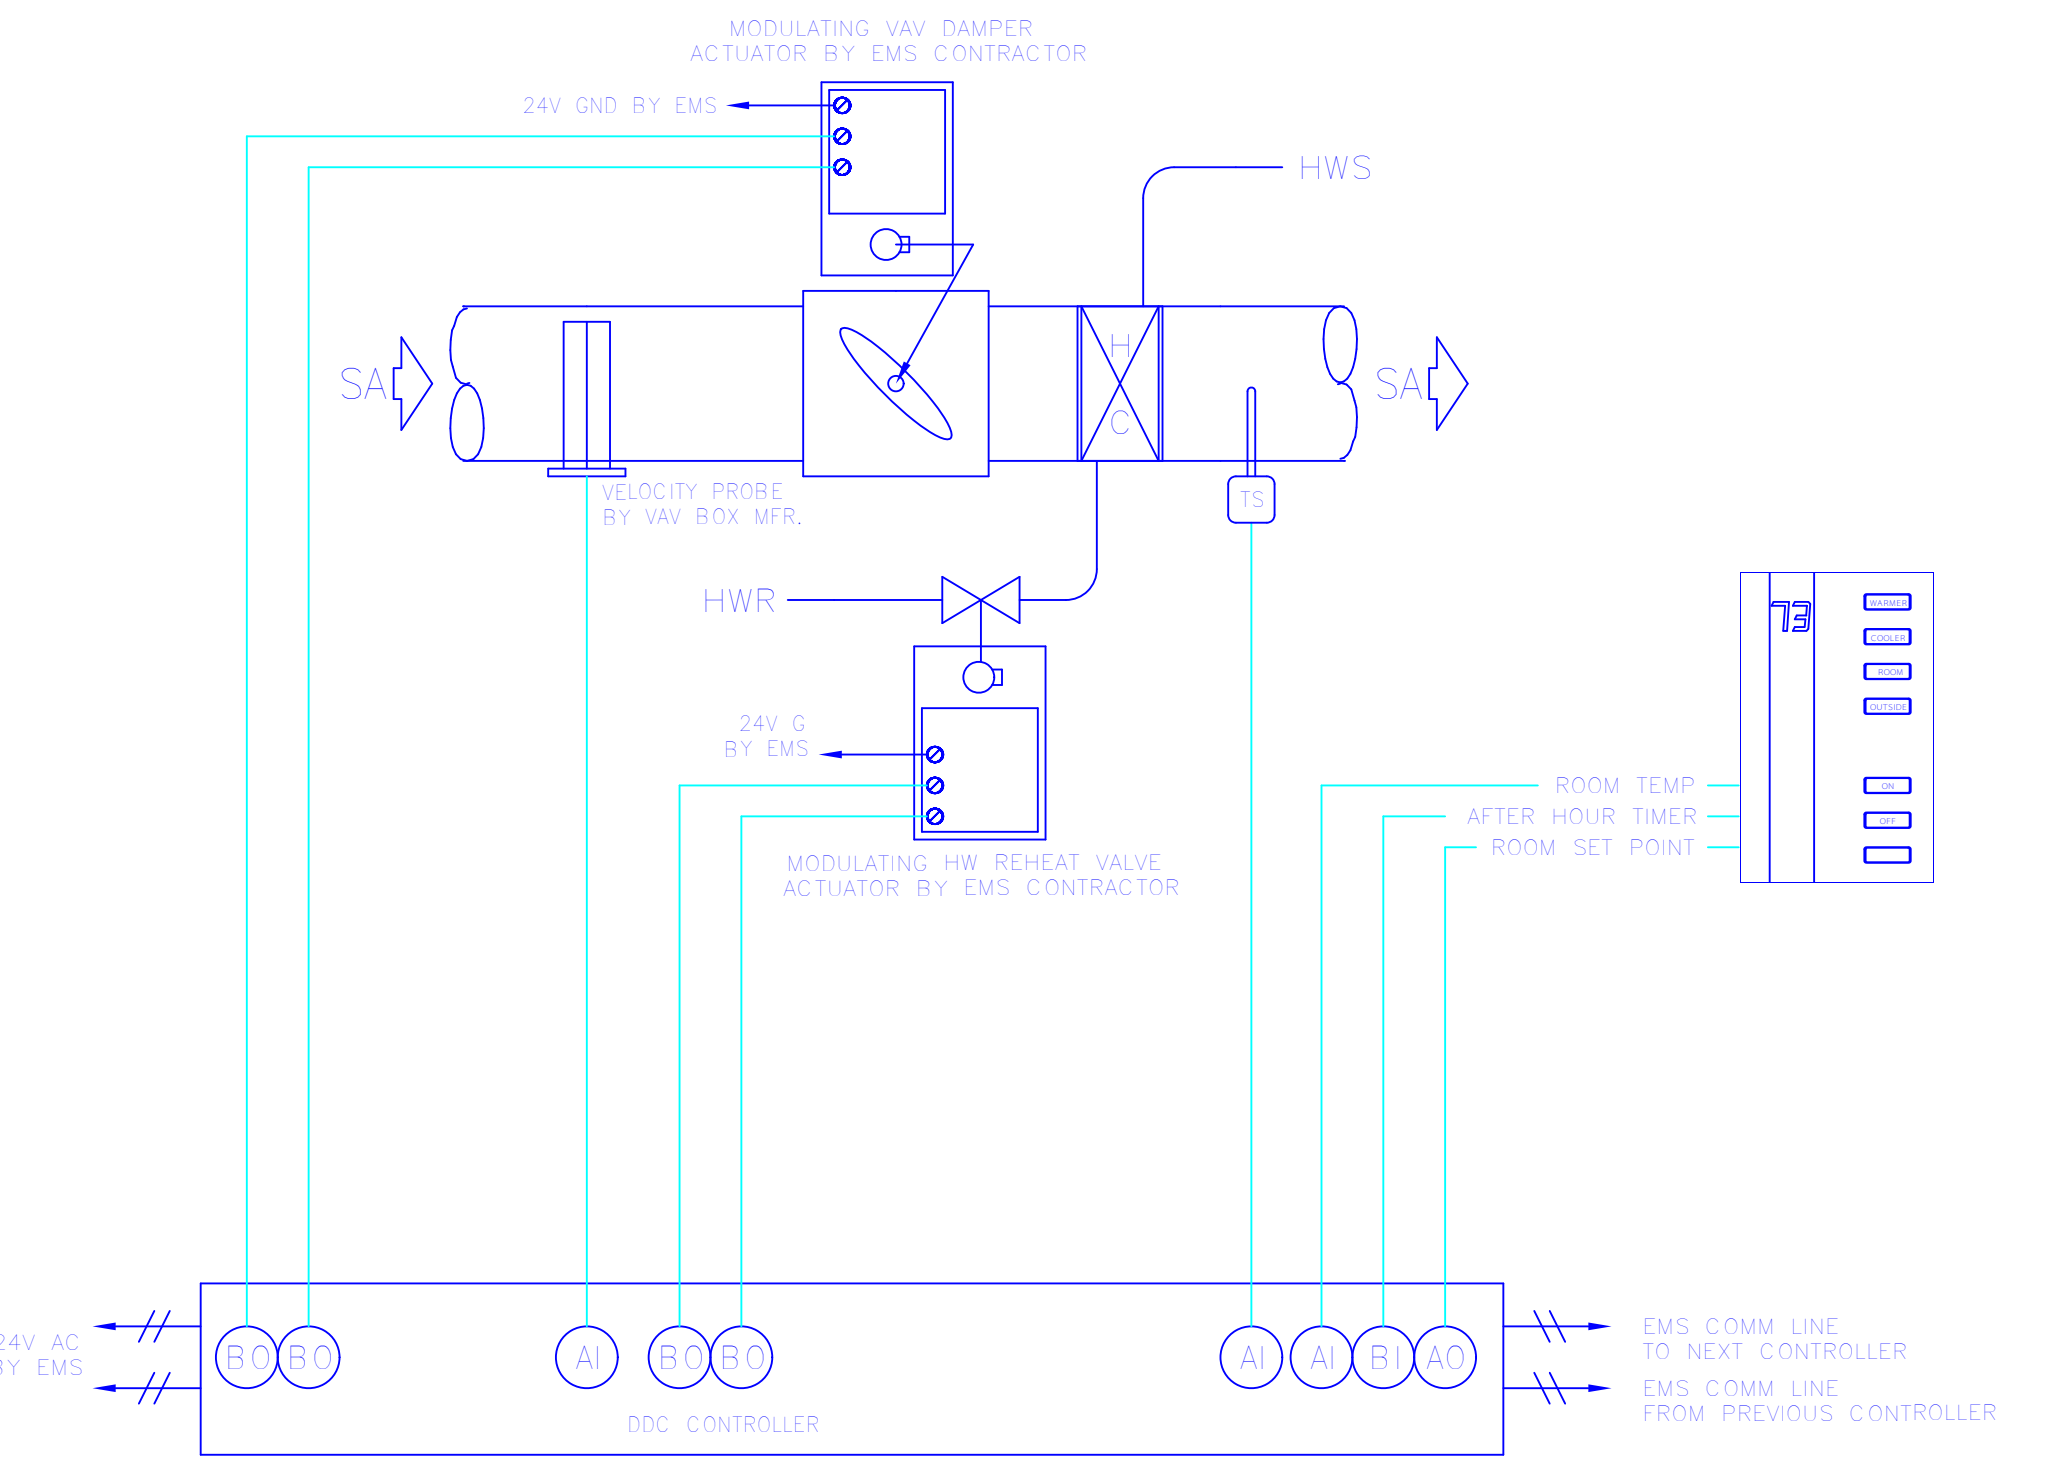


TYPICAL VAV BOX W/ HOT WATER REHEAT

NO SCALE

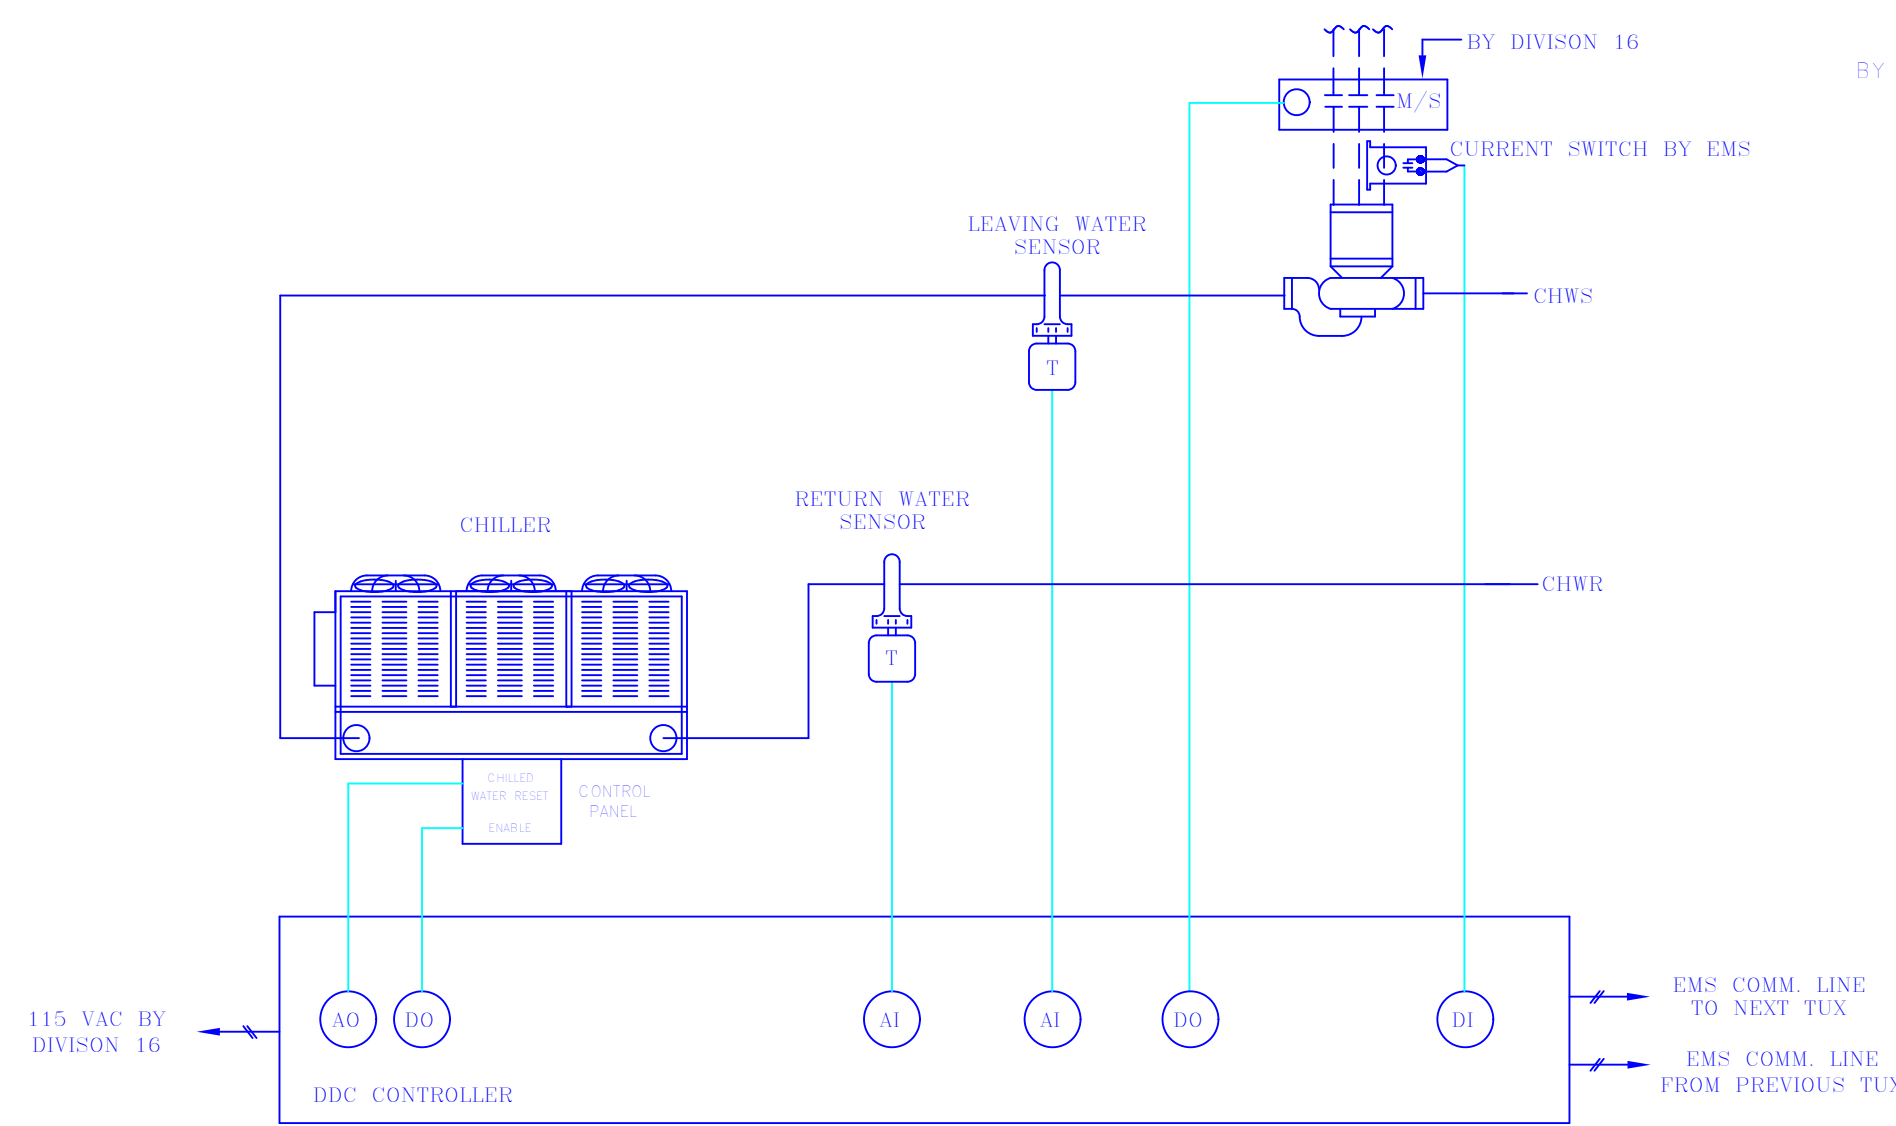


CHILLED WATER CONTROL

NO SCALE

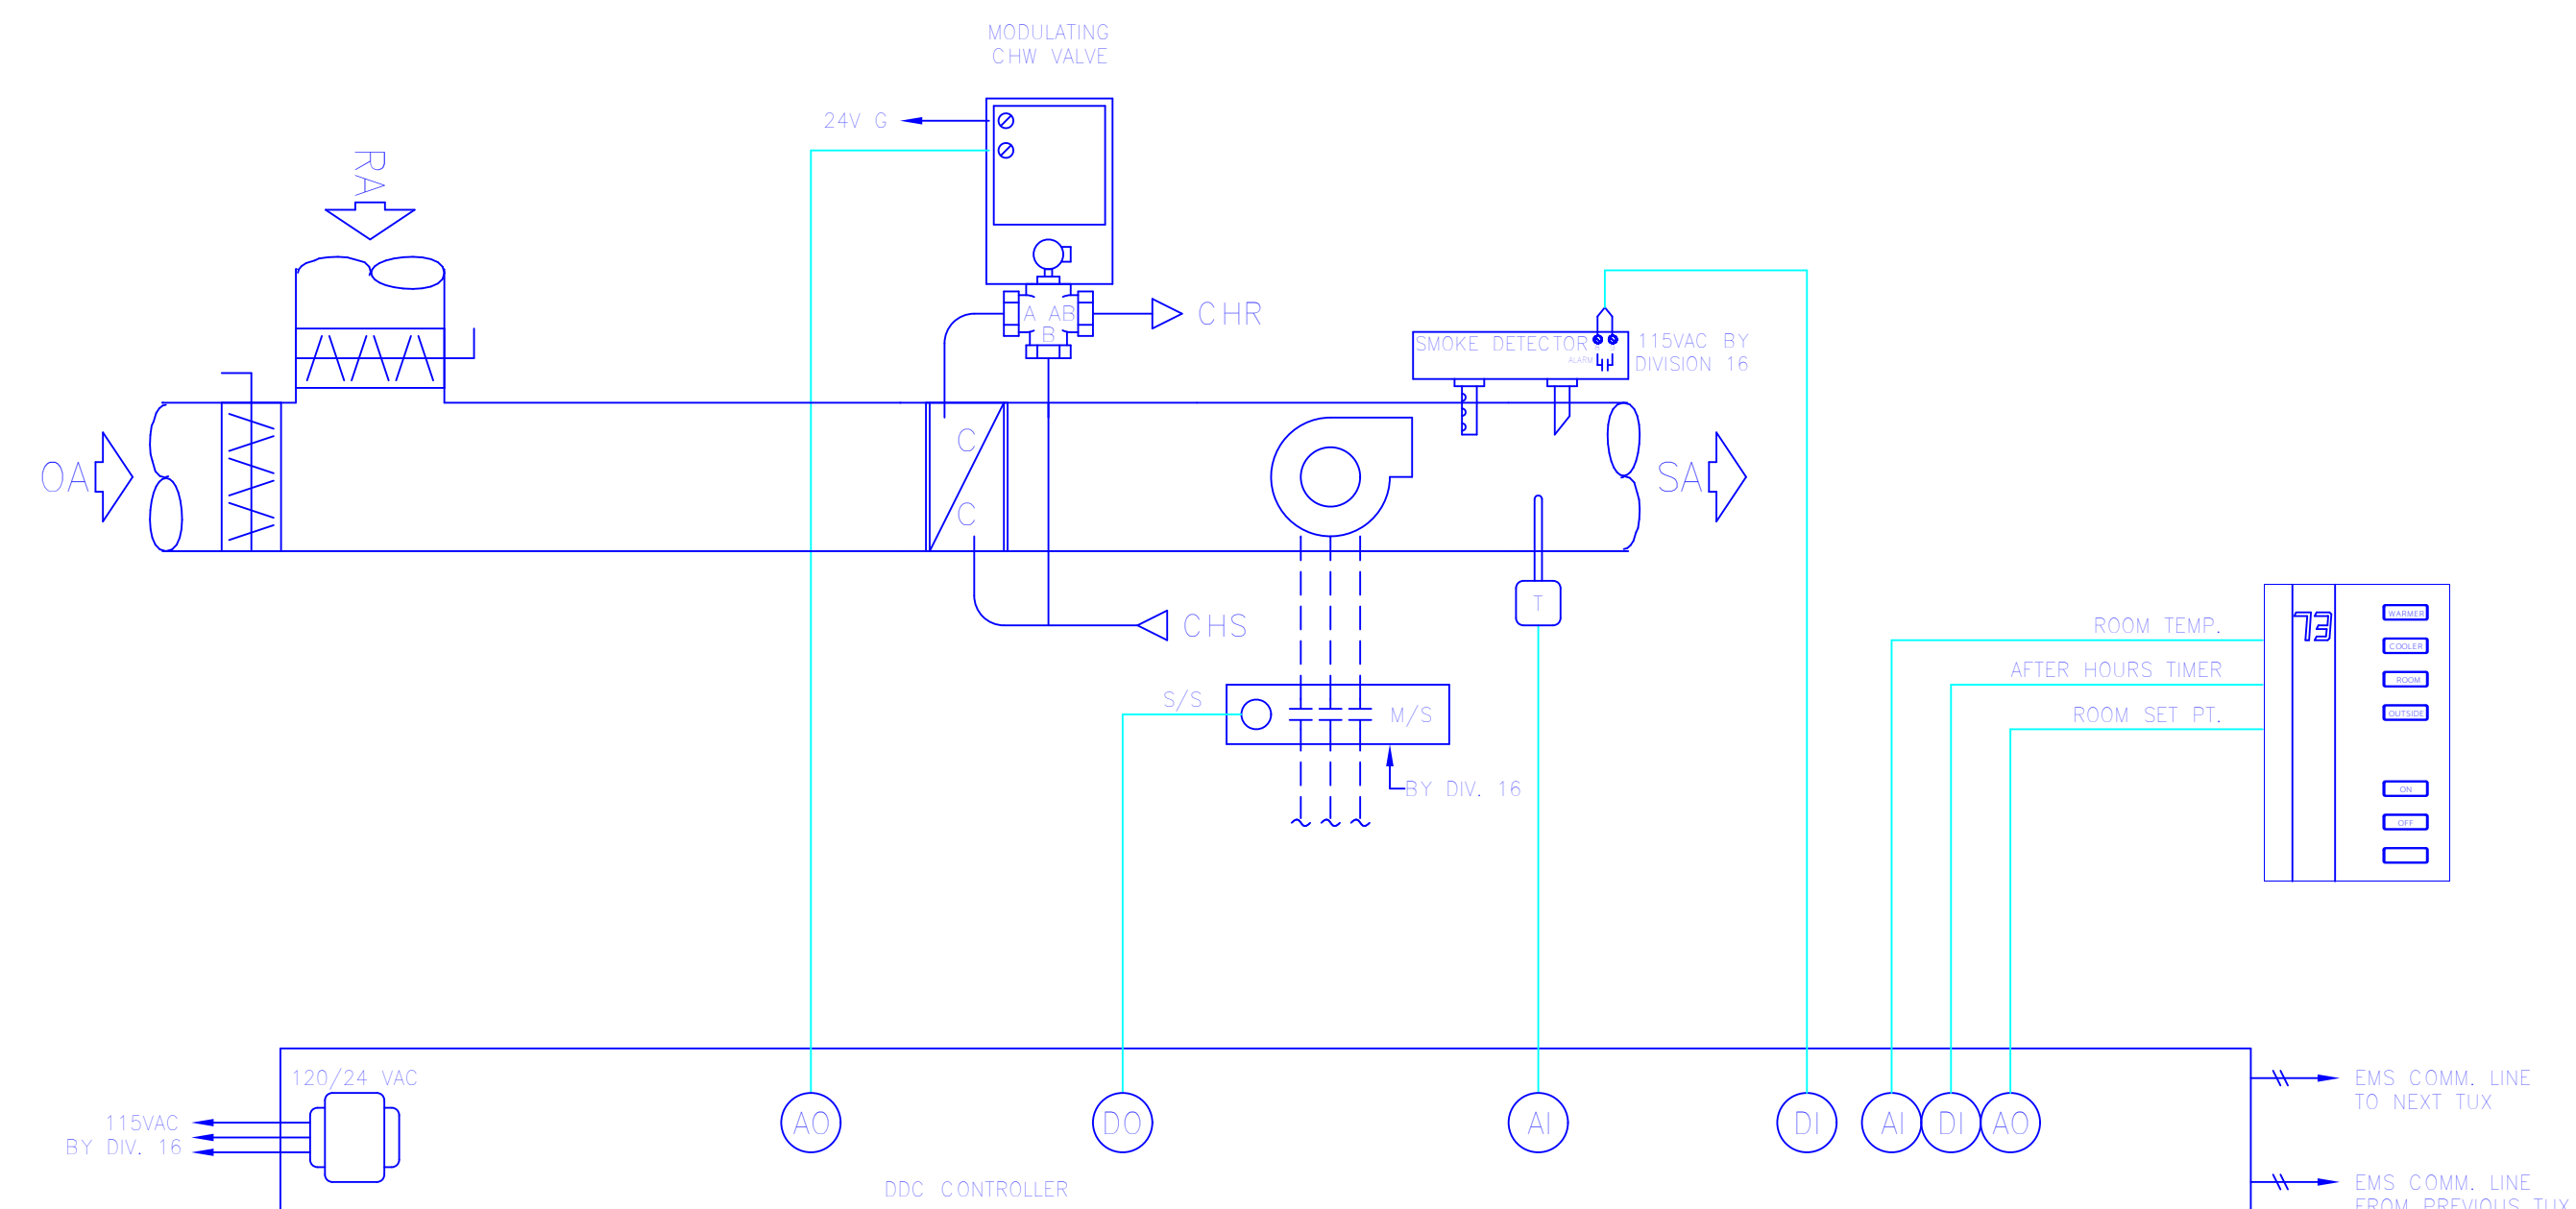

AHU-2 CONTROL

NO SCALE

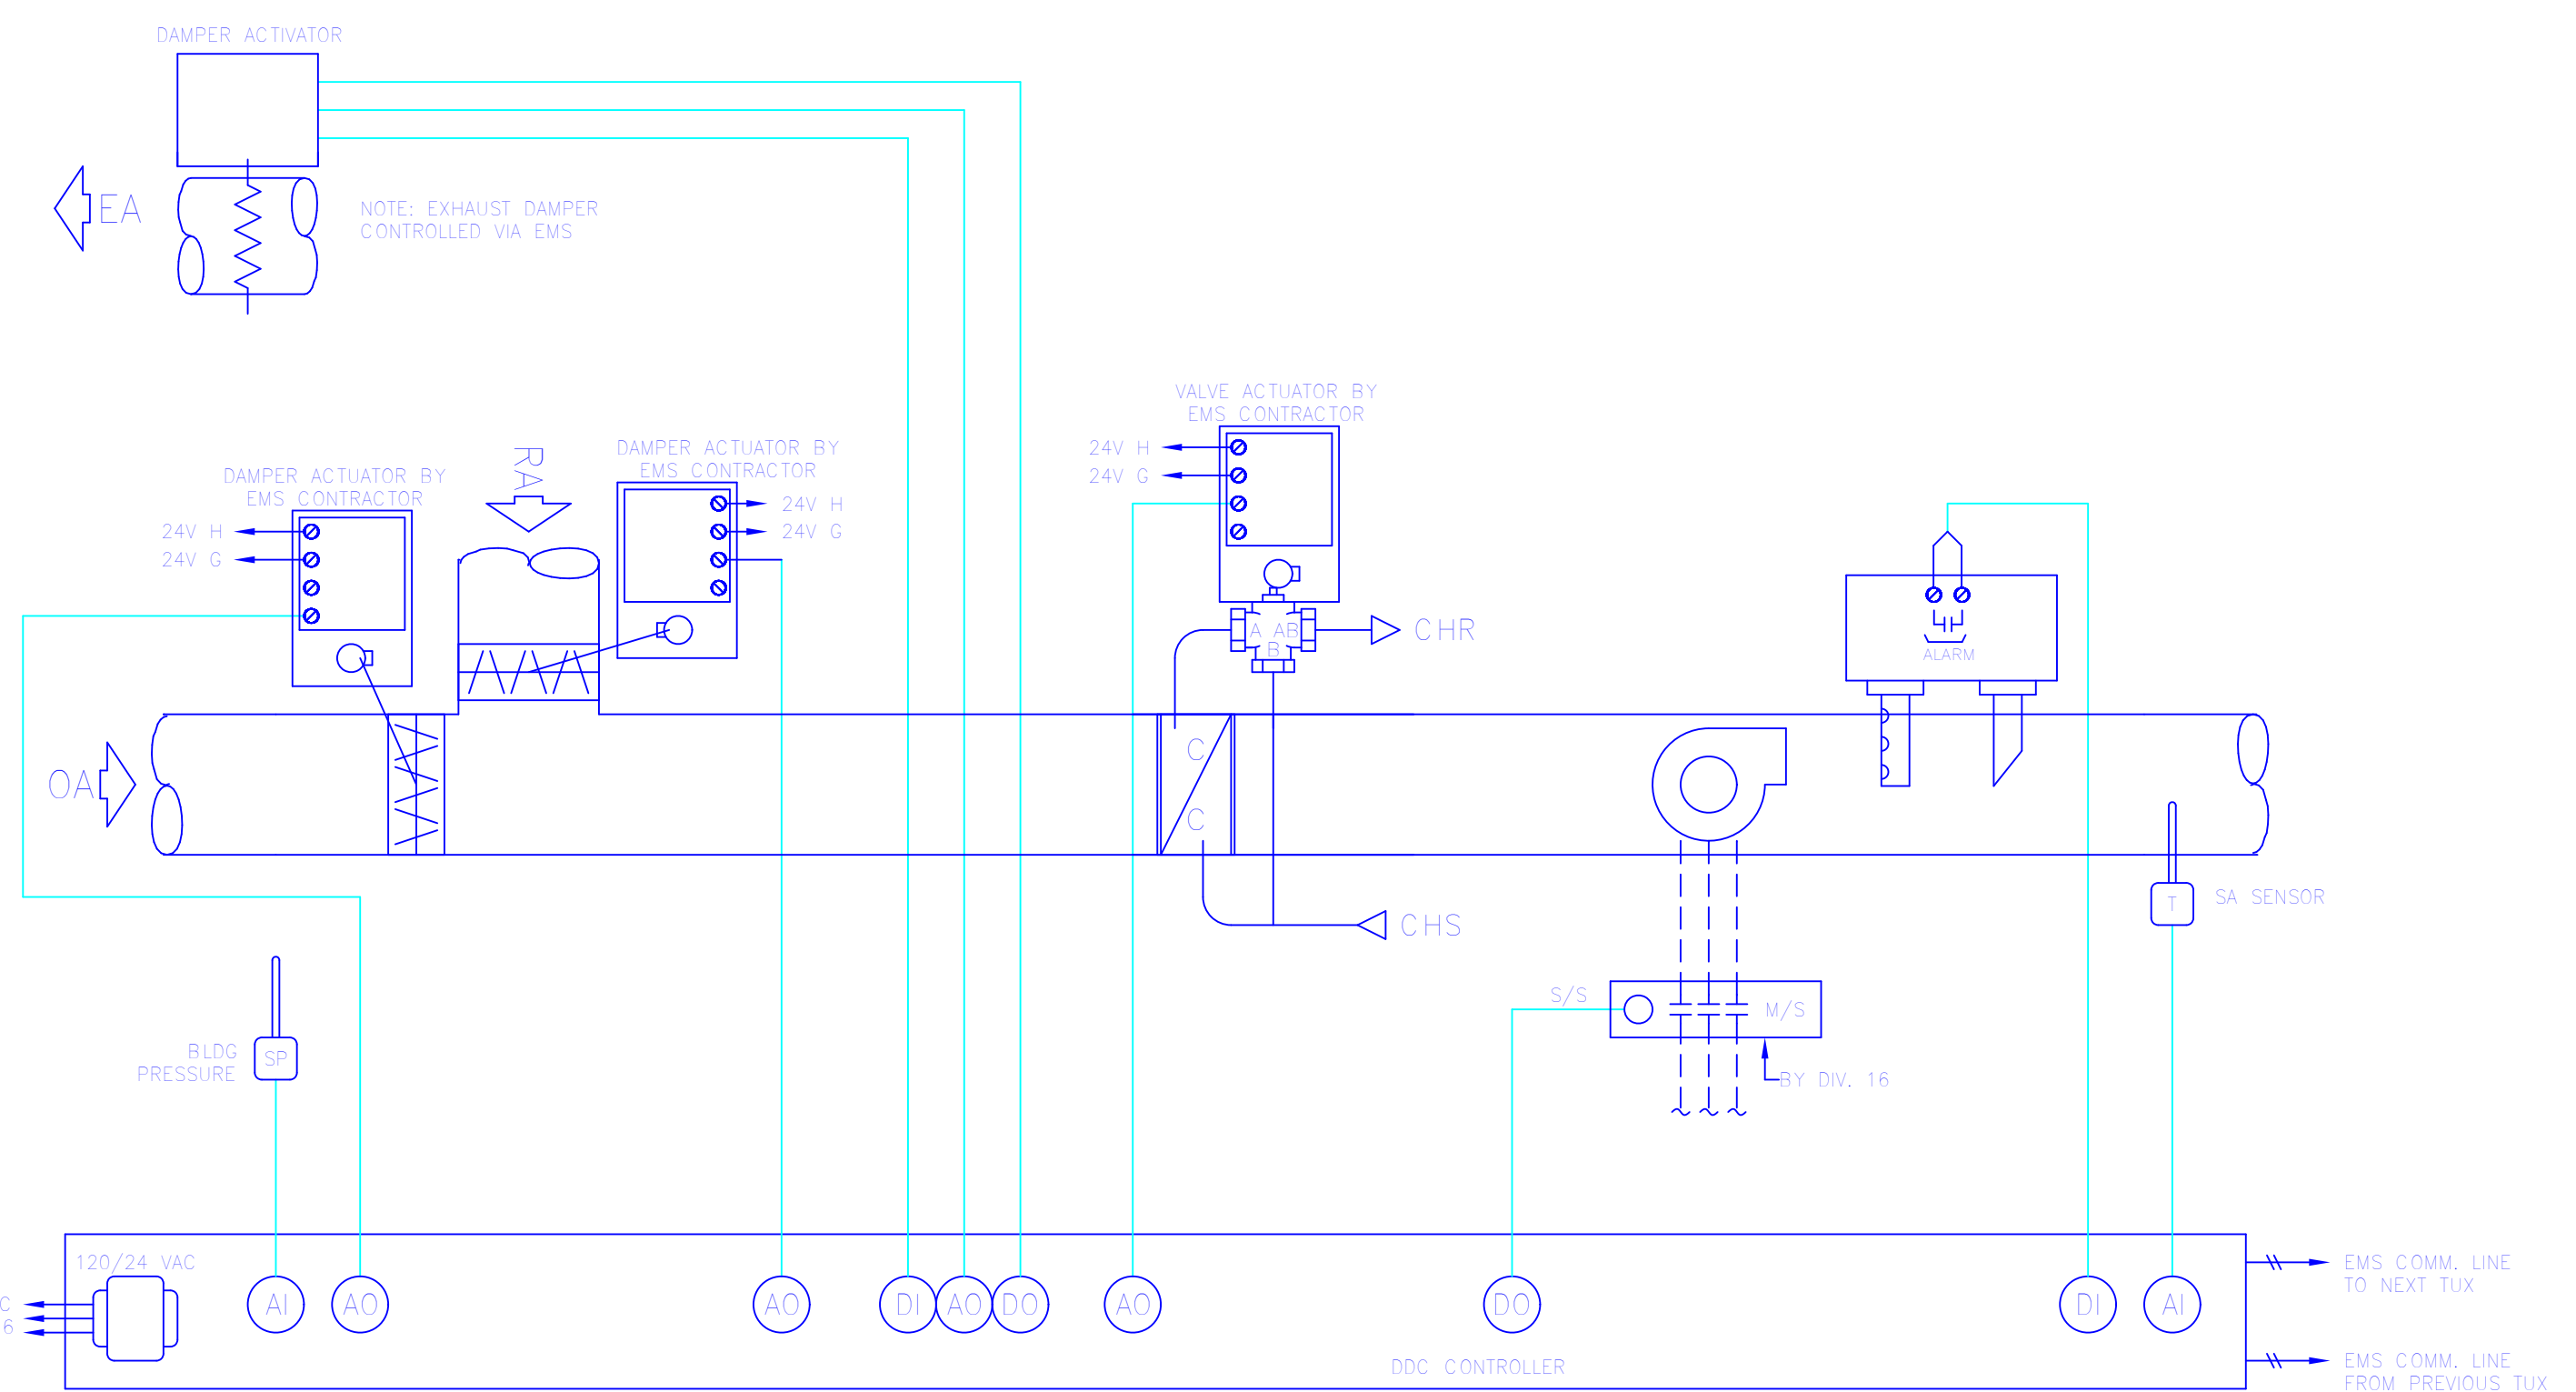

AHU-3 CONTROL

NO SCALE

MECHANICAL CONTROL DIAGRAMS

AS-BUILTS			
DRAWN BY	DATE	CHECKED BY	DATE
PCP	6/30/06	MP	6/30/06

SAN MATEO COUNTY
COMMUNITY COLLEGE DIST.

BUILDING 9
MECHANICAL
CONTROL DIAGRAMS

PROJECT NO.	1323
DRAWN BY	M. FARGHIAN
CHECKED BY	PCP
PROJECT NO.	02/01/06
DRAWN BY	W. PUGHGAS
DATE	24x36-NXTS
DRAWN BY	JRSLF
CHECKED BY	JRSLF
DRAWN BY	JRSLF
CHECKED BY	JRSLF
PROJECT NAME	1323-MECH-DIAG

M-09

Doc: A:\Projects\02021509_M-09_Mechanical_Diagrams_Rev_01.dwg, 04/23/09, 04:10:19 PM