

IDENTIFICATION STAMP
DIVISION OF THE STATE ARCHITECT
APPLICATION NUMBER 01-11618
AC: [Signature] FILE: [Signature] DATE: 2/9/11
CALIFORNIA STATE FIRE MARSHAL
APPROVED
APPROVAL OF THIS PLAN DOES NOT AUTHORIZE OR APPROVE ANY
DESIGN OR CONSTRUCTION FROM APPLICABLE REGULATIONS. FINAL
APPROVAL IS SUBJECT TO FIELD INSPECTION. ONE SET OF APPROVED
PLANS SHALL BE AVAILABLE ON THE PROJECT SITE AT ALL TIMES.
REVIEWED BY: _____ DATE: _____

CAÑADA COLLEGE
Electrical
Infrastructure
Replacement
Project
4200 Farm Hill Blvd
Redwood City, CA 94061



REGISTERED ARCHITECT
CHRISTOPHER NOLL
REN. 12/31/11
15915
[Signature]
BID SET

SHEET TITLE
Overall Site Plan

REVISIONS		
NO.	DATE	DESCRIPTION

DATE: January 14, 2011
DRAWN: TC/AL
CHECKED: MM
SCALE: 1" = 60'-0"
JOB NO.: 2921.01

SHEET NUMBER
A0.01

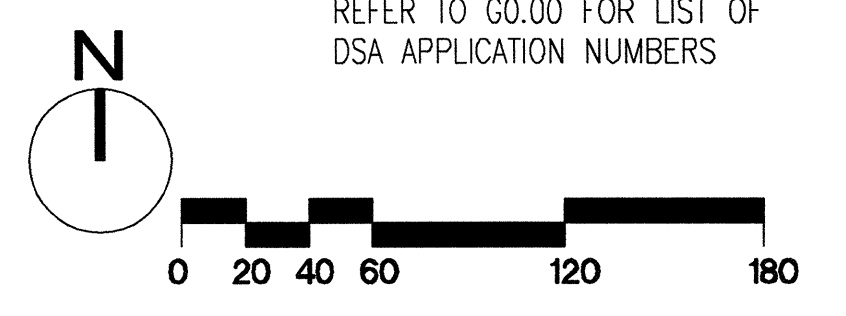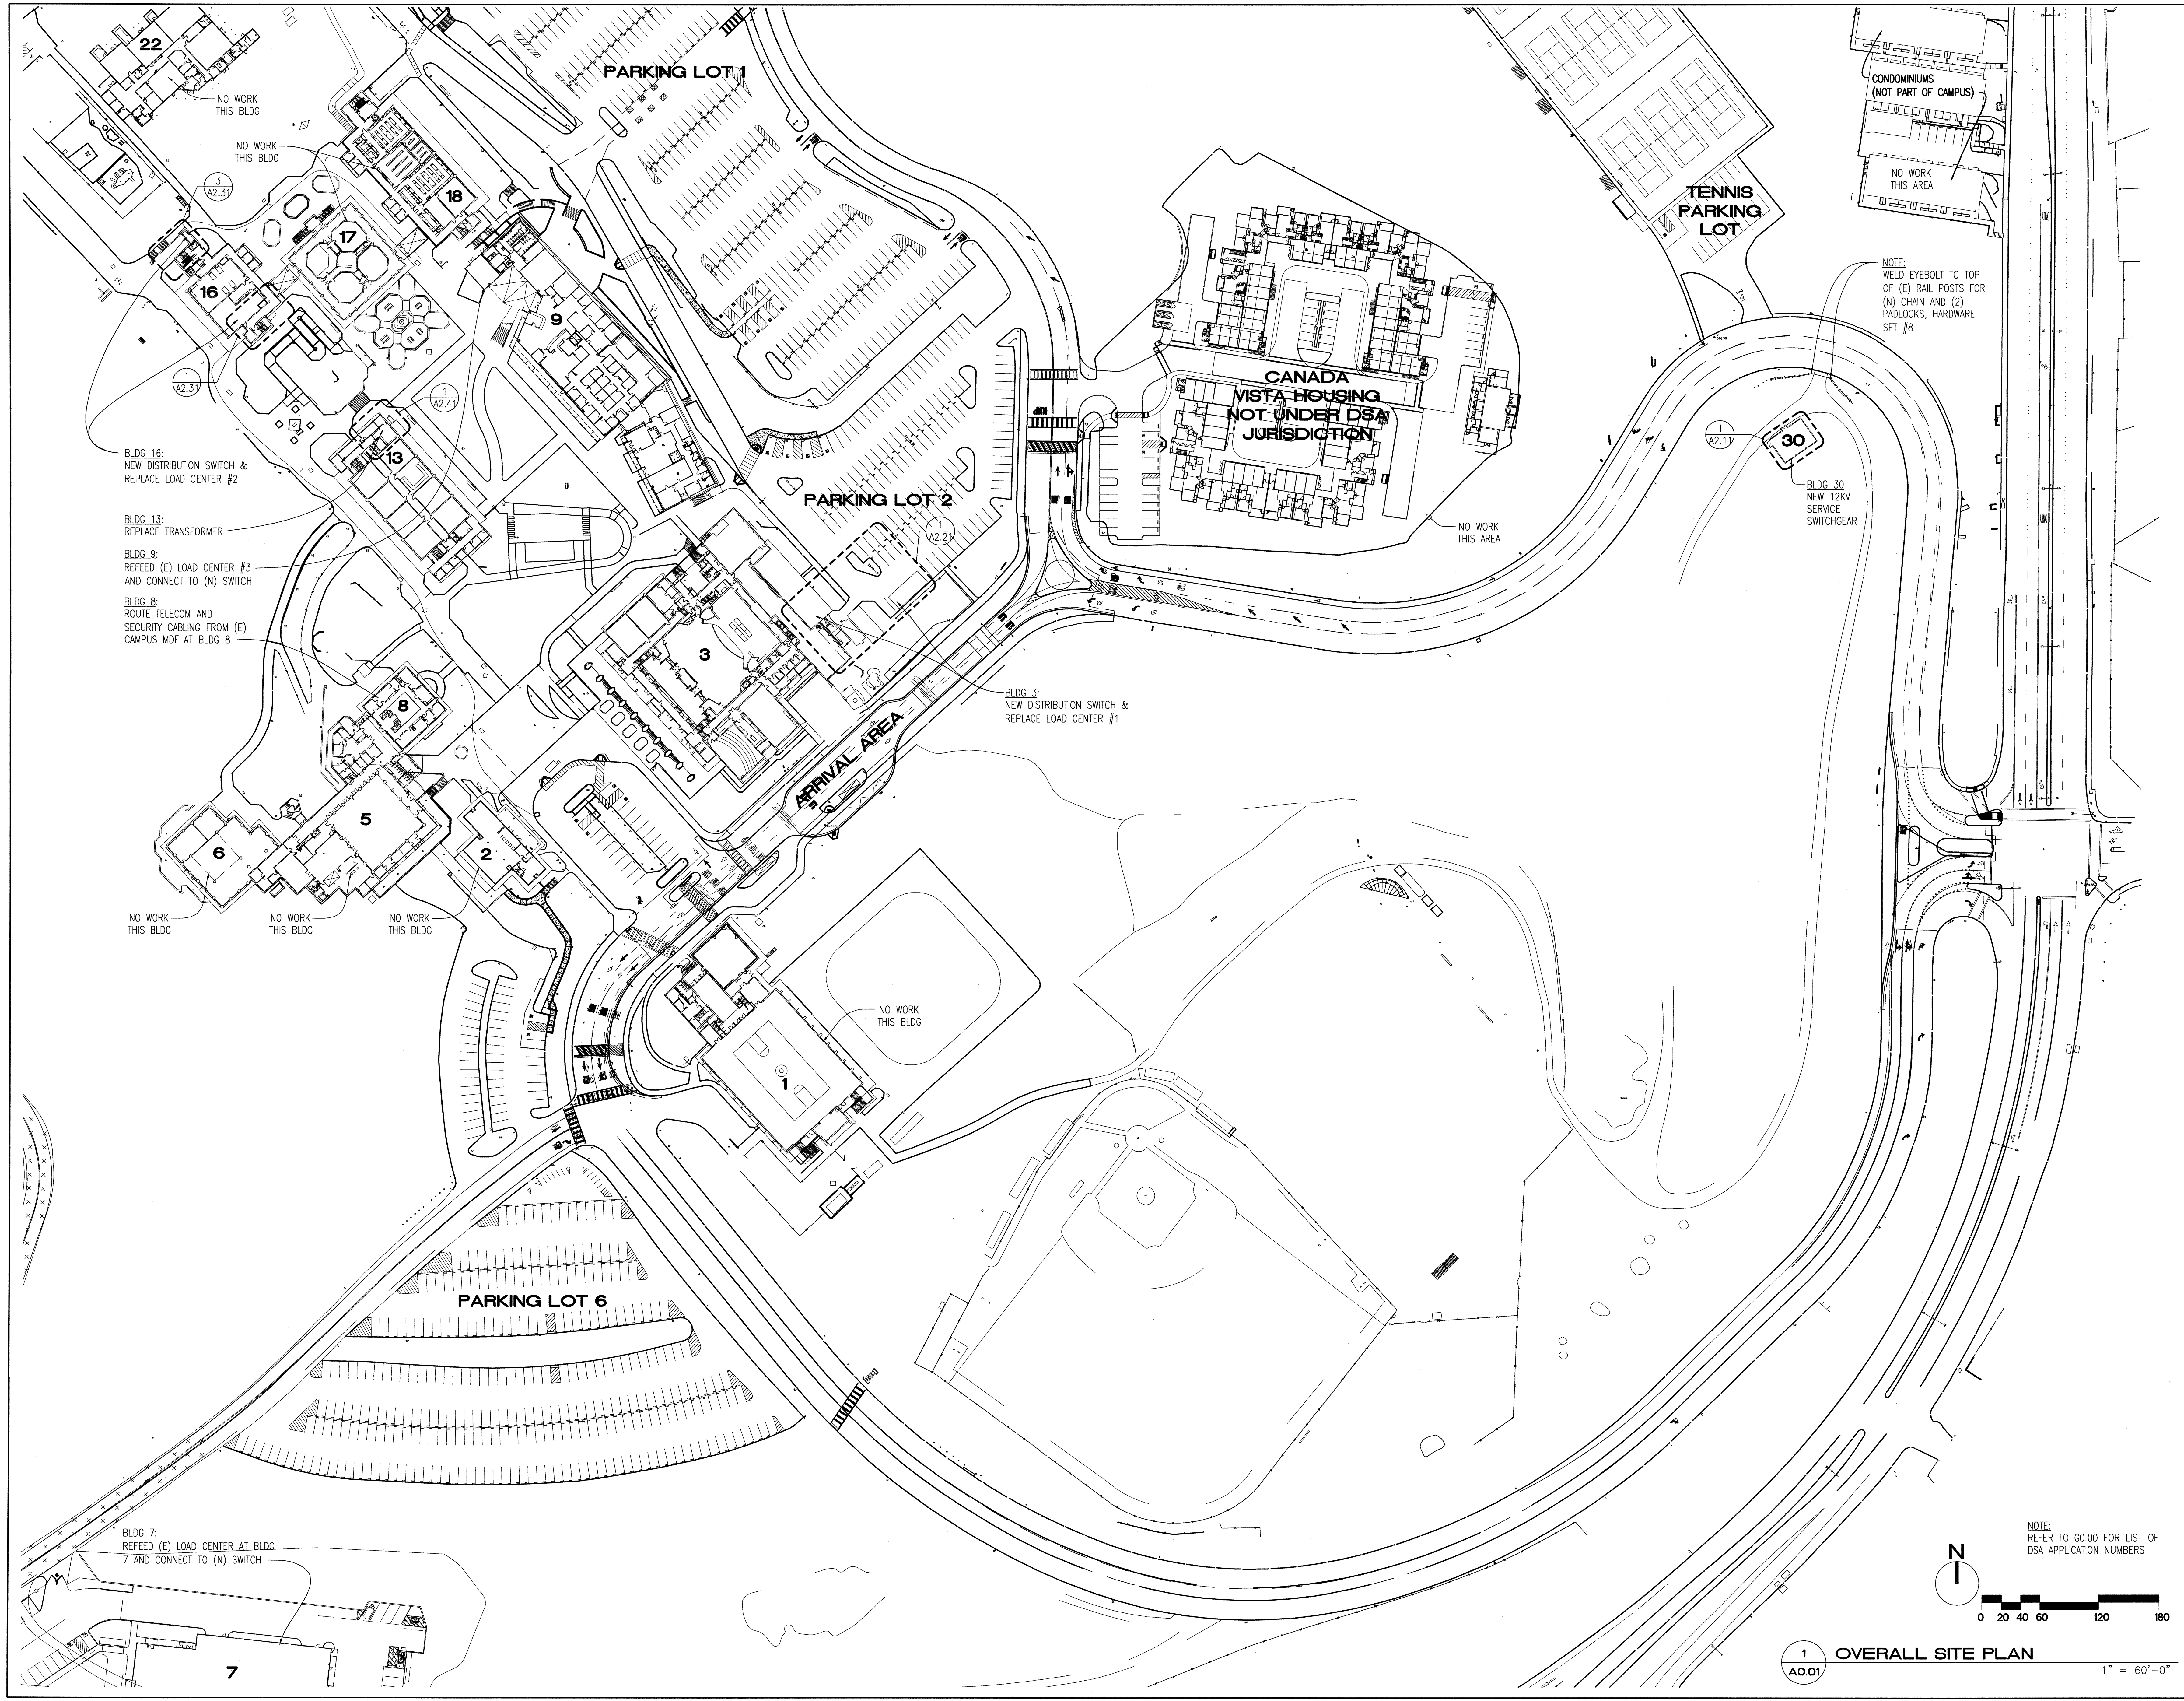

1 OVERALL SITE PLAN
A0.01 1" = 60'-0"