


- ### SHEET NOTES
- 10 SUSPENDED ACOUSTICAL PANEL CEILING
 - 11 GYPSUM BOARD CEILING
 - 14 (E) EXPOSED STRUCTURE ABOVE
 - 16 RECESSED LIGHT FIXTURE
 - 18 SUSPENDED LIGHT FIXTURE
 - 21 WALL MTD. FULL-DOWN PROJECTION SCREEN (SEE 21/A10.51)
 - 48 ELEVATOR
 - (E) CEILING AND LIGHT FIXTURES TO REMAIN
 - (E) ELEVATOR TO REMAIN
 - 62 PROVIDE CEILING AND REPLACE MOUNTED LIGHT FIXTURES AS NECESSARY TO RESTORE TO PRE-CONSTRUCTION CONDITION. (TYPICAL AT AREAS DEMOLISHED FOR REMOVAL/ PROVISION OF NEW MECHANICAL WORK)
 - 84 CEILING MOUNTED PROJECTOR BRACKET (SEE DETAIL 11/A10.91 FOR CONNECTION). SEE ELECTRICAL DRAWINGS FOR ADDITIONAL INFORMATION.

BCA
 architecture
 planning
 interiors

Bunton Clifford Associates, Inc.
 210 Hammond Ave.
 Fremont, California 94539
 [T] 510.445.1000
 [F] 510.445.1005
 www.BCAincOnline.com

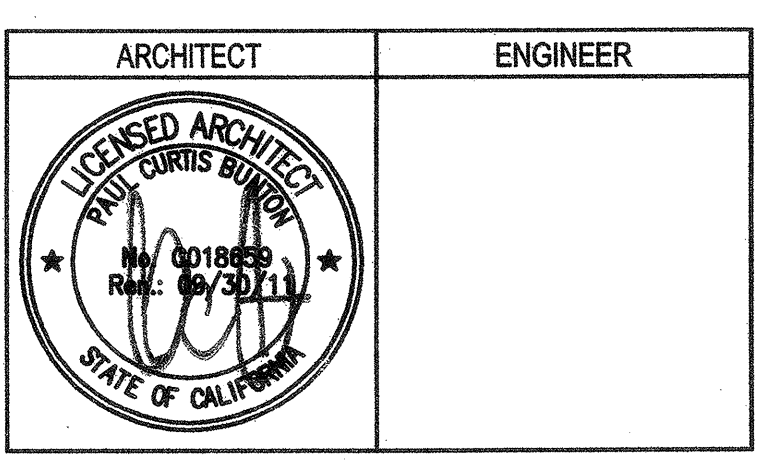

GENERAL NOTES

- This sheet is part of a set and is not to be used alone.
- This sheet is not to be used for construction unless the architect's stamp and signature appear on the drawings and the status box indicates drawings have been released for construction.
- These plans and prints thereof, as instruments of service, are owned by the architect and are for use on this project only. Reproduction and/or distribution without the prior written consent of the architect is forbidden.
- Copyright Bunton Clifford Associates, 2009

REVISIONS	DATE
ADDENDUM NO. 1	09/18/09
ADDENDUM NO. 2	11/08/09

DRAWING STATUS	DATE
DBA PLAN CHECK	08/28/08
DBA BACK CHECK	01/22/09
BIDDING	08/18/09
CONSTRUCTION	

FILE NO. 41-C1

IDENTIFICATION STAMP
 DIV. OF THE STATE ARCHITECT

01- 110074

AC PLS SS

DATE

- ### GENERAL NOTES
- A. SEE SHT. A9.1 FOR FINISH SCHEDULES.
 - B. SEE ELECTRICAL DRAWINGS FOR LIGHT FIXTURE SUPPORTS & BRACING.
 - C. SEE MECHANICAL AND PLUMBING DRAWINGS FOR HVAC AND PLUMBING EQUIPMENT AND FIXTURES.
 - D. SEE SHEETS A10.91 & A10.92 FOR TYPICAL CEILING DETAILS.

- ### LEGEND
- (E) 1'x1' ACOUSTICAL CEILING TILES
 - 2'x4' SUSPENDED ACOUSTICAL CEILING PANEL. SEE FINISH SCHED. FOR PANEL TYPE.
 - GYPSUM BOARD CEILING. PAINT, U.O.N.
 - CONCRETE STRUCTURE ABOVE, PAINT, U.O.N.
 - SUPPLY AIR DIFFUSER
 - RETURN AIR REGISTER/EXHAUST AIR GRILLE
 - ACCESS DOOR
 - FLUORESCENT LIGHT FIXTURE. SEE ELECTRICAL PLANS
 - FLUORESCENT LIGHT FIXTURE. SEE ELECTRICAL PLANS
 - DECORATIVE PENDANT LIGHT FIXTURE. SEE ELECTRICAL PLANS
 - RECESSED 'CAN' LIGHT FIXTURE. SEE ELECTRICAL PLANS
 - EXTERIOR WALL-MOUNTED LIGHT FIXTURE. SEE ELECTRICAL PLANS
 - CEILING HEIGHT
 - X'-X" EXIT LIGHT - SEE ELECTRICAL PLANS

BUILDINGS 5 & 6 RENOVATIONS

San Mateo County Community College District

APPROVED
 DIV. OF THE STATE ARCHITECT
 AS PL. NO. 10188, DATE 5/22/10

CANADA COLLEGE
 4200 Farm Hill Boulevard
 Redwood City, CA 94061

THIRD FLOOR REFLECTED CEILING PLAN

Date: 08/29/08
 Scale: AS NOTED
 Project Number: 07013

Drawing Number: **A3.32**

THIRD FLOOR REFLECTED CEILING PLAN