

San Mateo County Community College District
3401 CSM Dr.
San Mateo, CA 94402

Subject: Skyline College Athletic Team Room Project
San Mateo County Community College District
SMCCCD Bid #
SMCCCD Project No.

Date: November 3, 2015

ADDENDUM NO. 1

CHANGES AND/OR CLARIFICATION'S OF THE DRAWINGS AND SPECIFICATIONS AS
FOLLOWS:


ITEM

- Item #1 **Grading and Utilities Plan, Sheet L5.0.** CHANGE: Length and connection points for both the sanitary sewer and domestic water lines have been modified to match with point of connections at new modular building. Refer to Drawing Attachments #1 and AD1-P1 for additional information.
- Item #2 **Layout and Material Plan, Sheet L6.0.** CLARIFICATION: New asphalt paving shown on layout and material plan shall extend to under the building as well and not just the outer edge of the building. Refer to Drawing Attachment #2 and #3 for additional information.

ELECTRICAL

ITEM

- Item #1 **Electrical Site Plan E1.1:**
1. Revise <E> panel "MCC3" to panel "N1A".
 2. Revise power pull box, panel "DP", transformer "TP" and modular panel "P" location to suit site layout.
 3. Added 2"C from <E> signal pull box next to the restroom bldg.. for data/EAS cabling.
 4. Revised sheet note 4.
- Item #2 **Electrical Plans and Wiring Diagrams E2.1:**
1. Electrical Plan - Revise panel "P" location.
 2. Tel/Data Wiring Diagram: Revise cable type C, added cable type D for EAS and note 3.
 3. Partial Single Line Diagram – Revise Panel "MCC3" to "N1A".

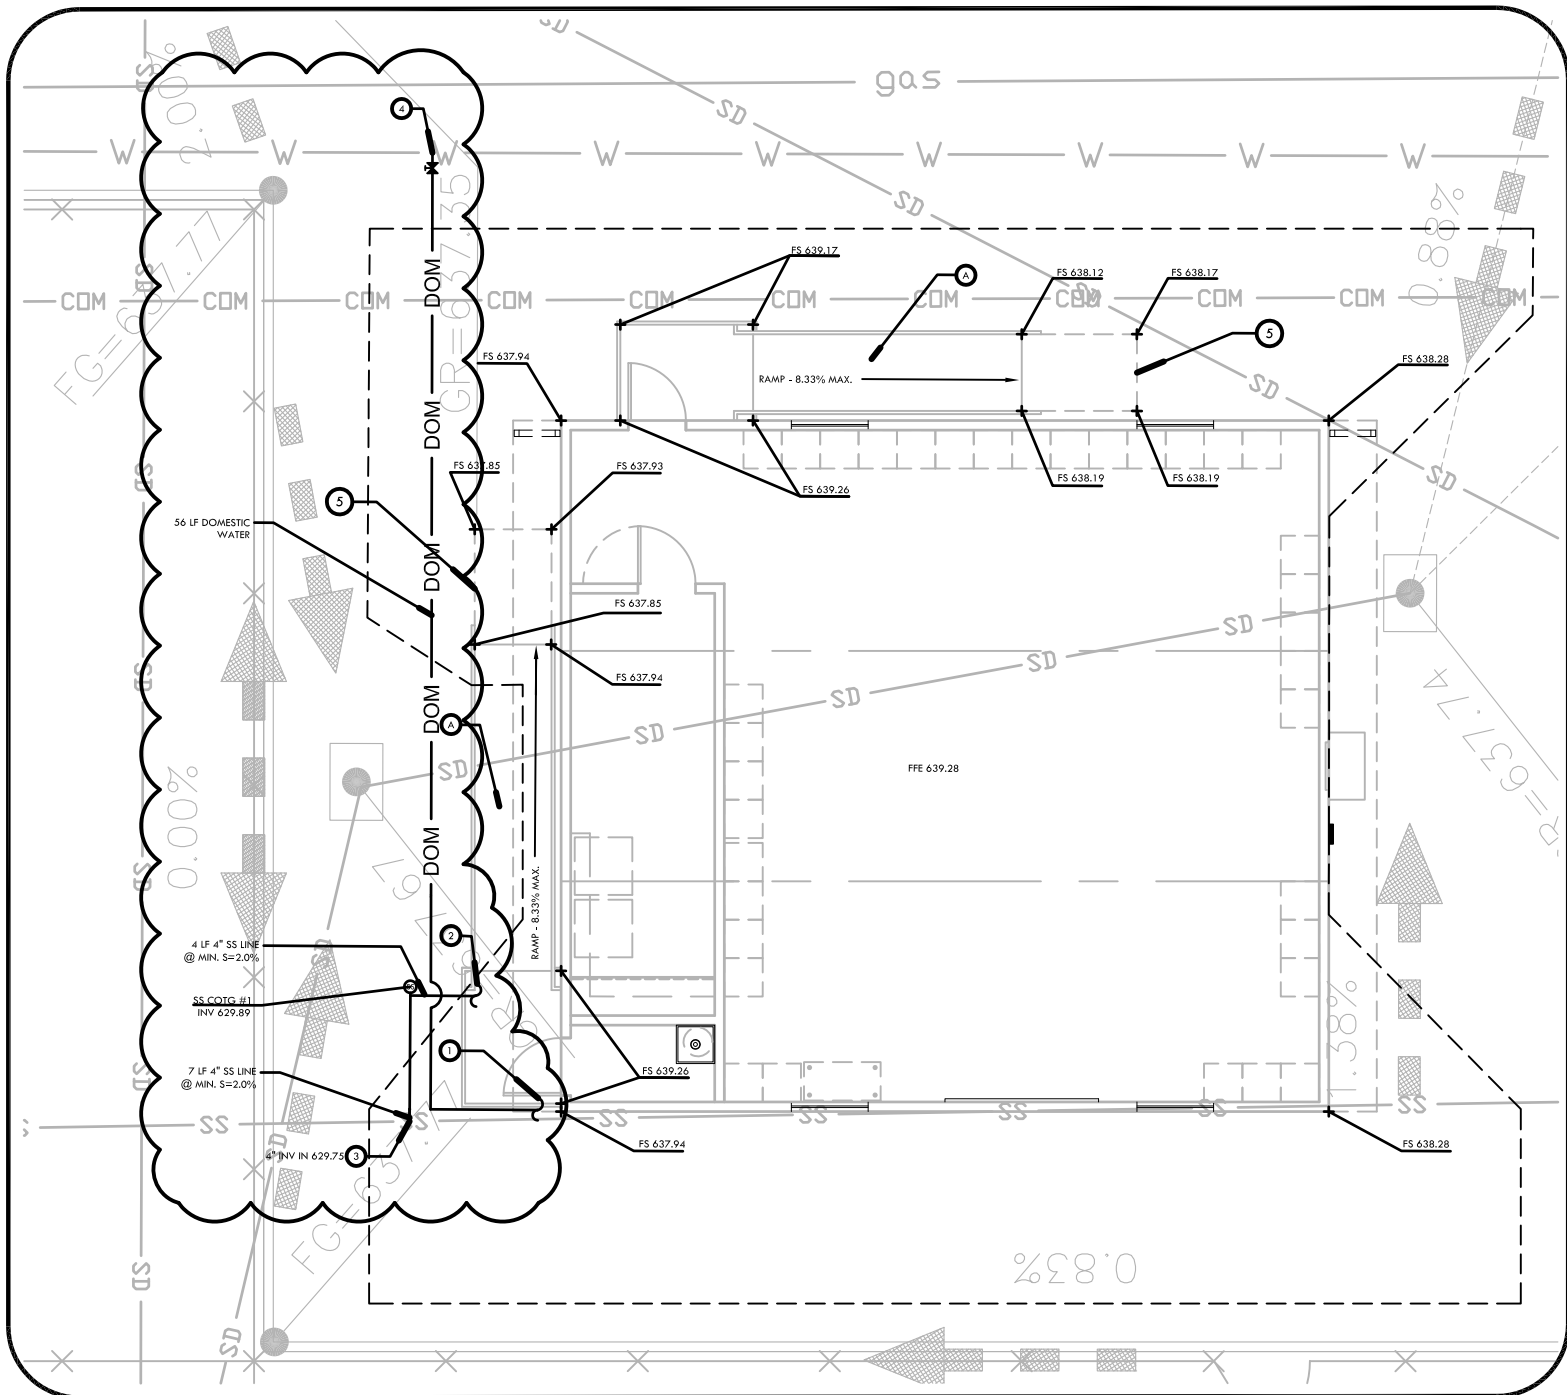

VERDE DESIGN
 LANDSCAPE ARCHITECTURE
 CIVIL ENGINEERING
 SPORT PLANNING & DESIGN
 2455 The Alameda, Ste. 200
 Santa Clara, CA 95050
 tel: 408.985.7200
 fax: 408.985.7260
 www.verdedesigninc.com

ADD# 01 - DRAWING ATTACHMENT
 Skyline College Athletic Team Rooms

Verde Project # 1312600


Date: 11/03/15

Checked By: DC

SCALE: NTS

DA#1



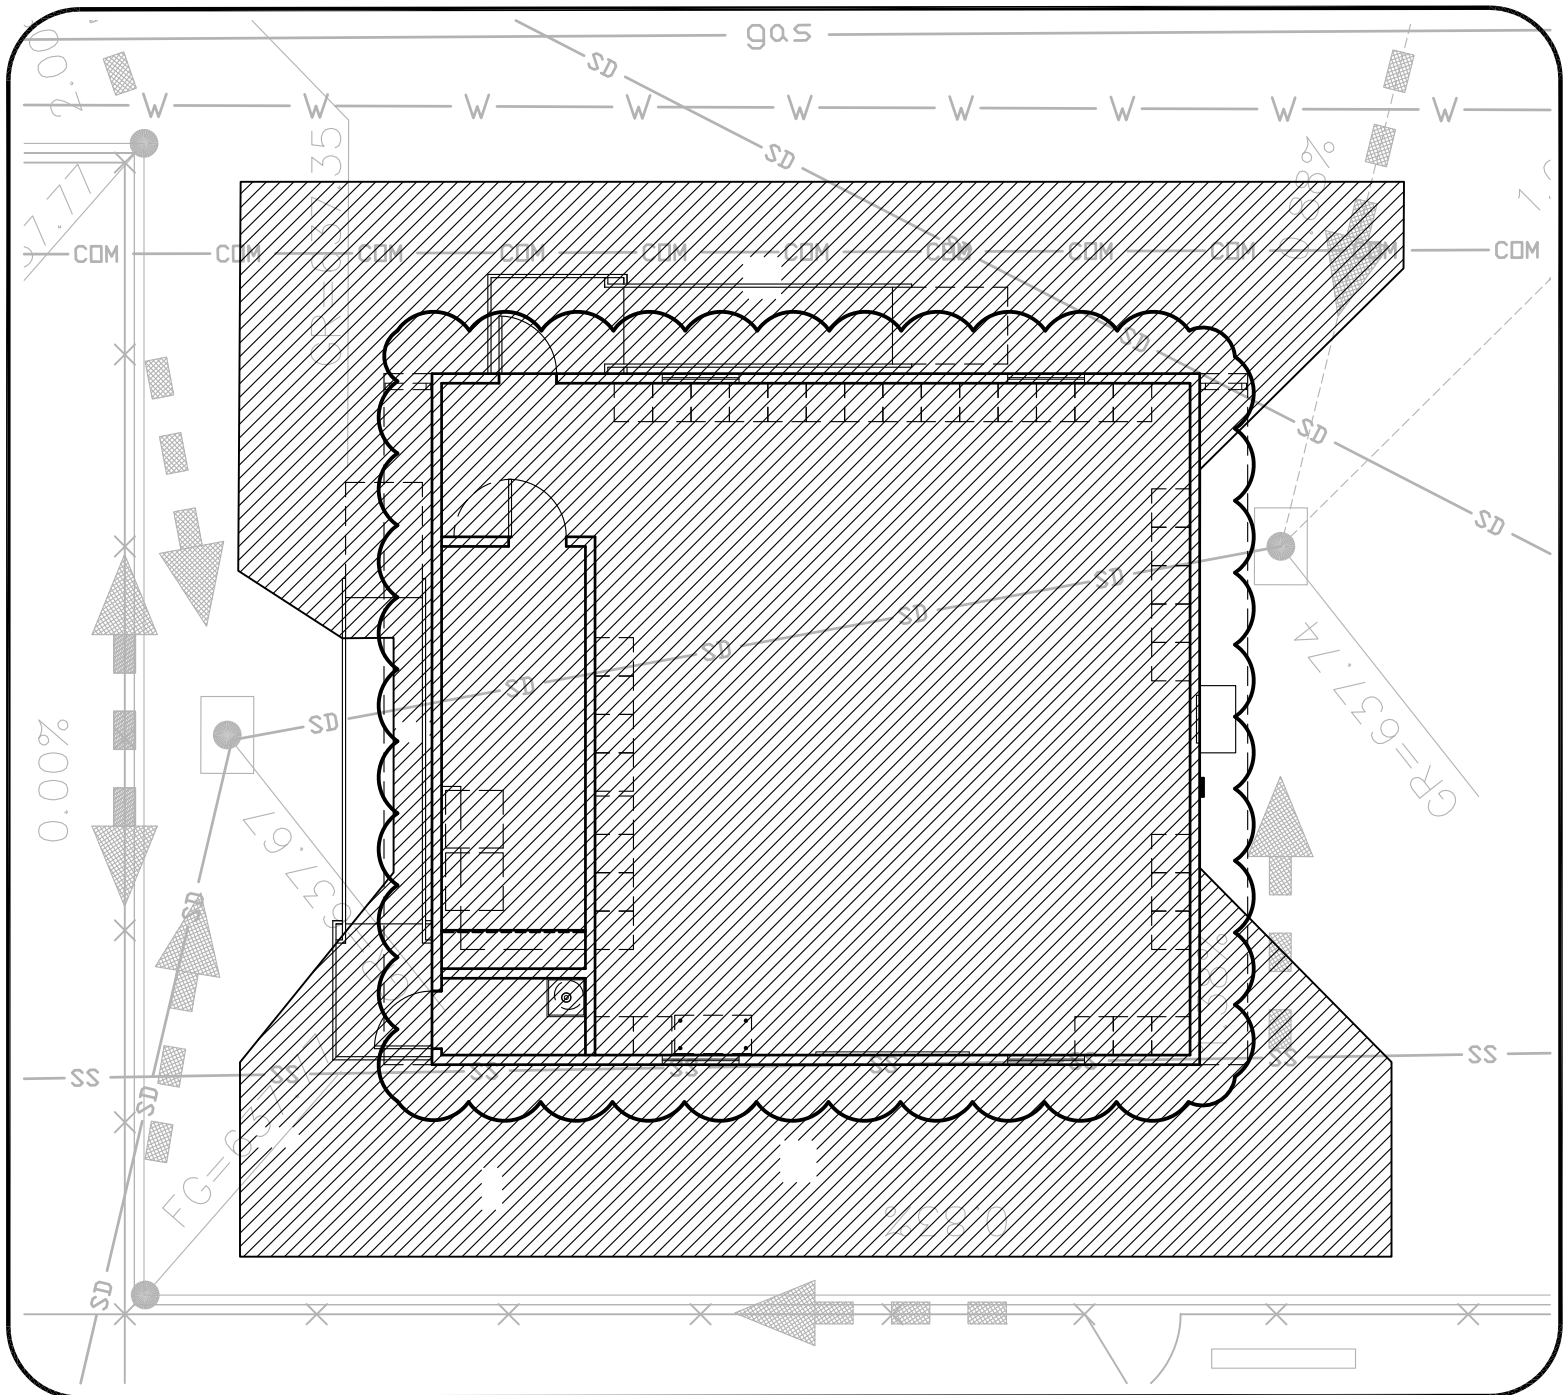

SHEET LEGEND

SYM	DESCRIPTION
	ASPHALT PAVING, REFER TO SPECIFICATIONS

ADD# 01 - DRAWING ATTACHMENT
 Skyline College Athletic Team Rooms

Verde Project # 1312600


Date: 11/03/15

Checked By: DC

SCALE: NTS

DA#2



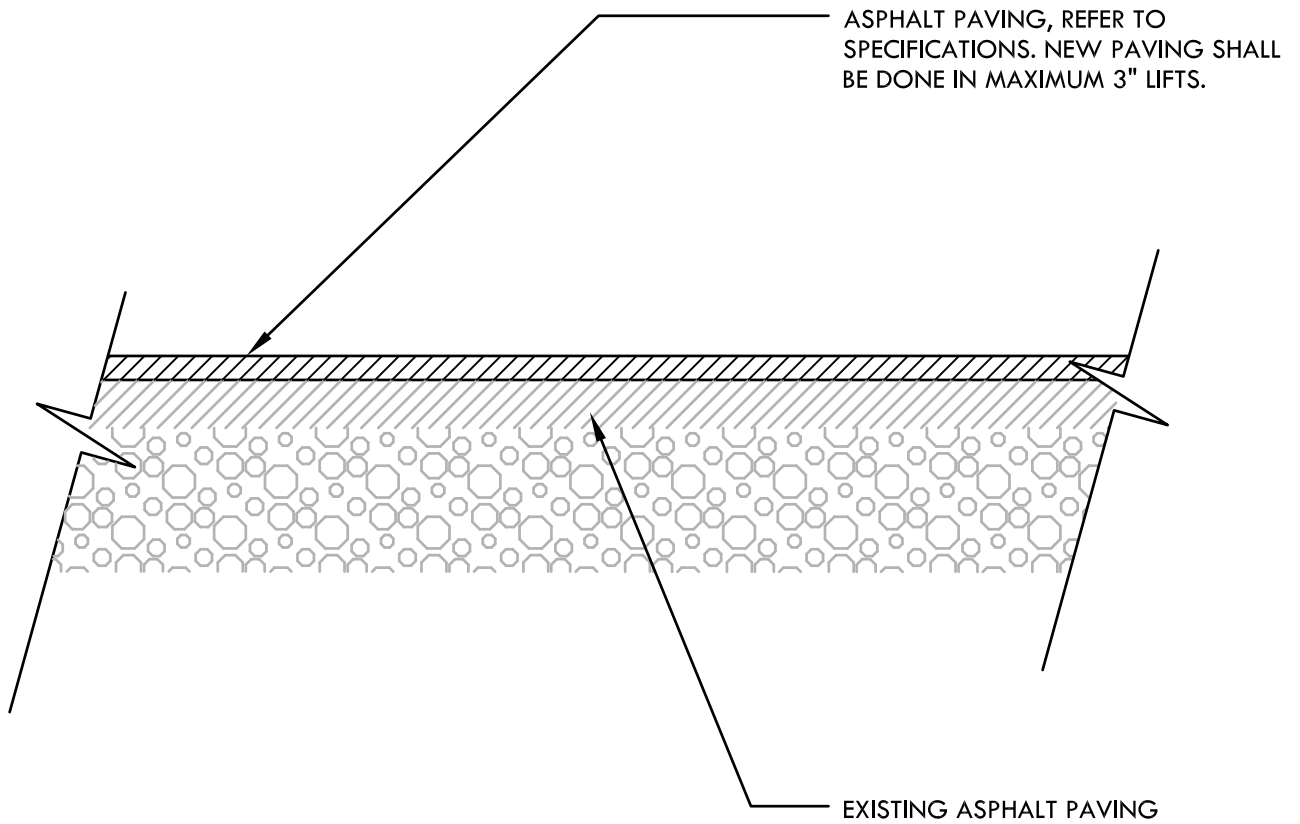

ASPHALT PAVING

NTS



ADD# 01 - DRAWING ATTACHMENT
 Skyline College Athletic Team Rooms

Verde Project # 1312600

Date: 11/03/15

Checked By: DC

SCALE: NTS

DA#3