



1 **BUILDING 16 AREA**
SCALE: 1" = 10'

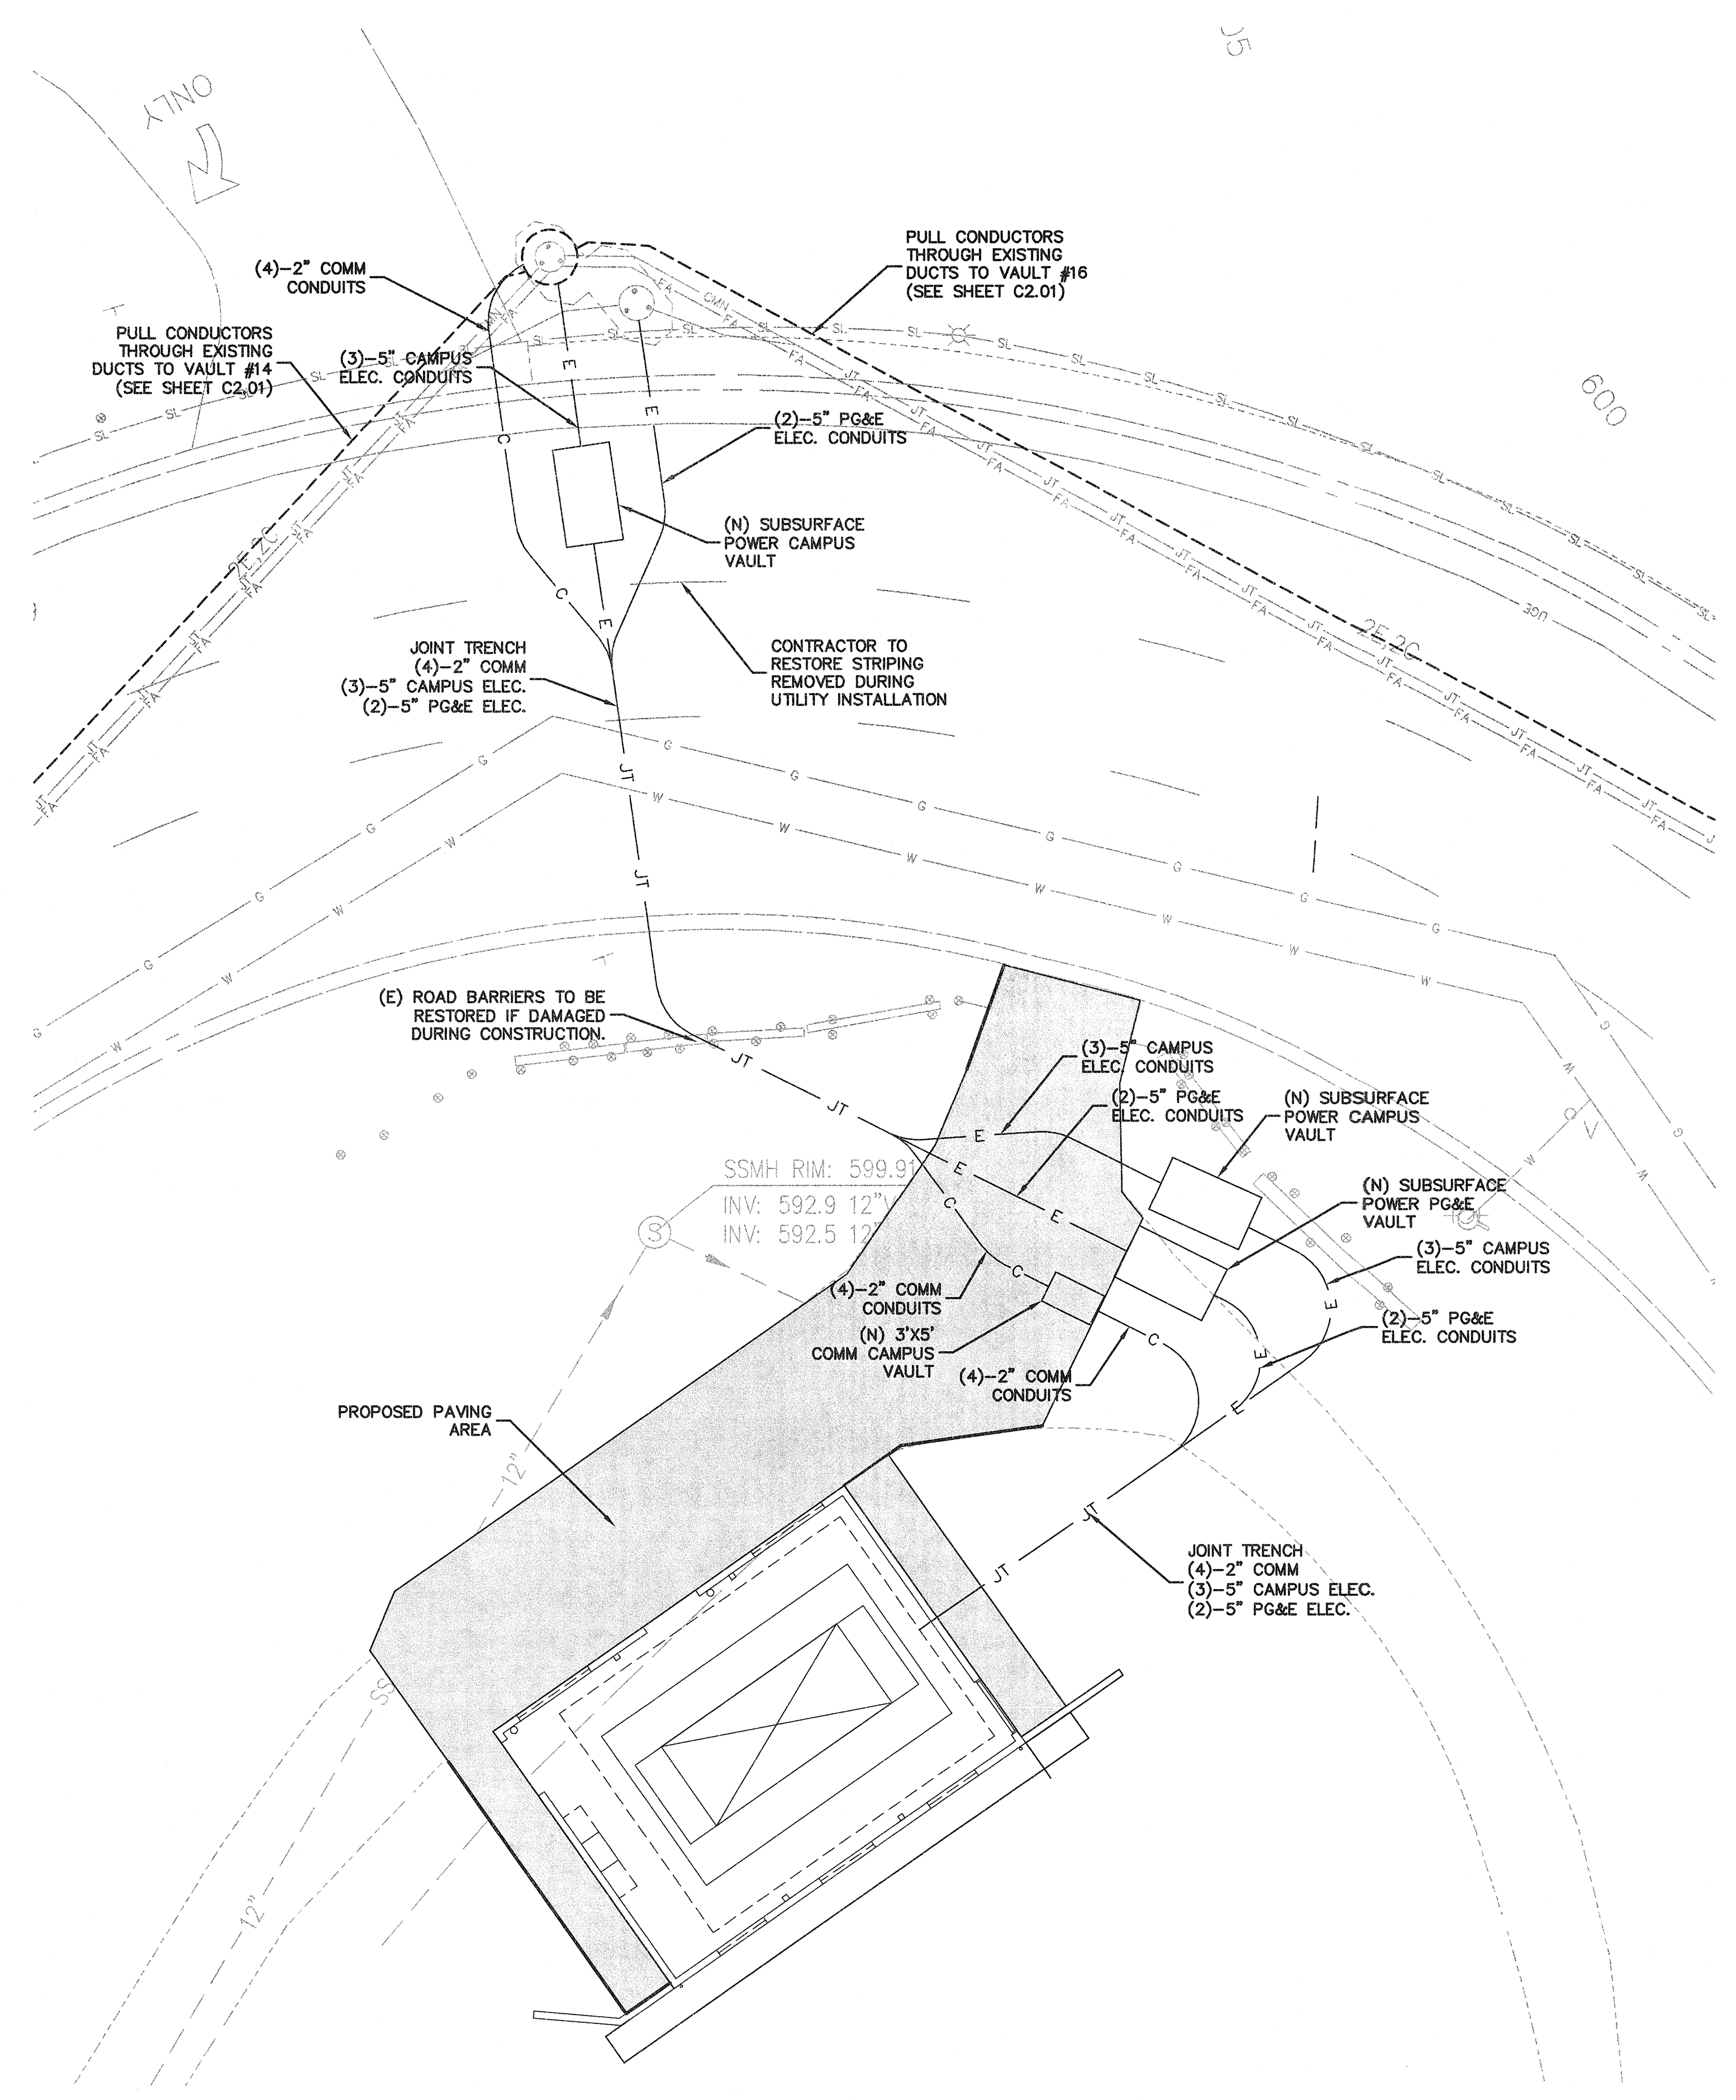


3 **(N) BUILDING 30 AREA**
SCALE: 1" = 10'

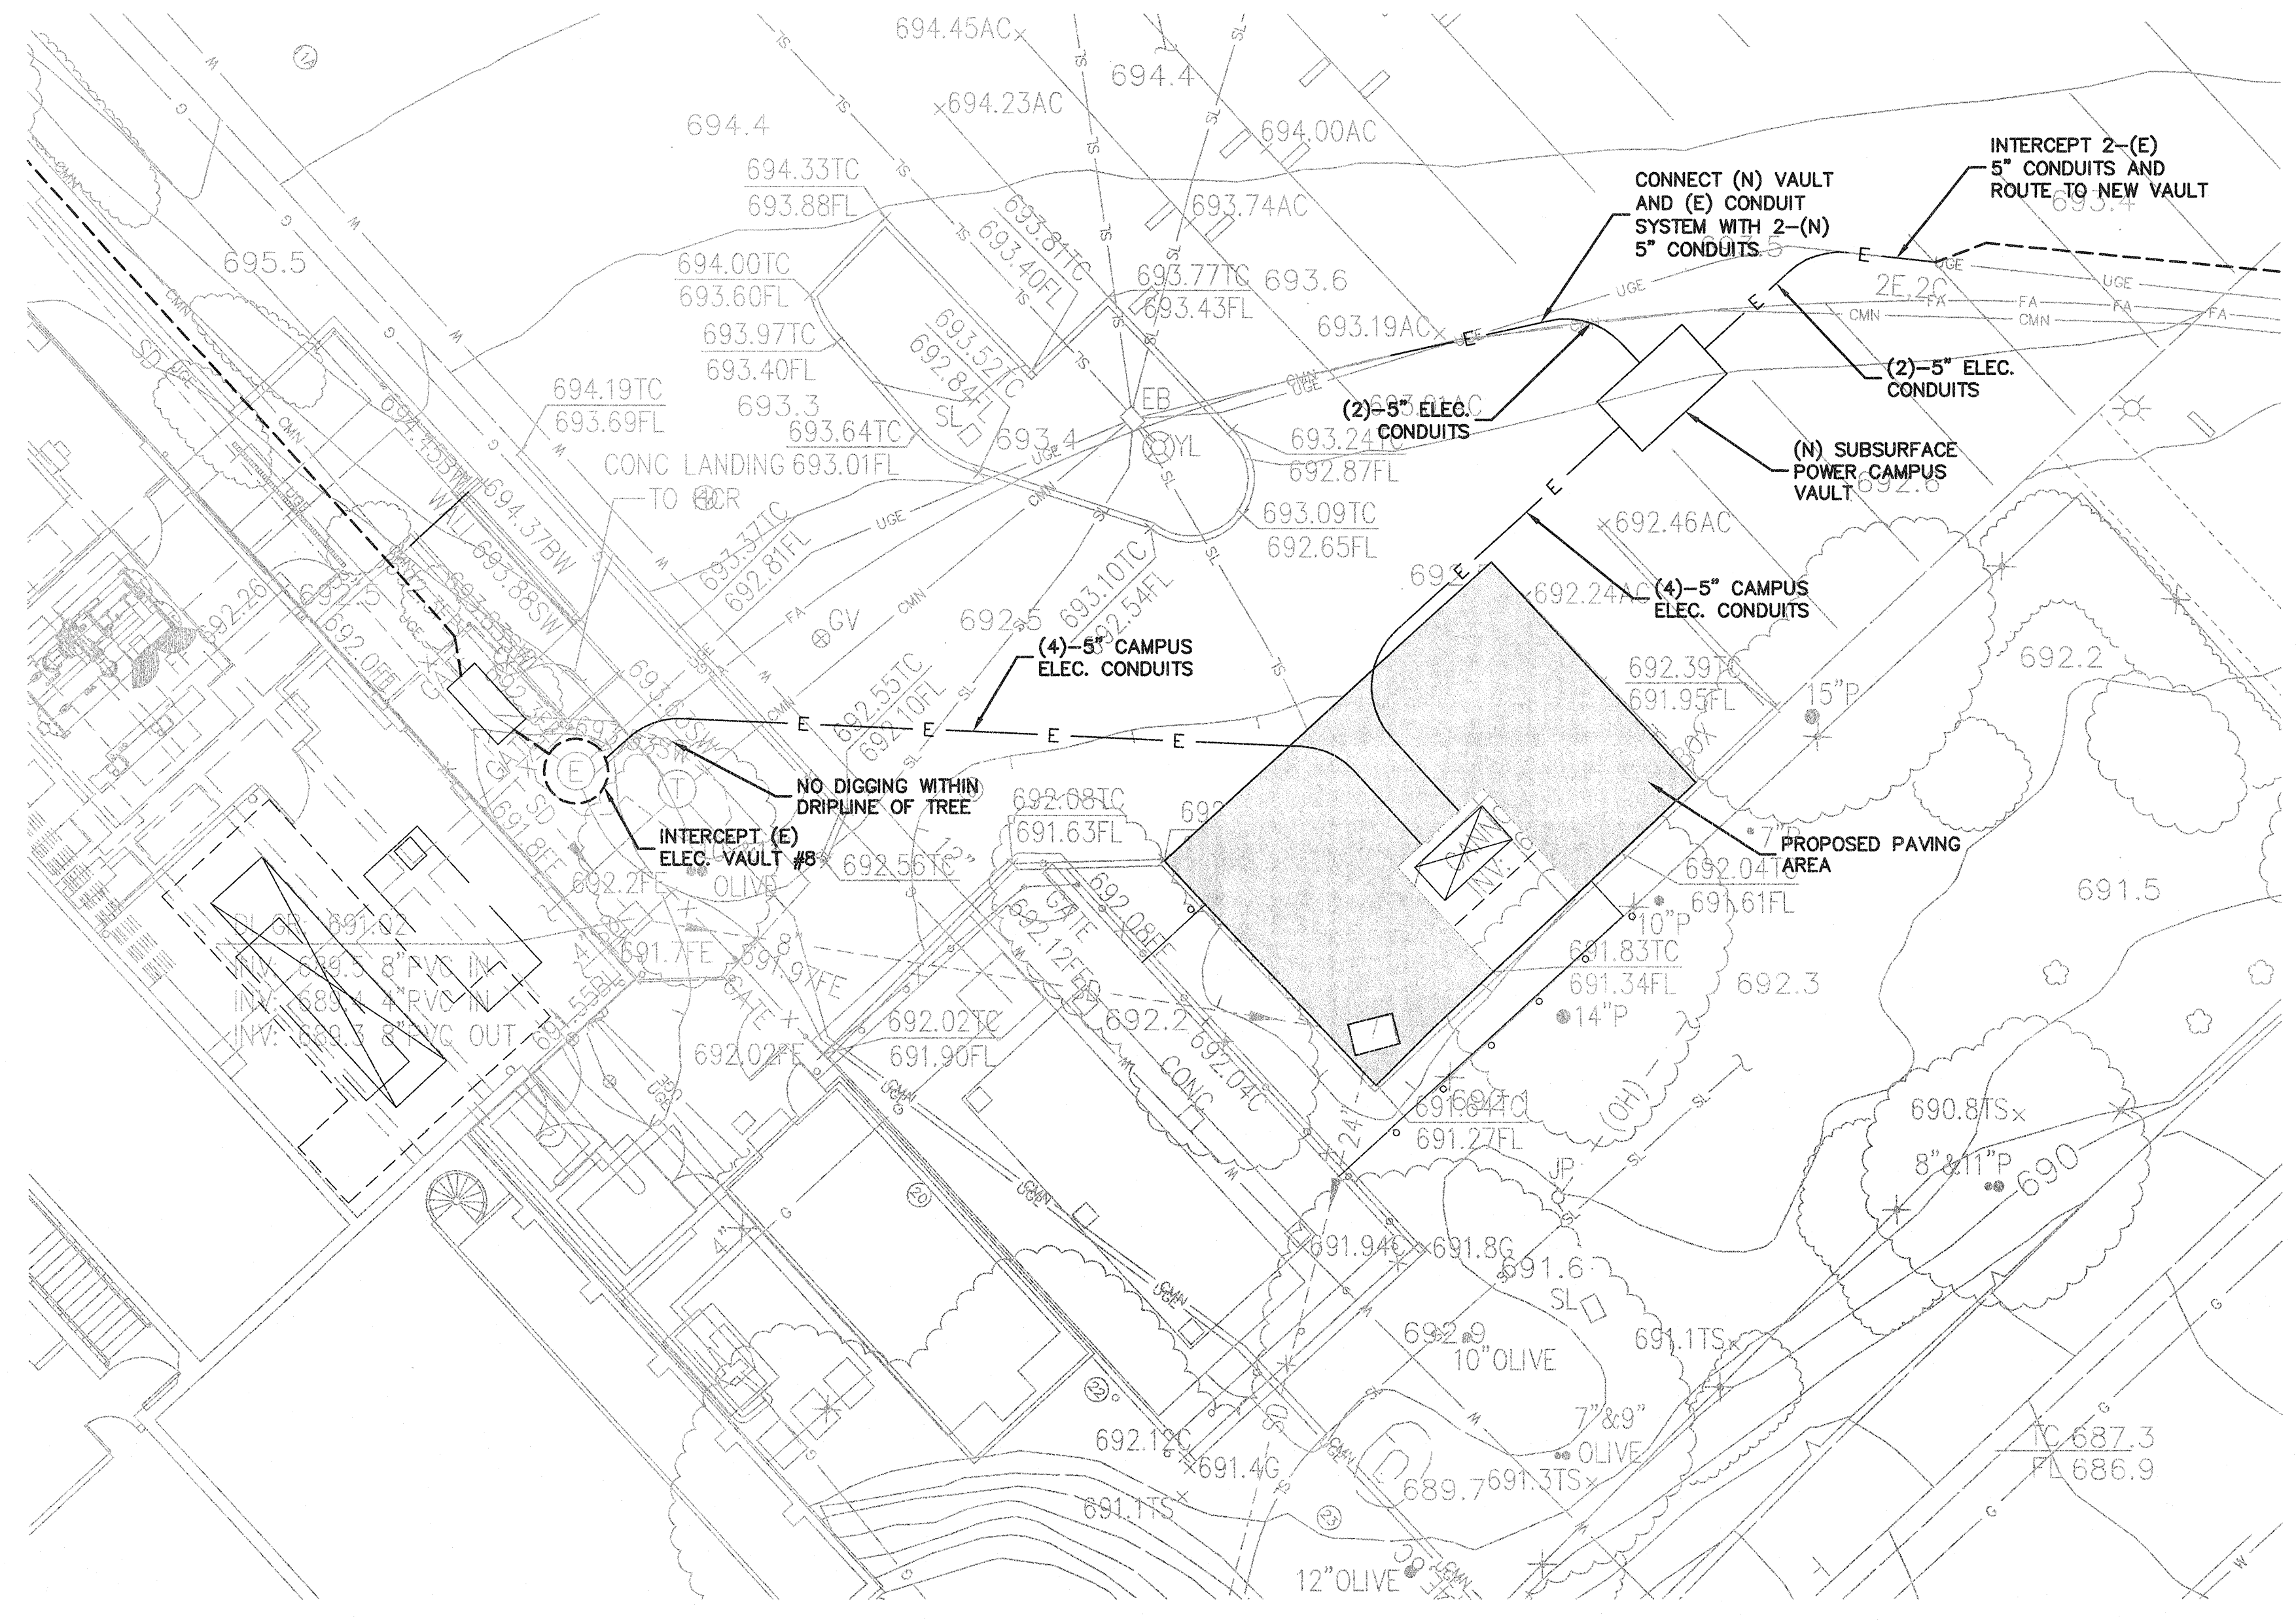

2 **BUILDING 3 AREA**
SCALE: 1" = 10'

LEGEND

- PULL THROUGH EXISTING CONDUIT
- E (N) ELECTRICAL TRENCH
- C (N) COMM TRENCH
- JT (N) JOINT TRENCH
- [Square] (N) FULL TRAFFIC ELECTRICAL VAULT
- [Square] (N) 3'x5' TRAFFIC RATED ELECTRICAL VAULT
- (E) ELECTRIC VAULT TO BE PULLED THROUGH

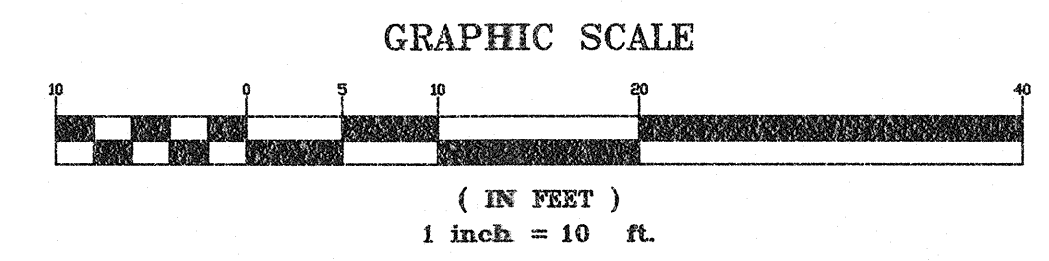

IDENTIFICATION STAMP
DIVISION OF THE STATE ARCHITECT
APPLICATION NUMBER: 111618
AC: [Signature] FLS: [Signature] [Signature]
DATE: 2/9/11

CALIFORNIA STATE FIRE MARSHAL
APPROVED

APPROVAL OF THIS PLAN DOES NOT CONSTITUTE AN APPROVAL OR OPINION OF THE ENGINEER OR ARCHITECT AS TO THE ACCURACY OR COMPLETENESS OF THE INFORMATION PROVIDED BY THE CLIENT. THE USER OF THIS PLAN SHALL BE RESPONSIBLE FOR OBTAINING ALL NECESSARY PERMITS AND FOR OBTAINING ALL NECESSARY APPROVALS FROM THE APPROPRIATE AGENCIES. THE USER OF THIS PLAN SHALL BE RESPONSIBLE FOR OBTAINING ALL NECESSARY APPROVALS FROM THE APPROPRIATE AGENCIES. THE USER OF THIS PLAN SHALL BE RESPONSIBLE FOR OBTAINING ALL NECESSARY APPROVALS FROM THE APPROPRIATE AGENCIES.

CAÑADA COLLEGE
Electrical
Infrastructure
Replacement
Project
4200 Farm Hill Blvd
Redwood City, CA 94061

BID SET

SHEET TITLE
ENLARGED UTILITY PLAN

REVISIONS		
NO.	DATE	DESCRIPTION

DATE: January 14, 2011
DRAWN: ESS
CHECKED: RCS
SCALE: 1" = 10'
JOB NO.: 2921.01

SHEET NUMBER
C2.03