


3 SPIRAL DUCT PENETRATION DETAIL

NO SCALE

3
M5.04


NOTES:

1. ALL BLOCKING AROUND ROOF OPENING IS TO TAKE PLACE ABOVE THE ROOF. SEE STRUCTURAL DRAWINGS FOR REQUIRED MODIFICATIONS.
2. FILL ALL CORNERS, ALL JOINTS AND SEAMS IN FLASHING AND COUNTERFLASHING ARE TO BE SOLDERED WATERTIGHT.

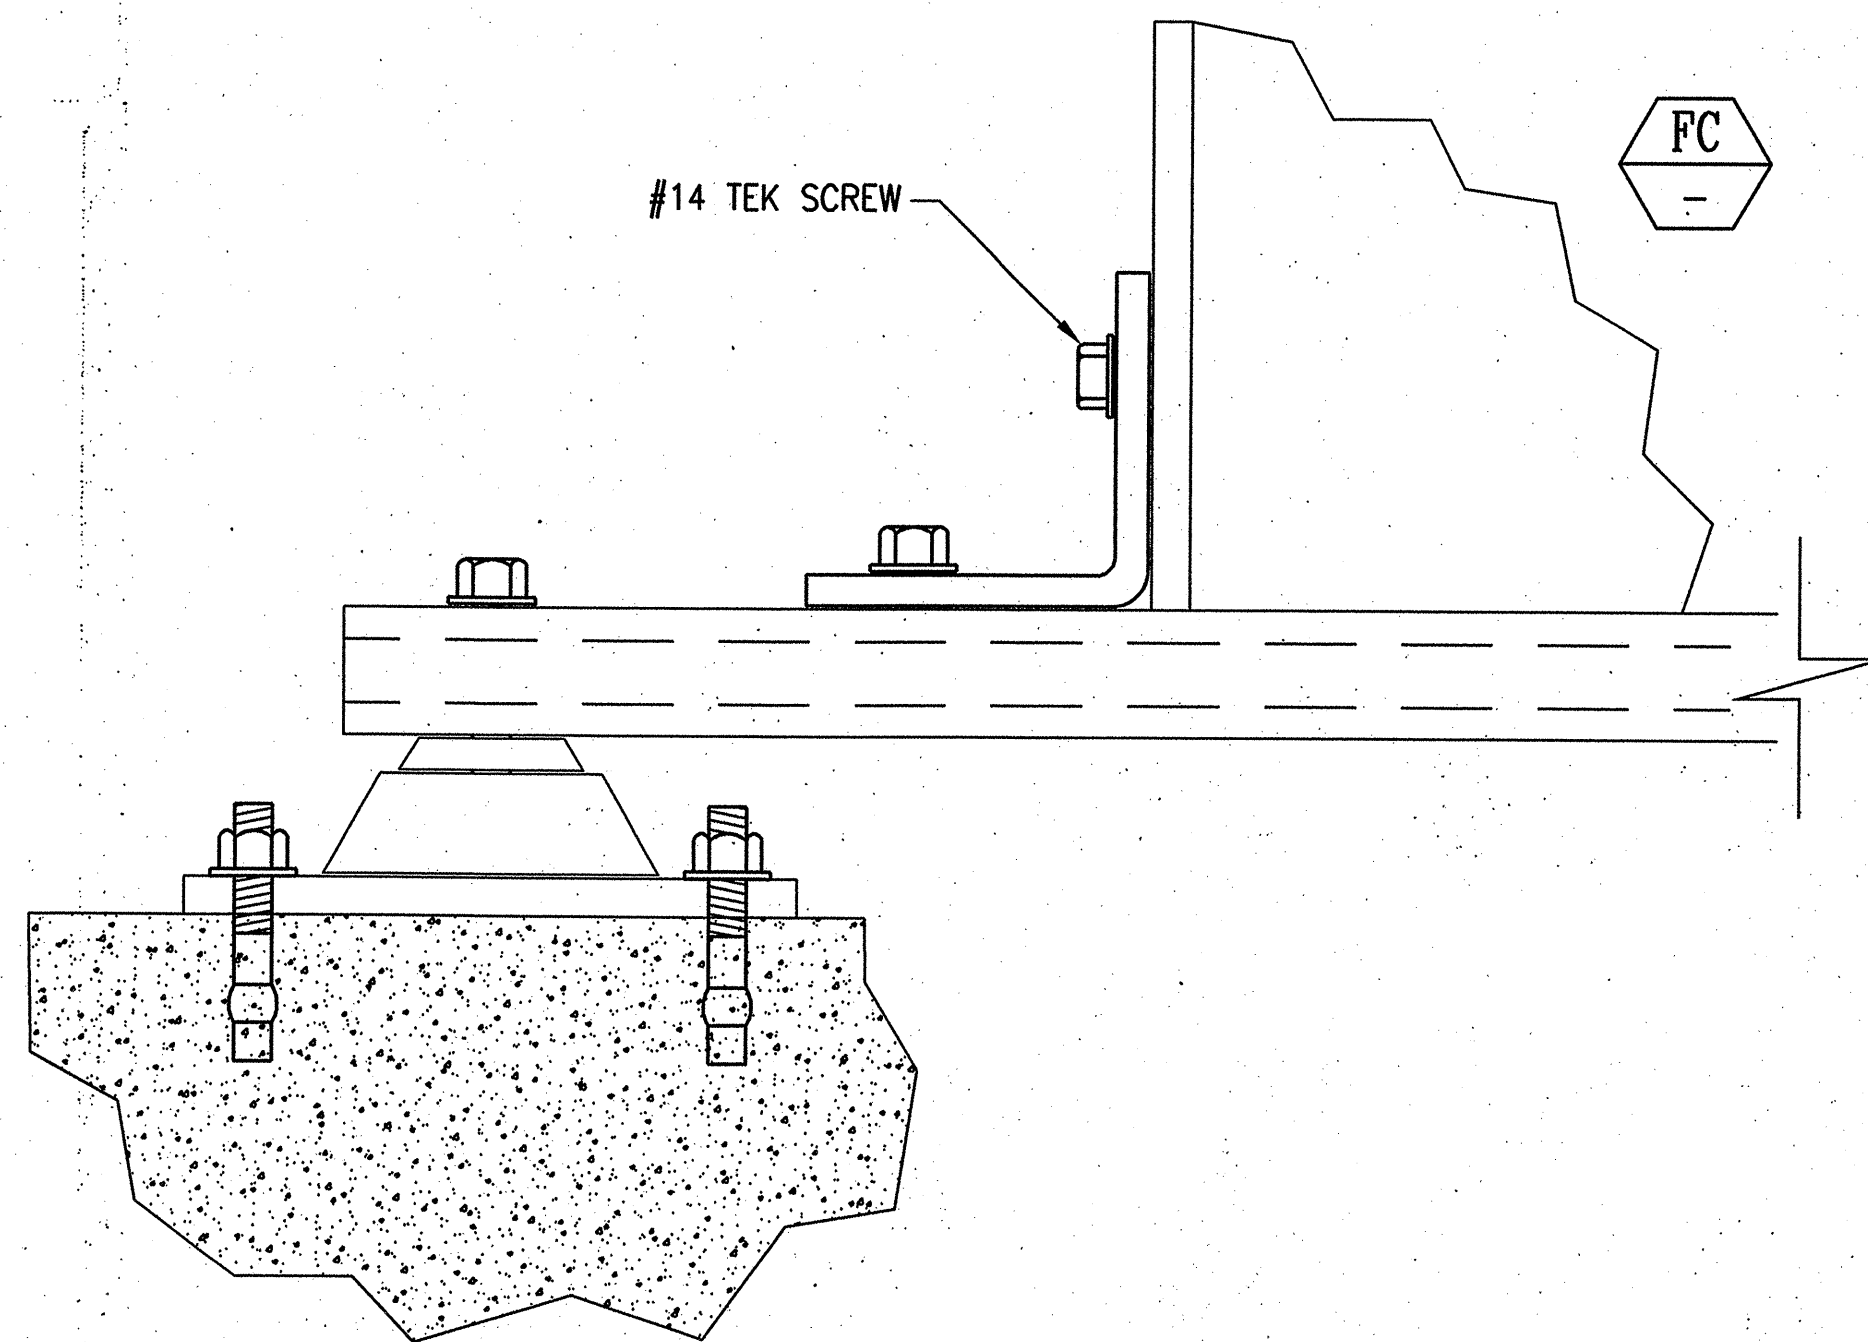

5 UNIT MOUNTING DETAIL

SCALE: NONE

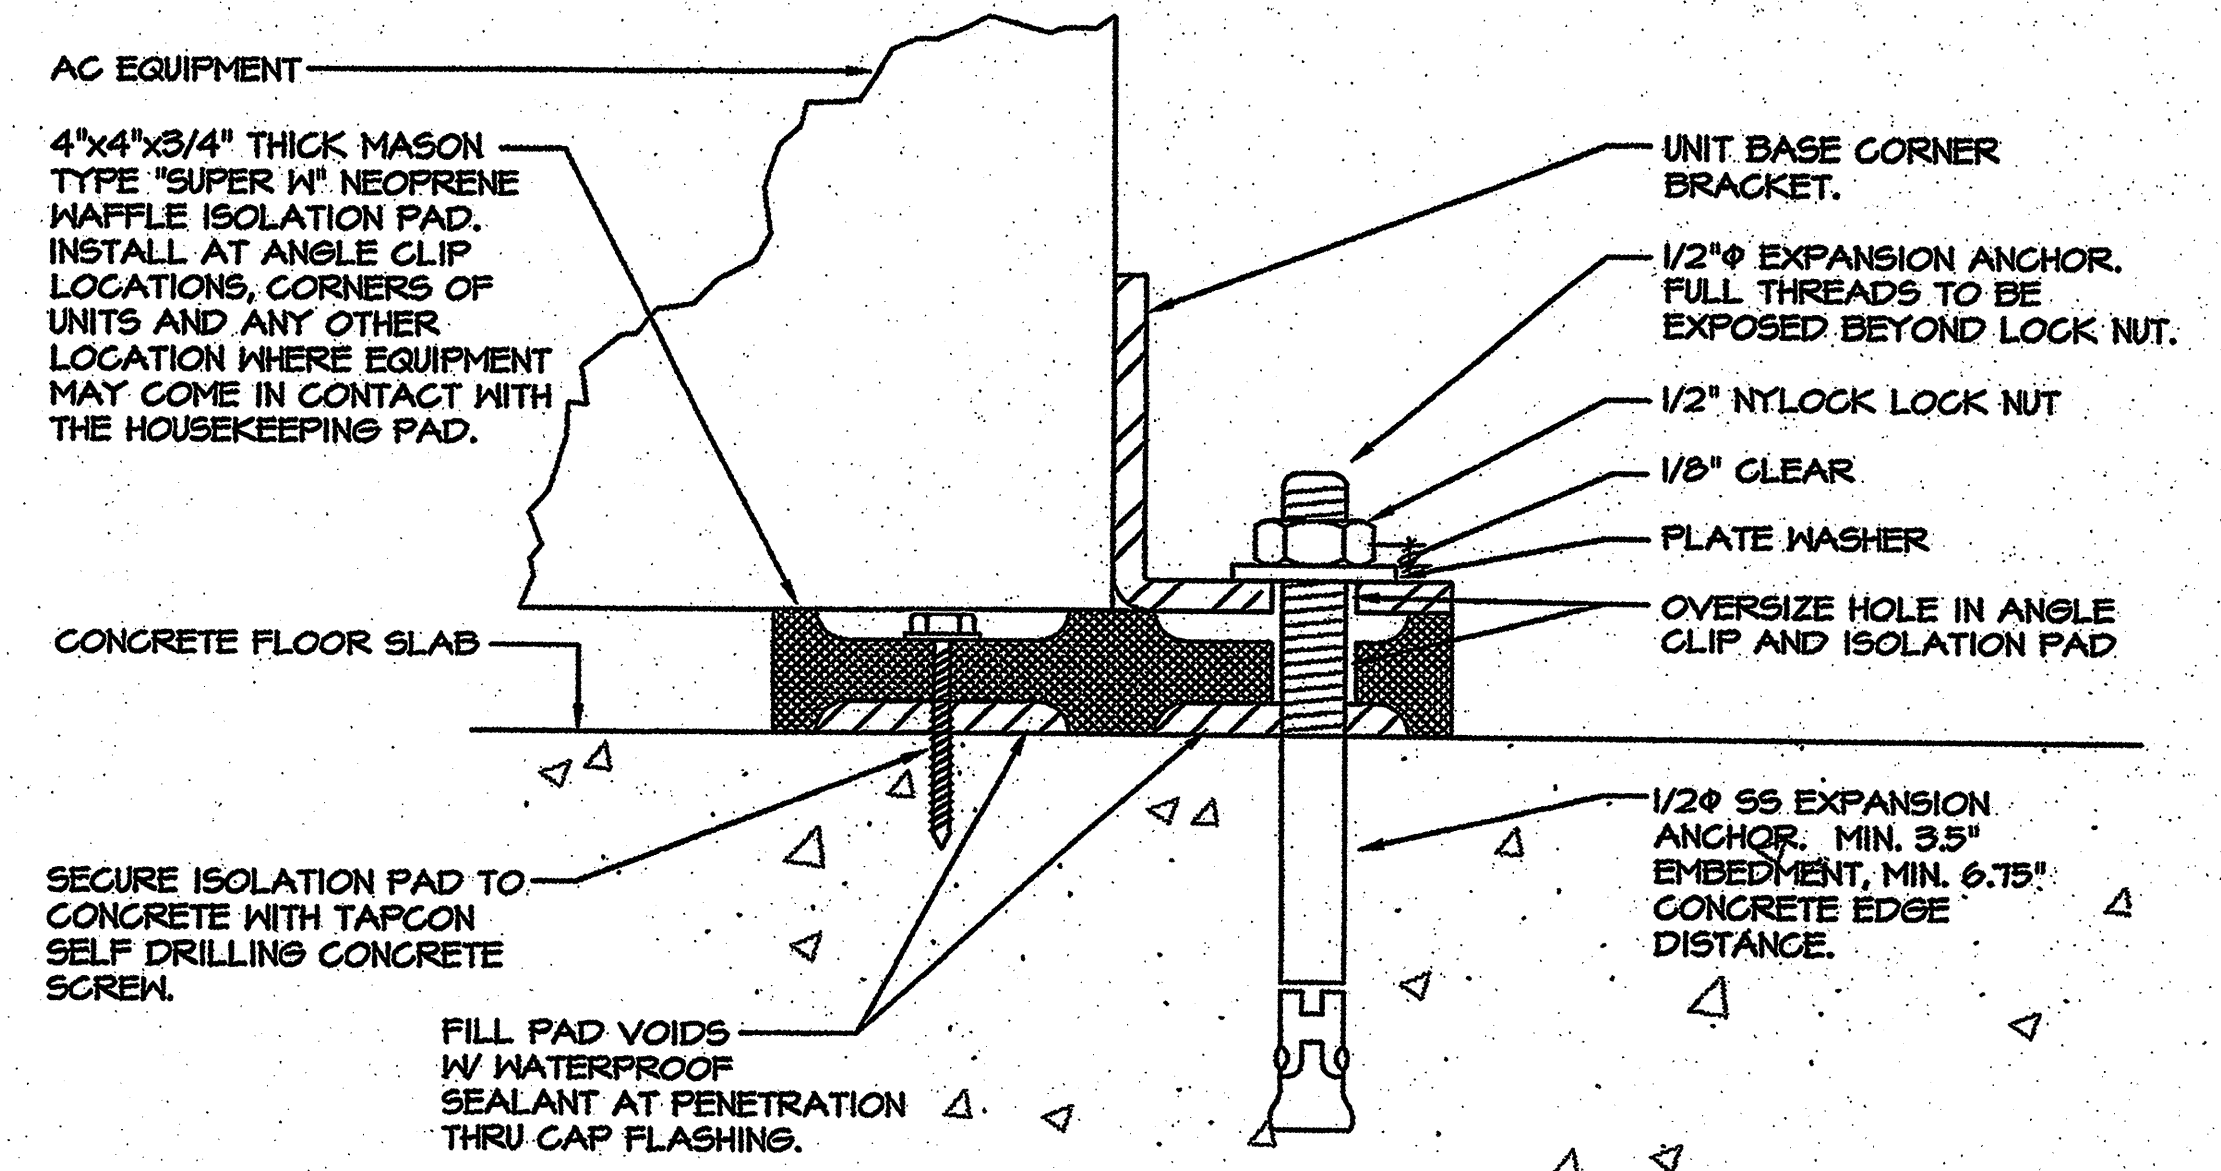

1 UNIT ATTACHMENT DETAIL

NO SCALE


1
M5.04

acco engineered systems
 1133 ALADDIN AVE
 SAN LEANDRO, CALIFORNIA 94577
 (510) 346-4300

626403 M0.01.DWG RC RISE
 Job Number Filename Drawn By Project Mgr
 88519

RECORD DRAWING District Contract #
 Contractor's Signature

DATE: 02-01-07

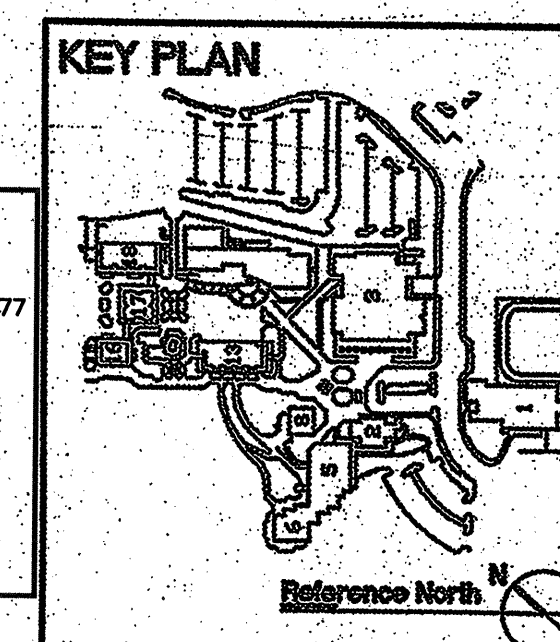

ARCHITECT OF RECORD
noll & tam
 architects and planners

729 Heinz Avenue
 Berkeley, CA 94710
 510.649.8295
 fax 510.649.3006

CONSULTANTS

McCracken & Woodman
 INCORPORATED
 Consulting Mechanical Engineers
 355 Grand Avenue, Oakland, California 94610
 Telephone (510) 763-4891 Fax (510) 763-0619



IDENTIFICATION STAMP
 DIVISION OF THE STATE ARCHITECT
 FILE NUMBER: 4-01
 APPLICATION NUMBER: 01-0001
 AC: [Signature] DATE: 4/14/06

BID DOCUMENTS

CAÑADA COLLEGE
 BUILDING 16, 17, 18
 RENOVATION
 SMCCCD
 3401 CSM Drive
 San Mateo, CA 94402
 Cañada College
 4200 Farm Hills Blvd.
 Redwood City, CA 94061

SHEET TITLE
MECHANICAL DETAILS

REVISIONS		
NO.	DATE	DESCRIPTION
1	02/01/07	RECORD SET

DATE: MARCH 1, 2006
 DRAWN: JP
 CHECKED: BC
 SCALE: AS NOTED
 N&T JOB NO.: 2220.07

SHEET NUMBER

M5.04