


DOMESTIC WATER & GAS PLAN
SCALE: 1/4" = 1'-0"

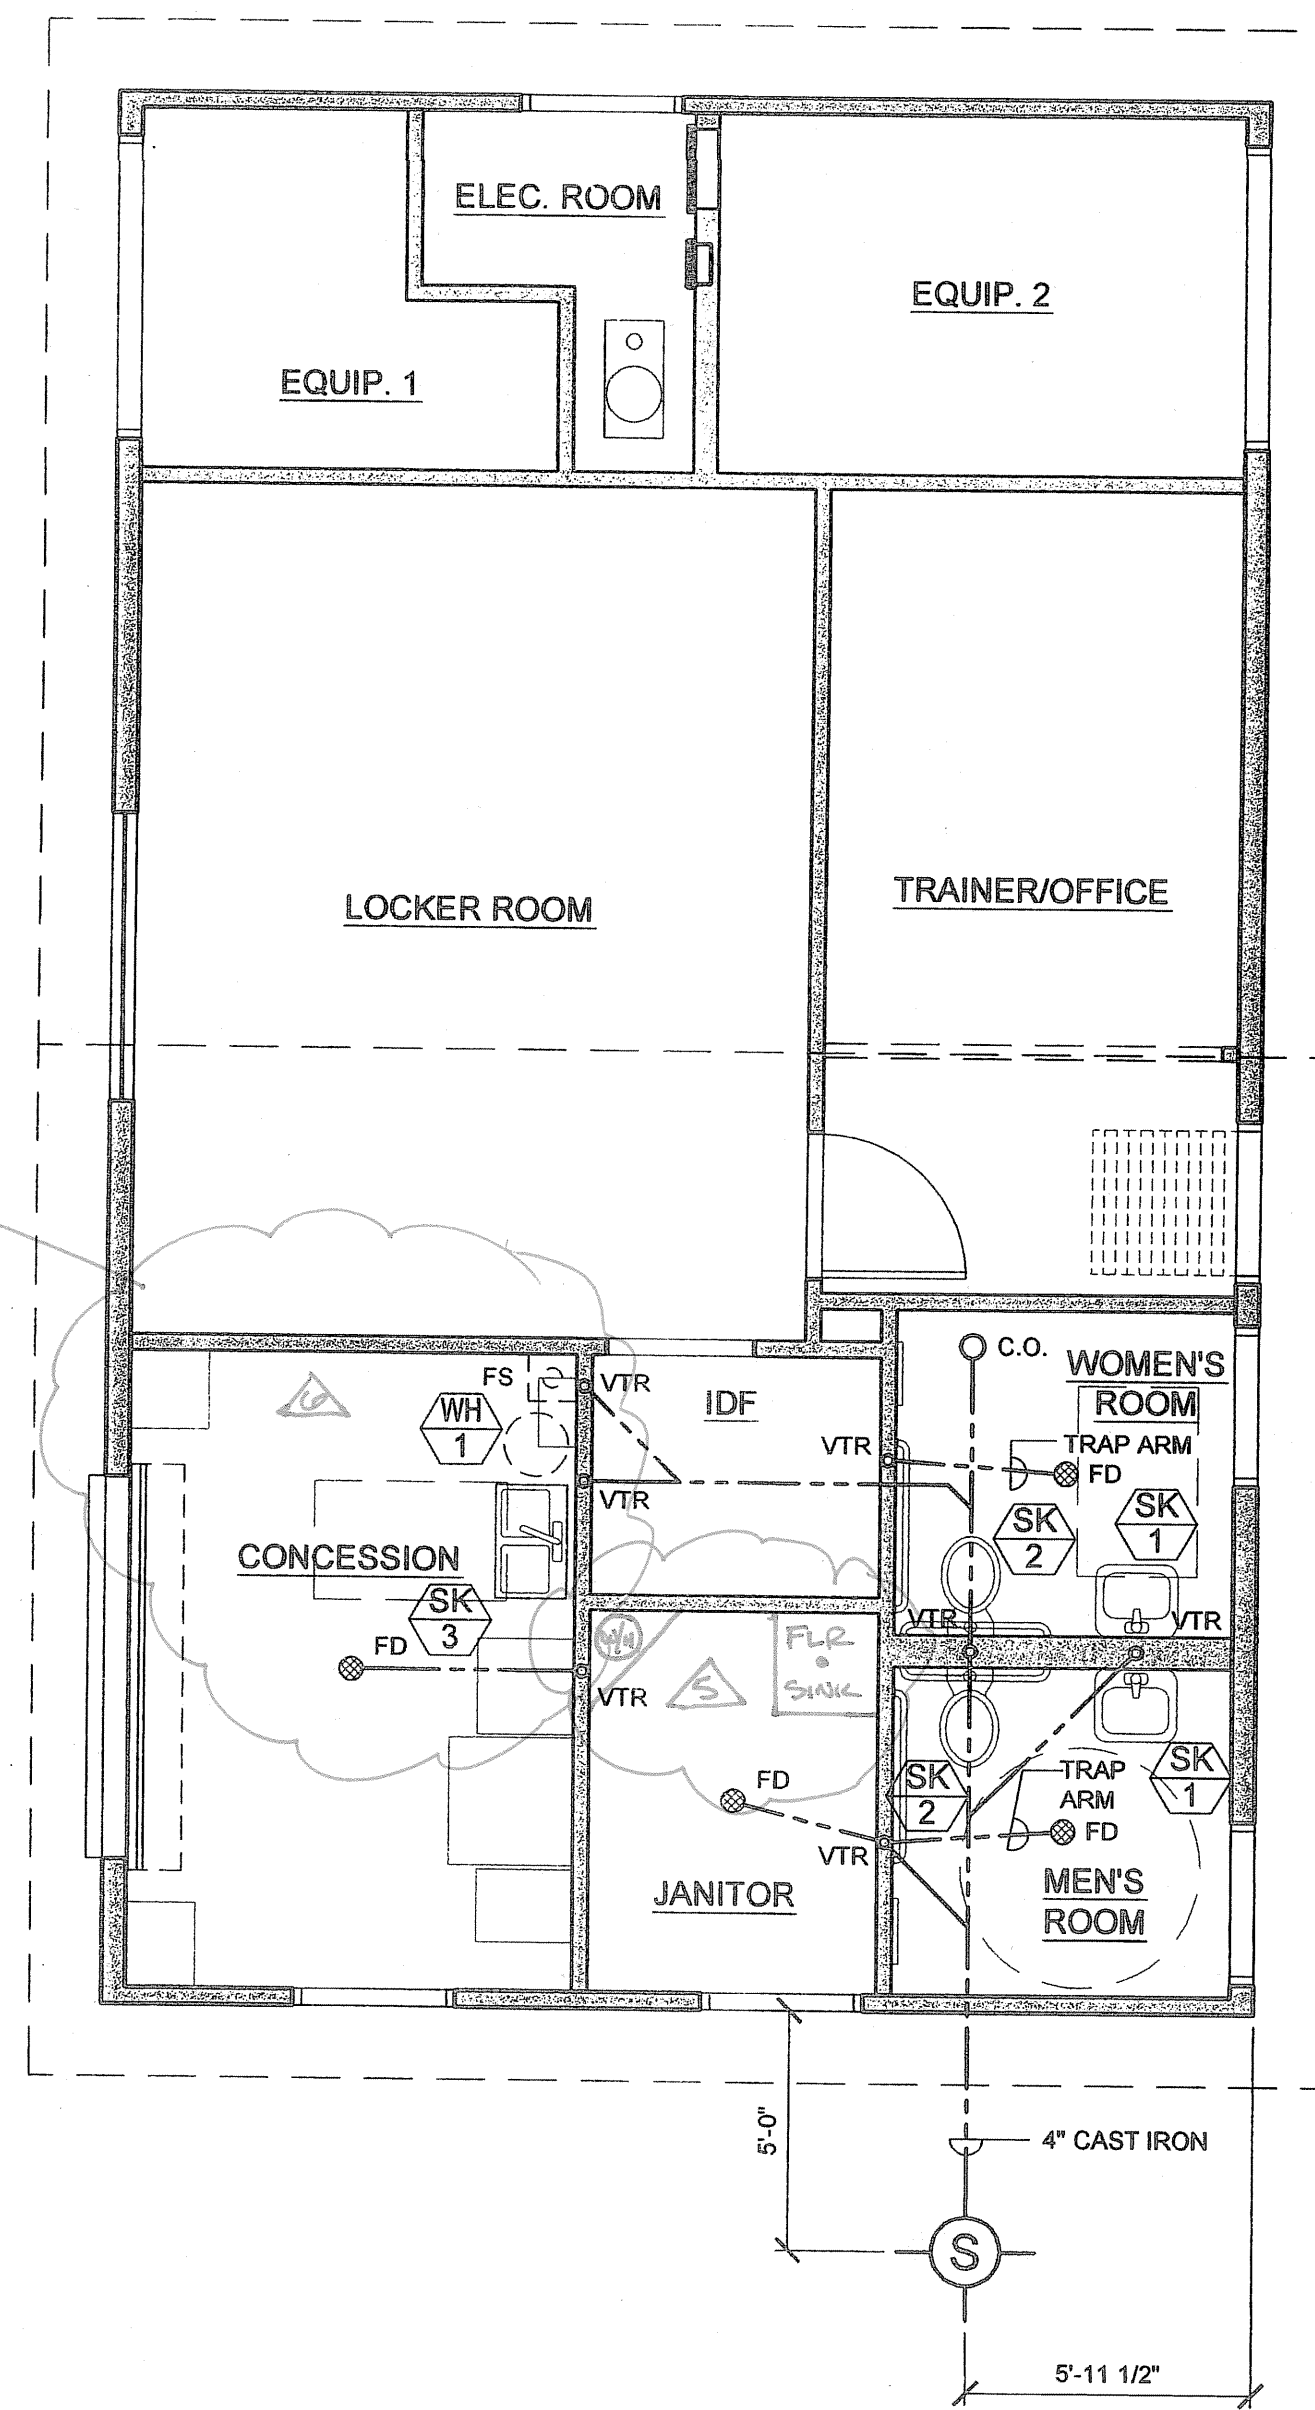

SEWER PLAN
SCALE: 1/4" = 1'-0"

▲ CHANGED WATER P.O.C. & ADDED VALVE & REDUCERS.
 ▲ ADDED DRINKING FOUNTAINS.
 ▲ HOSE BIBB RELOCATE.
 ▲ DELETED GAS P.O.C. (ELECTRIC FURNACE UNIT USED)
 ▲ RELOCATE WATER HEATER ABOVE CEILING, & ADD FLOOR SINK
 ▲ FLOOR PLAN CHANGE. SEE SH1 F.O. #5-#7 DETAILS AT
 END OF THIS SET. (AS BUILTS)

GENERAL NOTES:

- EXISTING SEWER & WATER LINES TO BE FIELD VERIFIED.
- POINTS OF CONNECTION FOR SEWER & WATER ARE DIAGRAMATIC. ACTUAL POINTS OF CONNECTION MAY VARY FROM WHAT IS SHOWN IN THIS DRAWING; ADJUST ALIGNMENT OF UTILITIES INTO THE BUILDING ACCORDINGLY.
- PROVIDE CONNECTION TO FIXTURES AS PER MANUFACTURERS RECOMMENDATIONS *4.
- FLOOR DRAIN GRATING TO BE FLUSH WITH ALL OPENINGS

| PLUMBING FIXTURE SCHEDULE | | |
|---------------------------|----------------------|---|
| MARK | DESCRIPTION | REMARKS |
| SK 1 | WALL-HUNG LAVATORY | AMERICAN STANDARD BARRIER FREE LUCERNE WALL-HUNG LAVATORY - MODEL 0355.012 |
| SK 2 | WALL-HUNG TOILET | AMERICAN STANDARD BARRIER FREE AFWALL ELONGATED FLUSH VALVE TOILET - MODEL |
| SK 3 | ADA DOUBLE-BOWL SINK | STYLIST GROUP ADA COMPLIANT DLA-ADA-SERIES-A-18GA. |
| WH 1 | WATER HEATER | PATRIOT ELECTRIC POINT-OF-USE 6 GAL. WATER HEATER MIDGET MODEL LDE-6-10MS-E (STRAP TO WALL) |

LEGEND:

- SANITARY SEWER, SIZE AS FOLLOWS (U.O.N)
 PROVIDE 2" SERVICE FROM LAVATORY TO MAIN
 PROVIDE 2" SERVICE FROM FLOOR DRAIN TO MAIN
 PROVIDE 2" SERVICE FROM DRINKING FOUNTAIN TO MAIN
 PROVIDE 2" SERVICE FROM URINAL TO MAIN
 PROVIDE 3" SERVICE FROM WATER CLOSET TO MAIN
- VENT, SIZE PER 1997 UBC
- DOMESTIC COLD WATER, SIZE AS FOLLOWS (U.O.N)
 PROVIDE 1/2" SERVICE TO DRINKING FOUNTAIN FROM MAIN
 PROVIDE 1/2" SERVICE TO LAVATORY FROM MAIN
 PROVIDE 3/4" SERVICE TO URINAL FROM MAIN
 PROVIDE 1" SERVICE TO WATER CLOSET FROM MAIN
- W DOMESTIC COLD WATER - POINT OF CONNECTION
- S SANITARY SEWER - POINT OF CONNECTION
- G GAS - POINT OF CONNECTION
- WH WATER HEATER BELOW COUNTER
- FD FLOOR DRAIN
- VTR VENT THROUGH ROOF
- C.O. CLEAN-OUT
- DWN PIPE DOWN FROM ATTIC
- HB HOSE BIB BOX
- FS FLOOR SINK

| REVISIONS | |
|-----------|--|
| | |
| | |
| | |
| | |
| | |

COPYRIGHT © 2003
 SARAMARK, INCORPORATED
 THESE PLAN DRAWINGS ARE PROPRIETARY DOCUMENTS OF SARAMARK, INCORPORATED & ARE NOT TO BE DISTRIBUTED, PUBLISHED OR REPRODUCED WITHOUT THE WRITTEN CONSENT OF SARAMARK INCORPORATED.

EC CONSULTING GROUP
 1250 AVIATION AVE
 SUITE 200-F
 SAN JOSE, CA 95110
 TEL: (408) 294-8510

COLLEGE of SAN MATEO
 SAN MATEO UNIFIED SCHOOL DISTRICT

SARAMARK INCORPORATED
 SERIES 4024AX
 PC 01-108848
 P.O. BOX 24399
 SAN JOSE, CALIFORNIA 95154
 TEL: (408) 971-3821
 FAX: (408) 971-3534

BUILDING A TEAM ROOM PLUMBING PLAN



IDENTIFICATION STAMP
 DIV. OF THE STATE ARCHITECT
 OFFICE OF REGULATION SERVICES
 01-108848
 AC, G.C. FLS. [Signature]
 DATE OCT 10 2007

DRAWN: [Signature]
 DATE: 4.11.07
 CHECKED: FAV
 SCALE: AS SHOWN
 PROJECT: 1615

A-P-1