


(drawings\PROJECTS\OPEN PROJECTS\San Mateo Community College\Drawing Set\B-M-1.dwg, 10/9/2007 3:24:28 PM, 6050 - Bond-24.pc3

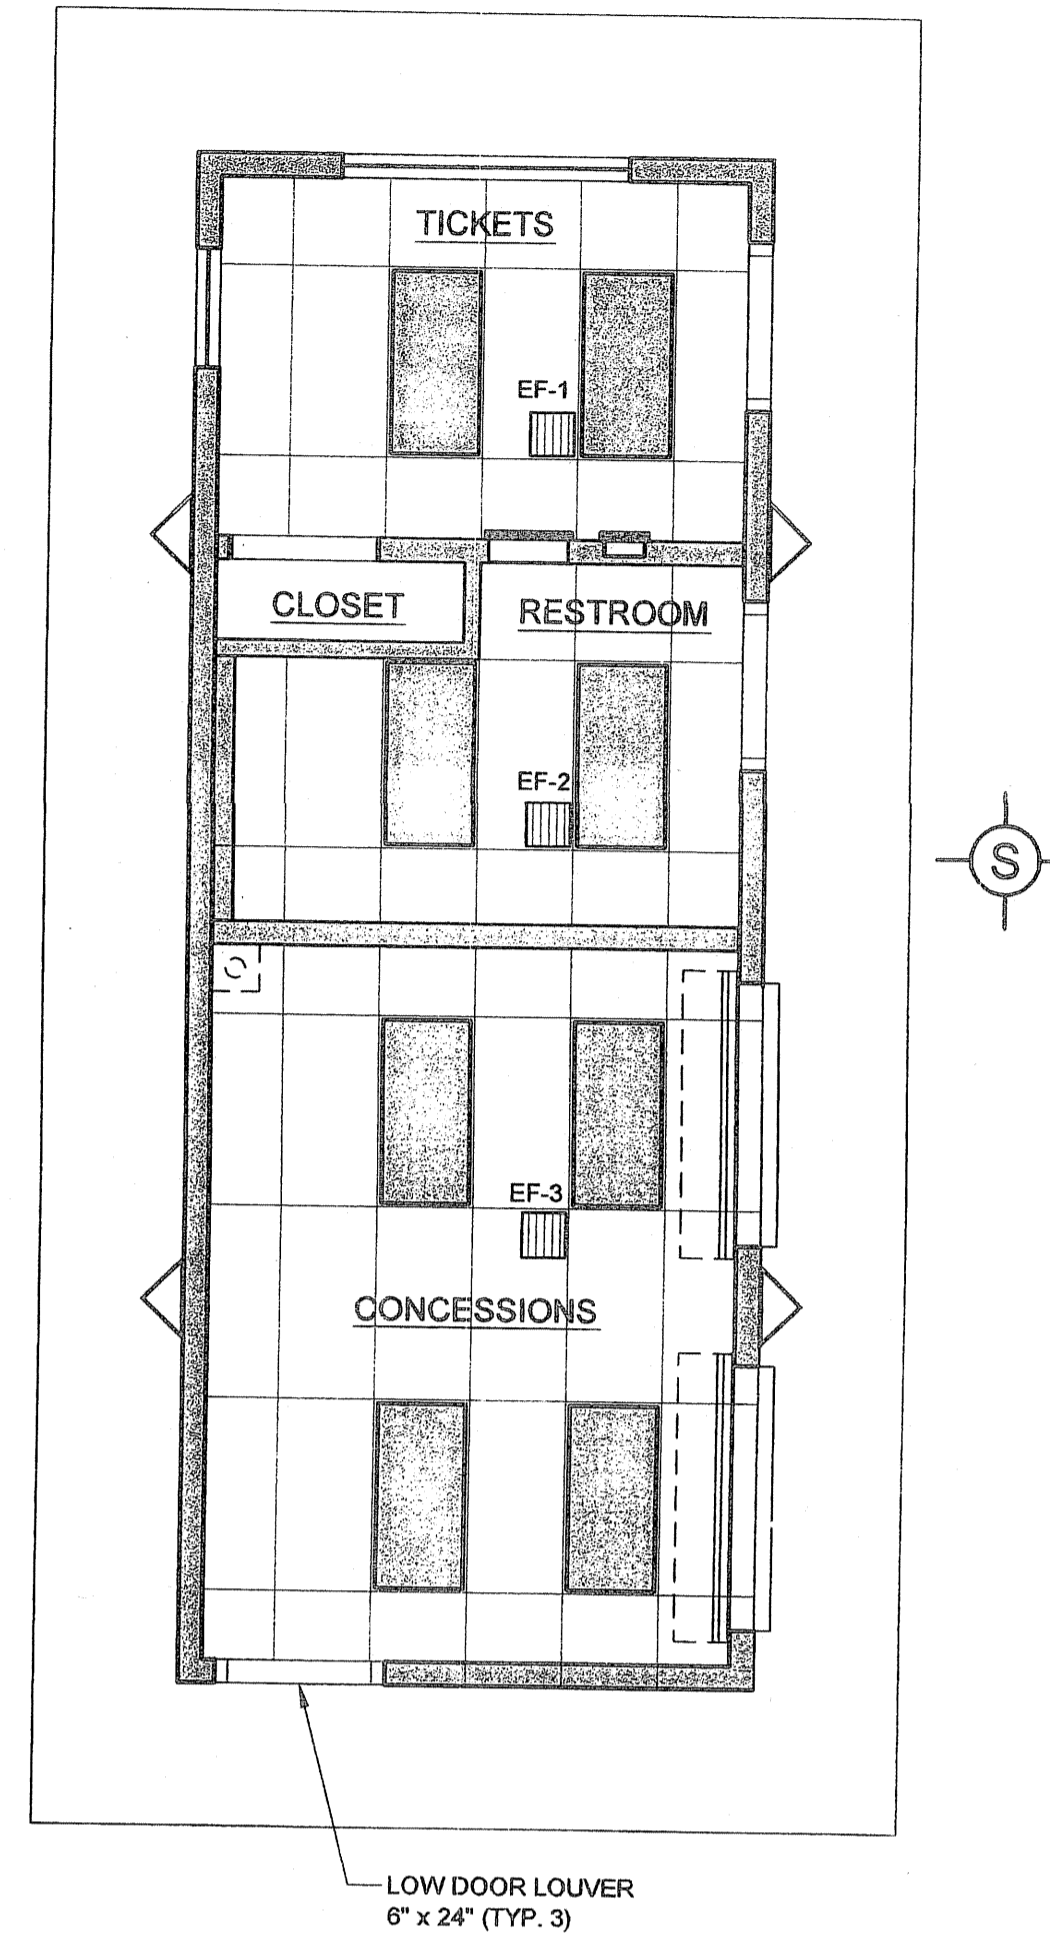

**BUILDING B -
MECHANICAL PLAN - HALL OF FAME**
SCALE: 1/4" = 1'-0"

REVISIONS	
1	
2	
3	
4	
5	
6	

COPYRIGHT © 2003
SARAMARK, INCORPORATED
THESE PLAN DRAWINGS ARE
PROPRIETARY DOCUMENTS
OF SARAMARK, INCORPORATED
& ARE NOT TO BE DISTRIBUTED,
PUBLISHED OR REPRODUCED
WITHOUT THE WRITTEN
CONSENT OF SARAMARK
INCORPORATED.

**EC
CONSULTING
GROUP**

1290 AVIATION AVE
SUITE 300-F
SAN JOSE, CA 95110
TEL: (408) 254-8313

**COLLEGE
of
SAN MATEO**


SAN MATEO
UNIFIED SCHOOL
DISTRICT

**SARAMARK
INCORPORATED**

SERIES
NEW

P.O. BOX 24369
SAN JOSE, CALIFORNIA 95114
TEL: (408) 971-3801
FAX: (408) 971-3834

**BUILDING B
HALL OF FAME
MECHANICAL PLAN**

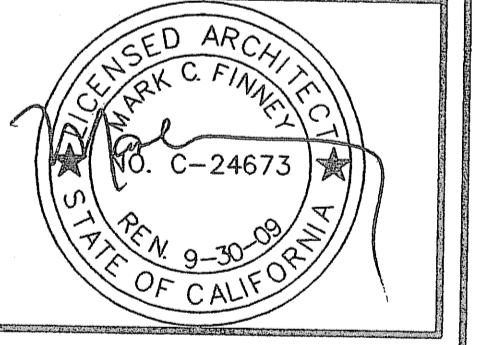

IDENTIFICATION STAMP
DIV. OF THE STATE ARCHITECT
OFFICE OF REGULATION SERVICES
01-108848
AC, JC, FLS, JJ, SS
DATE: OCT 10 2007

LEGEND:

2x4' FLUORESCENT LAY-IN
LIGHT FIXTURE, MOUNTING
DETAIL SEE
5
S-11

BROAN MODEL L-200 8" CEILING
EXHAUST FAN, DUCT VTR, SWITCHED W/
LIGHTS.

B-M-1

AS-BUILTS