


DOMESTIC WATER PLAN
SCALE: 1/4" = 1'-0"

SEE NEW UNDERSLAB SHEET F.O.#1-2 P.O.C. PLUMB @ END OF THIS SET.

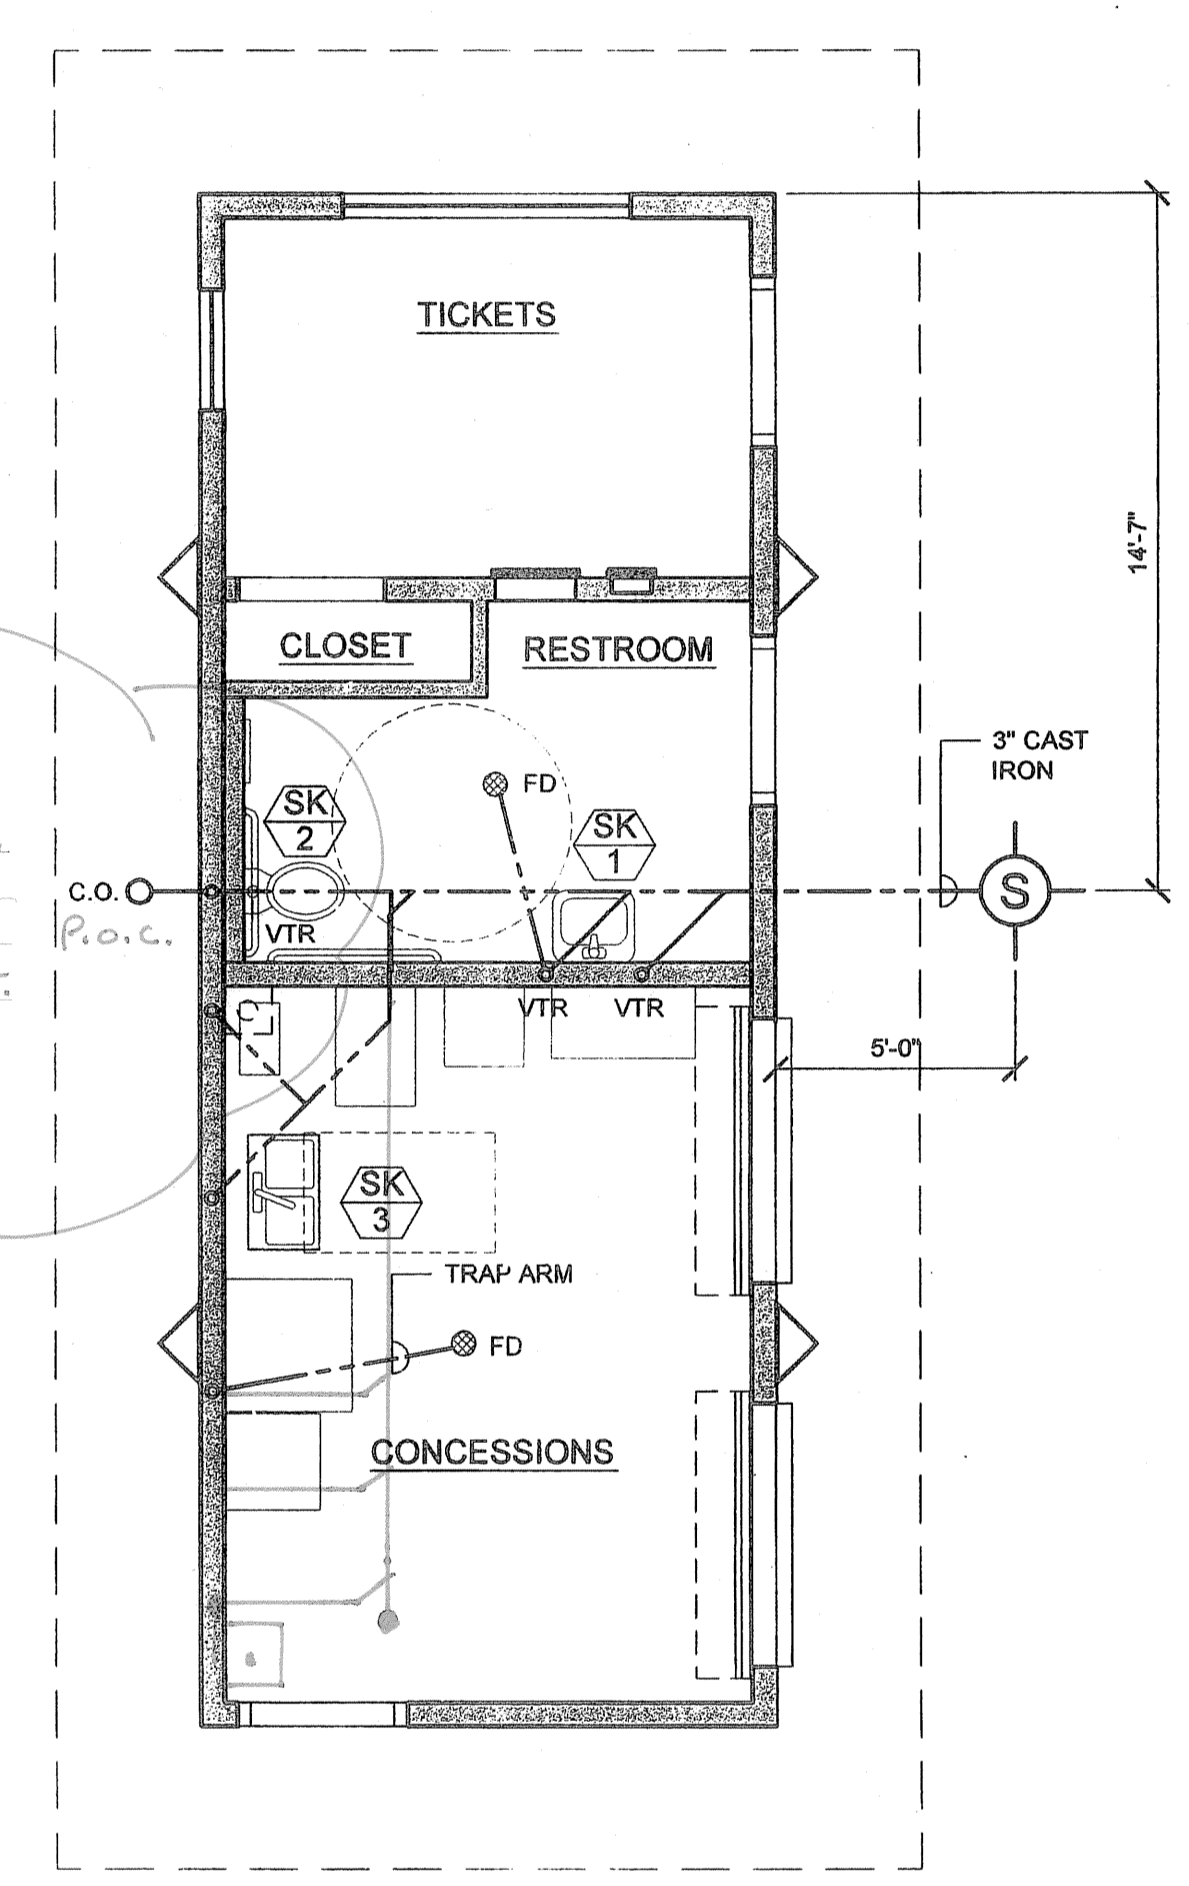

SEWER PLAN
SCALE: 1/4" = 1'-0"

GENERAL NOTES:

- EXISTING SEWER & WATER LINES TO BE FIELD VERIFIED.
- POINTS OF CONNECTION FOR SEWER & WATER ARE DIAGRAMATIC. ACTUAL POINTS OF CONNECTION MAY VARY FROM WHAT IS SHOWN IN THIS DRAWING; ADJUST ALIGNMENT OF UTILITIES INTO THE BUILDING ACCORDINGLY.
- PROVIDE CONNECTION TO FIXTURES AS PER MANUFACTURERS RECOMMENDATIONS *4.
- FLOOR DRAIN GRATING TO BE FLUSH WITH ALL OPENINGS

PLUMBING FIXTURE SCHEDULE

MARK	DESCRIPTION	REMARKS
SK 1	WALL-HUNG LAVATORY	AMERICAN STANDARD BARRIER FREE LUCERNE WALL-HUNG LAVATORY - MODEL 0355.012
SK 2	WALL-HUNG TOILET	AMERICAN STANDARD BARRIER FREE AFWALL ELONGATED FLUSH VALVE TOILET - MODEL
SK 3	ADA DOUBLE-BOWL SINK	STYLIST GROUP ADA COMPLIANT, DLA-ADA-SERIES-A-18GA 6 1/2" MAX DEPTH

LEGEND:

- SANITARY SEWER, SIZE AS FOLLOWS (U.O.N.)
PROVIDE 2" SERVICE FROM LAVATORY TO MAIN
PROVIDE 2" SERVICE FROM FLOOR DRAIN TO MAIN
PROVIDE 2" SERVICE FROM DRINKING FOUNTAIN TO MAIN
PROVIDE 2" SERVICE FROM URINAL TO MAIN
PROVIDE 3" SERVICE FROM WATER CLOSET TO MAIN
- VENT, SIZE PER 1997 UBC
- DOMESTIC COLD WATER, SIZE AS FOLLOWS (U.O.N.)
PROVIDE 1/2" SERVICE TO DRINKING FOUNTAIN FROM MAIN
PROVIDE 1/2" SERVICE TO LAVATORY FROM MAIN
PROVIDE 3/4" SERVICE TO URINAL FROM MAIN
PROVIDE 1" SERVICE TO WATER CLOSET FROM MAIN
- W DOMESTIC COLD WATER - POINT OF CONNECTION
- S SANITARY SEWER - POINT OF CONNECTION
- FD FLOOR DRAIN
- VTR VENT THROUGH ROOF
- C.O. CLEAN-OUT
- DWN PIPE DOWN FROM ATTIC

△ NEW P.O.C. FOR WATER & SHUT OFF & BACKFLOW.
 △ HOSE BIB LOCATIONS.
 △ WATER HEATER LOCATION (30 GALLON, FLOOR MOUNT)
 △ SEE NEW UNDERSLABS FOR SEWER. SHT F.O.#1-2 AT END OF THIS SET.

AS BUILT
CONDITION
THIS SHEET

REVISIONS	
1	
2	
3	
4	
5	
6	


COPYRIGHT © 2003
SARAMARK, INCORPORATED
THESE PLAN DRAWINGS ARE PROPRIETARY DOCUMENTS OF SARAMARK, INCORPORATED & ARE NOT TO BE DISTRIBUTED, PUBLISHED OR REPRODUCED WITHOUT THE WRITTEN CONSENT OF SARAMARK INCORPORATED.

EC CONSULTING GROUP
1280 AVIATION AVE
SUITE 200-4
SAN JOSE, CA 95110
TEL: (408) 284-8510

COLLEGE of SAN MATEO
SAN MATEO UNIFIED SCHOOL DISTRICT

SARAMARK INCORPORATED SERIES NEW
P.O. BOX 24369
SAN JOSE, CALIFORNIA 95154
TEL: (408) 971-3881
FAX: (408) 971-3854

BUILDING B HALL OF FAME PLUMBING PLAN

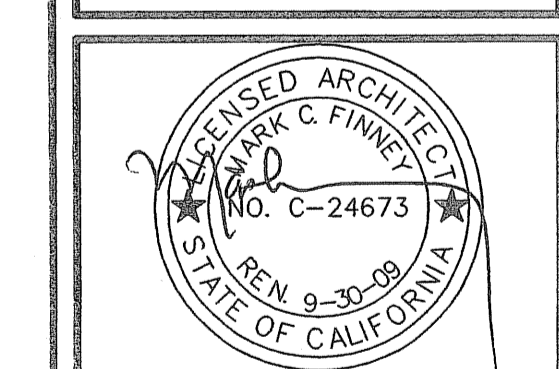

IDENTIFICATION STAMP
DIV. OF THE STATE ARCHITECT
OFFICE OF REGULATION SERVICES
01-108848
AC, PL, FL, SS
DATE OCT 10 2007

DRAWN: ED
DATE: 4.11.07
CHECKED: FAV
SCALE: AS NOTED
PROJECT: 1615

B-P-1