
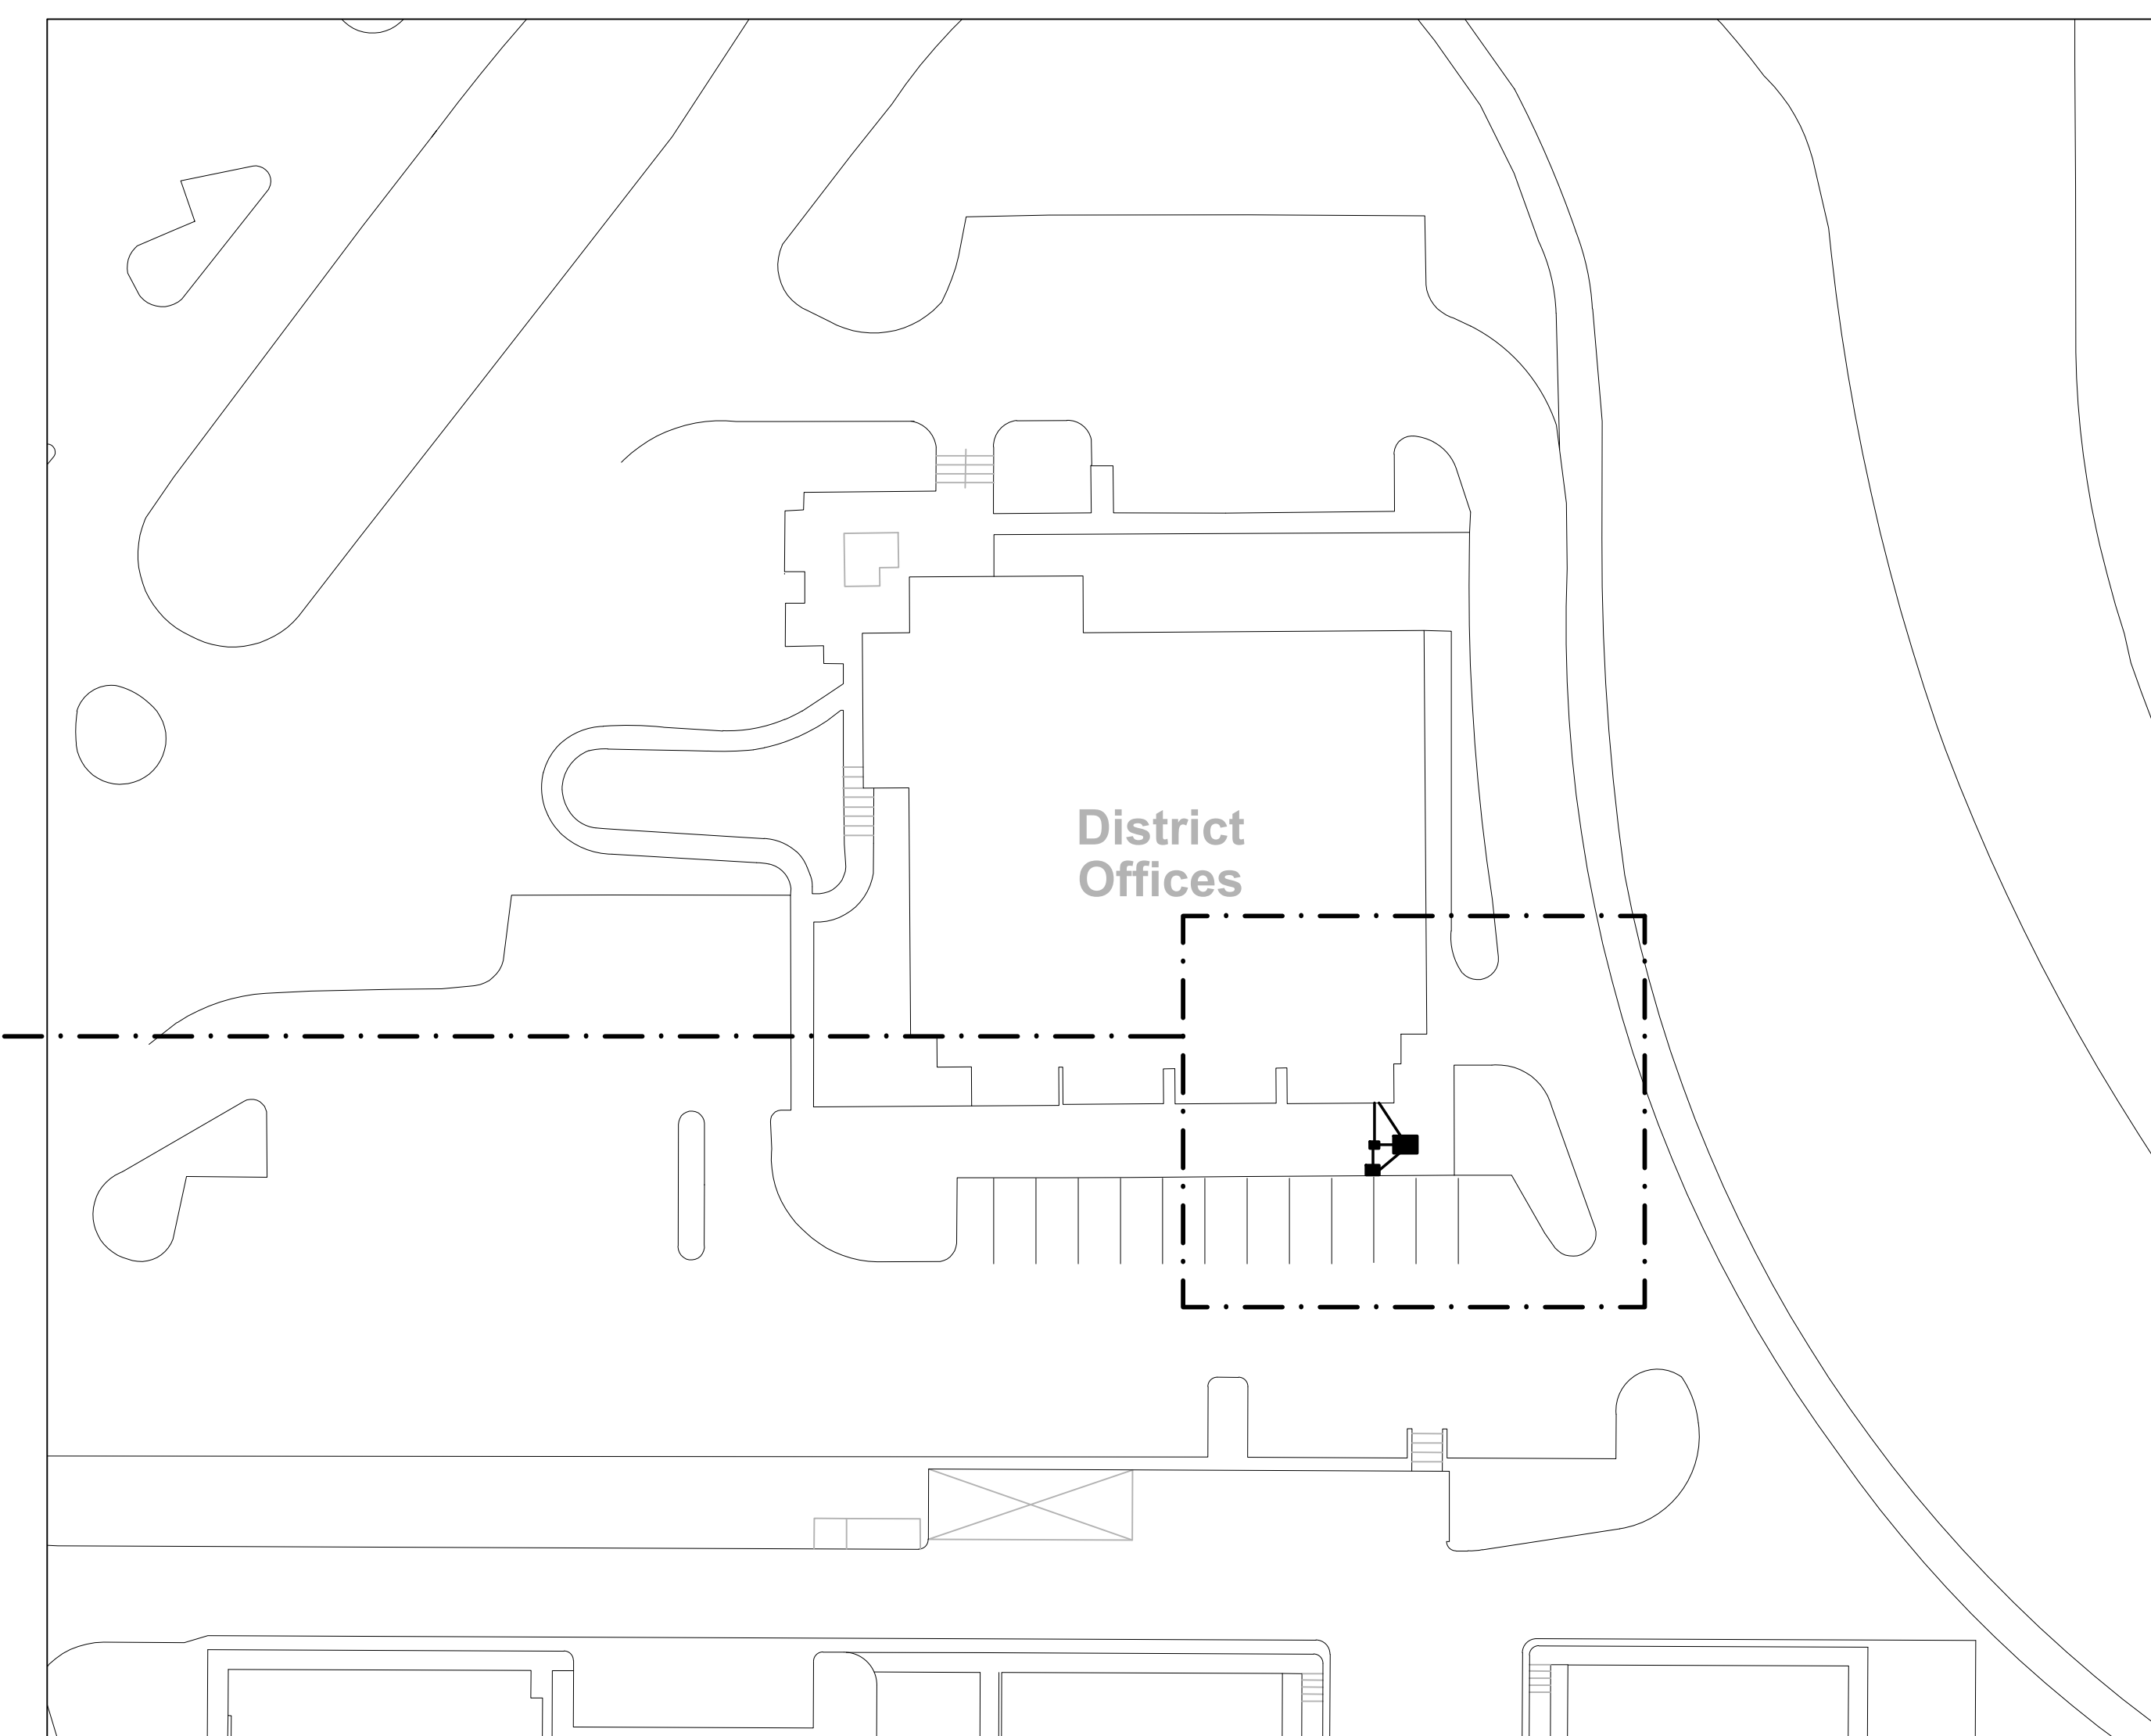


1 MARIE CURIE LOT  
N.T.S.

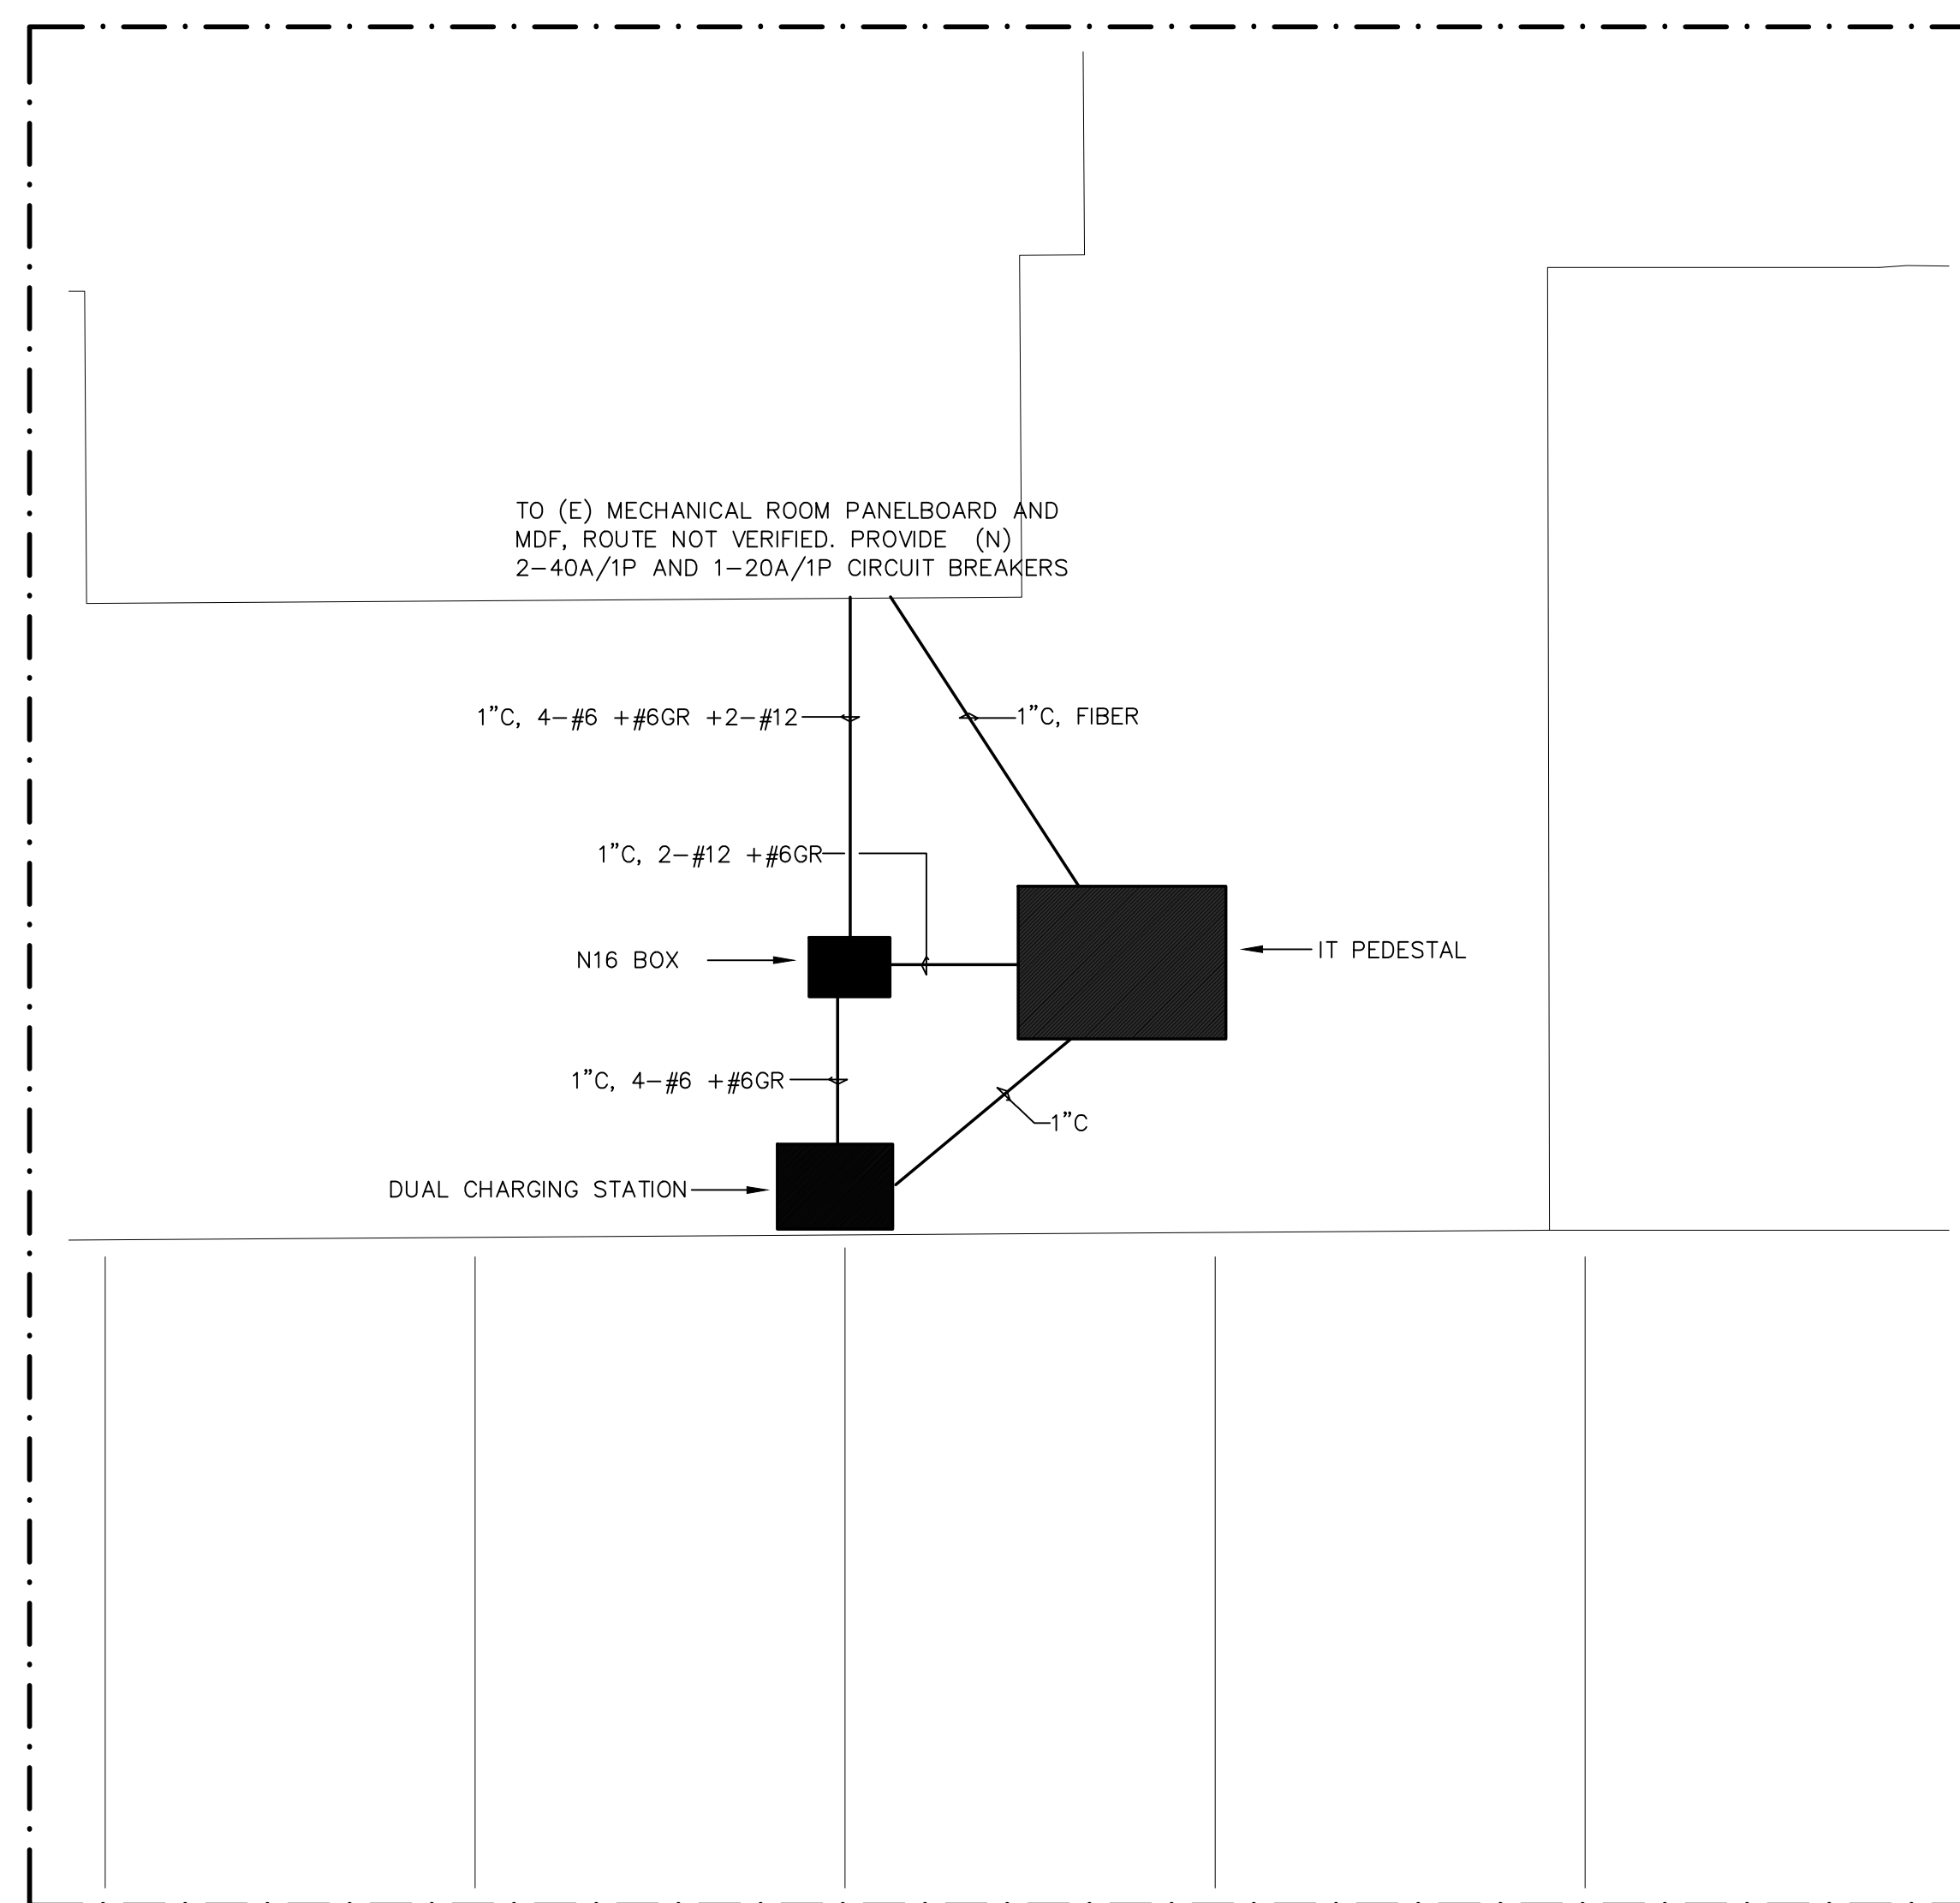

2 DISTRICT OFFICES  
N.T.S.

SHEET TITLE  
ELECTRICAL PLAN AND DETAILS

REVISIONS		
NO.	DATE	DESCRIPTION

DATE: FEBRUARY 28, 2012  
DRAWN: JS  
CHECKED: -  
SCALE: AS NOTED  
JOB NO.:

SHEET NUMBER  
CSM-E2