
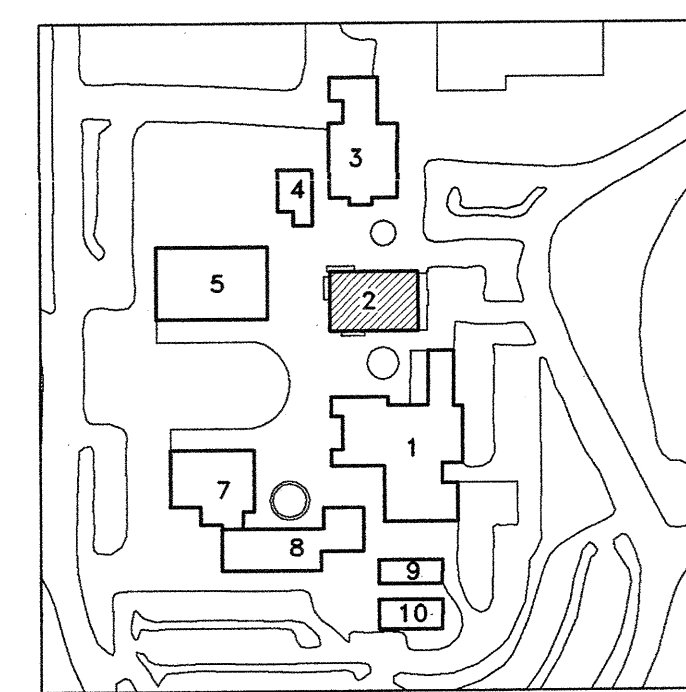


PLAN LEGEND

- ⊖ ROOM THERMOSTAT BY MECHANICAL CONTRACTOR. RUN 1/2" C.O. TO CORRESPONDING VAV BOX
- ⬡ VARIABLE AIR VOLUME TERMINAL BOX BY MECHANICAL CONTRACTOR. PROVIDE 120V. CIRCUIT AND 20A-1P, TOGGLE SWITCH ON A SINGLE GANG BOX FOR CONTROL CIRCUIT.


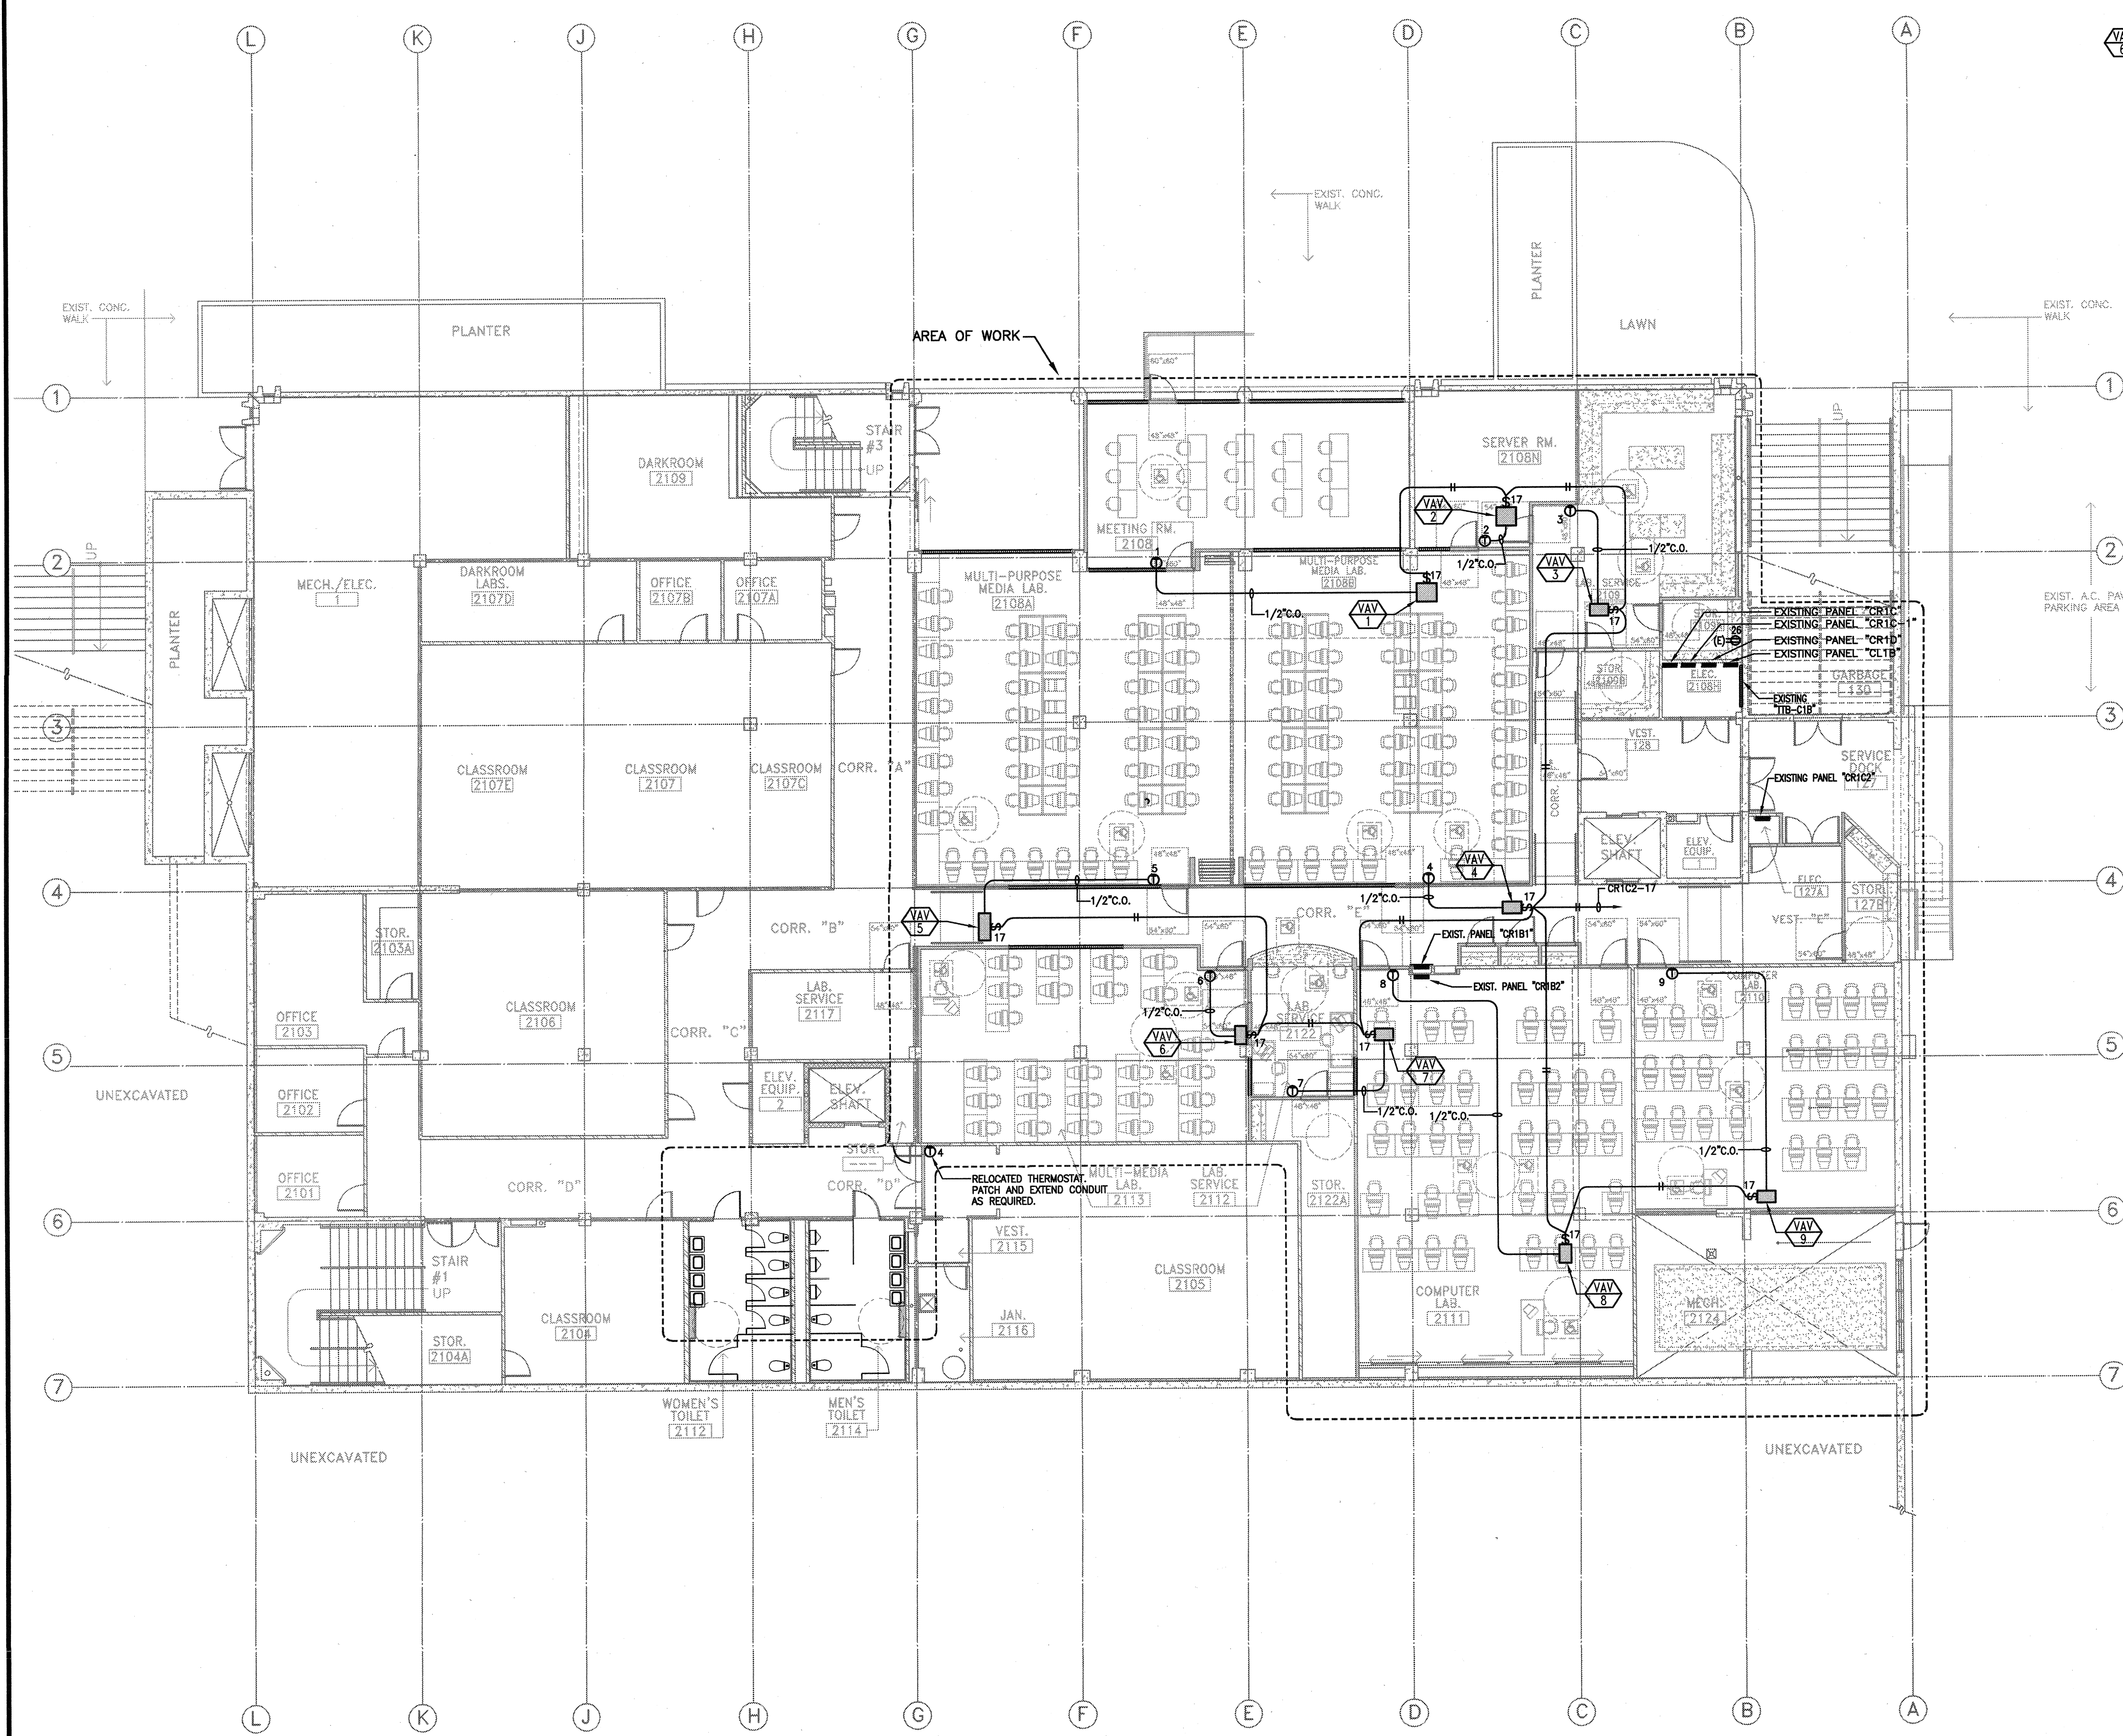


KEY MAP

R E M O D E L

1st LEVEL FLOOR PLAN BUILDING # 2

SCALE: 1/8" = 1'-0"

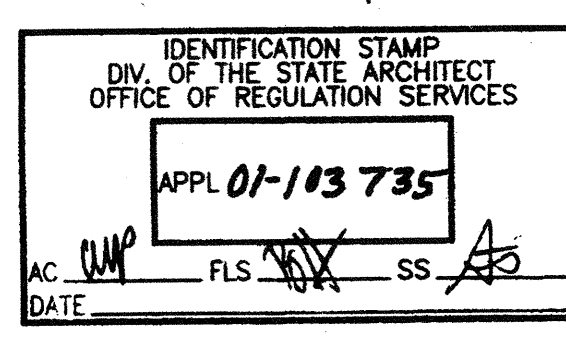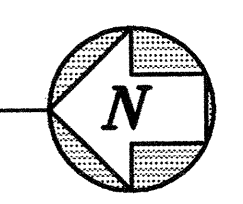

KABZ
KRUGER BENSEN ZIEMER ARCHITECTS, INC.
 30 W. ARRELLAGA, SANTA BARBARA, CA 93101
 805/963-1726

STEVE DOWTY, A.I.A.
 PRINCIPAL IN CHARGE

GERALD SHUSTA
 PROJECT ARCHITECT

DALAN ENGINEERING, INC.
 ELECTRICAL ENGINEERS
 DALAN JOB No AA181
 8638 DARBY AVENUE (714) 771-4221
 NORTHBRIDGE, CA. 91325 (805) 684-4944
 (818) 772-2220 FAX (818) 772-2239

CENTER FOR ADVANCED LEARNING TECHNOLOGY
SKYLINE COLLEGE
 SAN MATEO COUNTY COMMUNITY COLLEGE DISTRICT
 3300 COLLEGE DRIVE
 SAN BRUNO, CALIFORNIA 94066

△	BID SET REVISIONS	10/25/01
	DSA SUBMITTAL	06/15/01
NO.	DESCRIPTION	DATE BY
	REVISION	

DRAWN LOG
 CHECKED DK
 DATE 03/21/01
 JOB NO. 98-03

SHEET TITLE
1ST FLOOR VAV BOX POWER PLAN

SHEET
E-2.3A

OF