

GENERAL ELECTRICAL NOTES

- A. REFER TO COLLEGE OF SAN MATEO EXISTING FIXTURE SURVEY SPREADSHEET FOR EXISTING LUMINAIRE INFORMATION.
- B. ALL DRAWINGS SHALL BE READ IN CONJUNCTION WITH RFP REPORT AND SPREADSHEET DOCUMENTS.


SHEET KEYNOTES

- 1. NIC, FIXTURES PART OF SEPARATE FUTURE BOND PROJECT. LOCATIONS SHOWN FOR INFORMATION ONLY.

LEGEND

- EXISTING WALL MOUNTED FIXTURE
- ⊕ EXISTING BOLLARD FIXTURE
- ◻ EXISTING POLE MOUNTED FIXTURE

INTERFACE ENGINEERING
 717 Market Street
 Suite 500
 San Francisco, CA 94103
 TEL 415.489.7240
 FAX 415.489.7289
 www.interfaceengineering.com

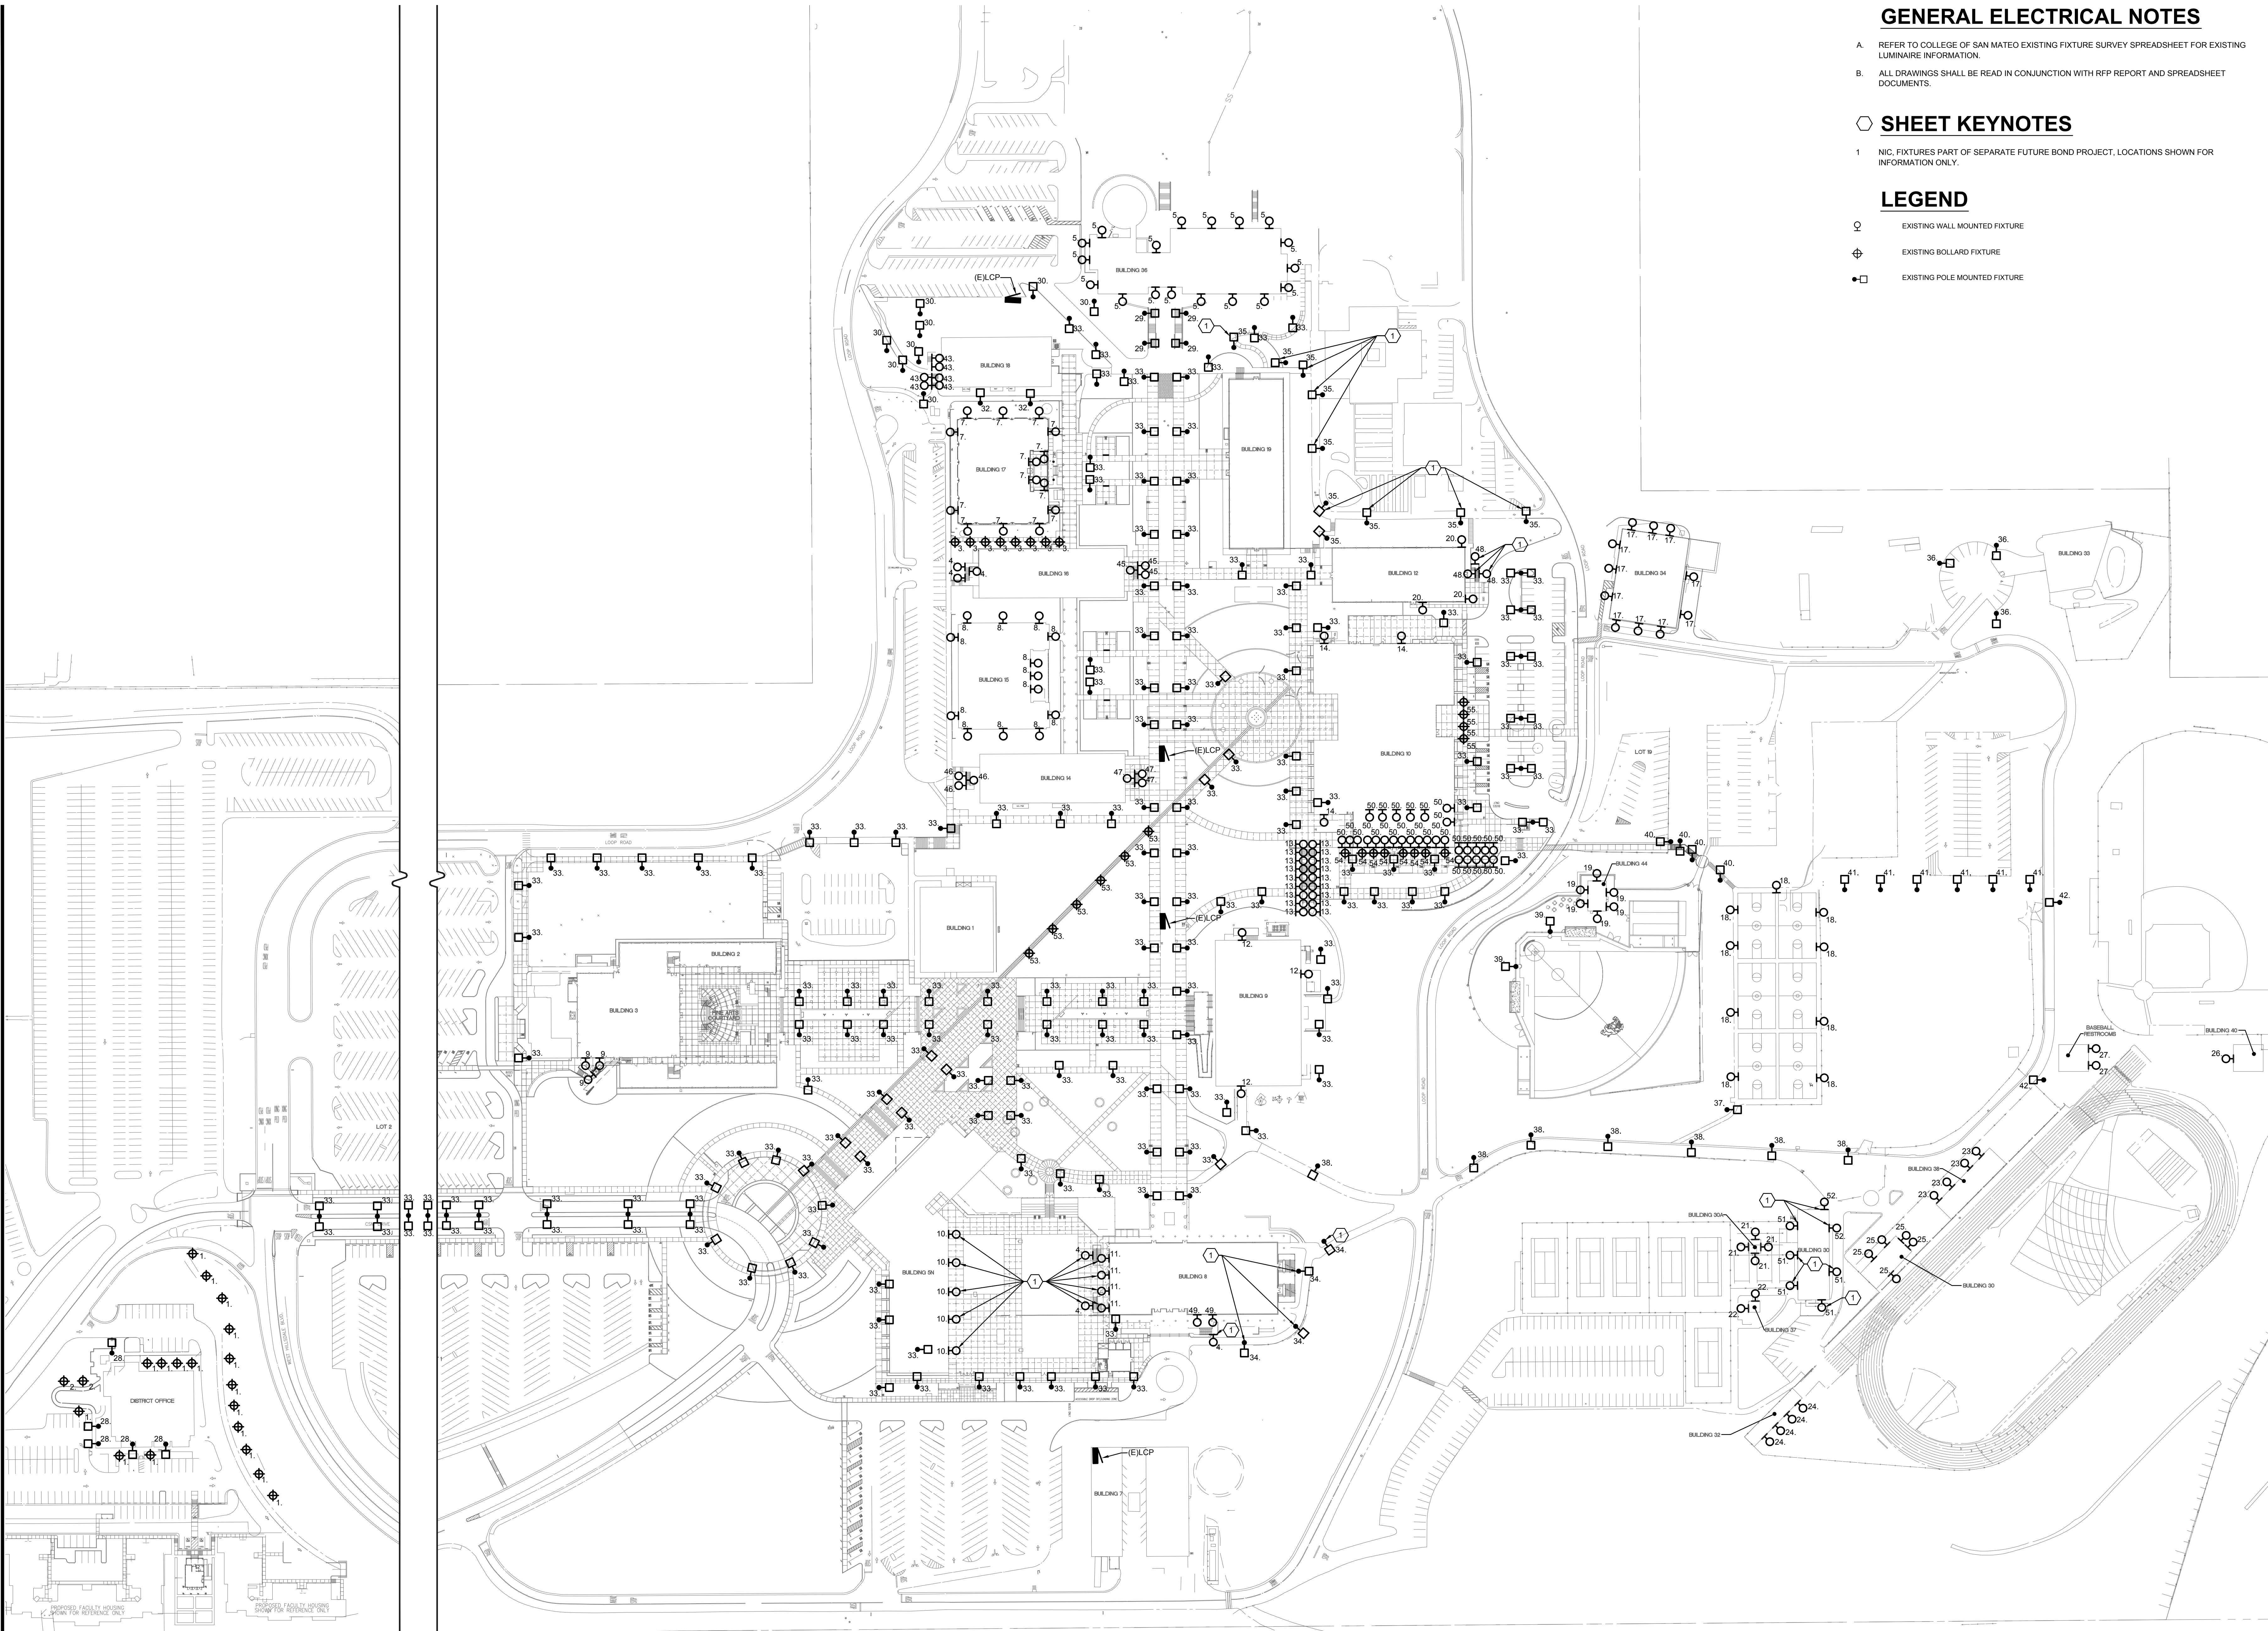

DISTRICT WIDE EXTERIOR LIGHTING UPGRADE

**SAN MATEO COMMUNITY COLLEGE DISTRICT
 3401 CSM DRIVE, SAN MATEO, CA 94402**

1 COLLEGE OF SAN MATEO SITE LIGHTING PLAN

PROJECT 2014-0207
 CONTACT Kristina Santi
INTERFACE ENGINEERING
 717 Market Street
 Suite 500
 San Francisco, CA 94103
 TEL 415.489.7240
 FAX 415.489.7289
 www.interfaceengineering.com

SHEET TITLE	
REVISIONS	
DRAWN BY	
CHECKED BY	
JOB NO.	2014-0207
DATE	02/09/2015
SHEET NUMBER	E1.0