




**1 ELECTRICAL PLAN**  
SCALE: 1/16"=1'-0"

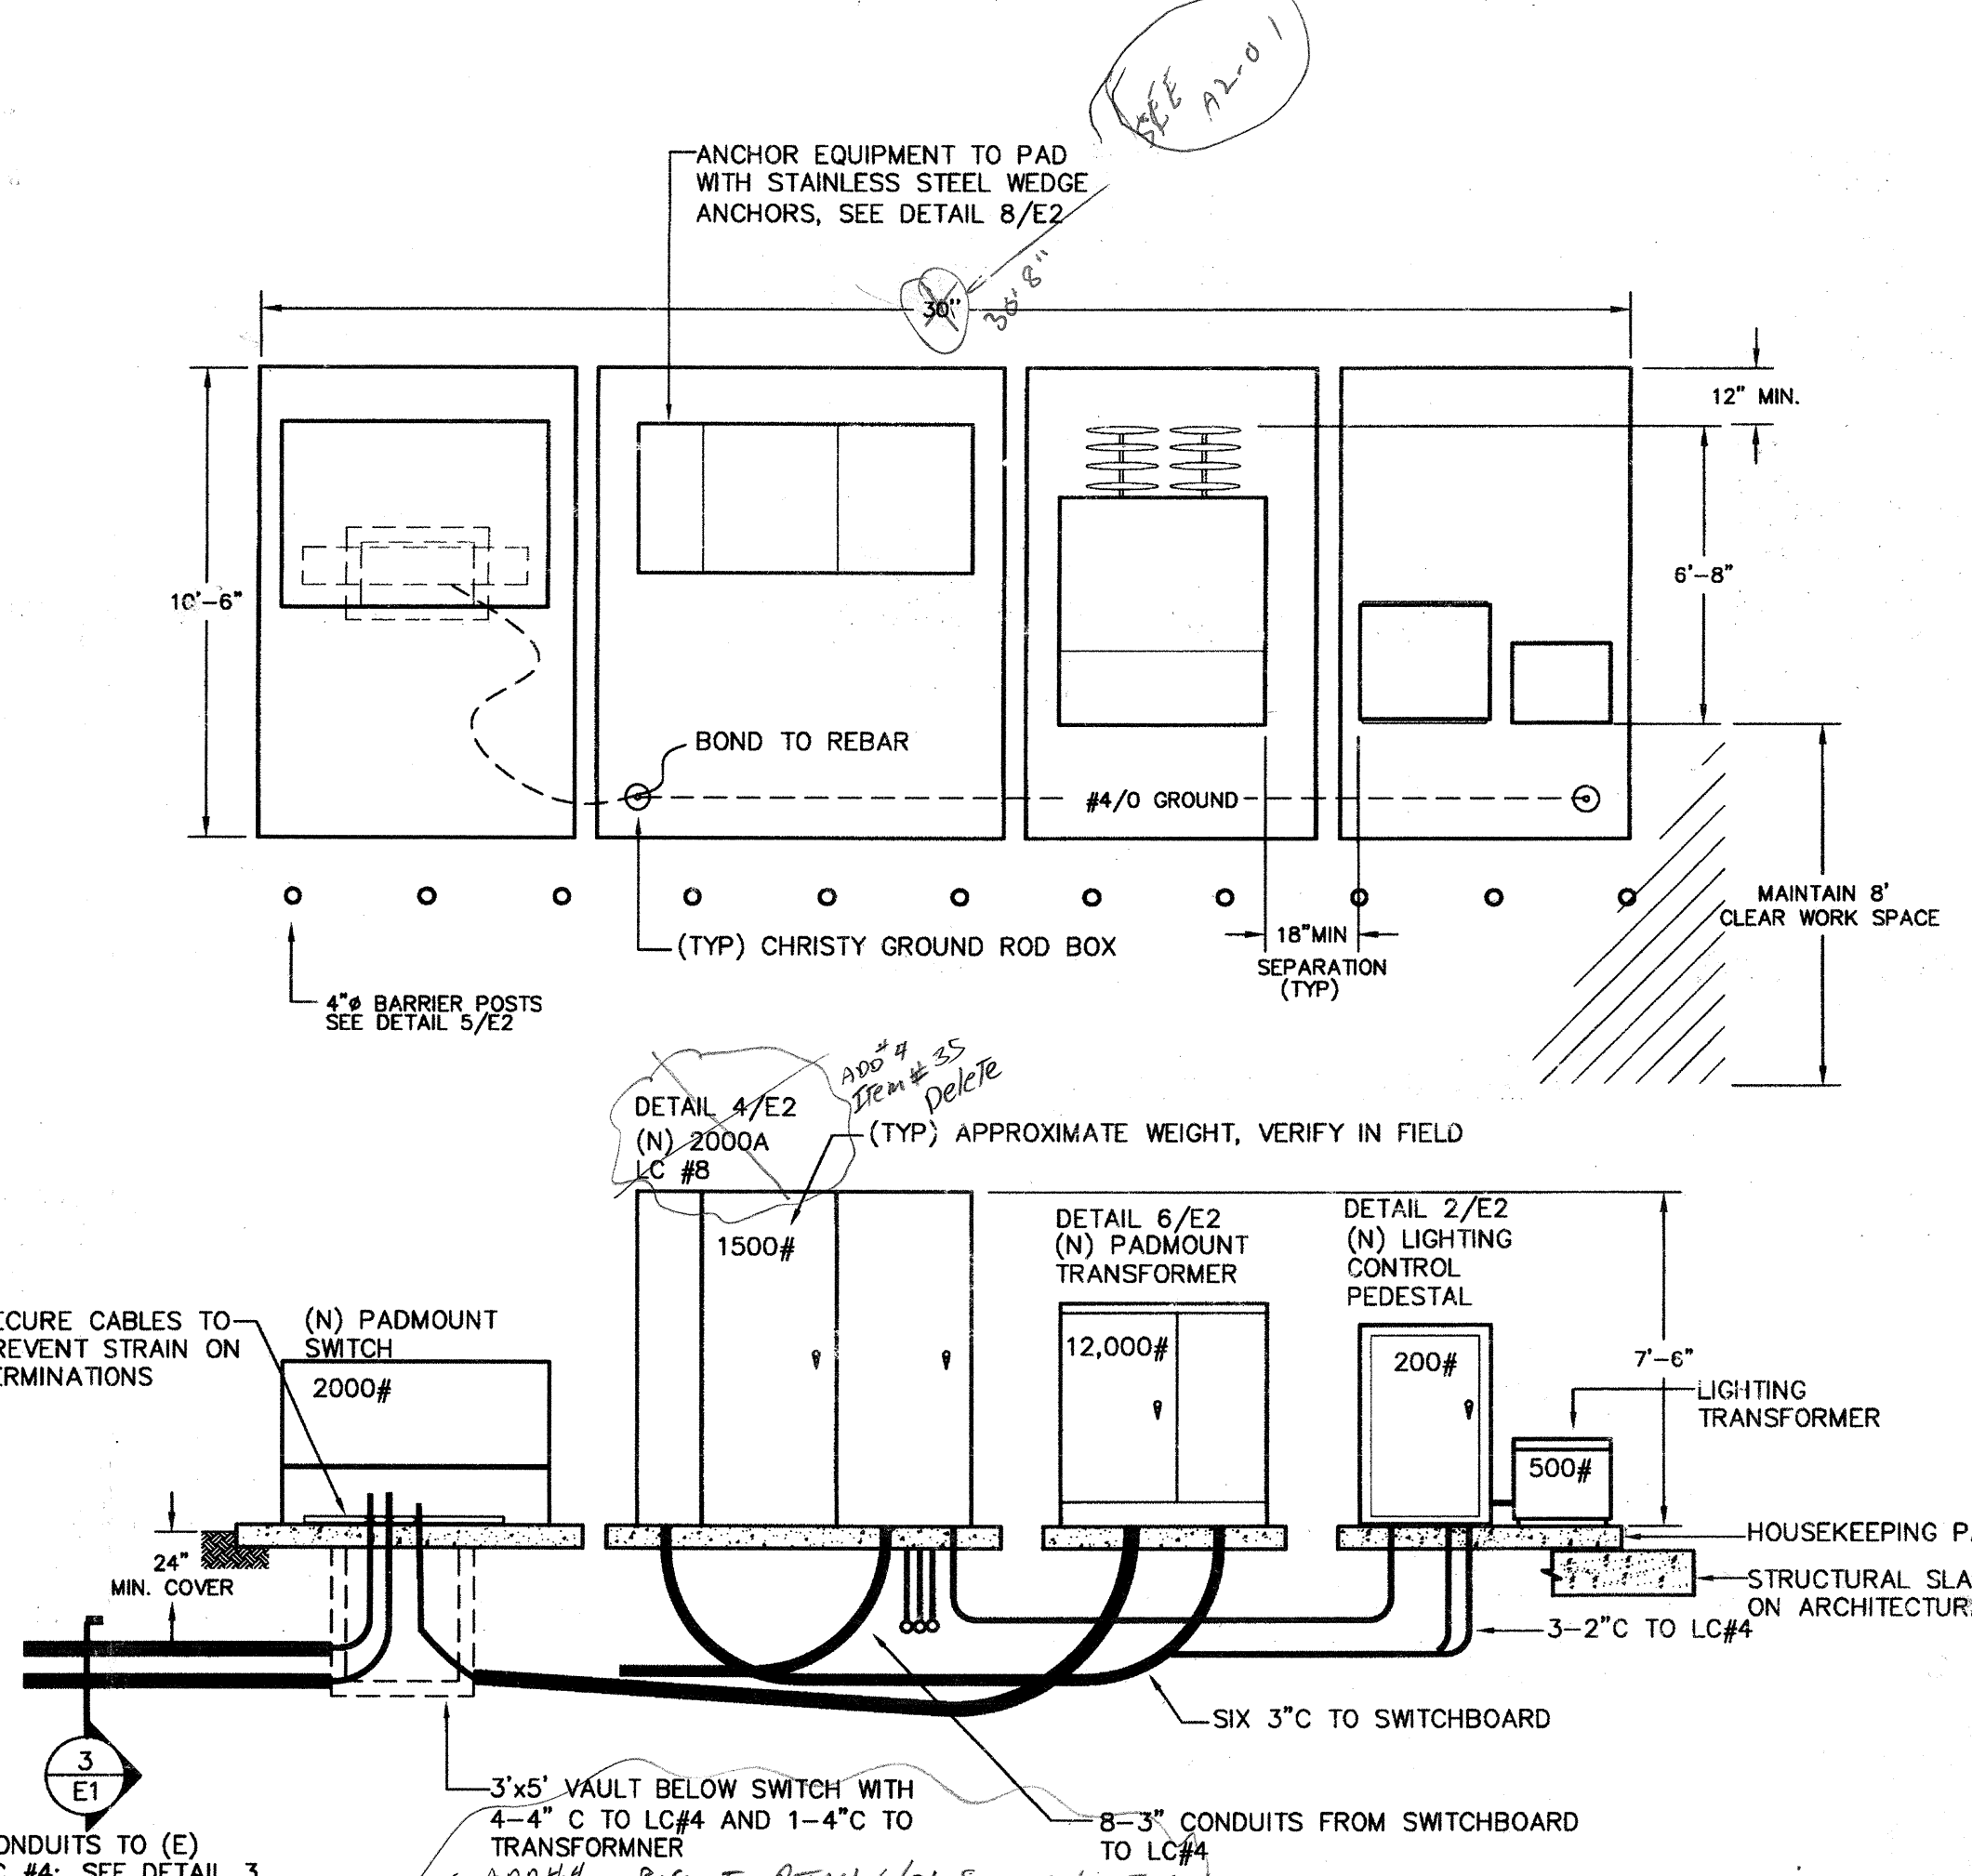


**2 (N) EQUIPMENT PAD**  
SCALE: 1/4"=1'-0"

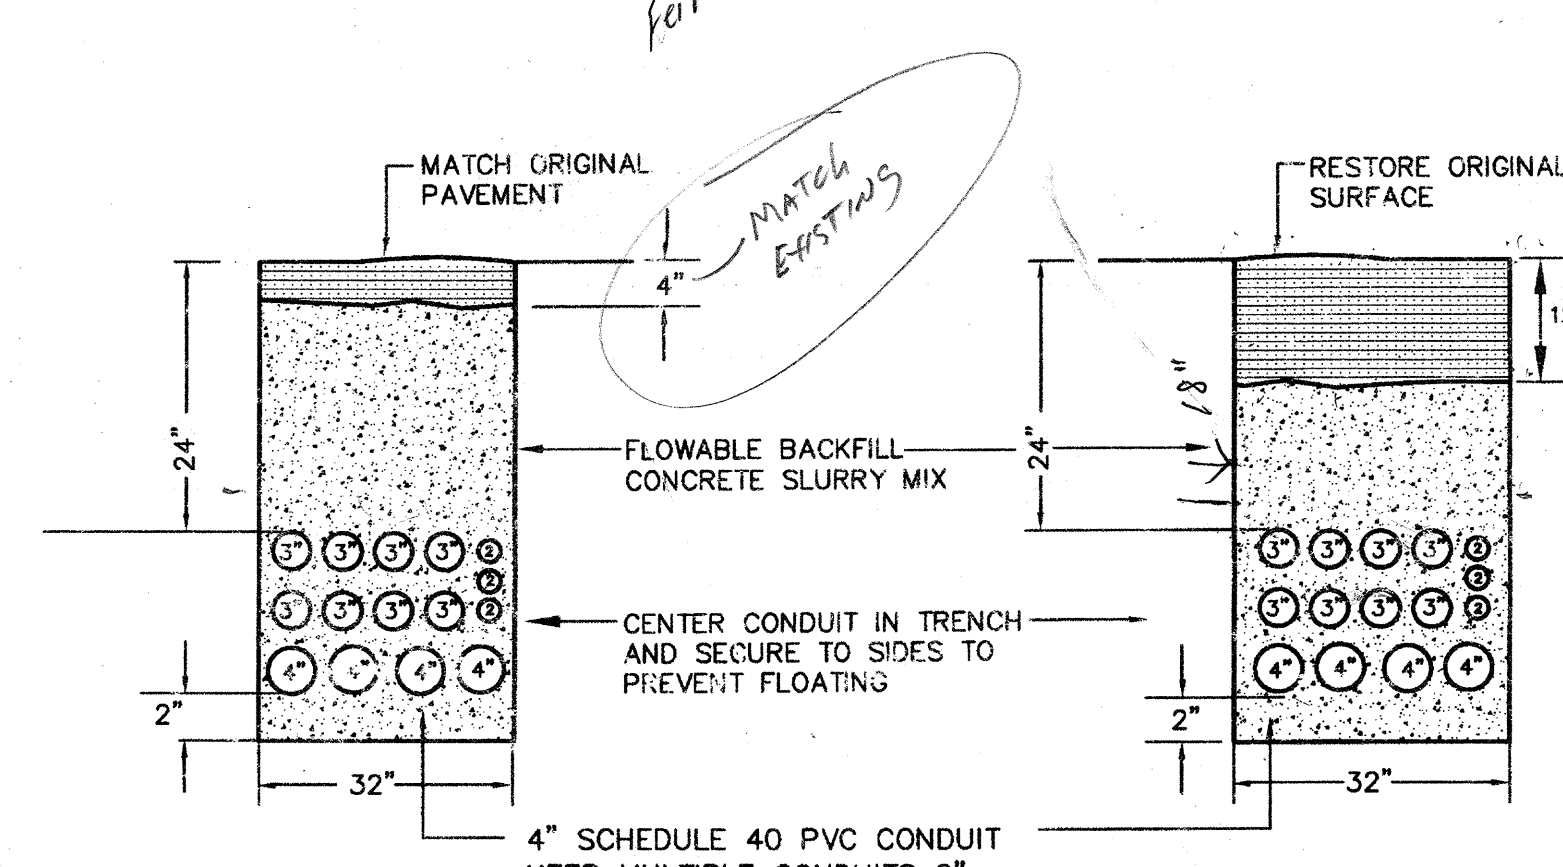


**3 TRENCH SECTIONS**  
N.T.S.

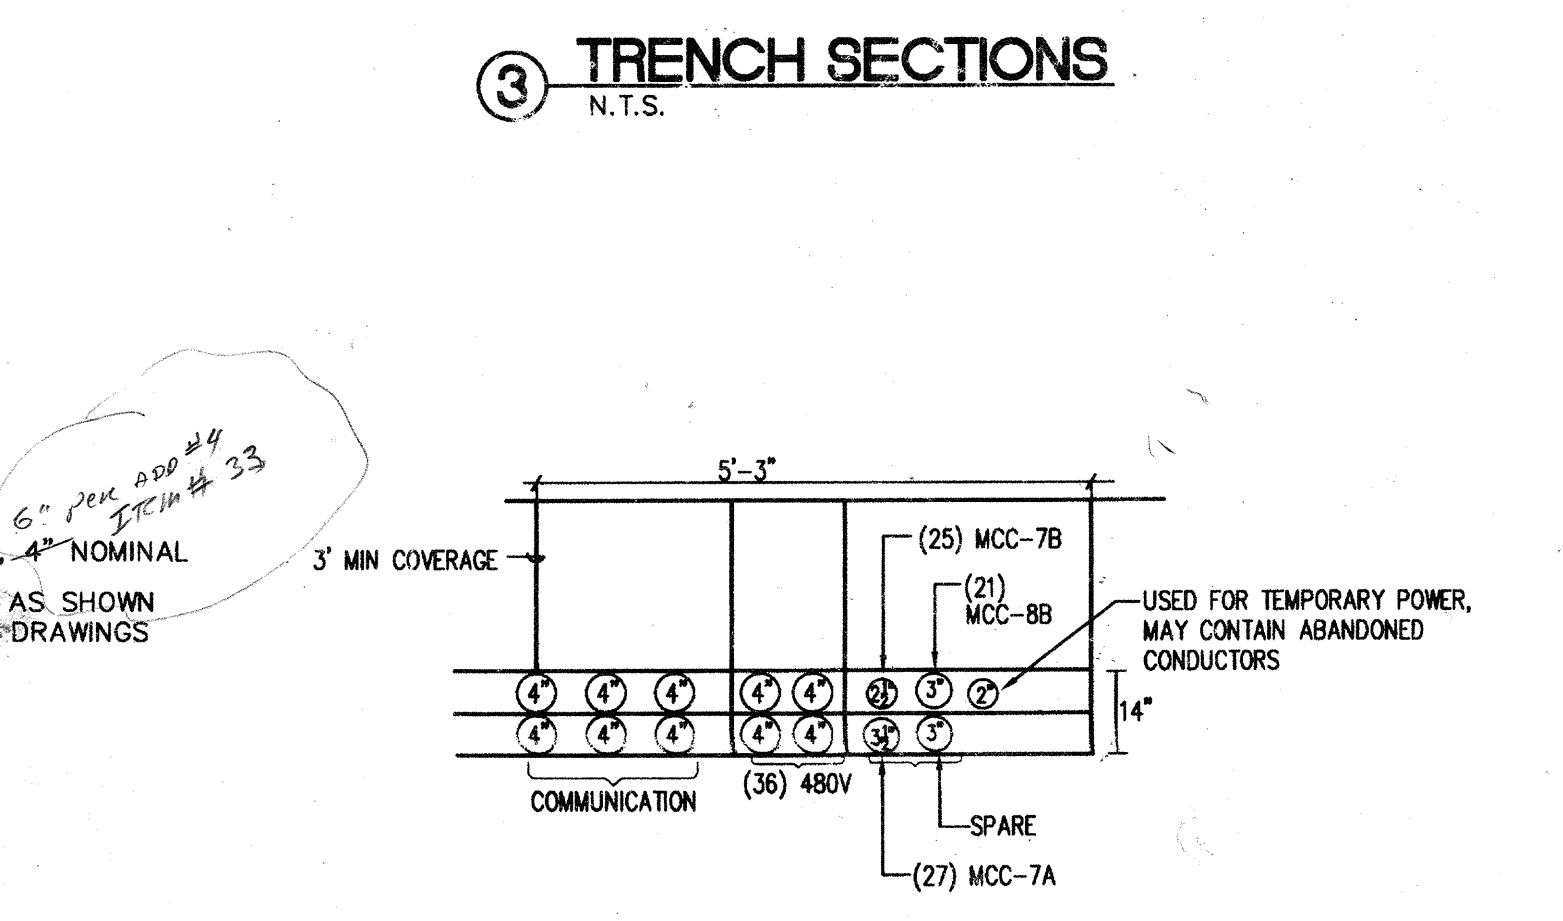


**5 (E) UNDERGROUND DUCT BANK**  
SASCO SECTION 'D' N.T.S.

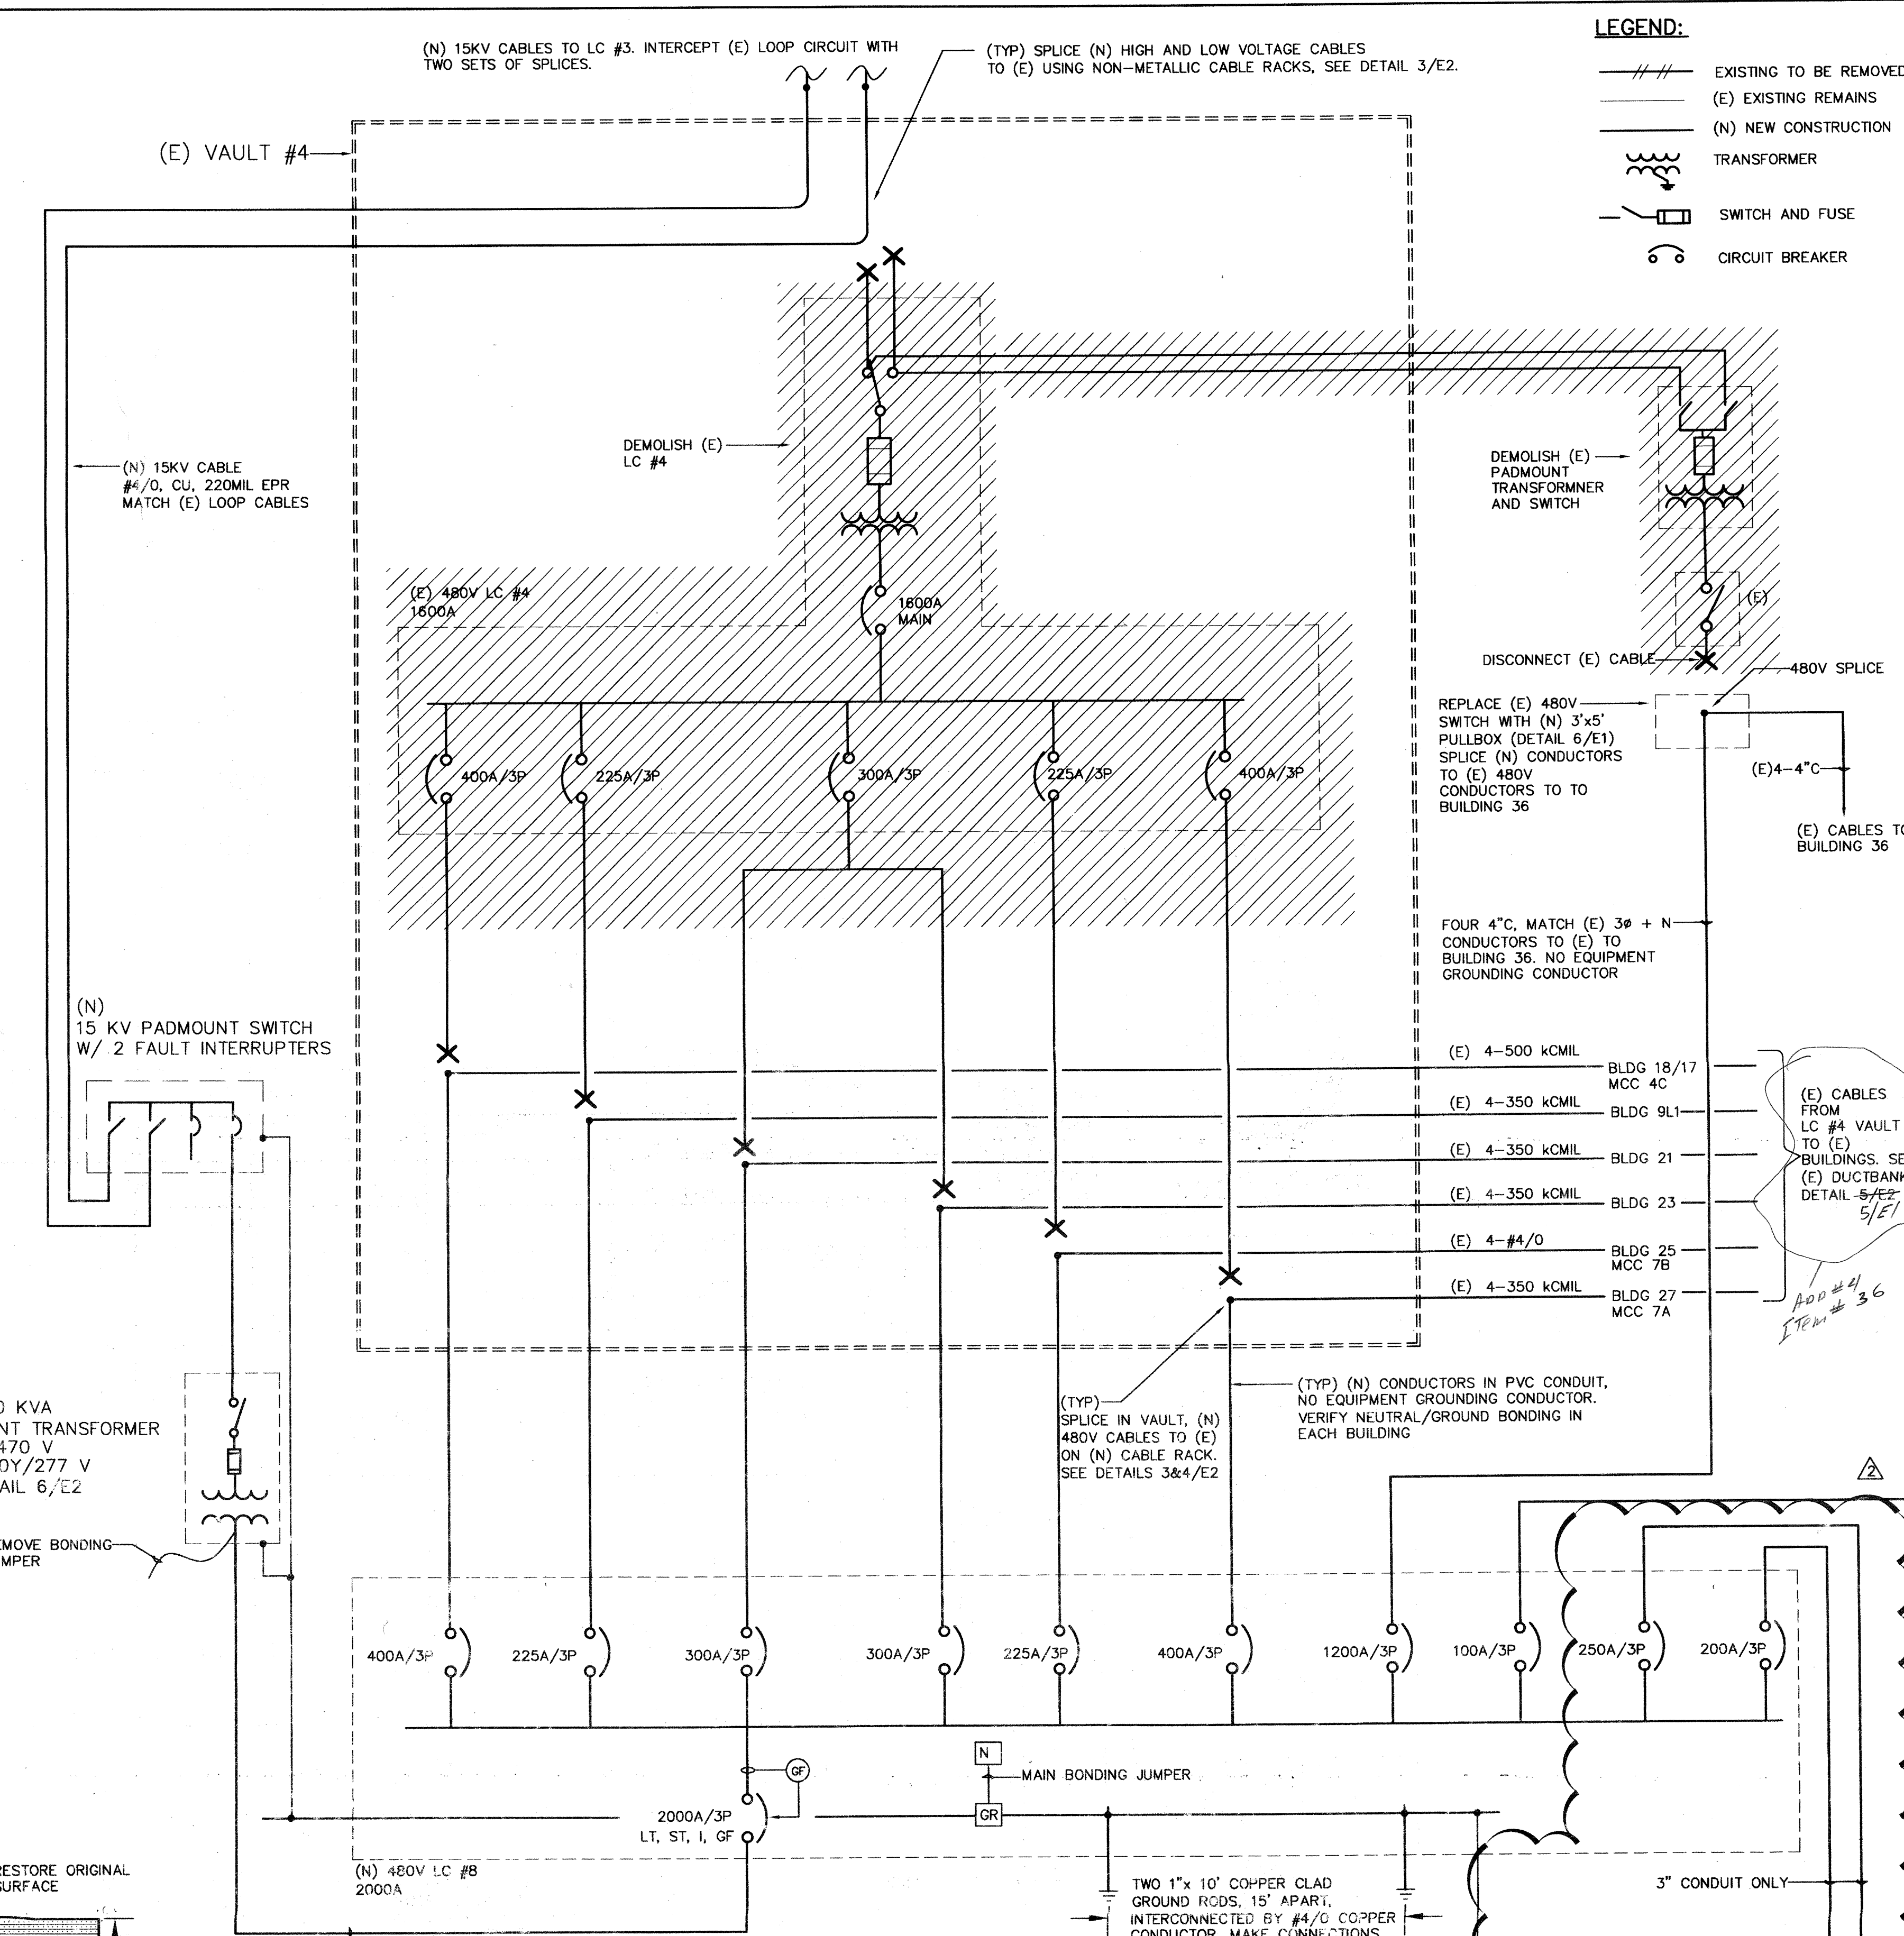

**4 1-LINE DIAGRAM**  
N.T.S.

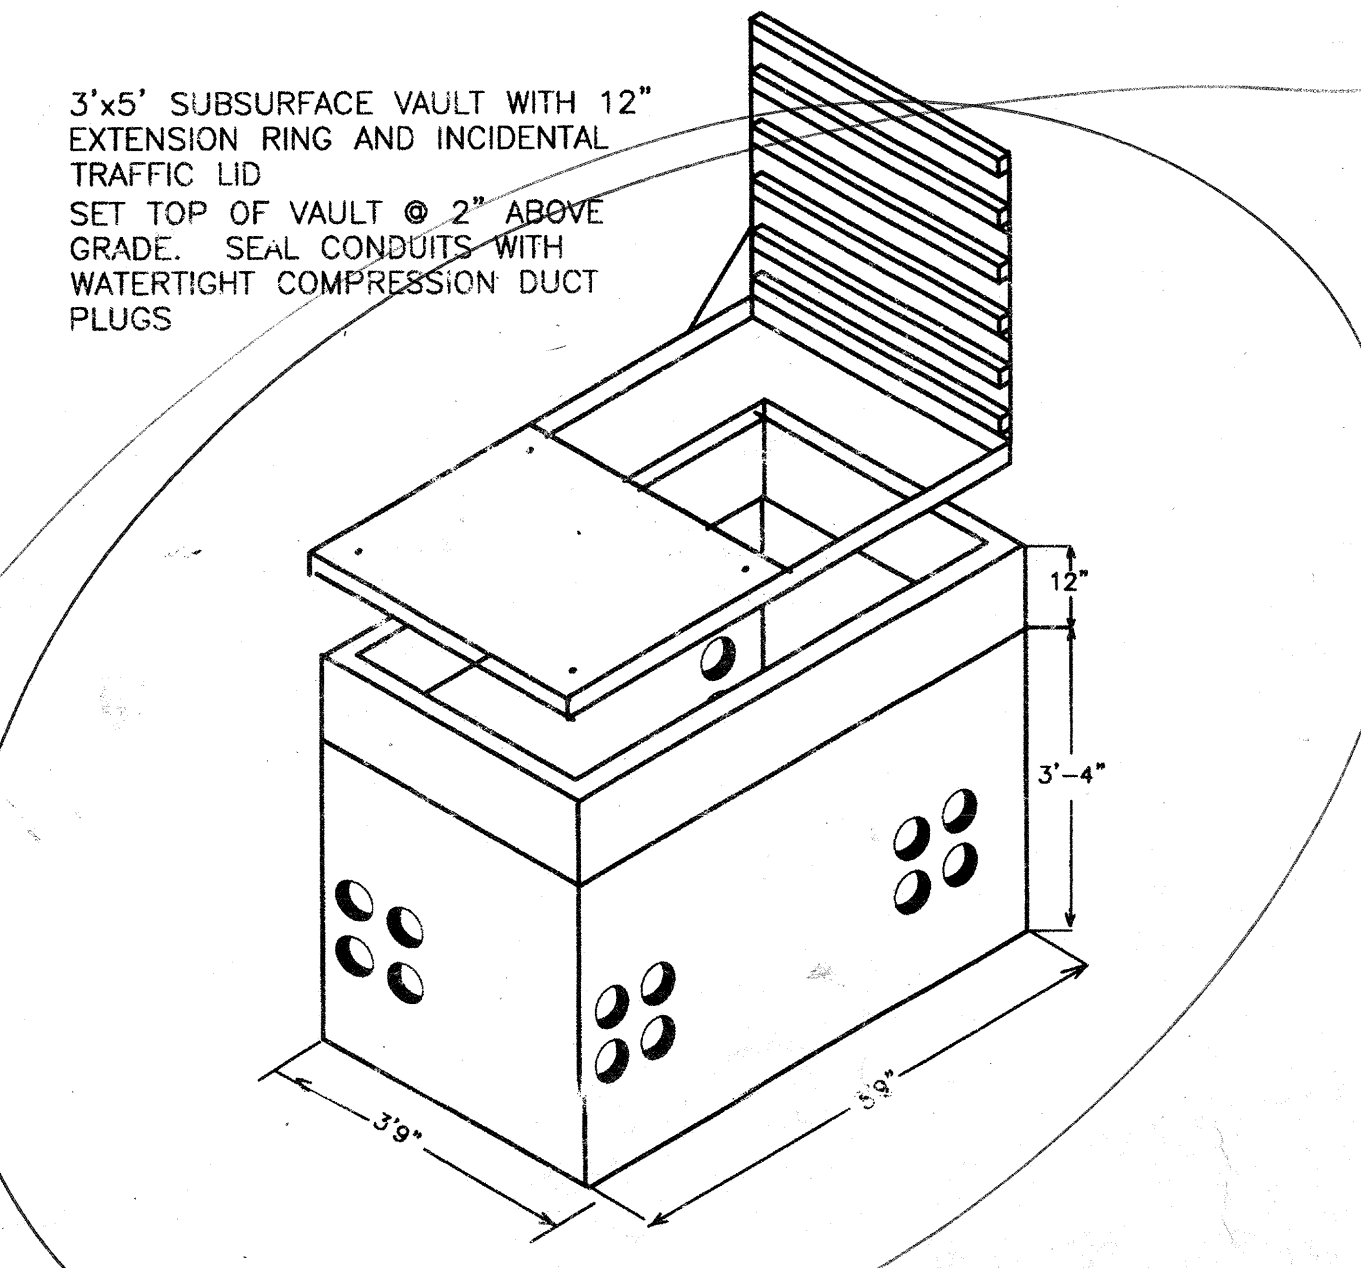

**6 3'x5' SUBSURFACE VAULT**  
N.T.S.

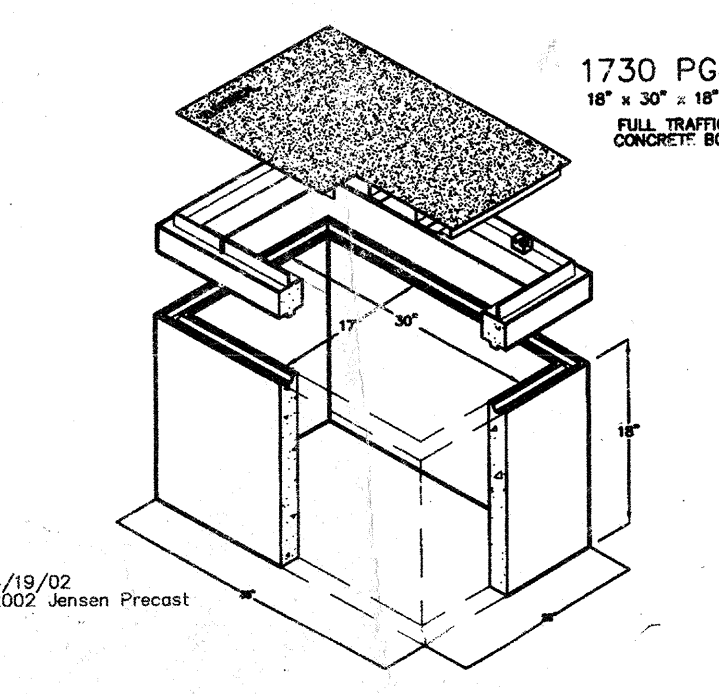

**7 17'x30' SUBSURFACE VAULT**  
N.T.S.

- LEGEND:**
- EXISTING TO BE REMOVED
  - (N) EXISTING REMAINS
  - (N) NEW CONSTRUCTION
  - TRANSFORMER
  - SWITCH AND FUSE
  - CIRCUIT BREAKER

**noll tam**  
architects and planners  
728 Heinz Avenue  
Berkeley, CA 94710  
510.848.8295  
fax 510.649.3008

**JEFF SULTAN, P.E.**  
ELECTRICAL ENGINEER  
2050 Chestnut St Ste 205  
Menlo Park, CA 94025  
(650) 854-7585  
jeff@msp-power.net

**IDENTIFICATION STAMP**  
DIVISION OF THE STATE ARCHITECT  
APPLICATION NUMBER: 01  
DATE: \_\_\_\_\_

**CSM NORTH GATEWAY**  
**LOAD CENTER & SITE WALL**  
1700 West Hillsdale Blvd  
San Mateo, CA 94402

**PERMIT SET**  
11/24/08

**SHEET TITLE**  
**ELECTRICAL 1 LINE DIAGRAM AND DETAILS**

NO.	DATE	DESCRIPTION
7/9/10		ADDENDUM #2

DATE: 04/06/2009  
DRAWN:  
CHECKED:  
SCALE:  
JOB NO.:  
SHEET NUMBER:  
**E1**