


Copyright 2005 Steinberg Architects. All Rights Reserved. These drawings and specifications are intended for the sole benefit of the client and may not be used, copied, reproduced, or otherwise transmitted in any form without the express written consent of Steinberg Architects.

P:\020804\020812_Site\020812_Rooms\02081201.dwg
 Plot Date: 03/15/07 10:28:01 AM
 Plotter: HP DesignJet 5000

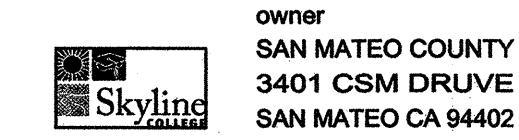

owner
 SAN MATEO COUNTY
 3401 CSM DRIVE
 SAN MATEO CA 94402

architect
 STEINBERG ARCHITECTS
 60 Pierce Avenue
 San Jose CA 95110




150 MONTGOMERY STREET, SUITE 715 415-403-3000
 SAN FRANCISCO, CALIFORNIA 94104 FAX: 415-778-8000
 SAN JOSE • SAN FRANCISCO • NEW YORK/NEW JERSEY
 LOS ANGELES • PALO ALTO • SINGAPORE • AUSTRALIA
 #Project 2002




SHEET NOTES


- 1 ALL FIXTURES ARE EXISTING, U.O.N. (N) FIXTURES TO MATCH EXISTING IN MODEL TYPE, LAMPING, MOUNTING, CIRCUITING, AND SWITCHING. EXTEND (E) CIRCUITING AND SWITCHING VIA OCCUPANCY SENSOR TO (N) FIXTURES SHOWN.
- 2 ALL FIXTURES ARE NEW. CONNECT TO (E) CIRCUIT IN THE AREA, CL1A-5.
- 3 WALL MOUNT (N) OCCUPANCY SENSOR BELOW CABLE TRAY, APPROXIMATELY 8"-3" AFF.
- 4 P1000 UNISTRUT FOR SUPPORT OF (N) LIGHTING FIXTURES. SUSPEND UNISTRUT FROM WAFFLE SLAB ABOVE. REFER TO STRUCTURAL AND ARCHITECTURAL DETAILS FOR MOUNTING REQUIREMENTS.

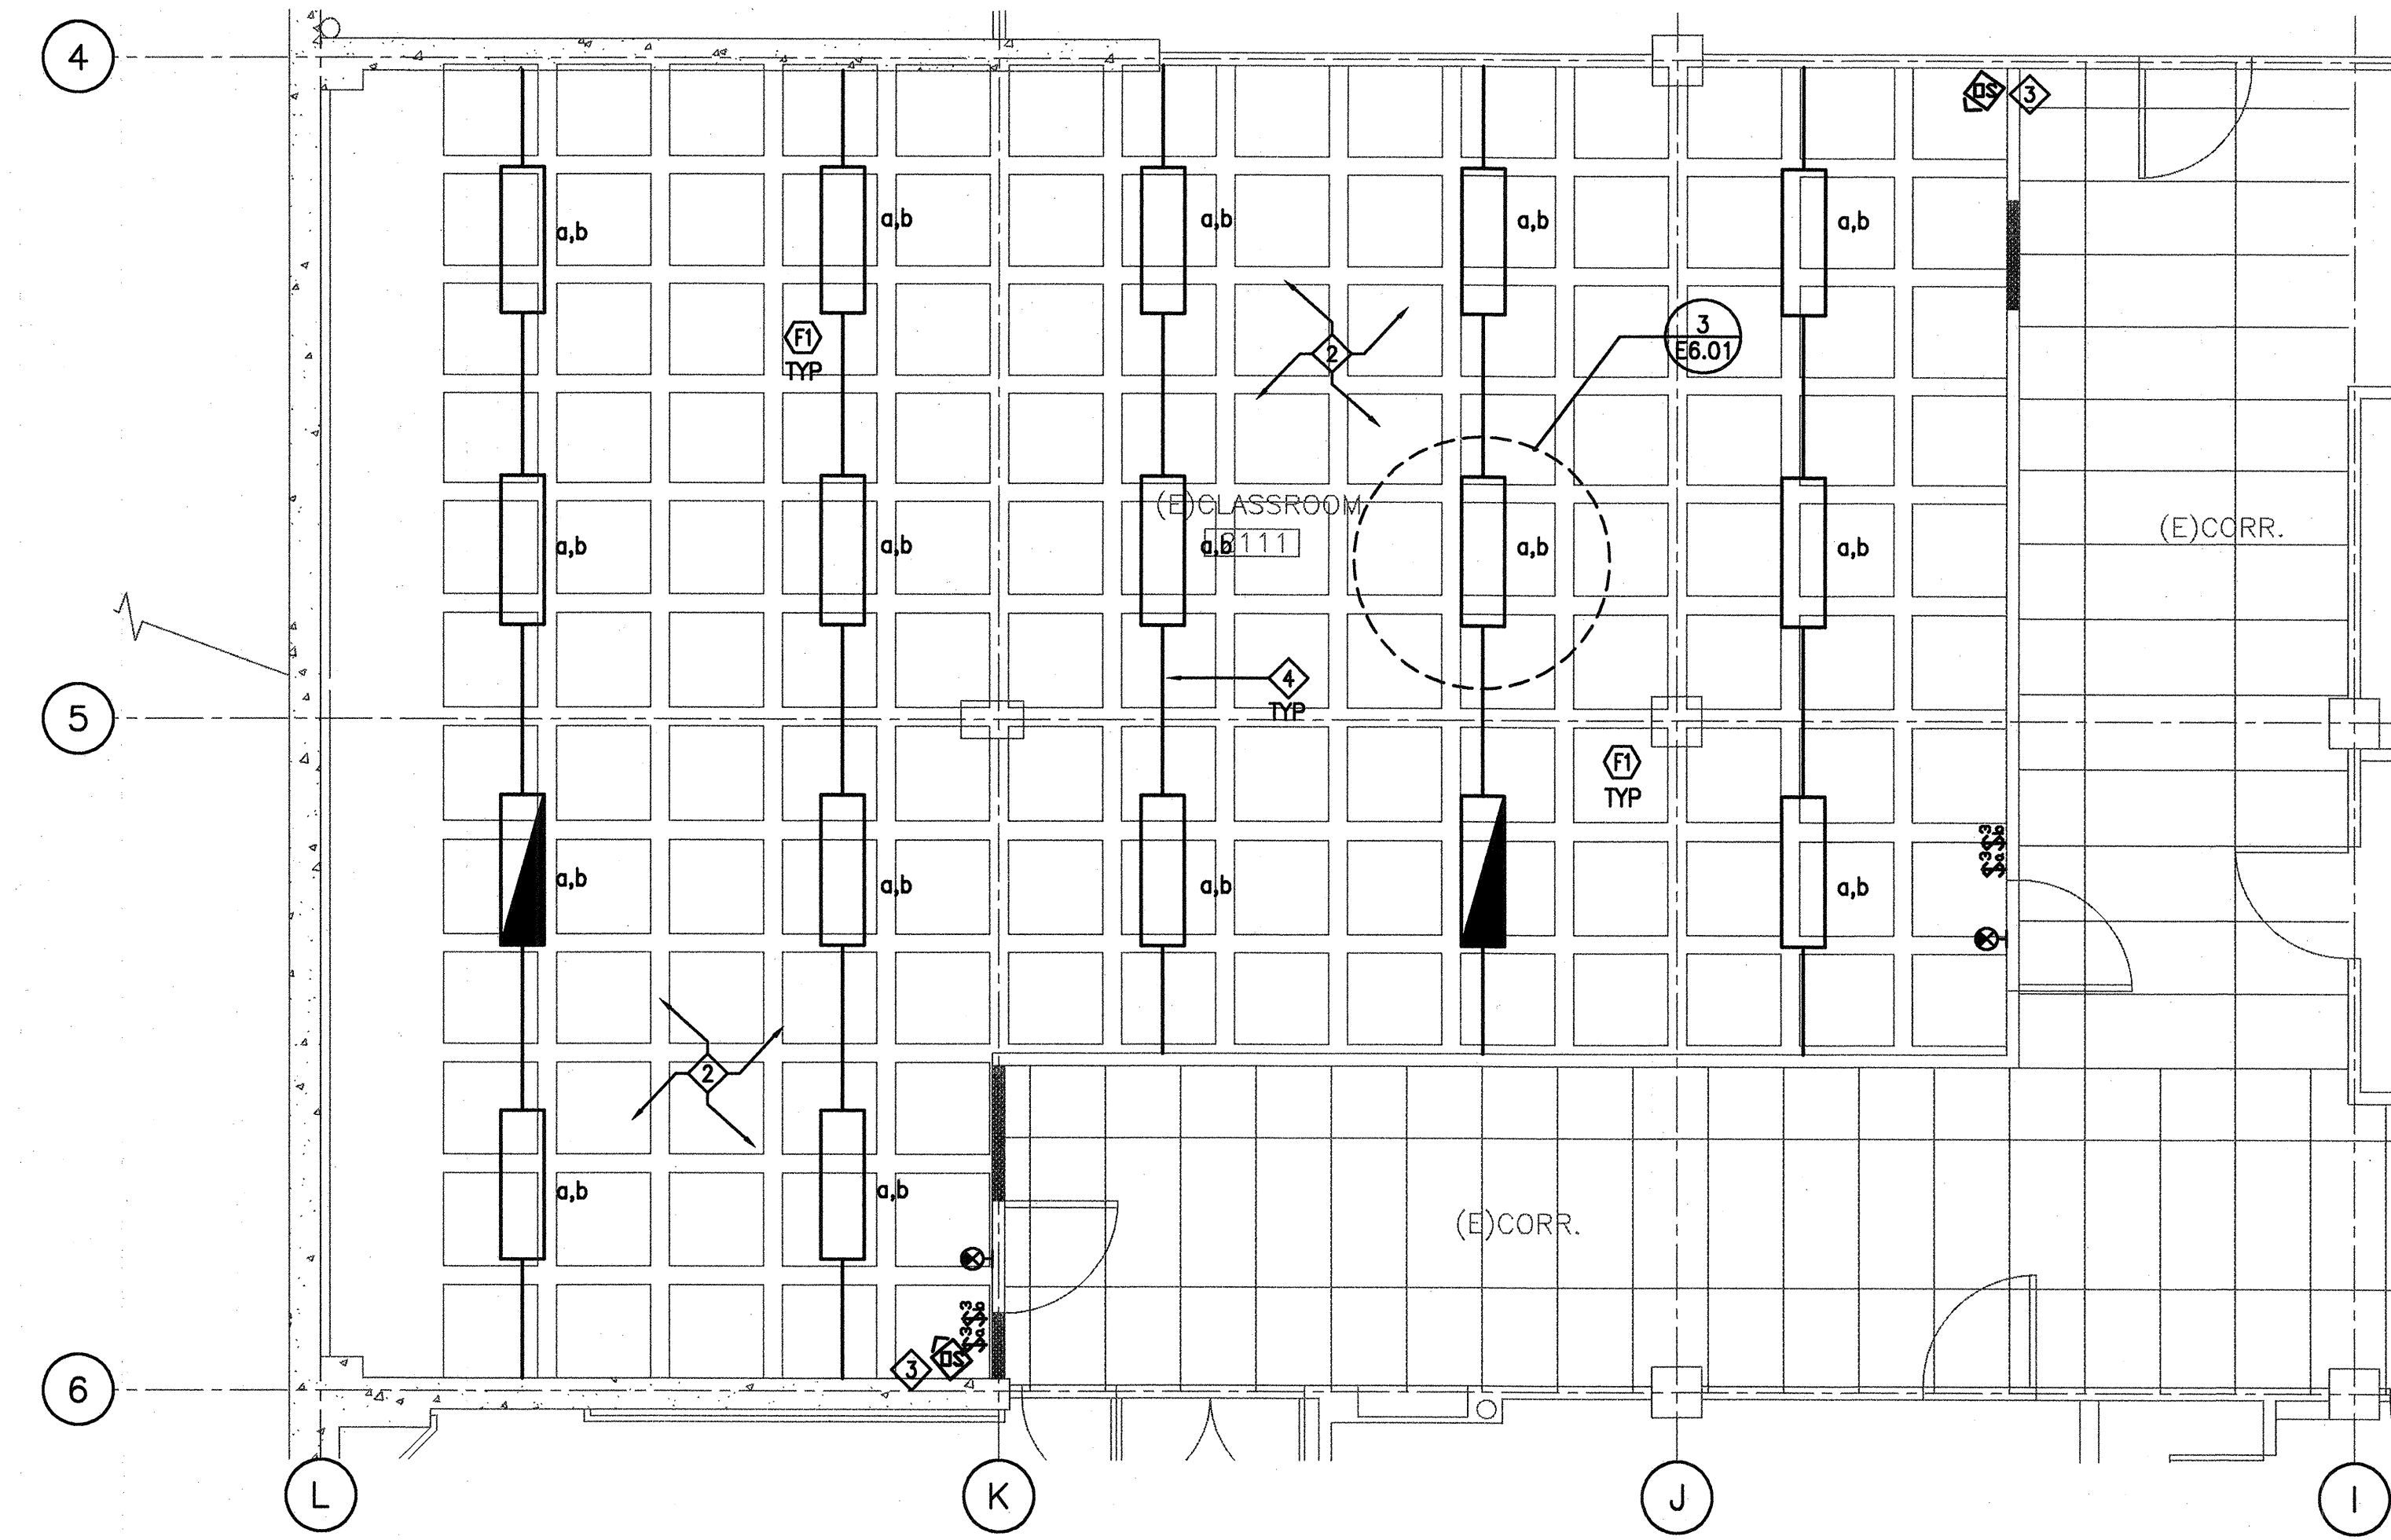


1 ROOM 2111 LIGHTING PLAN
 1/4" = 1'-0"

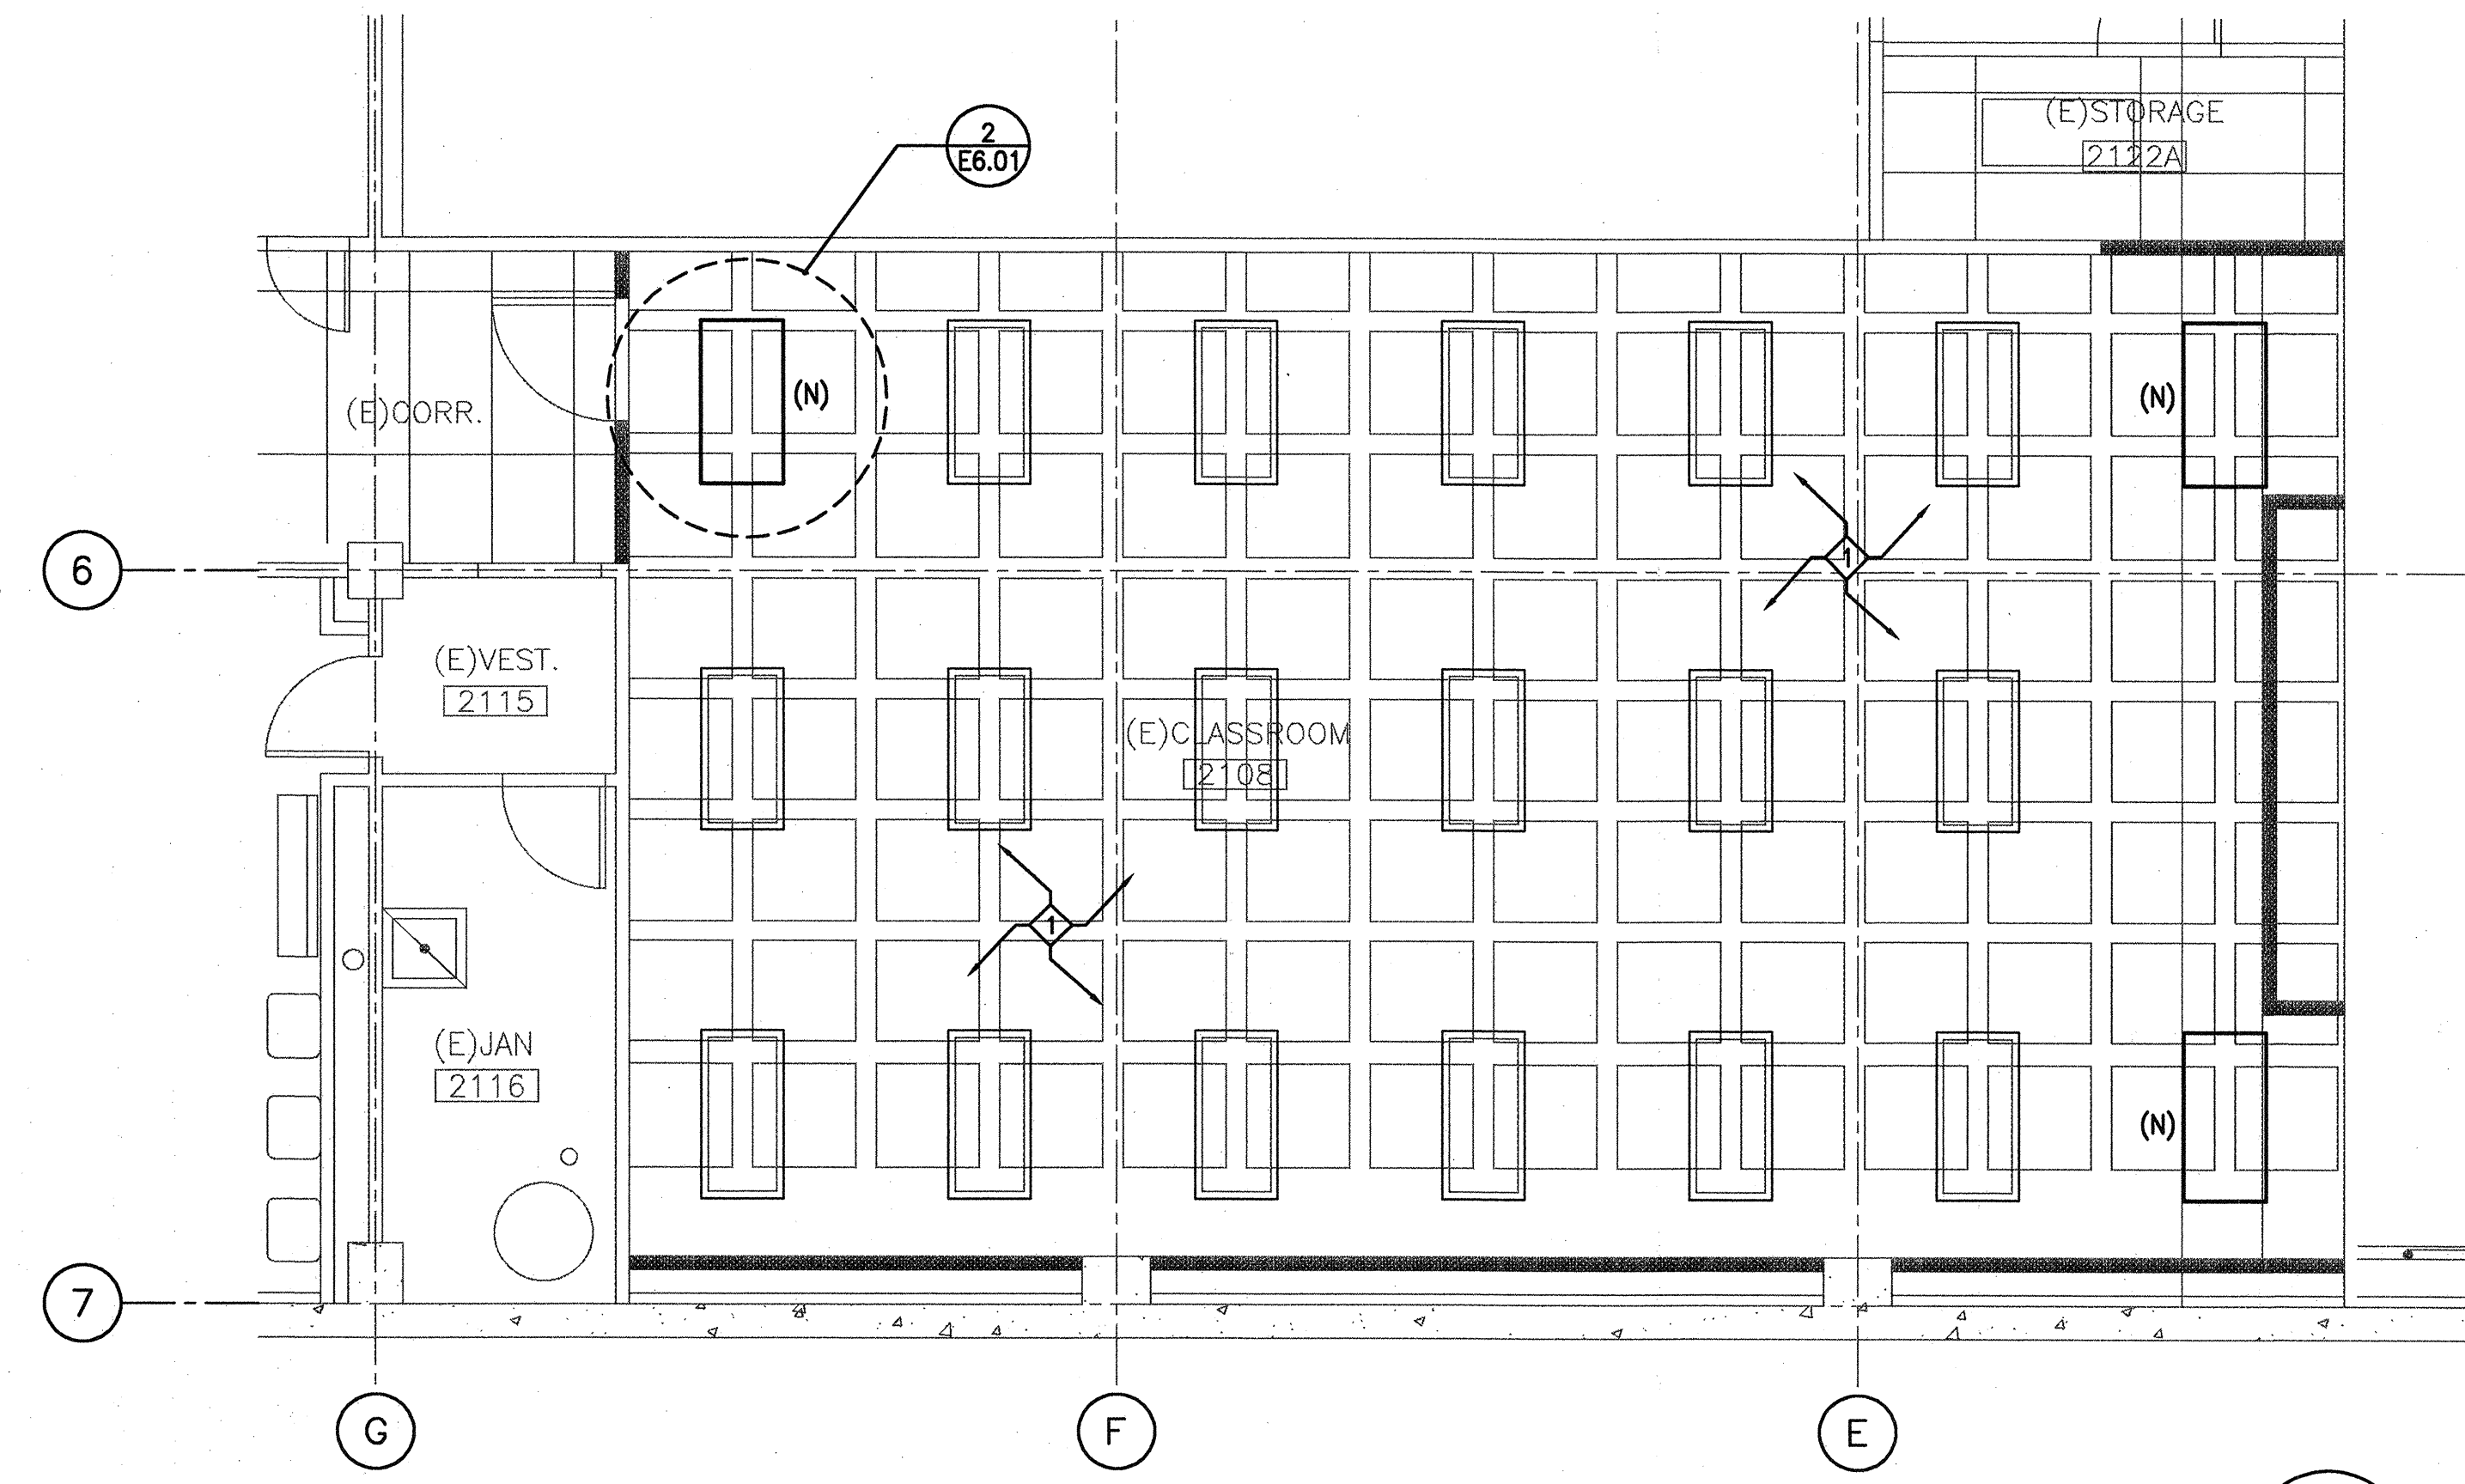

2 ROOF 2108 LIGHTING PLAN
 1/4" = 1'-0"

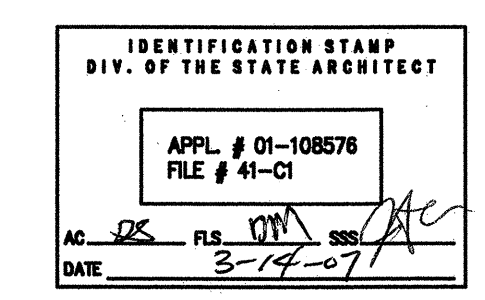

02.02.07	DSA SUBMITTAL	
	DSA BACKCHECK	
rev.	date	issue

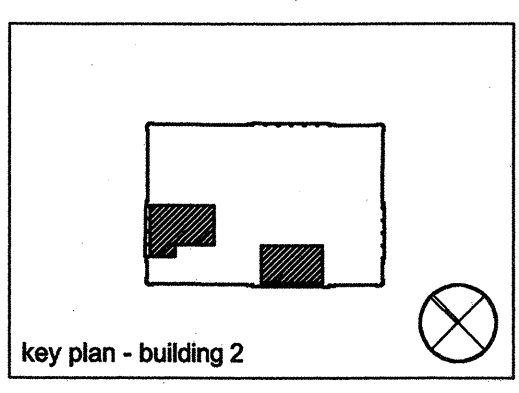

STEINBERG ARCHITECTS
 project no: 06044 date: 03/15/07
 drawn by: VB checked by: DL
 scale: 1/4"=1'-0"