



MATCHLINE SEE SHEET E6.04

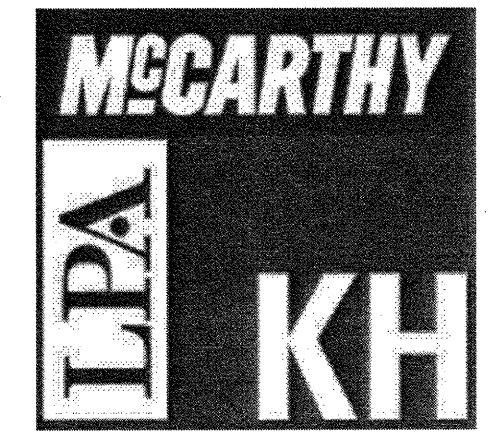

McCarthy Building Companies, Inc.
343 Sansome Street, 14th Floor
San Francisco, California 94104
P 415 | 364-1339
F 415 | 397-5999

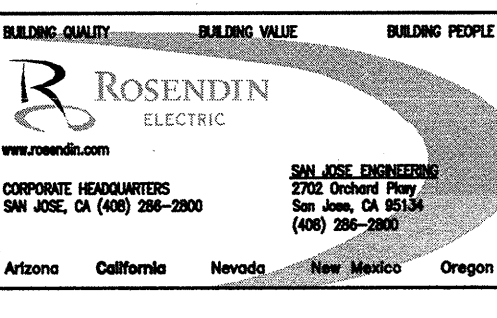

IDENTIFICATION STAMP
DIV. OF THE STATE ARCHITECT
OFFICE OF REGULATION SERVICE
APPL. # 01-110097
AC. A. FLS. DM. SS. D.H.
DATE: APR. 09 2009
FILE NUMBER:


The use of other project documents and all items, including but not limited to, drawings, specifications, and schedules, shall be subject to the provisions of the contract documents. The contractor shall be responsible for obtaining all necessary permits and licenses for the work. The contractor shall be responsible for obtaining all necessary permits and licenses for the work. The contractor shall be responsible for obtaining all necessary permits and licenses for the work.

College of San Mateo
Site Package
San Mateo, CA
Developed for
San Mateo County Community College District

Revision	Description	Date

Revision	Description	Date

Job No.	27082.30
Date	02 APRIL 2009
Drawn by	RE CAD TEAM
Checked by	THS/RW
Scale	AS SHOWN
ELECTRICAL SITE PLAN	
E6.03	

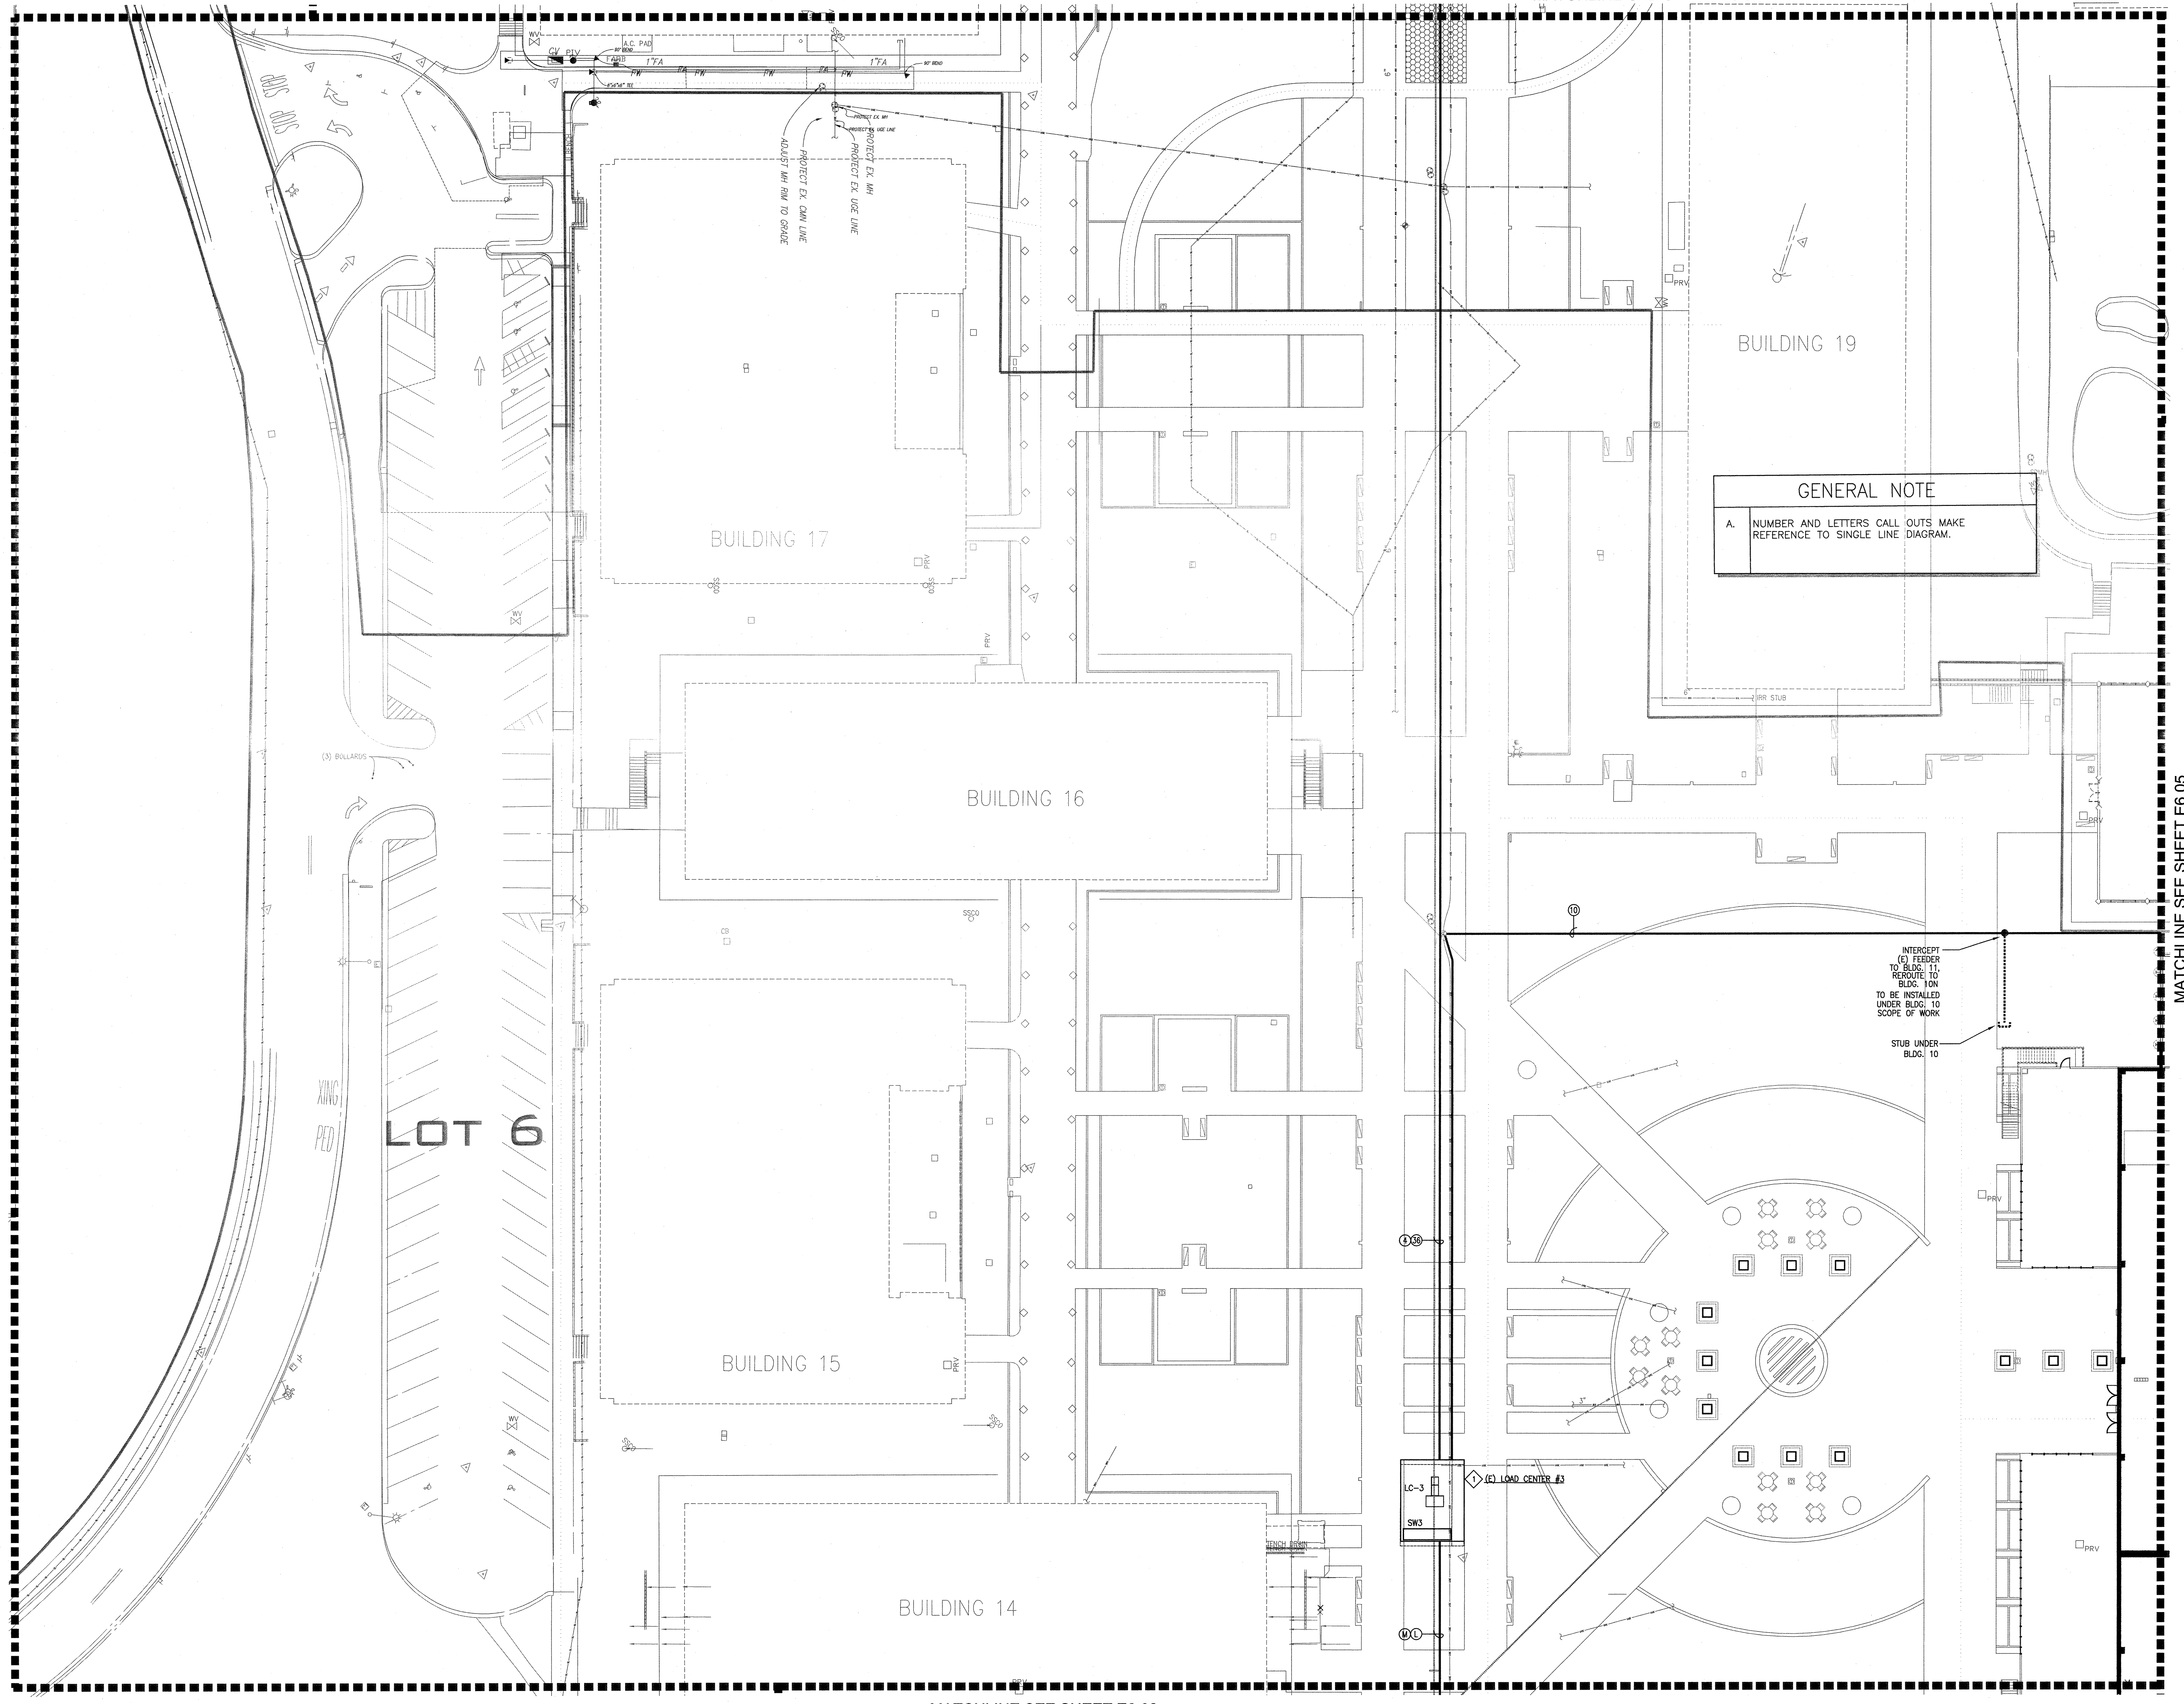

GENERAL NOTE
A. NUMBER AND LETTERS CALL OUTS MAKE REFERENCE TO SINGLE LINE DIAGRAM.

INTERCEPT (E) FEEDER TO BLDG. 11, REROUTE TO BLDG. 10N TO BE INSTALLED UNDER BLDG. 10 SCOPE OF WORK
STUB UNDER BLDG. 10

LC-3 SW3 (E) LOAD CENTER #3

MATCHLINE SEE SHEET L2.4

MATCHLINE SEE SHEET E6.02

MATCHLINE SEE SHEET E6.05

RIext (RIext)